

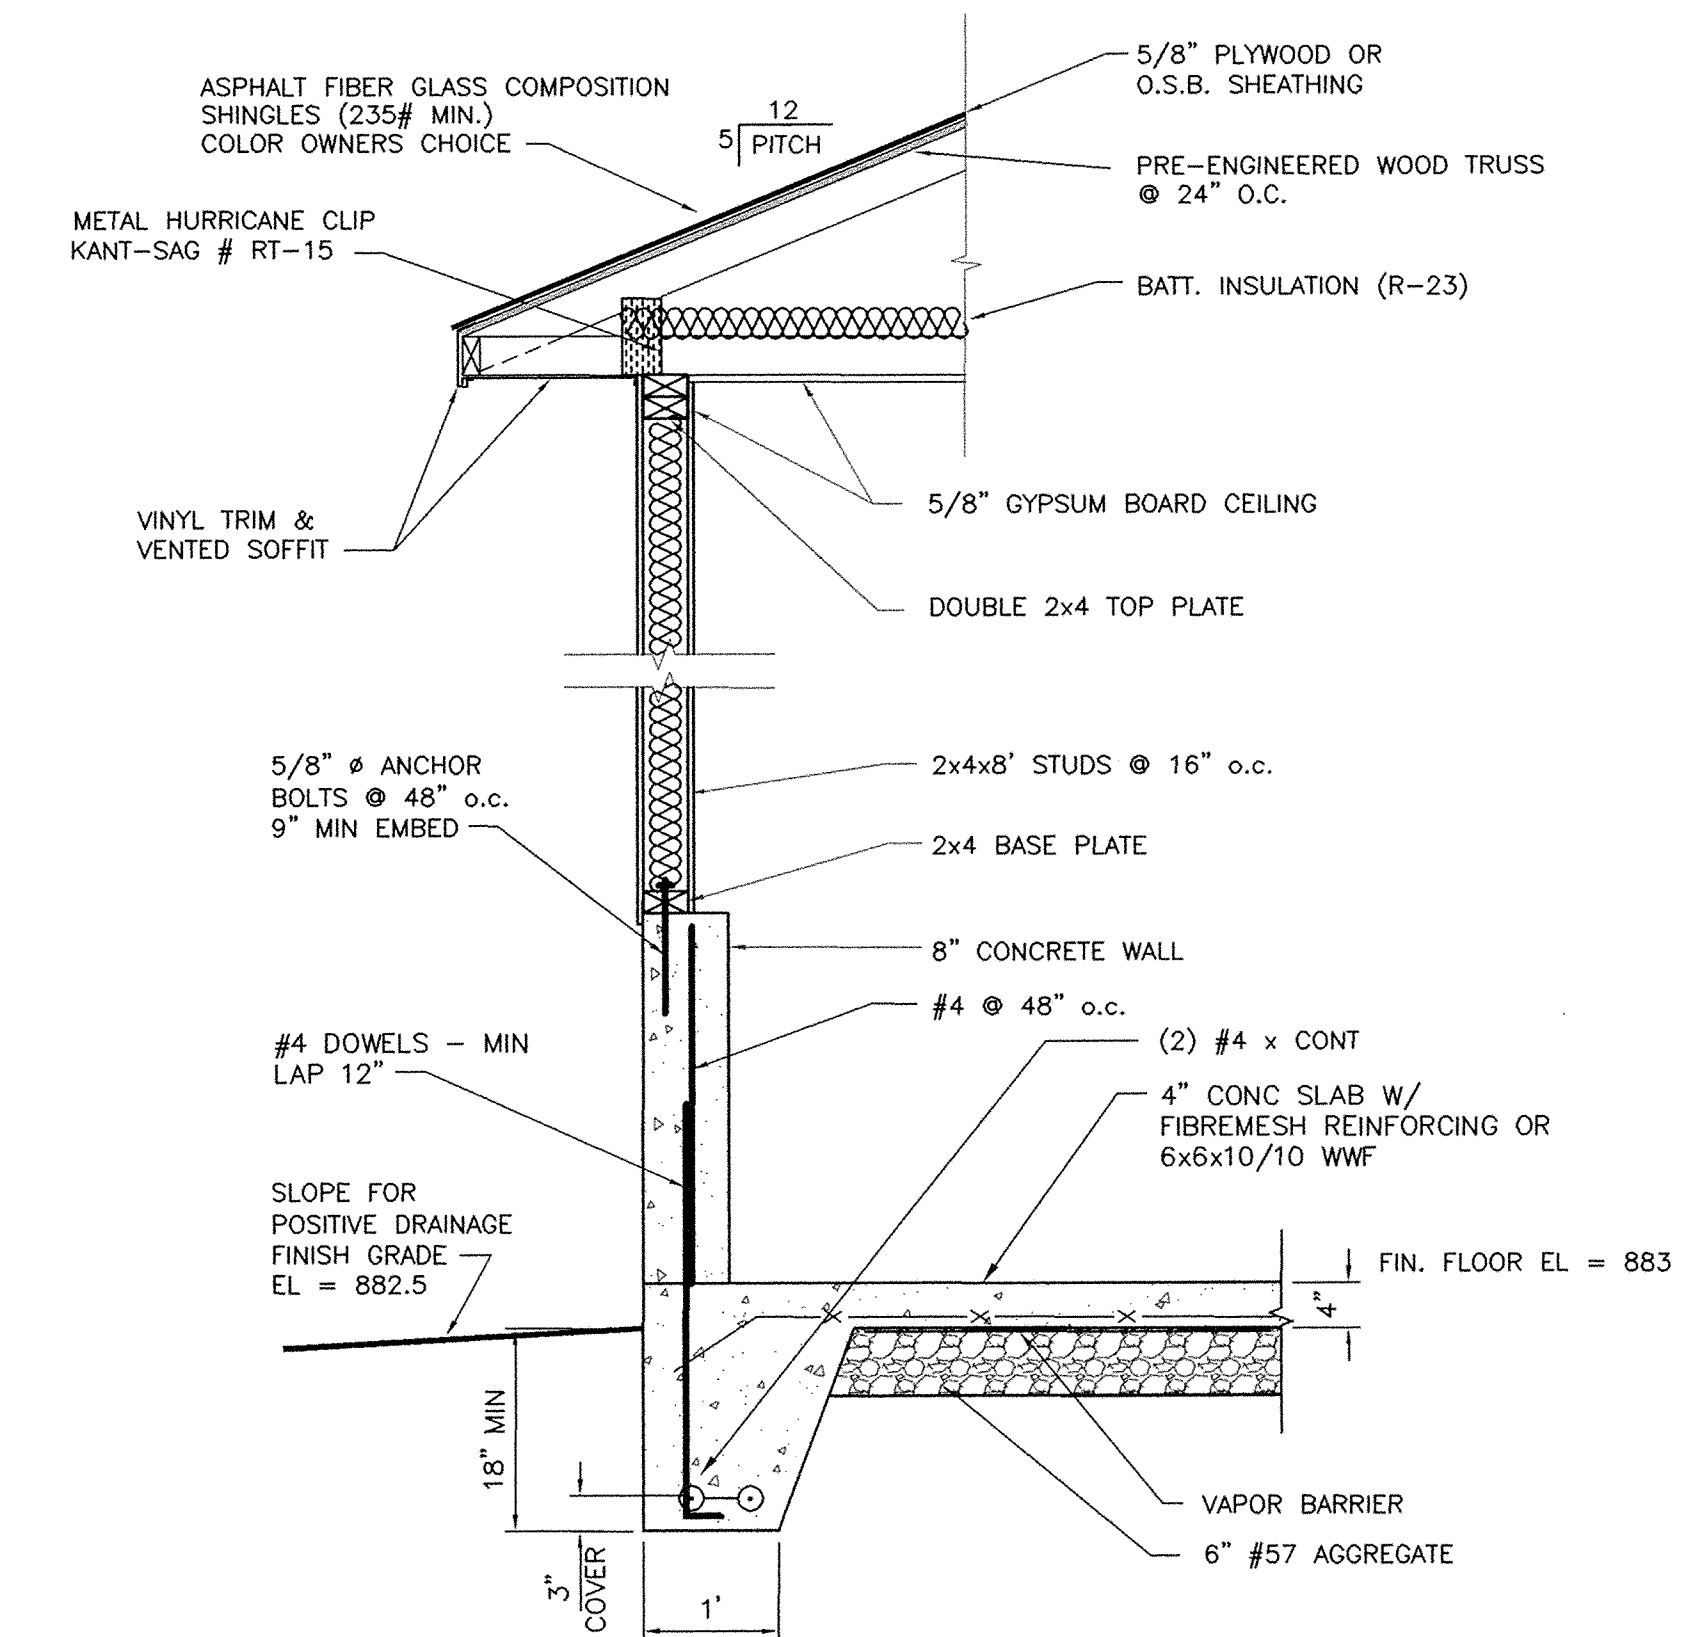


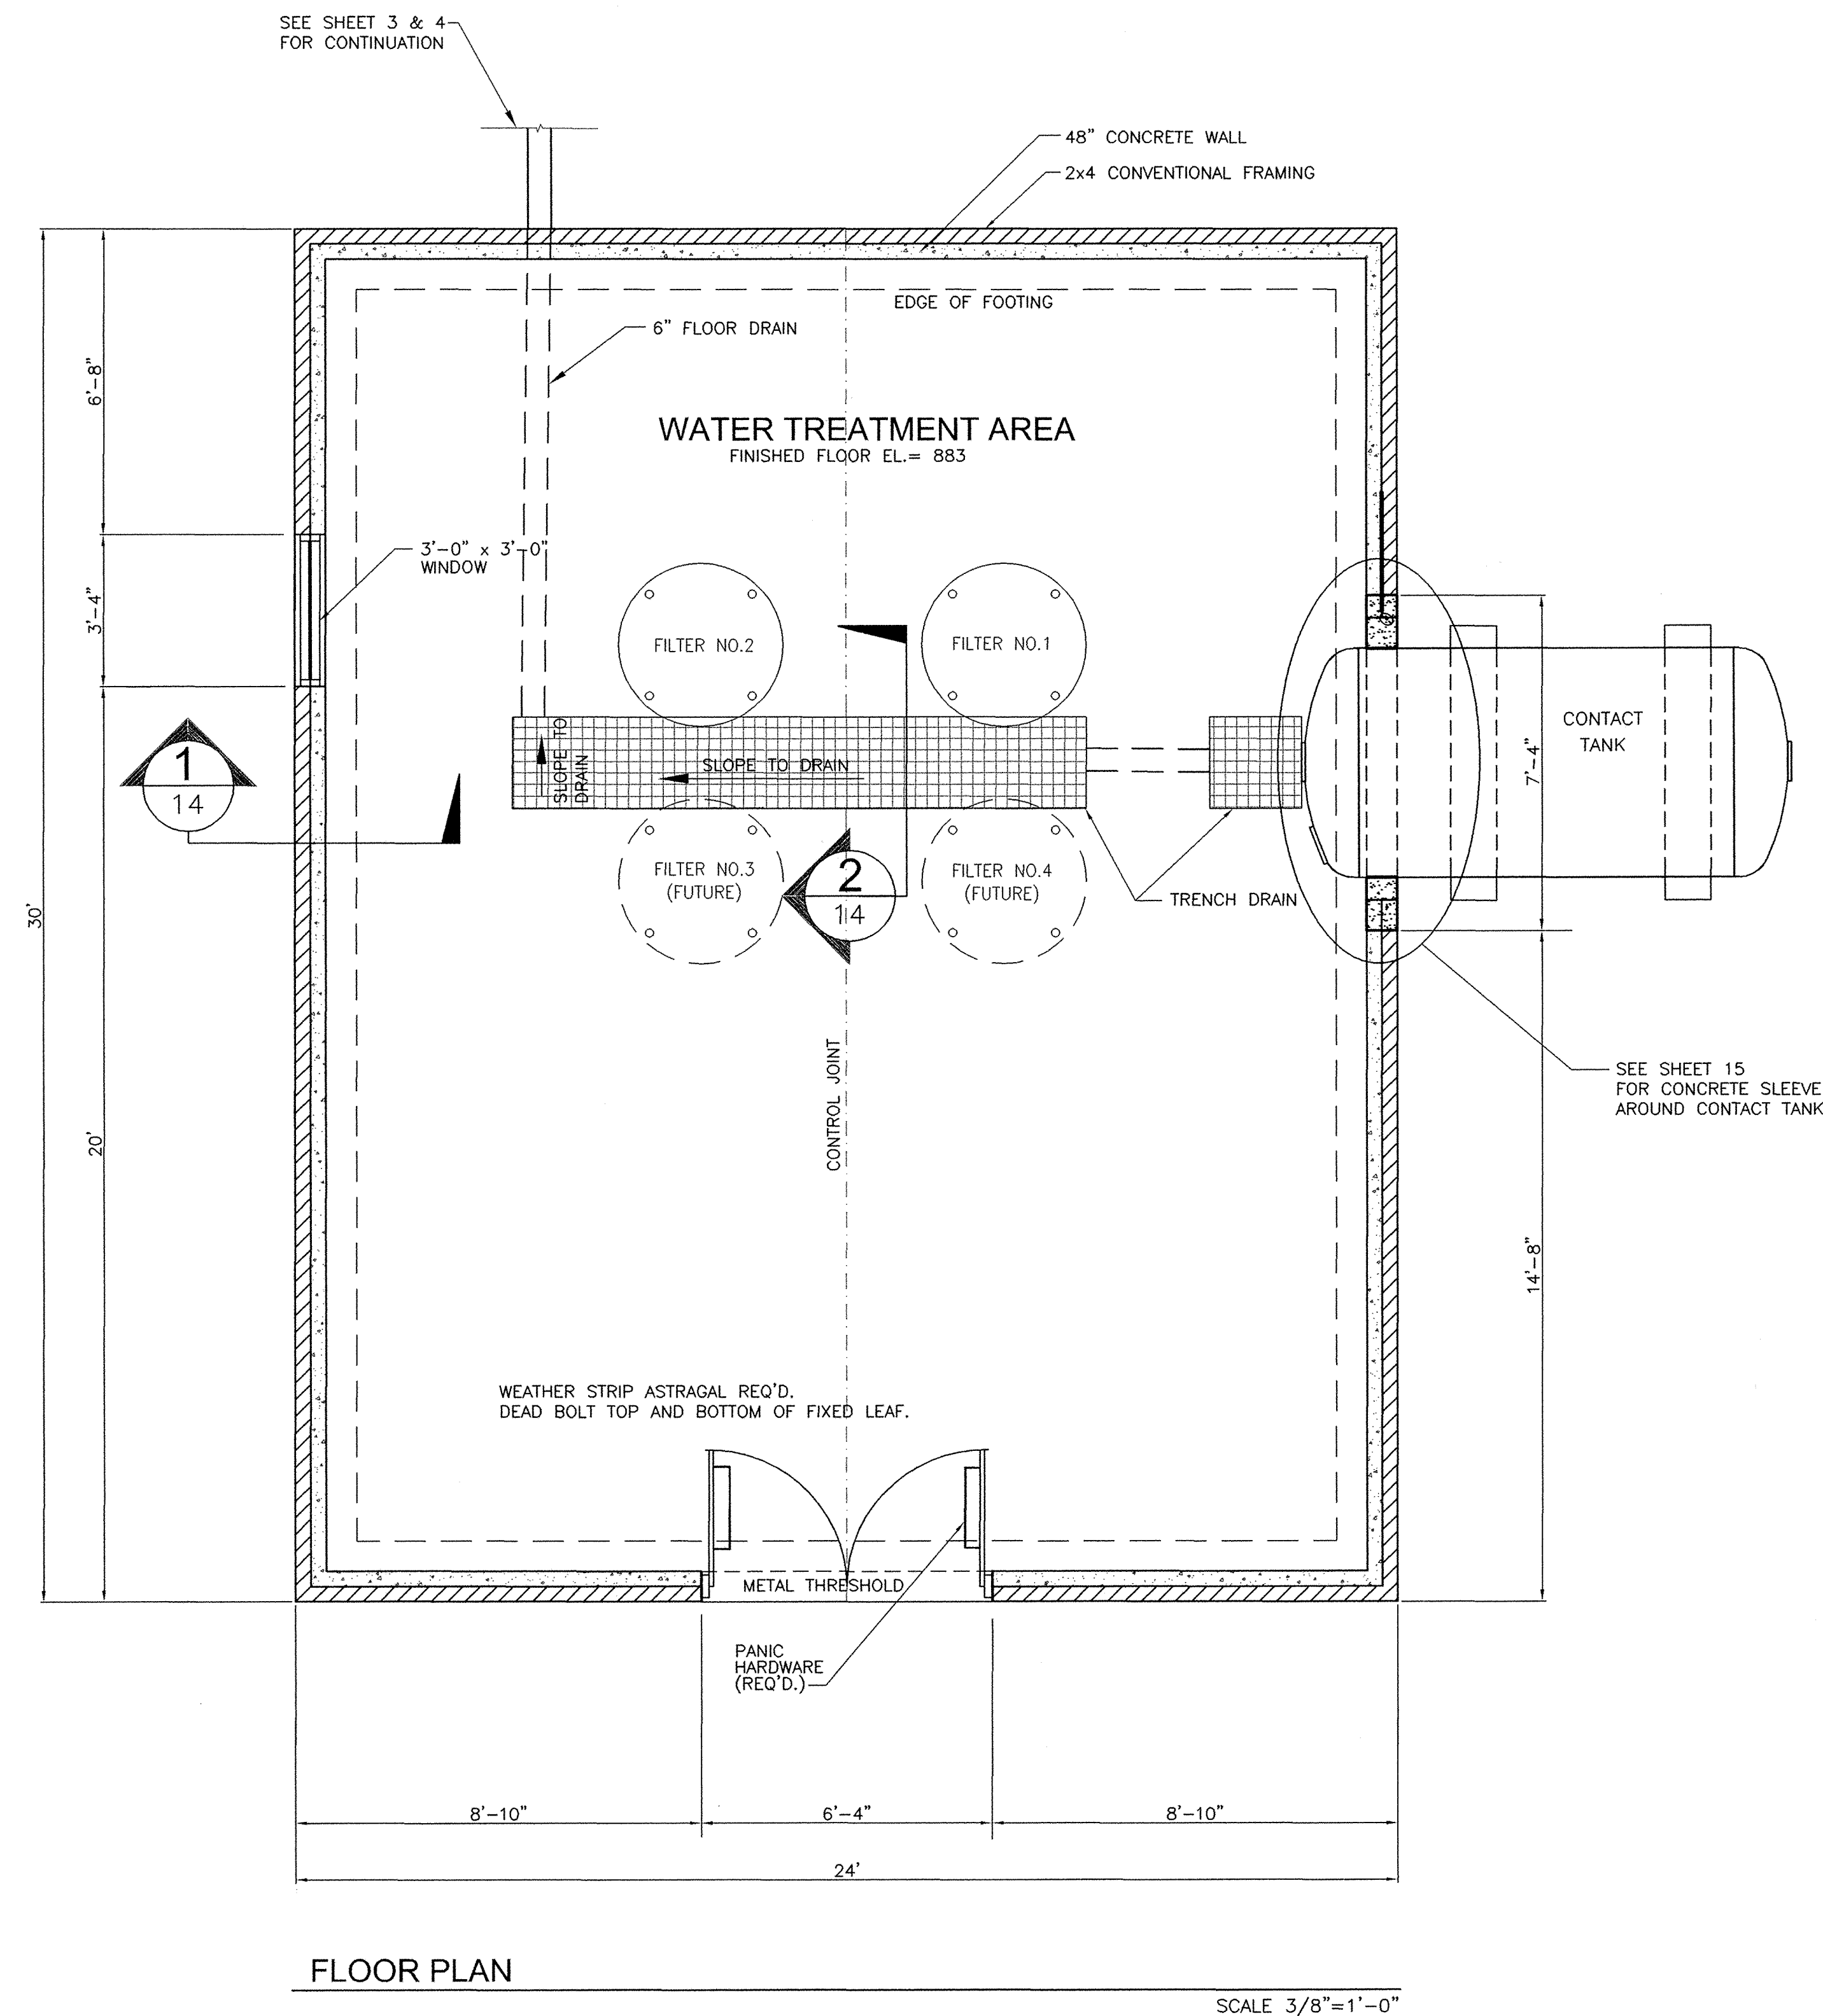


1 TYPICAL WALL SECTION

SCALE: 3/4" = 1'-0"

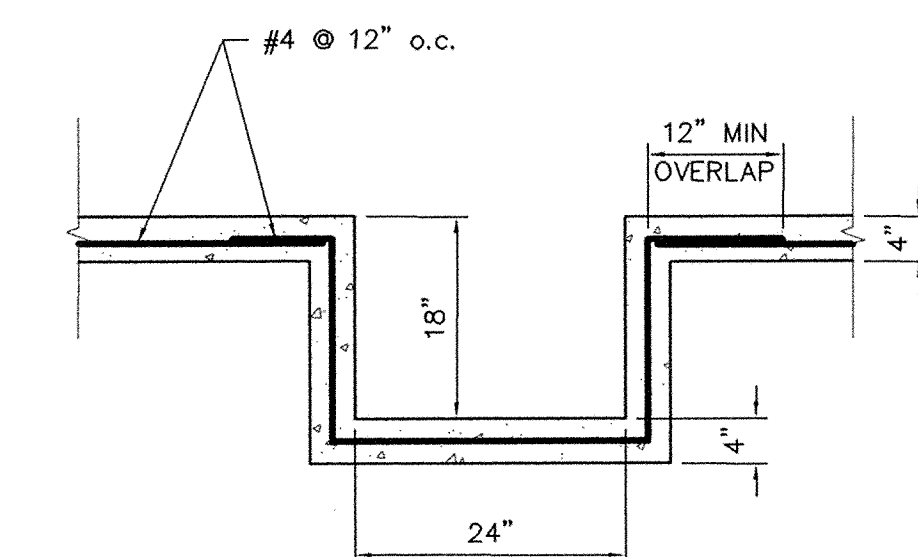

2 TRENCH DRAIN SECTION

SCALE: 3/4" = 1'-0"

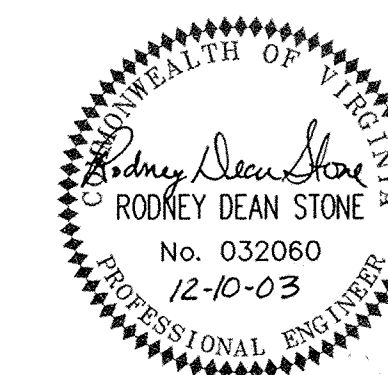

WATER TREATMENT PLANT
STRUCTURAL
COMPASS COVE
WATER DISTRIBUTION SYSTEM
DEVELOPED BY: WINDSTAR PROPERTIES, L.L.C.
GILLS CREEK MAGISTERIAL DISTRICT
FRANKLIN COUNTY, VIRGINIA
JULY 15, 2003
REVISED: DECEMBER 10, 2003
SHEET 14 OF 15