


SEE SHEET 11 FOR PUMP SCHEDULE

PUMP SCHEDULE

LOT	TDH	GOULDS PUMP MODEL
58	64.7	3885 WE1512H
57	67.2	3885 WE1512H
56	66.1	3885 WE1512H
55	66.1	3885 WE1512H
52	61.2	3885 WE1512H
51	61.2	3885 WE1512H
68	63.3	3885 WE1512H
70	63.3	3885 WE1512H
71	61.2	3885 WE1512H
72	61.2	3885 WE1512H
73	63.3	3885 WE1512H
74	63.3	3885 WE1512H
75	59.4	3885 WE1012H
76	59.4	3885 WE1012H
81	30.7	3885 WE0512H
80	30.7	3885 WE0512H
79	29.2	3885 WE0512H
78	29.9	3885 WE0512H
77	29.9	3885 WE0512H
1	32.0	3885 WE0512H
3	32.0	3885 WE0512H
4	30.3	3885 WE0512H
5	29.9	3885 WE0512H
6	29.9	3885 WE0512H


CONTRACTOR SHALL BE RESPONSIBLE FOR PROVIDING THE OWNER WITH TWO 3885, MODEL WE1512H, PUMPS FOR USE AS EMERGENCY SPARES

SIPHON	TOP ELEV.	INV. ELEV.
1	893.0±	888.0±
2	886.0±	881.0±

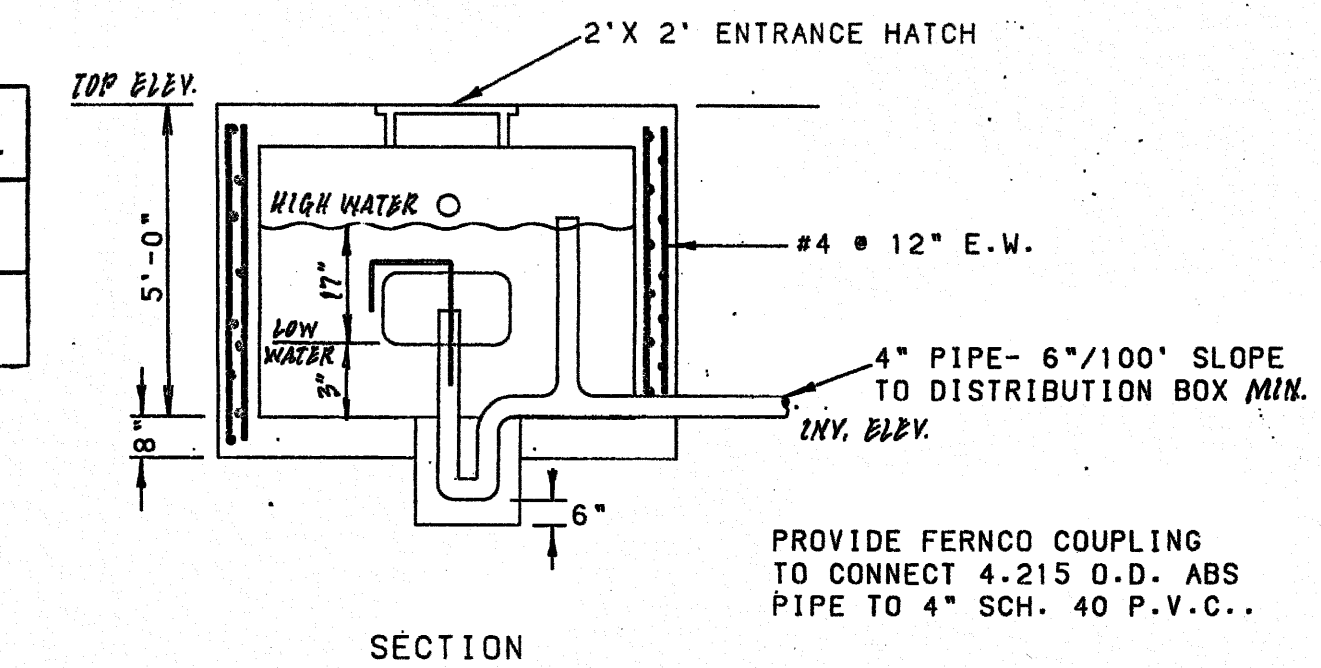

DOSING SIPHON VAULT
NO SCALE

NOTE: VAULT MUST PROVIDE 140 GALLONS DOSING VOLUME.

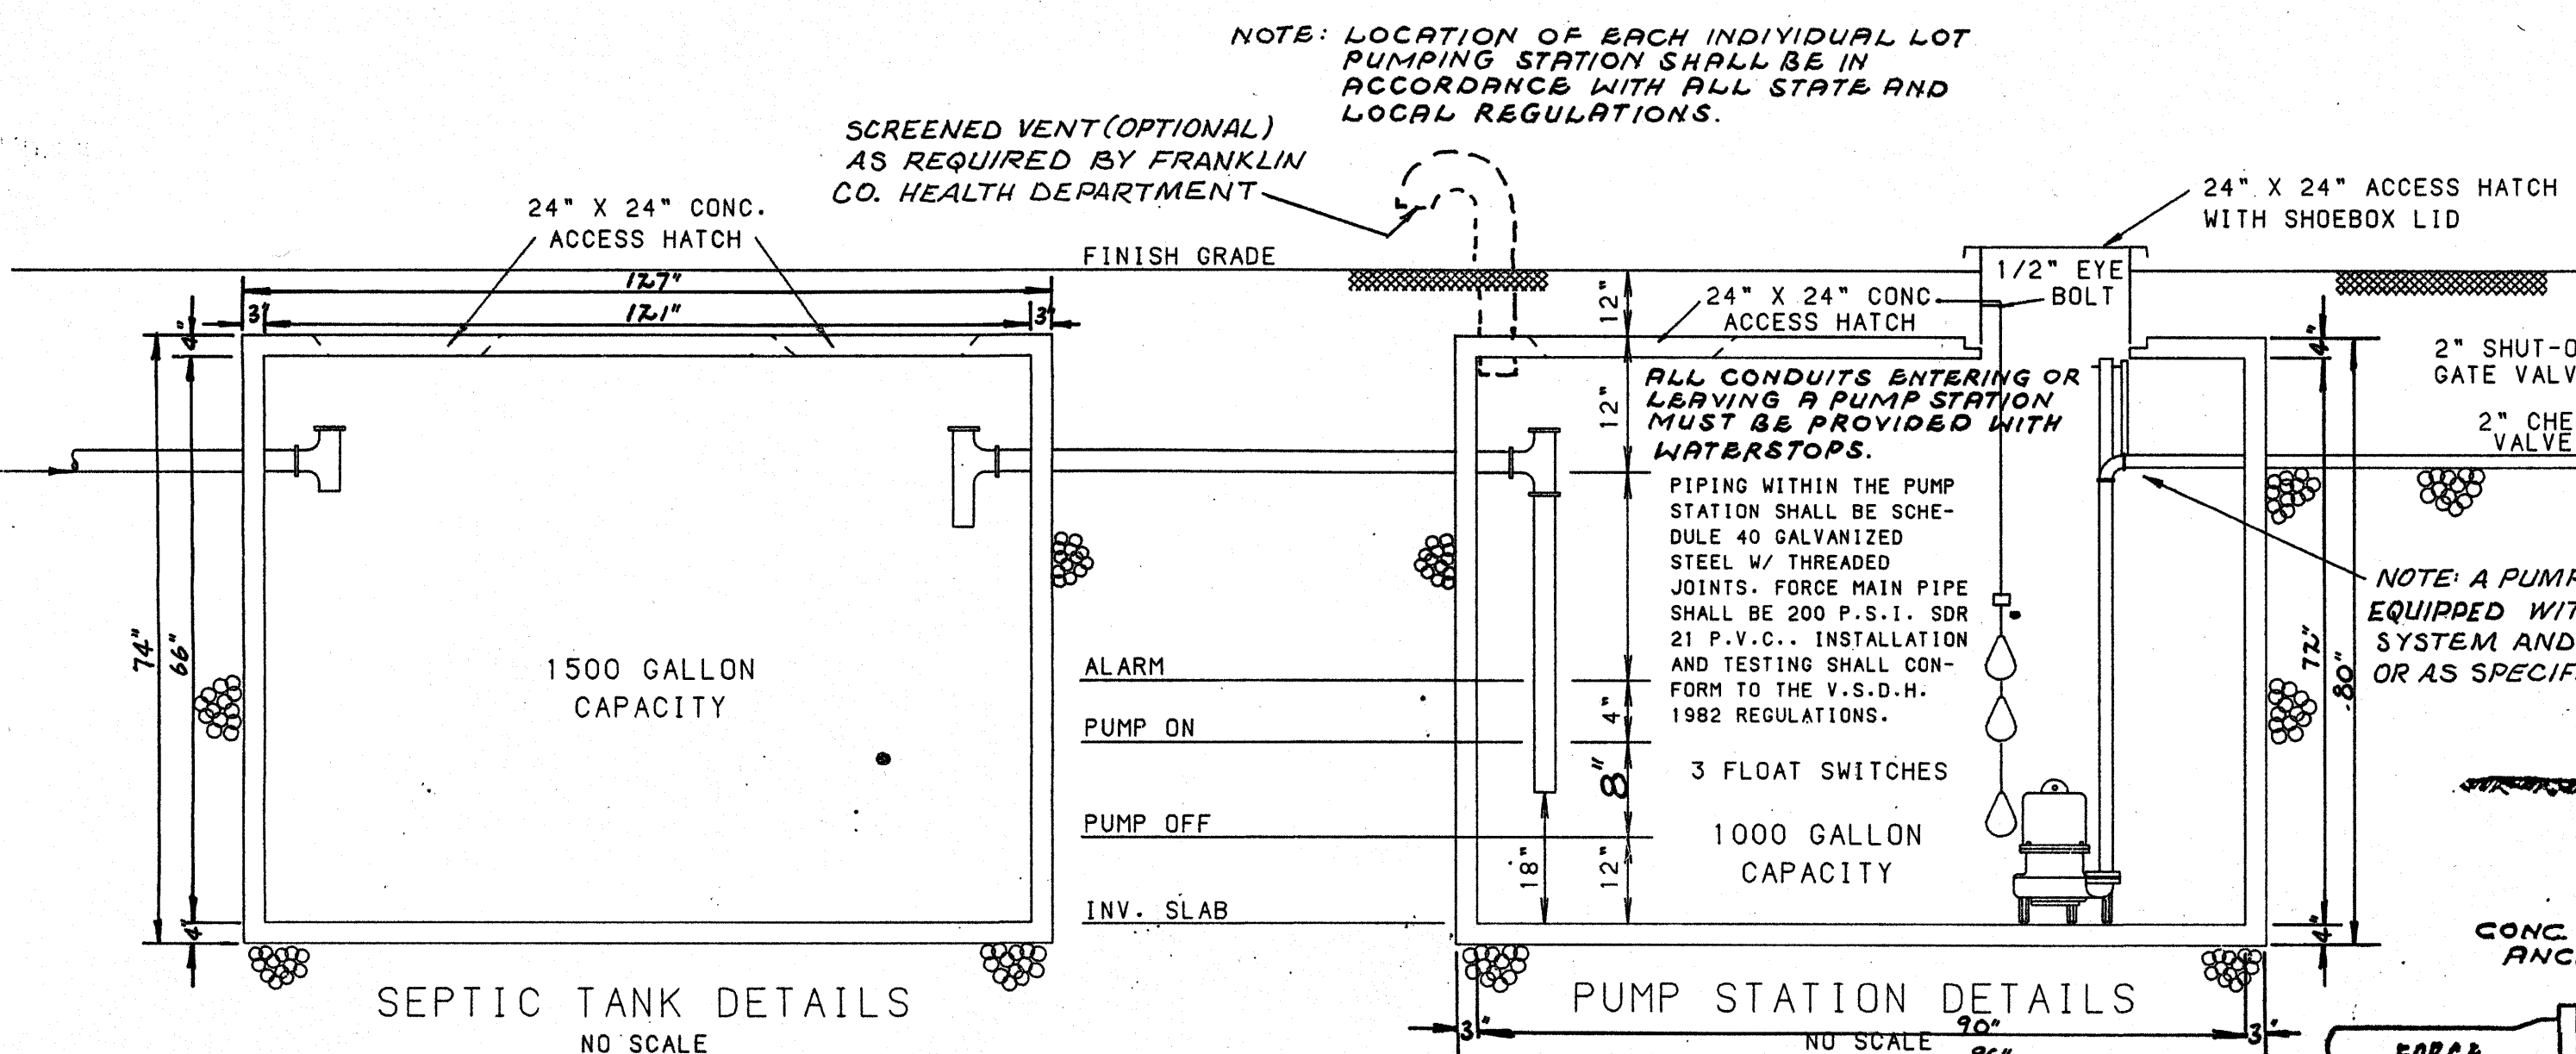


SEPTIC TANK DETAILS
NO SCALE


NOTE: 1500 GAL. TANK OVERALL WIDTH DIMENSION TO EQUAL 60"

PUMP STATION DETAILS
FOR INDIVIDUAL LOTS


NOTE: 1000 GAL. TANK OVERALL WIDTH DIMENSION TO EQUAL 48"
NOTE: CONCRETE TANKS MUST BE BEDDED WITH AT LEAST 6 INCHES OF SAND OR FINE GRAVEL WHERE ROCK OR OTHER UNDESIRABLE CONDITIONS ARE ENCOUNTERED.

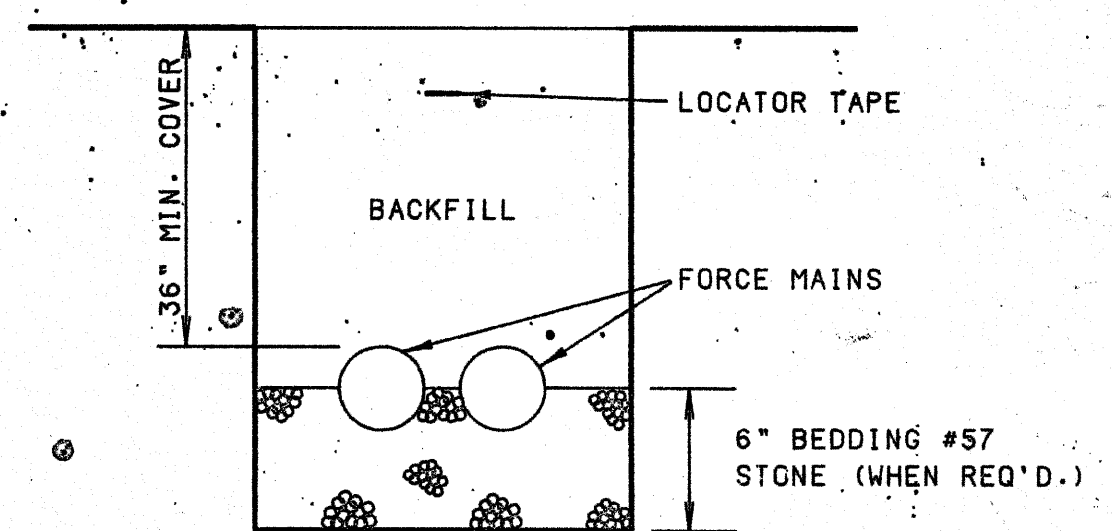


FORCE MAIN TRENCH DETAIL
NO SCALE

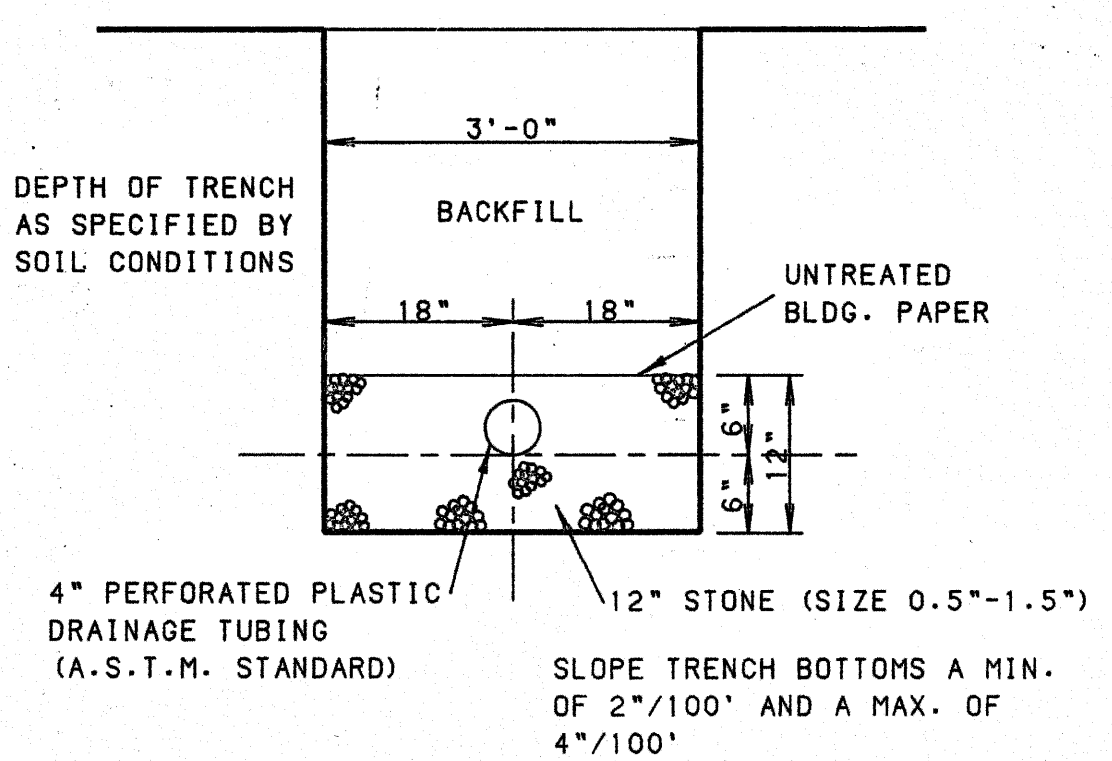


TYPICAL ABSORPTION TRENCH
NO SCALE

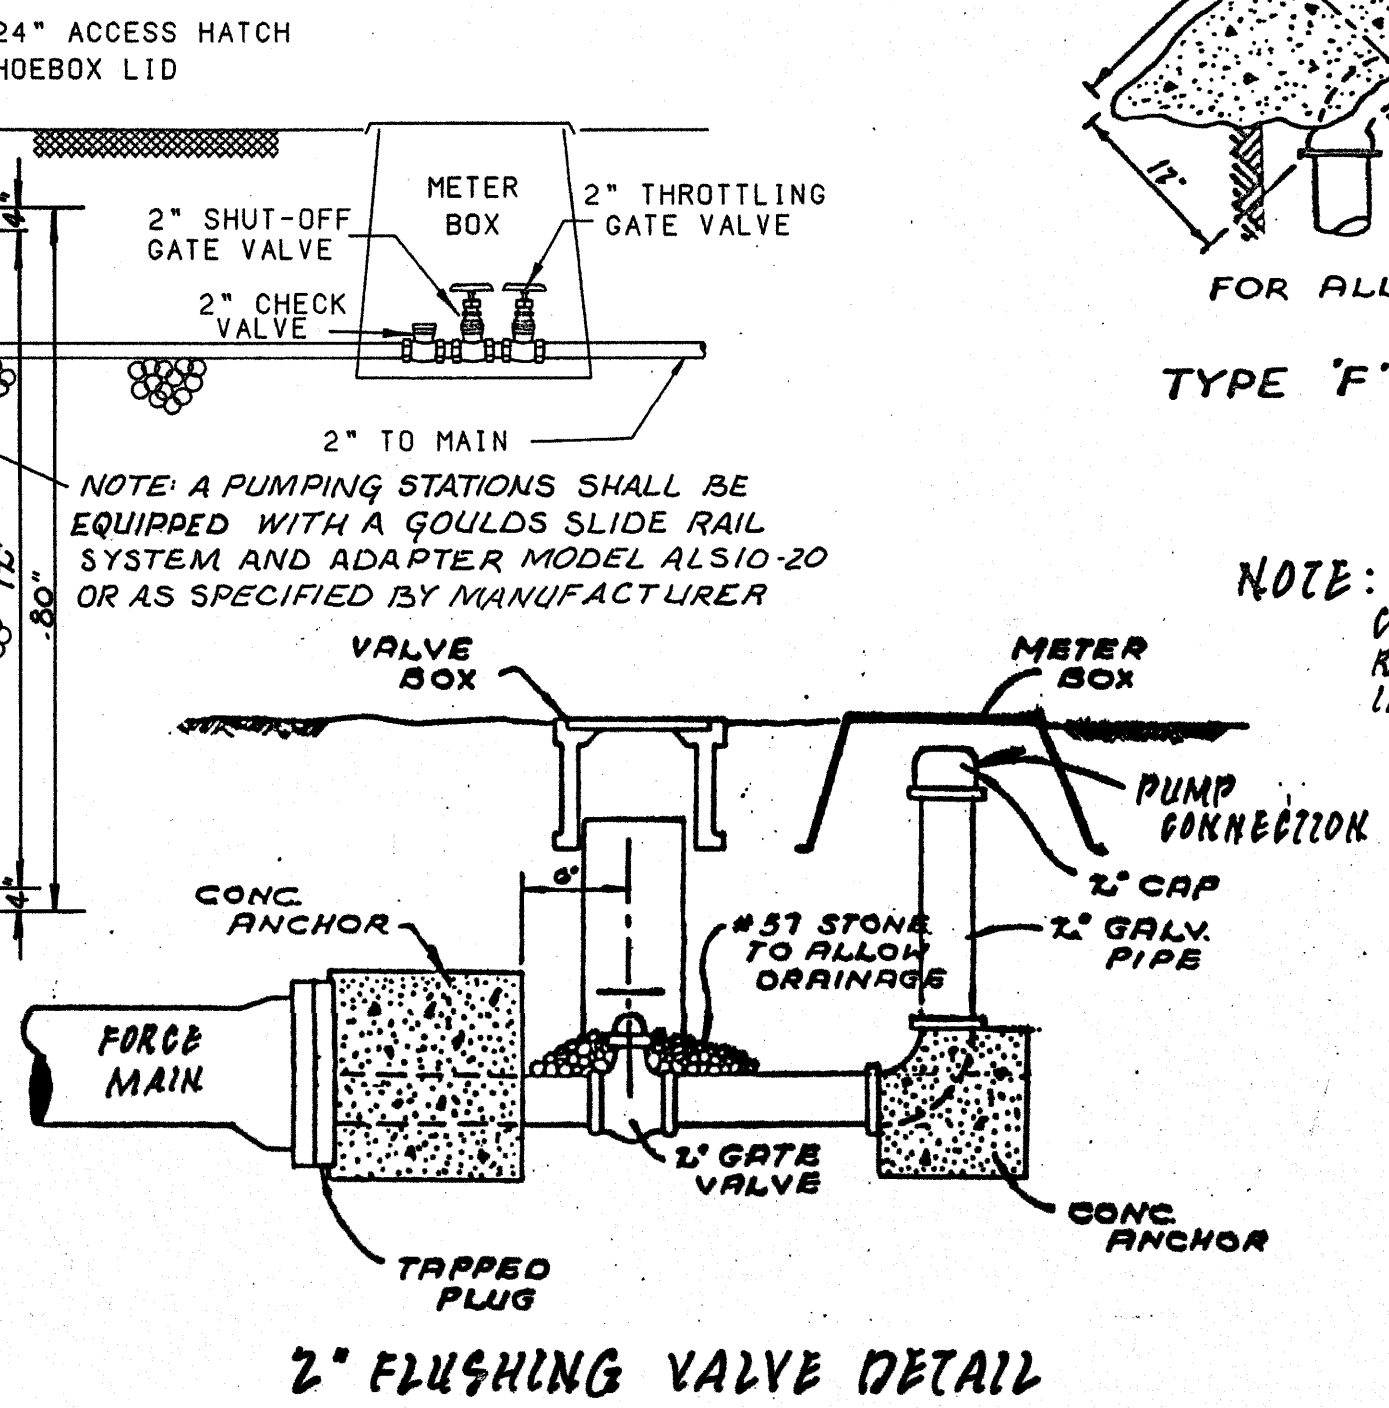


2" FLUSHING VALVE DETAIL

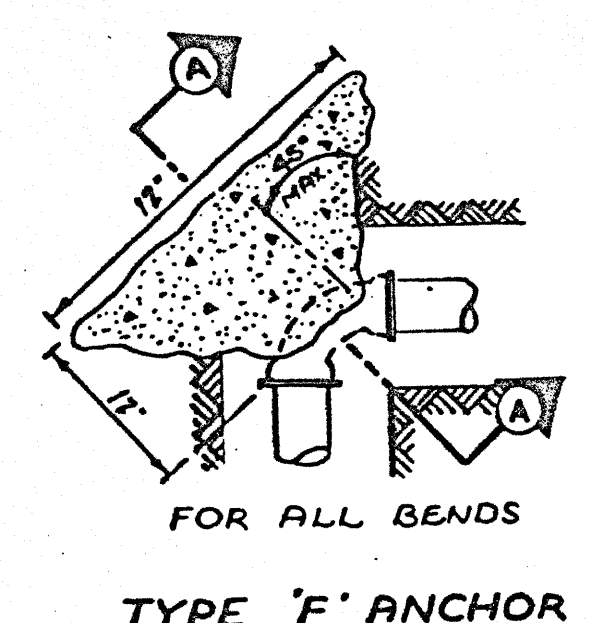

TYPE 'F' ANCHOR

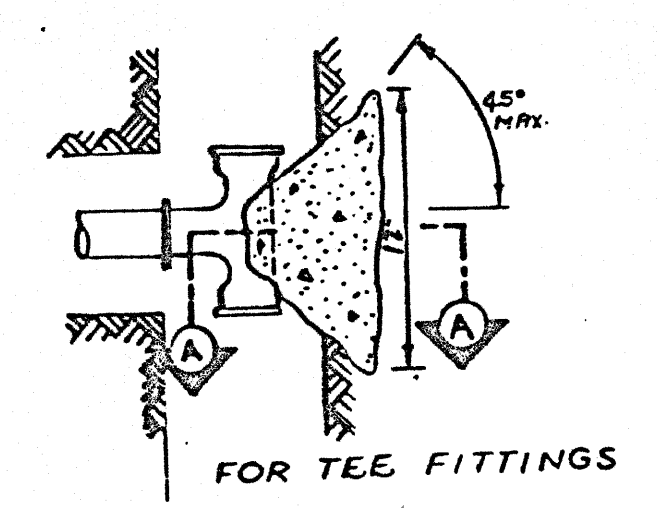


FOR TEE FITTINGS

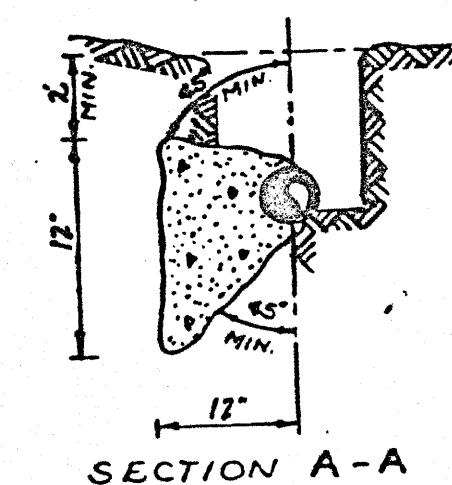


SECTION A-A


NOTE: CONCRETE ANCHORS REQUIRED AT ALL BENDS IN FORCE MAINS.

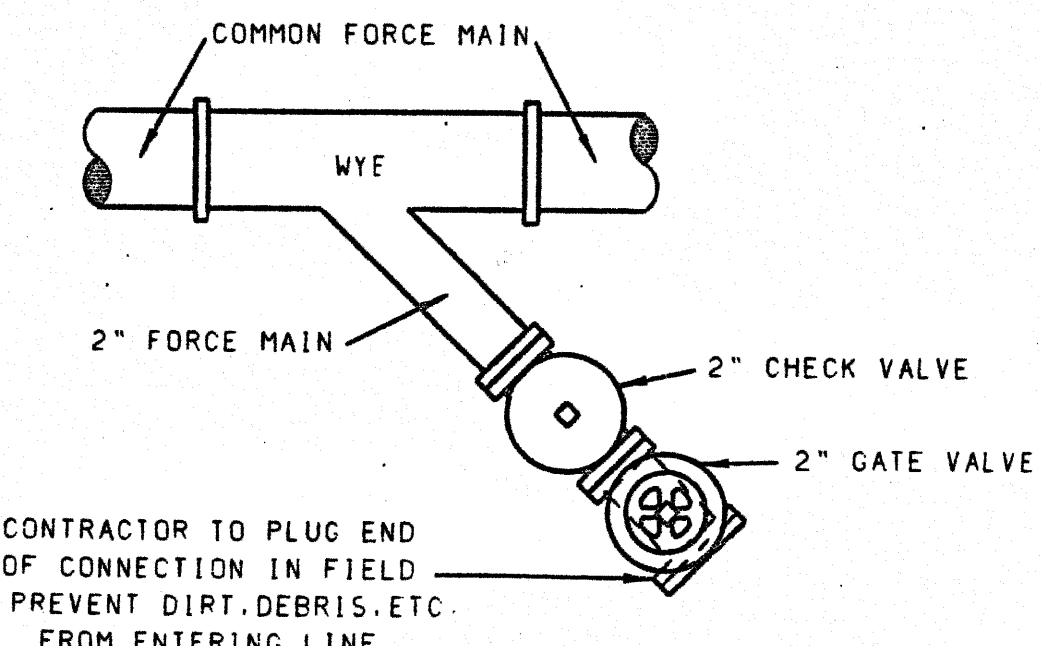

SAN. SEWER CONNECTION DETAIL
NO SCALE

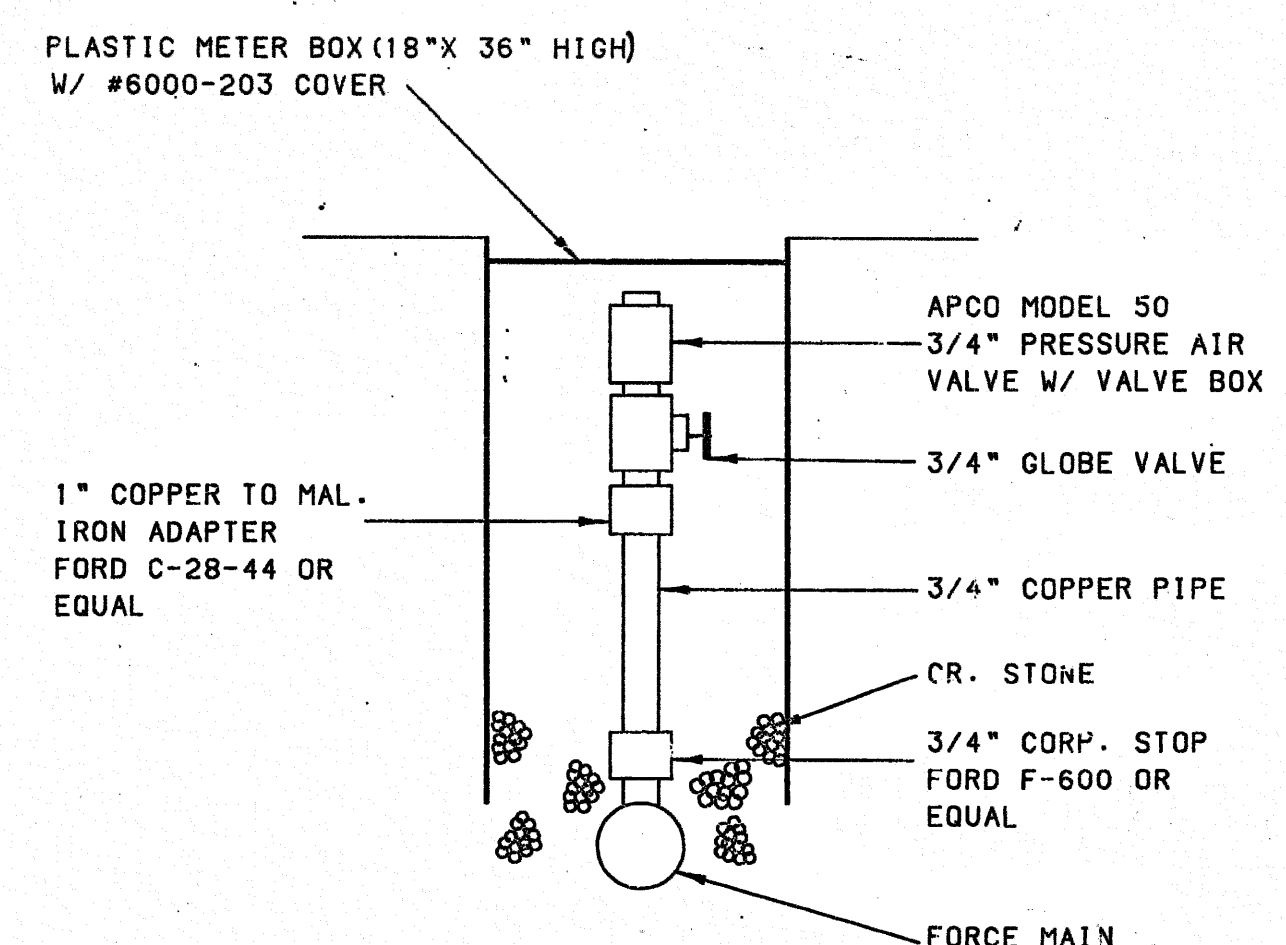

AIR RELEASE VALVE
NOTE: 3/4" SCH. 40 IN LIEU OF COPPER IS ACCEPTABLE

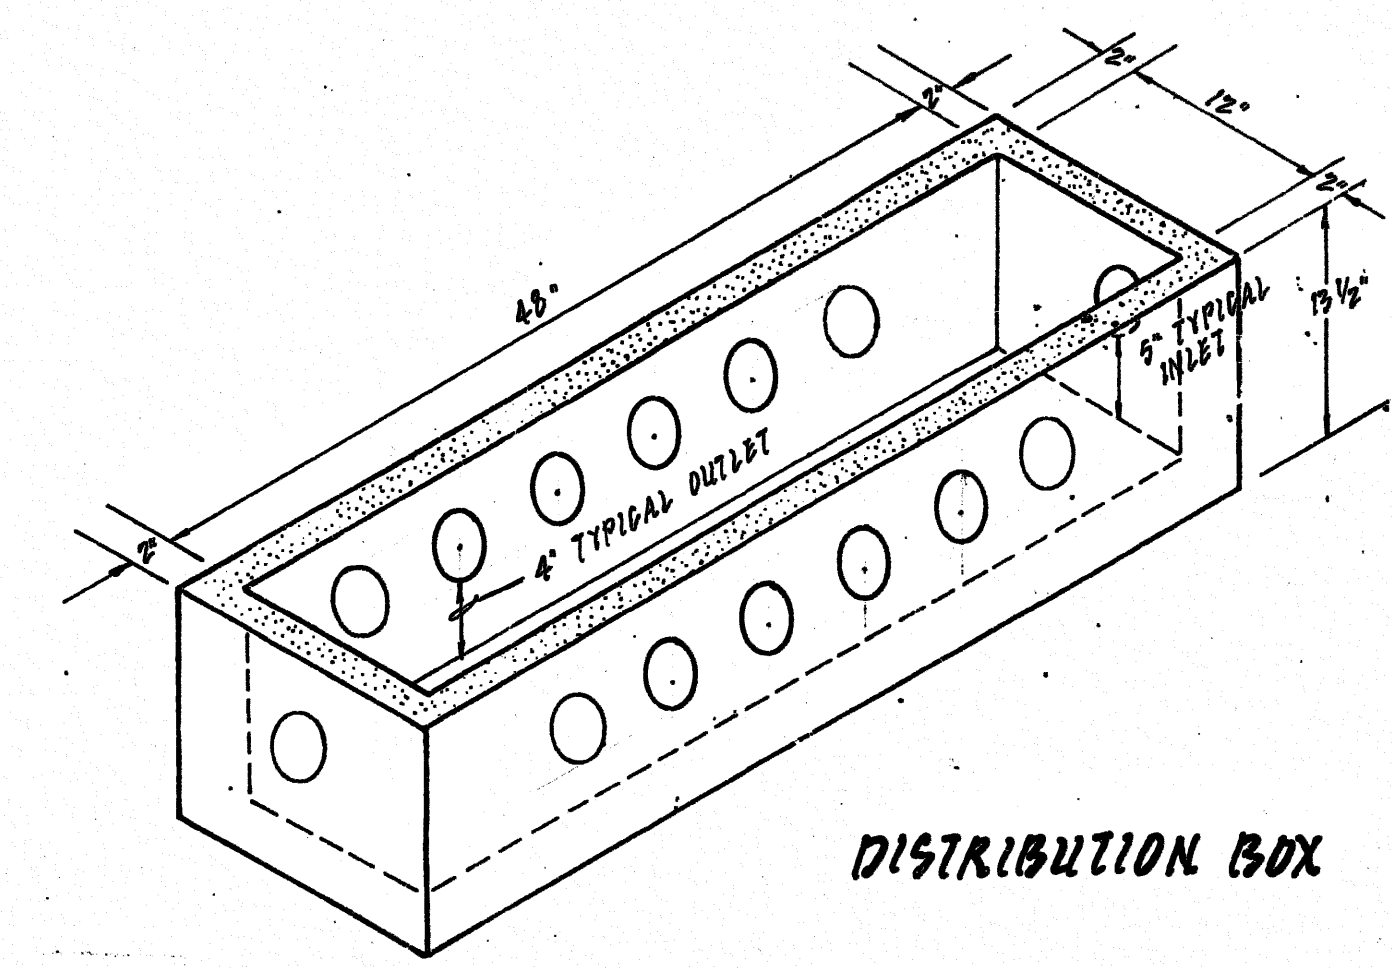

DISTRIBUTION BOX

BERKLEY HOWELL & ASSOC., P.C.
ENGINEERS • SURVEYORS • PLANNERS
LYNCHBURG, VA. SMITH MT. LAKE

MISC. DETAILS
CONTENTMENT ISLAND
SEWERAGE FACILITIES

DATE: 11/3/89
TECHNICIAN:
CHECKED BY:

REVISIONS

NO.	DATE

SCALES AS SHOWN

PROJ. NO. 89134S DIV.
SHEET NO. 11 OF 11
DRAWING NO.

89134S