




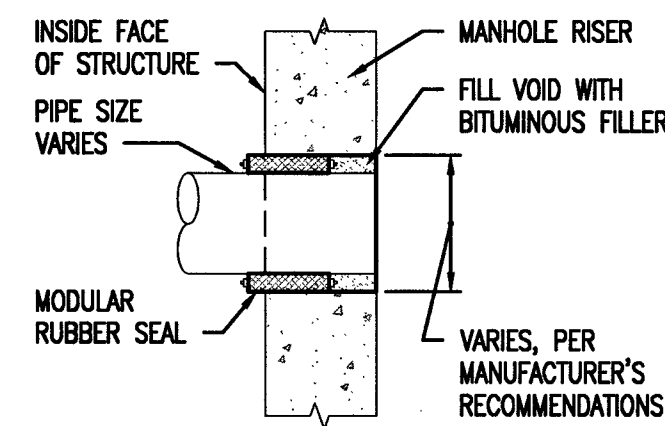


A WALL PENETRATION
M1.03 NOT TO SCALE

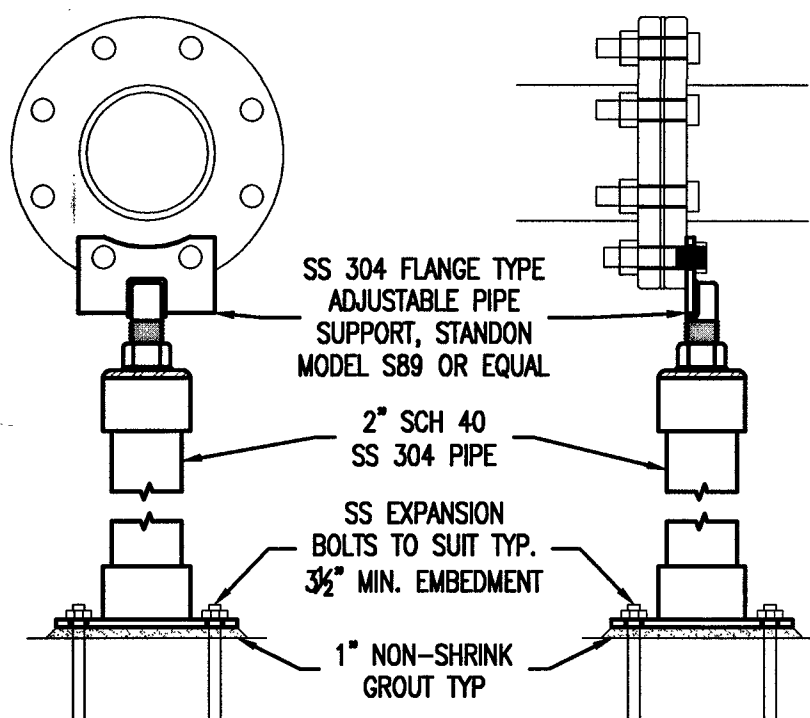


B FLANGE PIPE SUPPORT
M1.03 NOT TO SCALE

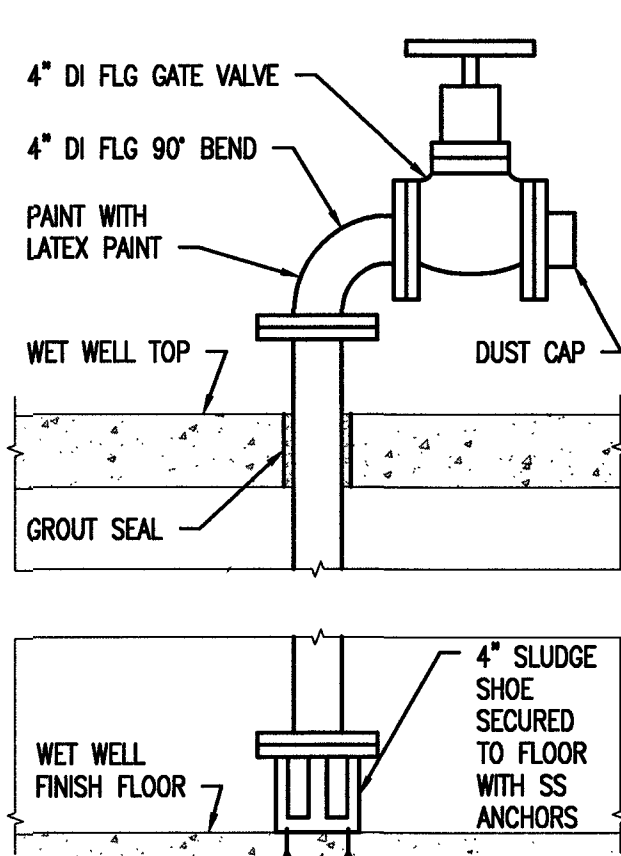


C EMERGENCY PUMP CONNECTION (SUCTION)
M1.03 NOT TO SCALE

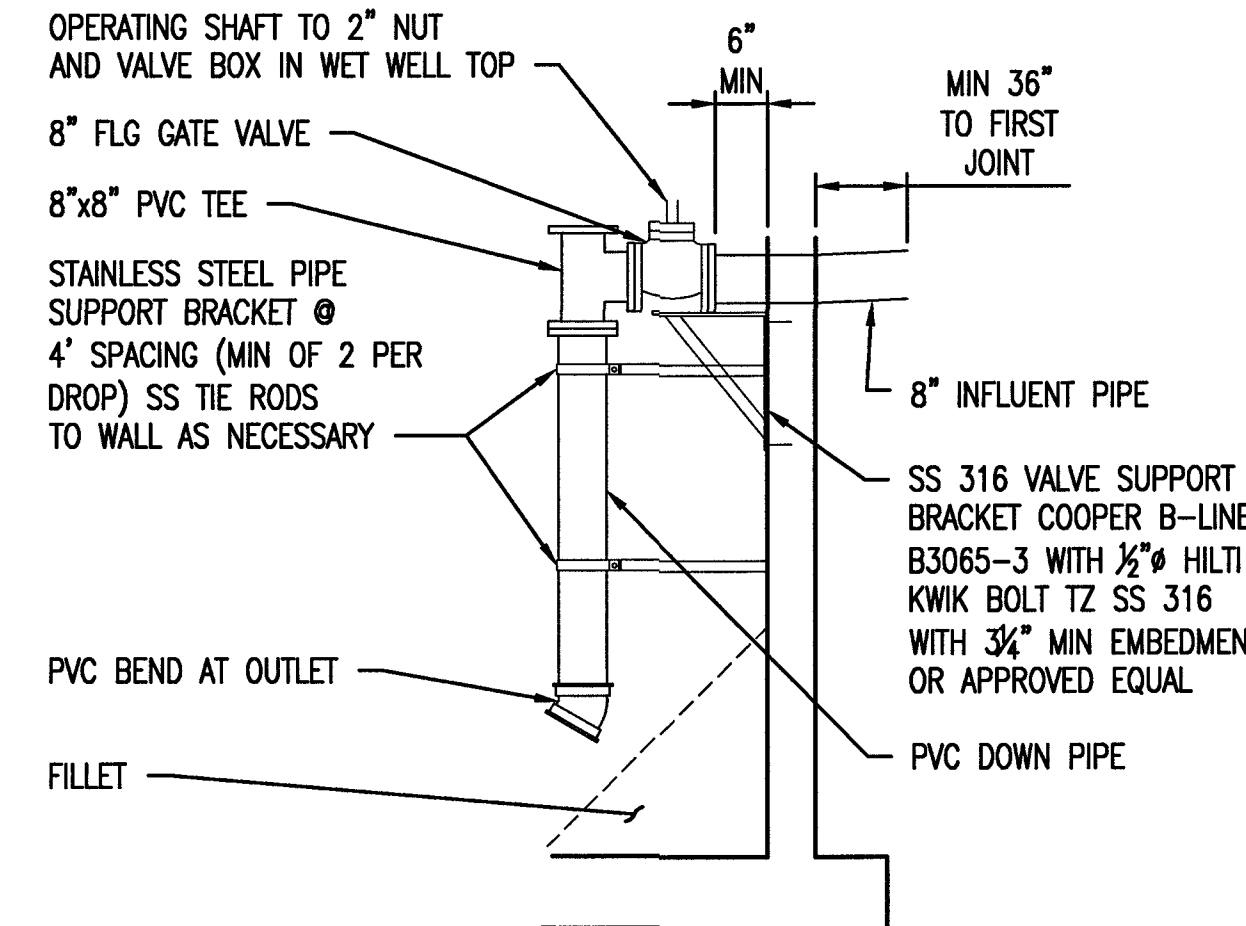


D 8" WET WELL GATE VALVE ASSEMBLY
M1.03 SCALE: 3/8" = 1'-0"

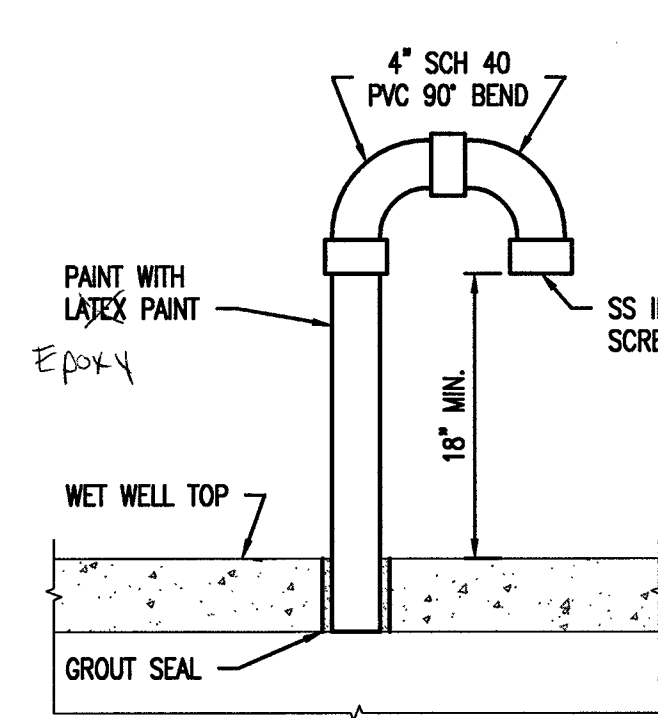

E WET WELL VENT
M1.03 NOT TO SCALE

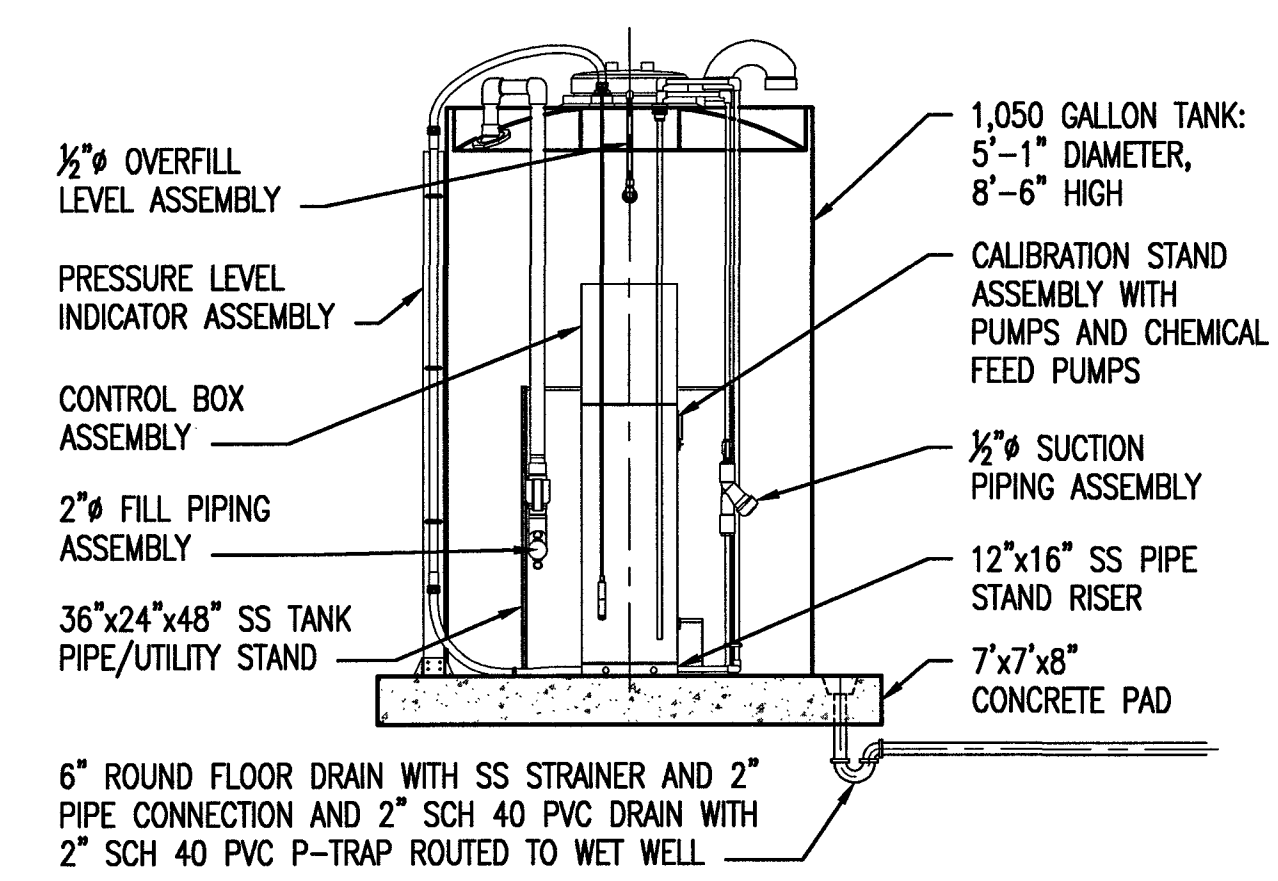


F ODOR CONTROL BIOXIDE PACKAGE
M1.03 SCALE: 3/8" = 1'-0"

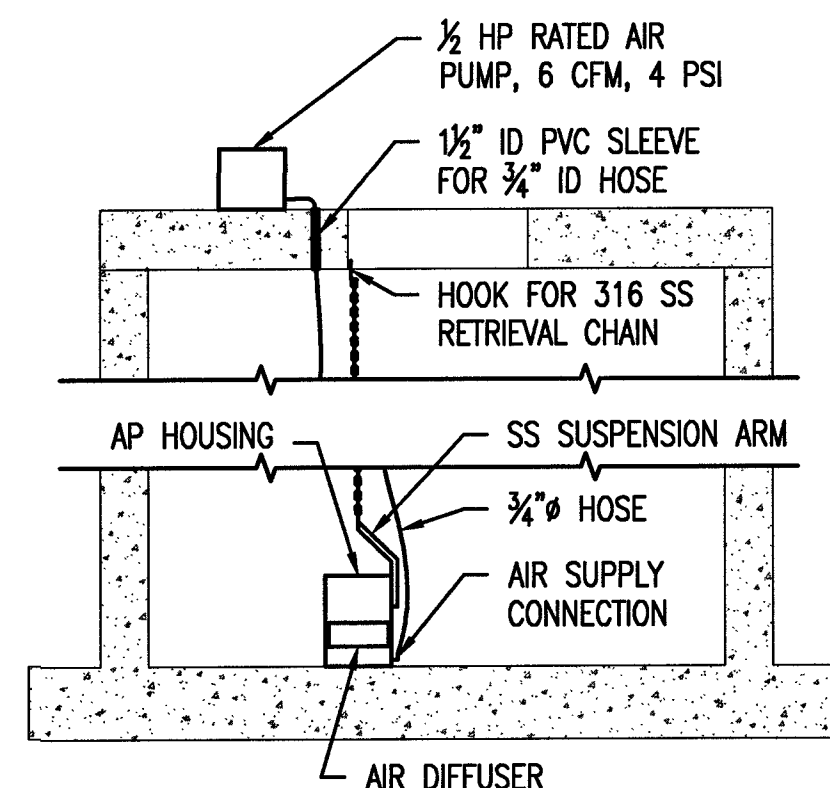


NOTE: AERATION SYSTEM SHALL BE GRIDBEE AP500-AU200, OR APPROVED EQUAL.

G WET WELL AERATION
M1.03 SCALE: 3/8" = 1'-0"


* Me Dora AP500 used

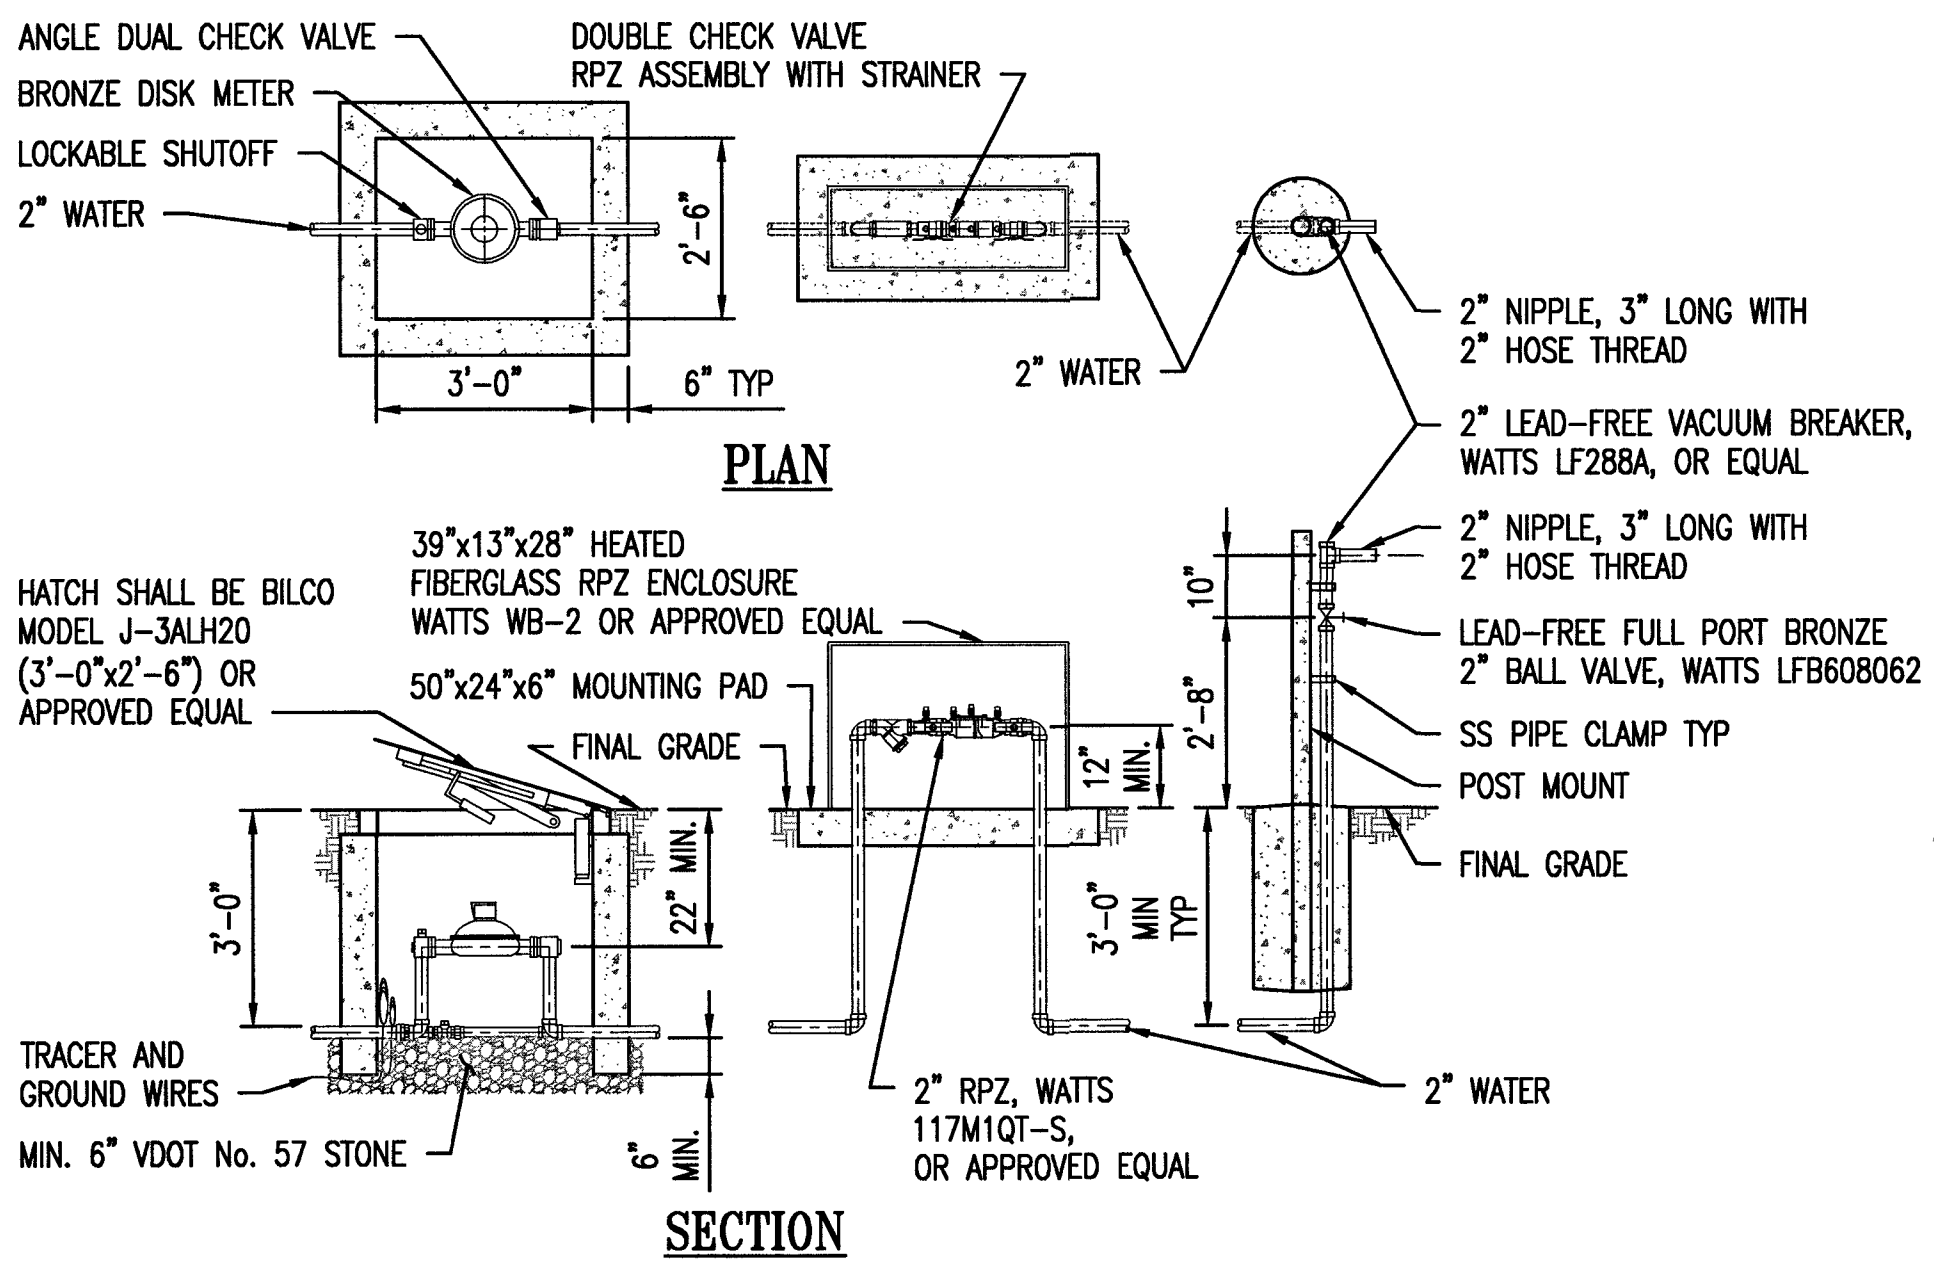


H COMMERCIAL WATER METER INSTALLATION
M1.03 SCALE: 3/8" = 1'-0"

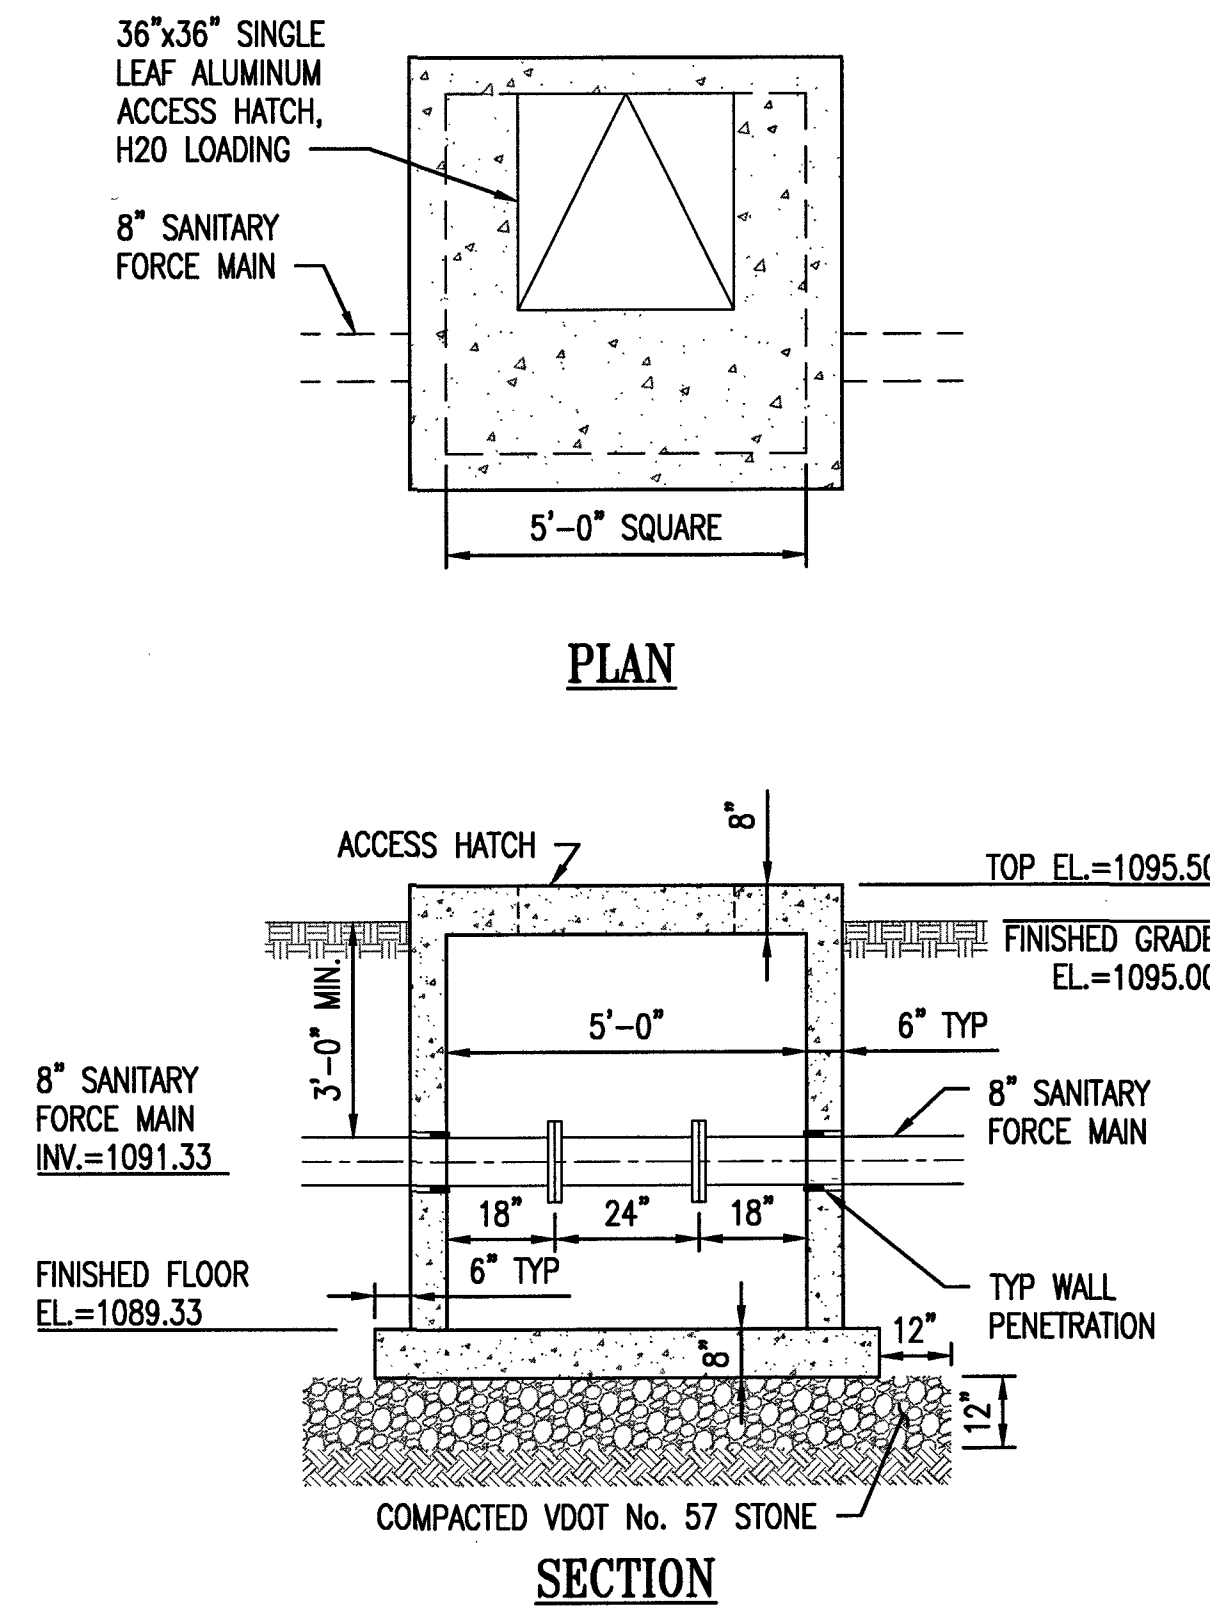

I FLOW METER VAULT DETAILS
M1.03 SCALE: 3/8" = 1'-0"

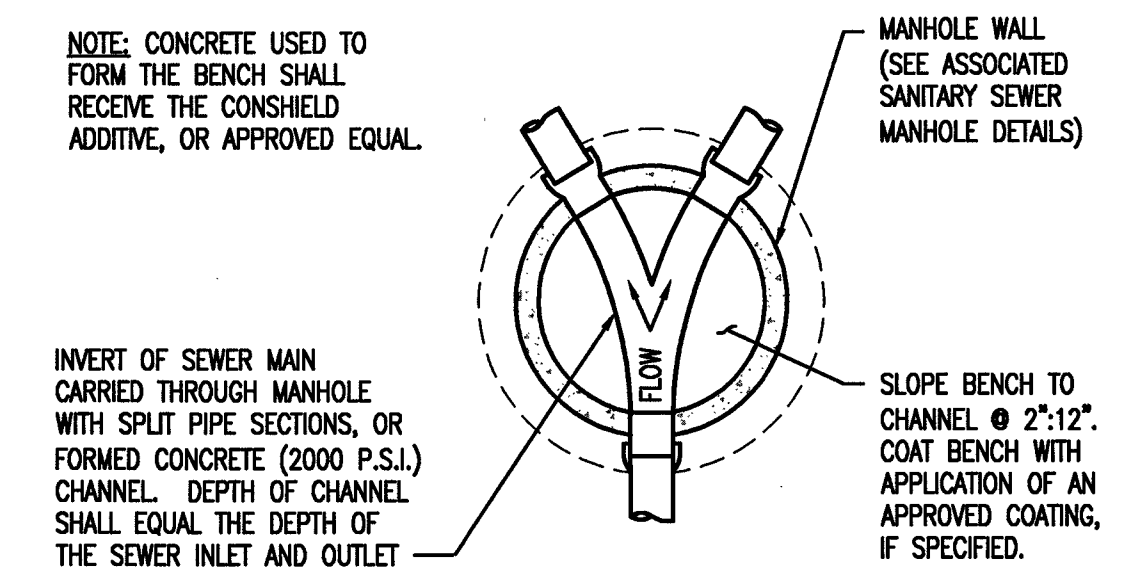


J MANHOLE INVERT SHAPING
M1.03 NOT TO SCALE

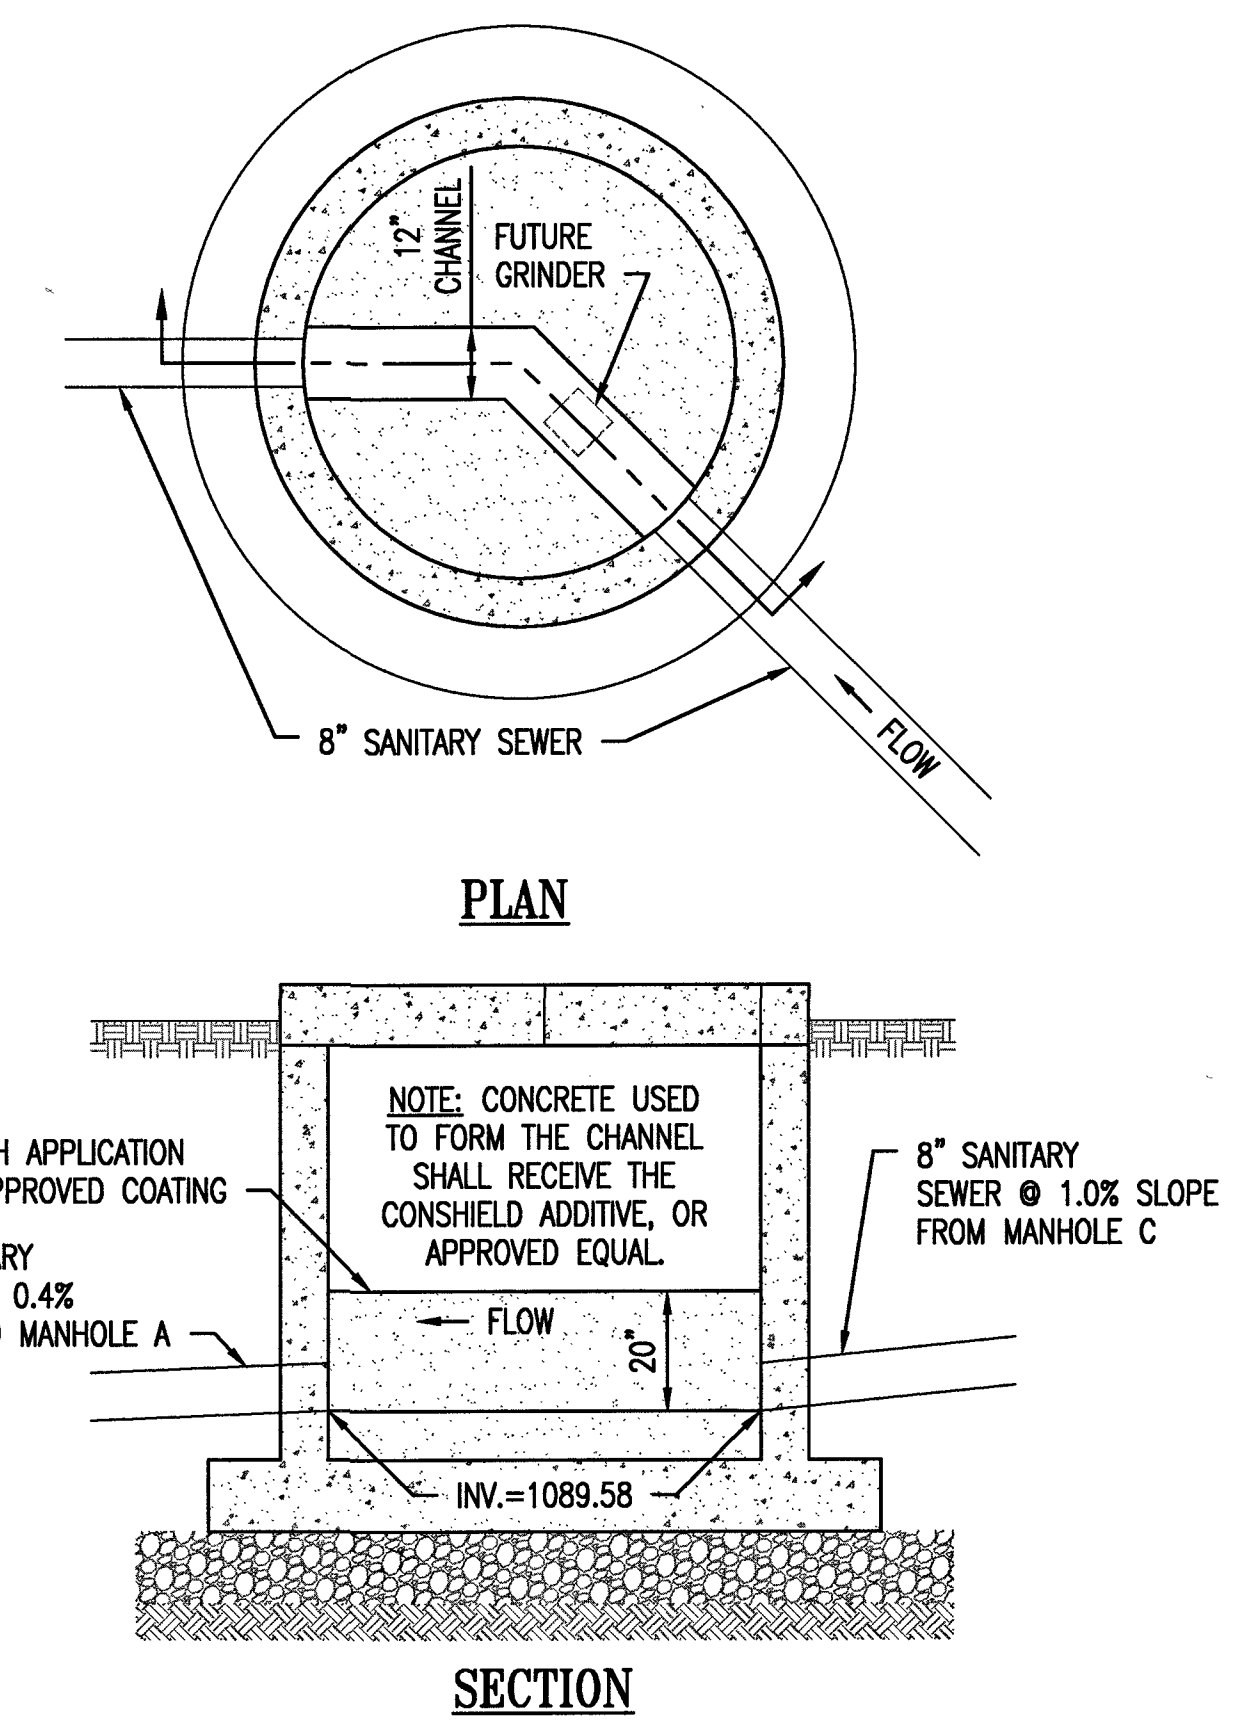

K LS-2 INVERT SHAPING FOR MANHOLE B
M1.03 SCALE: 3/8" = 1'-0"

0 1' 2' 3' 5'
SCALE: 3/8" = 1'-0"

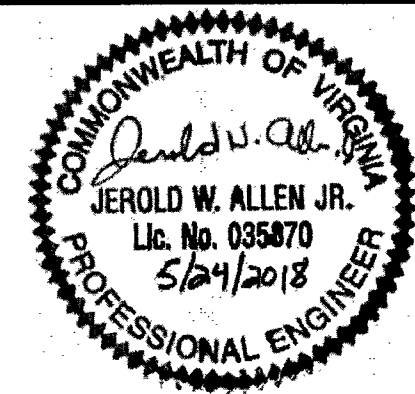

WESTERN VIRGINIA WATER AUTHORITY 601 South Jefferson Street, Suite 300 Roanoke, Virginia 24011		DES: KNA DRAWN: GSL CHECK: JWA DATE: 05/24/18	SCALE: AS SHOWN HORIZ: N/A VERT: N/A	SUMMIT VIEW BUSINESS PARK UTILITY IMPROVEMENTS PHASE 1	MECHANICAL DETAILS	DRAWING M1.03	SHEET 58
--	--	--	--	---	--------------------	------------------	-------------