




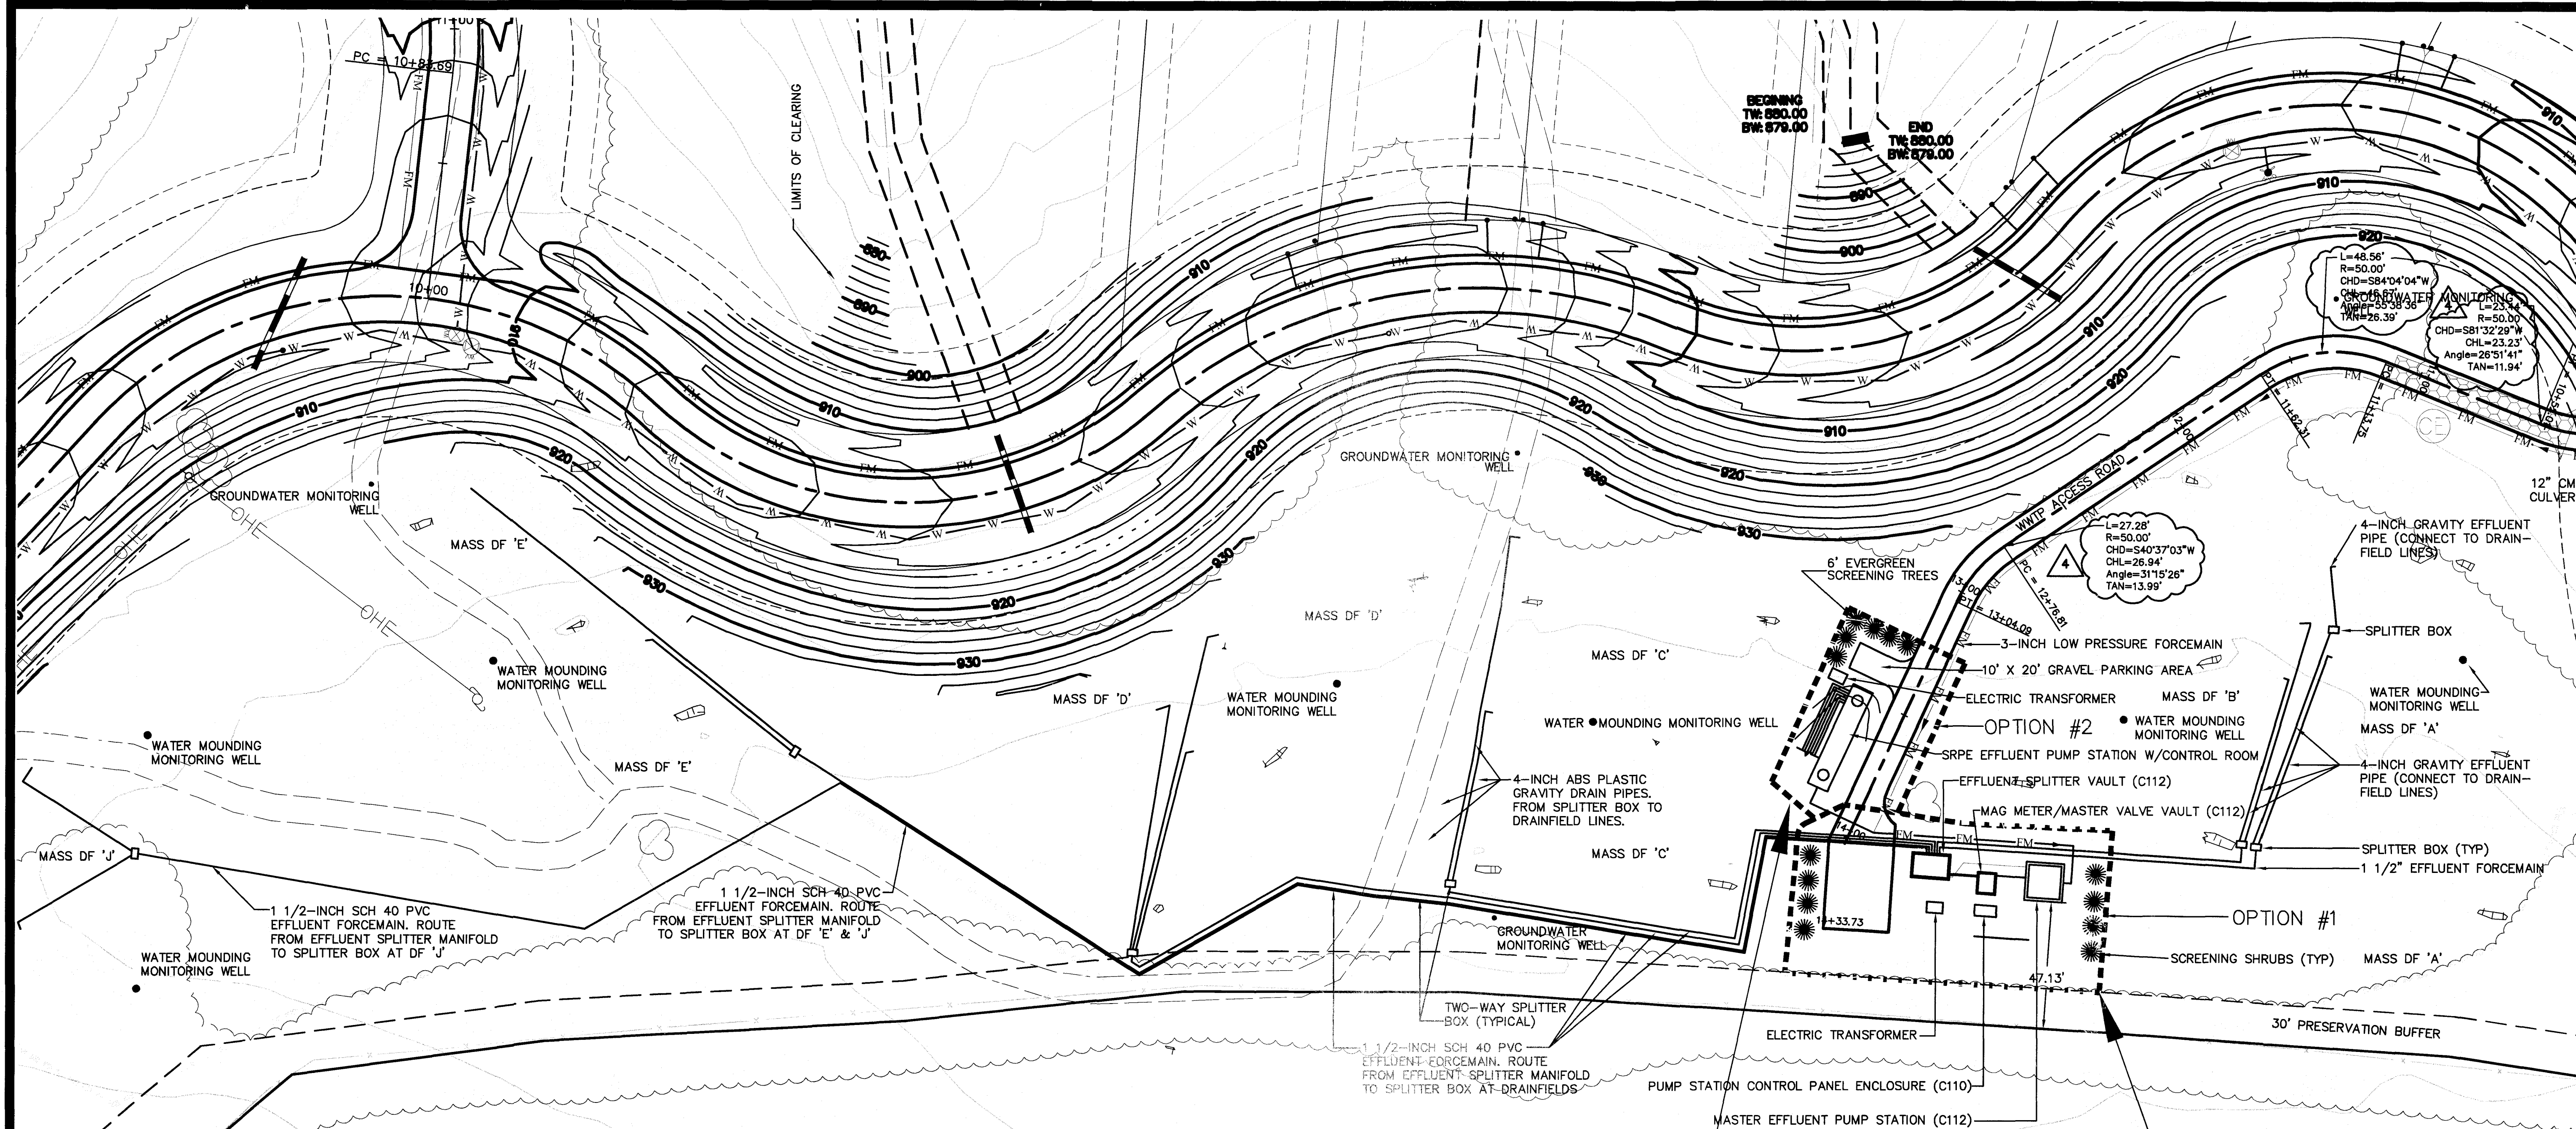

WASTEWATER PUMPING FACILITY  
ROAD PROFILE

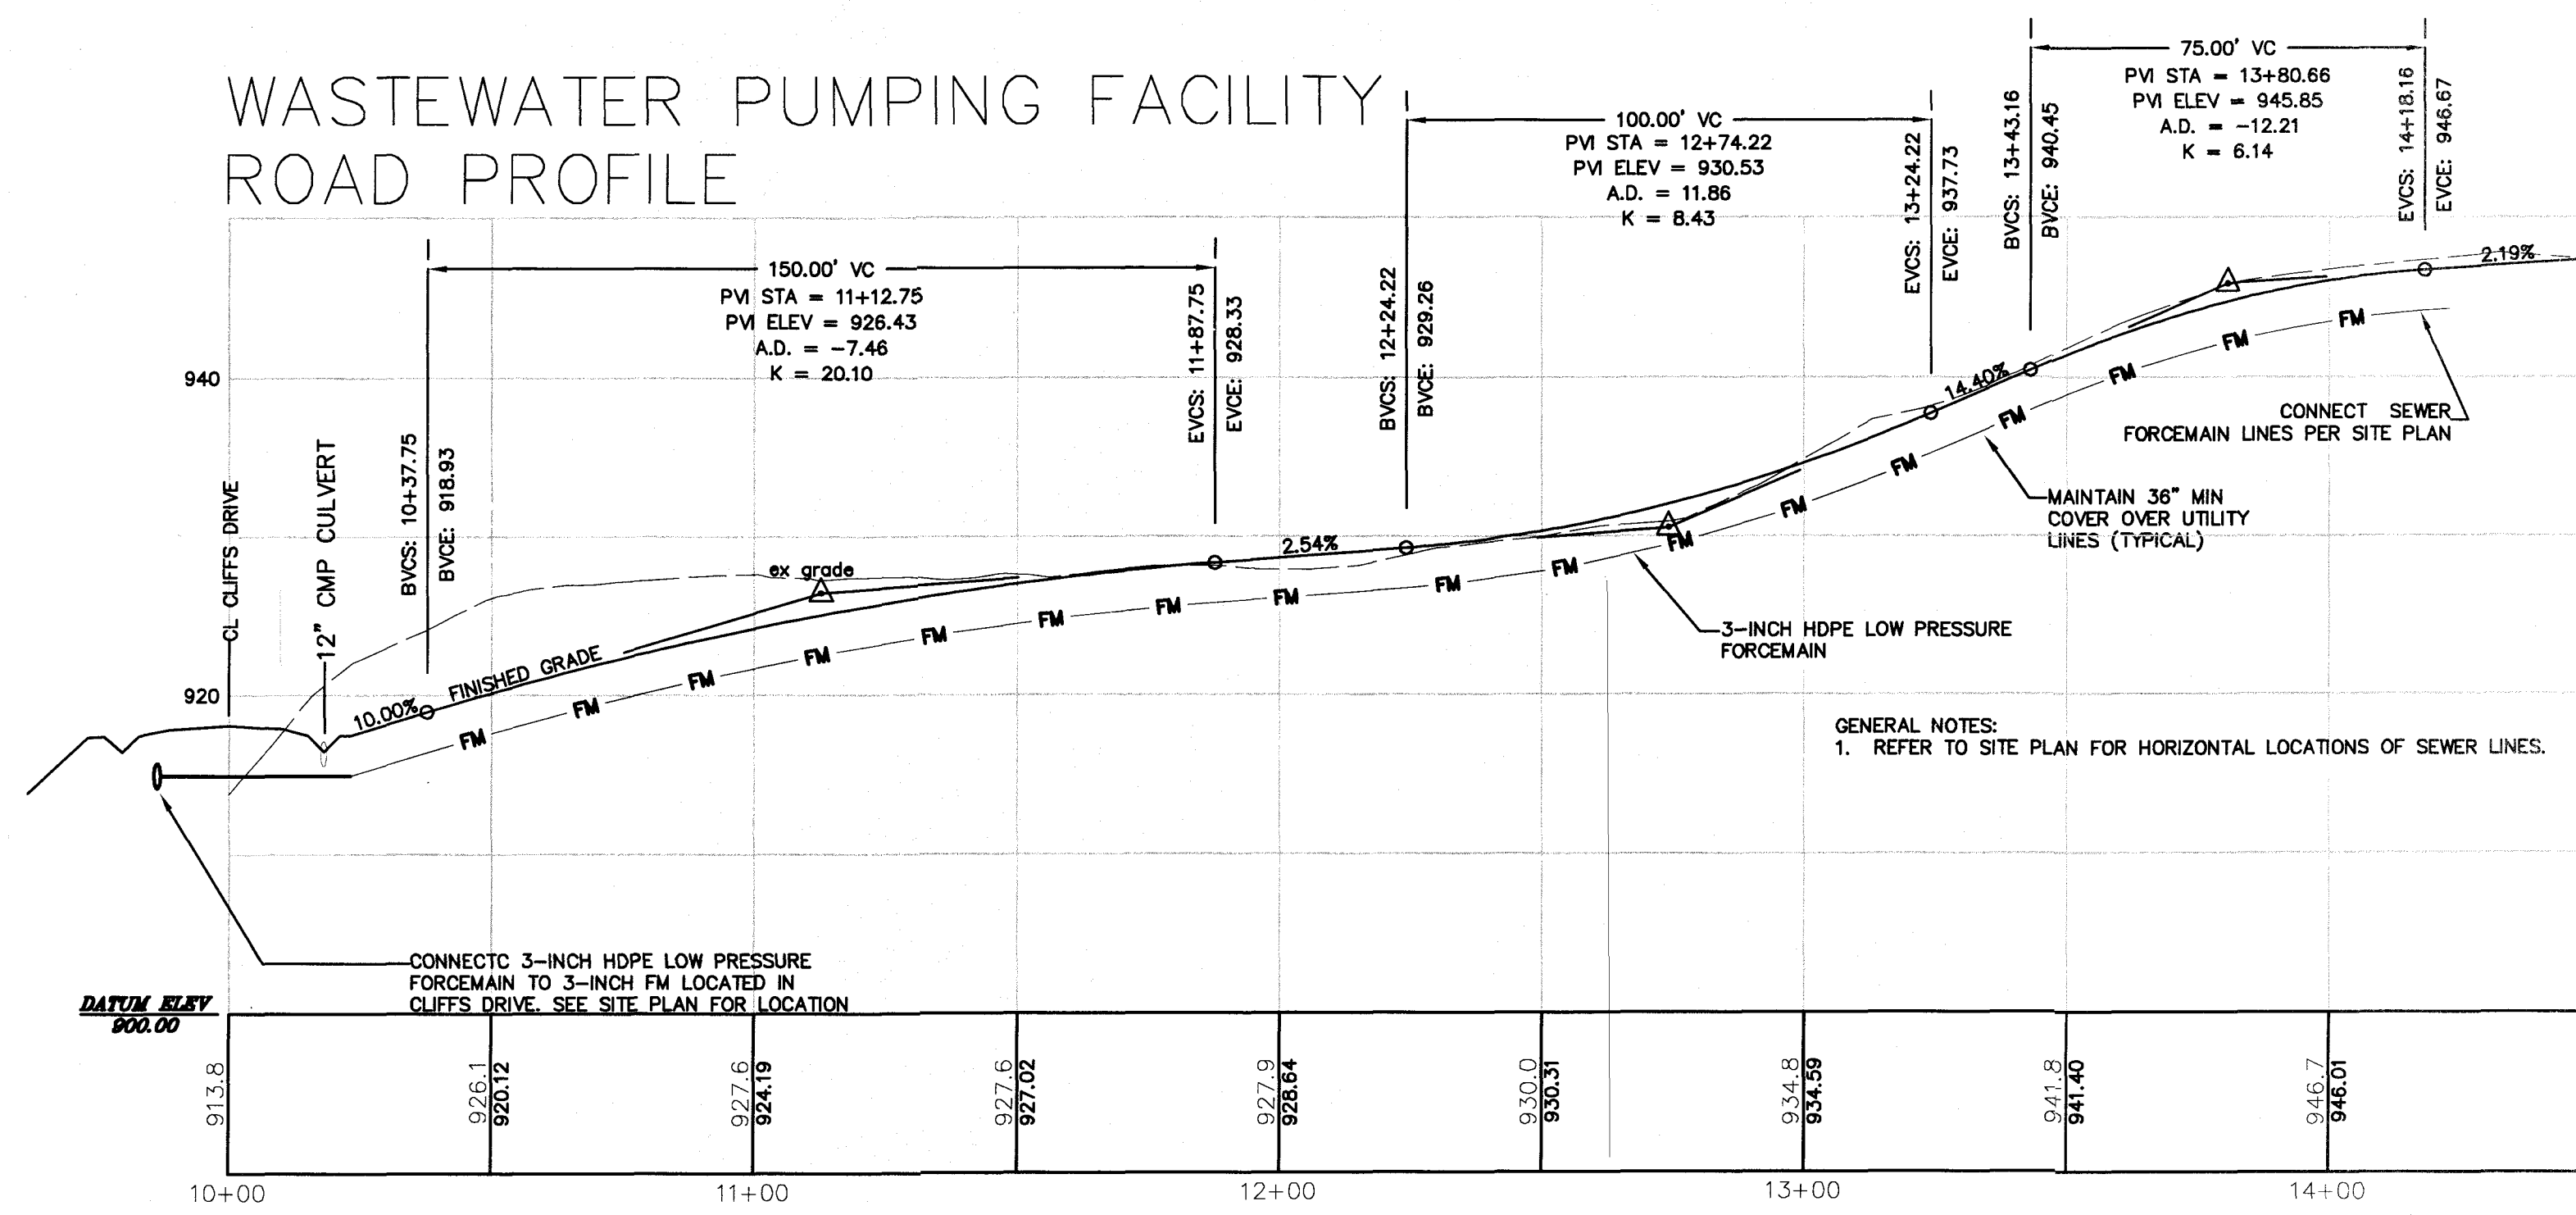

GENERAL NOTES:  
1. REFER TO SITE PLAN FOR HORIZONTAL LOCATIONS OF SEWER LINES.

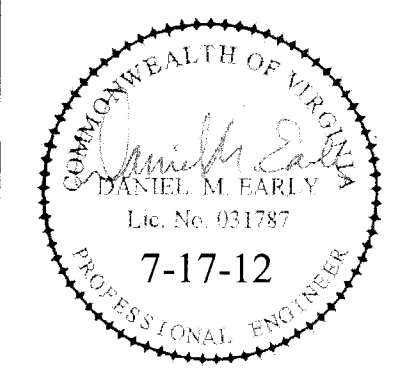

**ACS DESIGN**

ENGINEERING • SURVEYING  
CONSTRUCTION MANAGEMENT

2203 PETERS CREEK ROAD  
ROANOKE, VIRGINIA 24017  
P 540.562.2345 F 562.2344  
INFO@ACSDSIGNLLC.COM  
WWW.ACSDSIGNLLC.COM

The Coves at Smith Mountain Lake  
Central Sewer System Modifications  
Optima Properties-Smith Mountain Lake, LLC  
Franklin County, Virginia

DRAWN BY: JSH  
DESIGNED BY: DME  
CHECKED BY: DME  
DATE: 7-17-12  
JOB NUMBER: 11038

| REVISIONS: |
|------------|
| No. 1      |
| No. 2      |
| No. 3      |
| No. 4      |

SHEET NO.:  
C103

Sewer System  
Site Plan & Details