



THE RETREAT WATER SYSTEM

FRANKLIN COUNTY, VIRGINIA

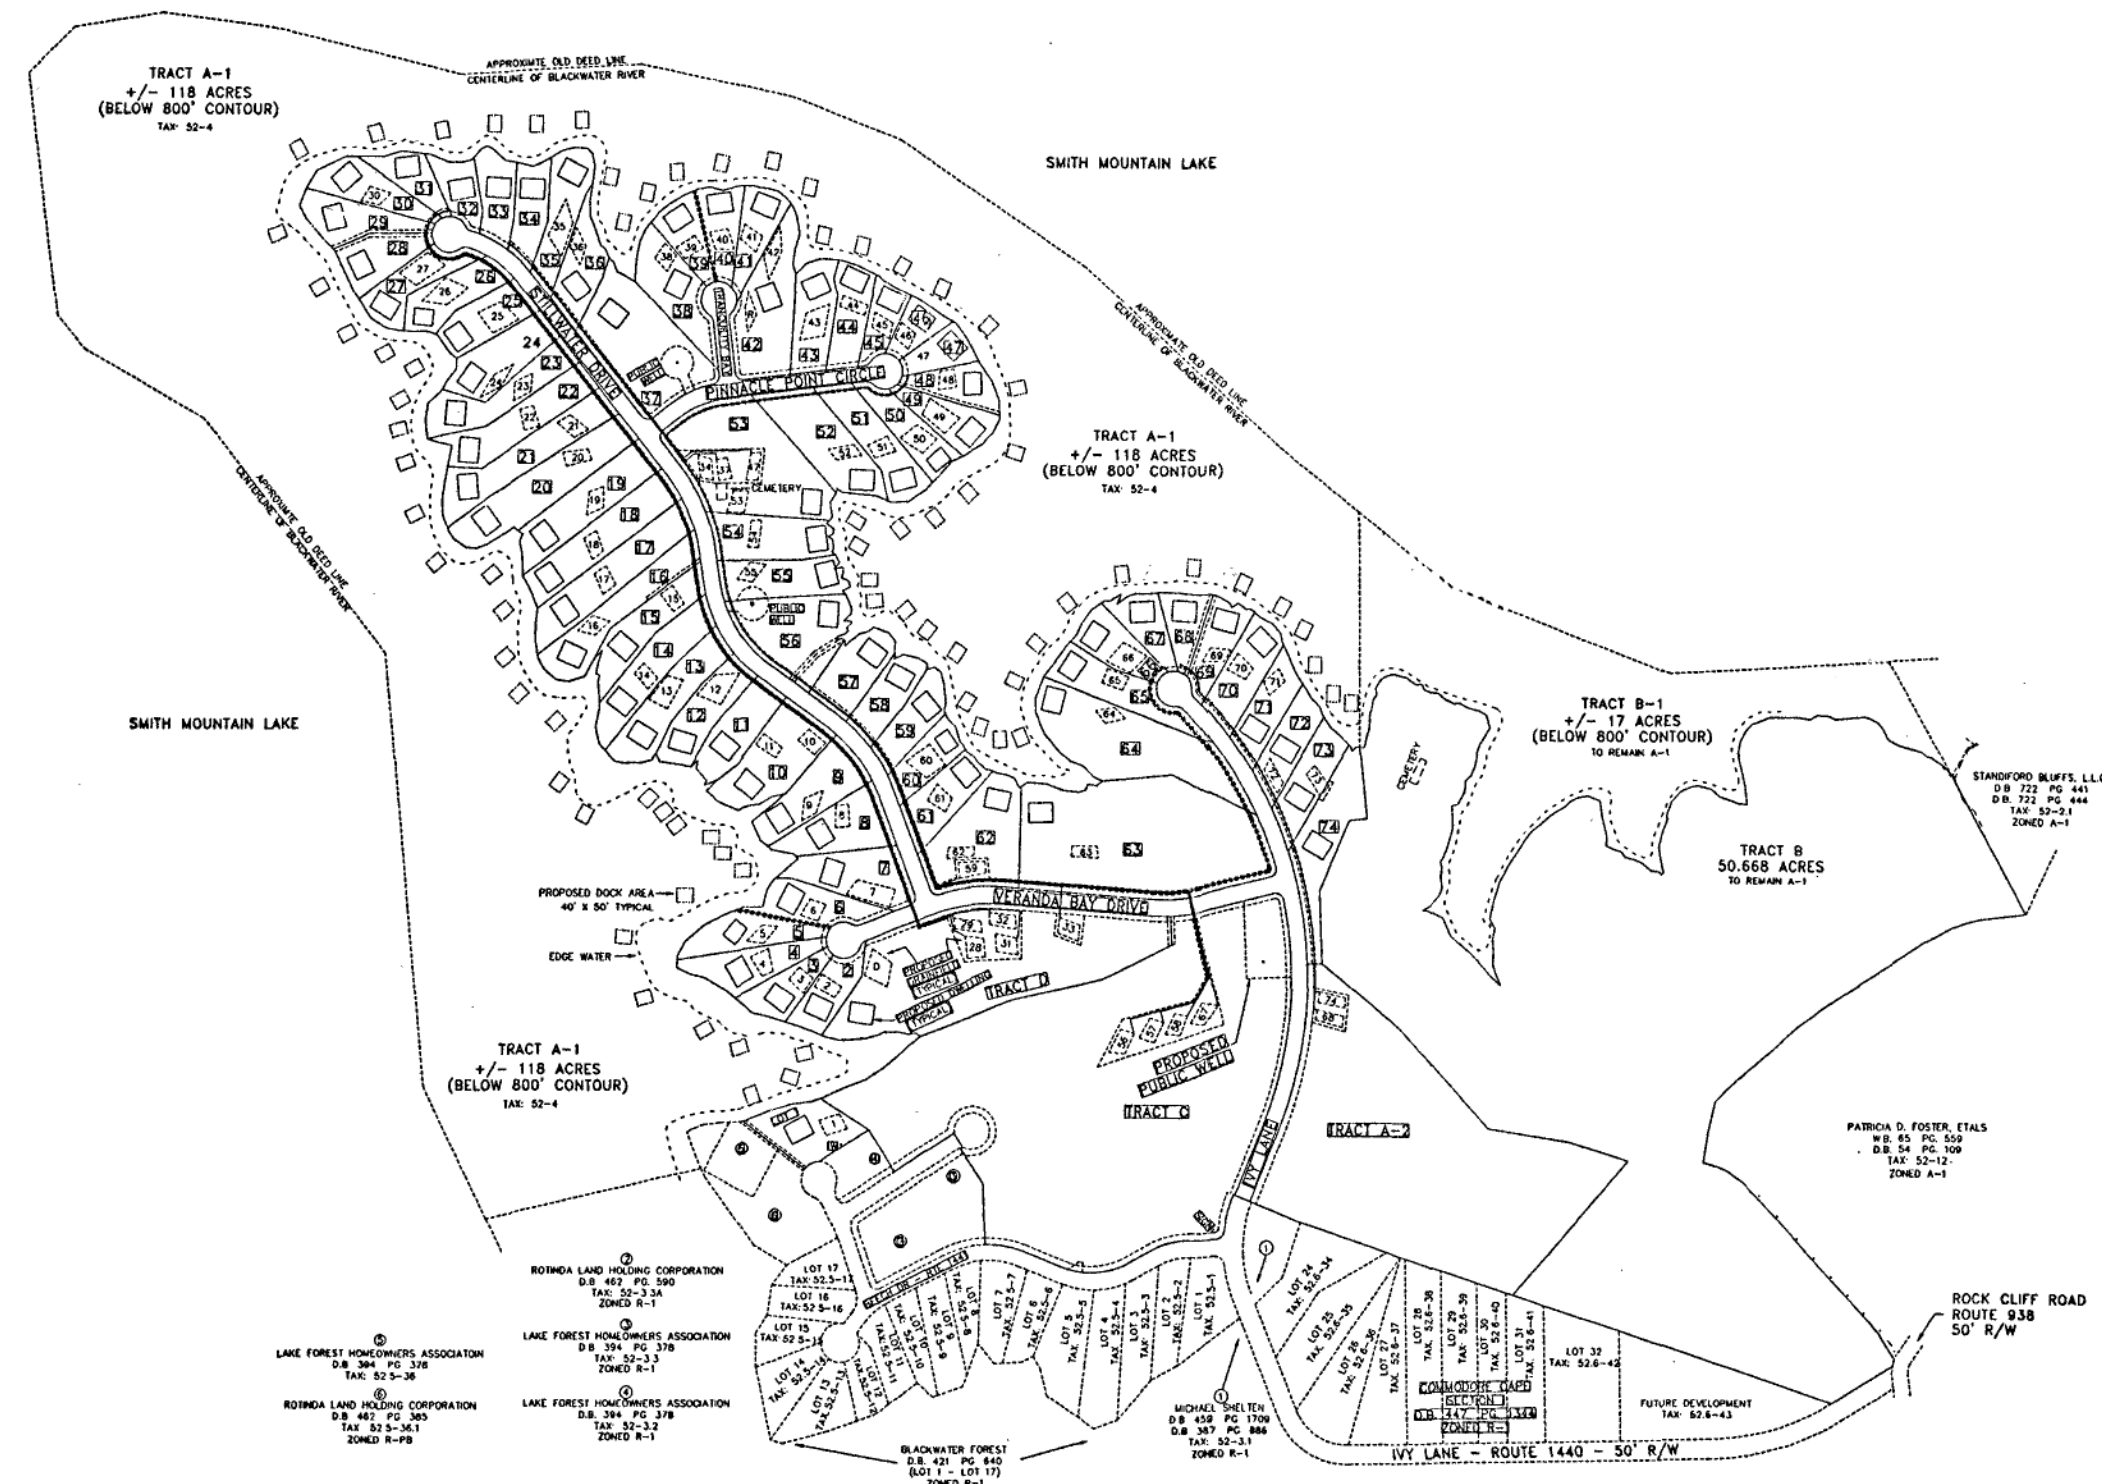

SCALE: 1" = 600'

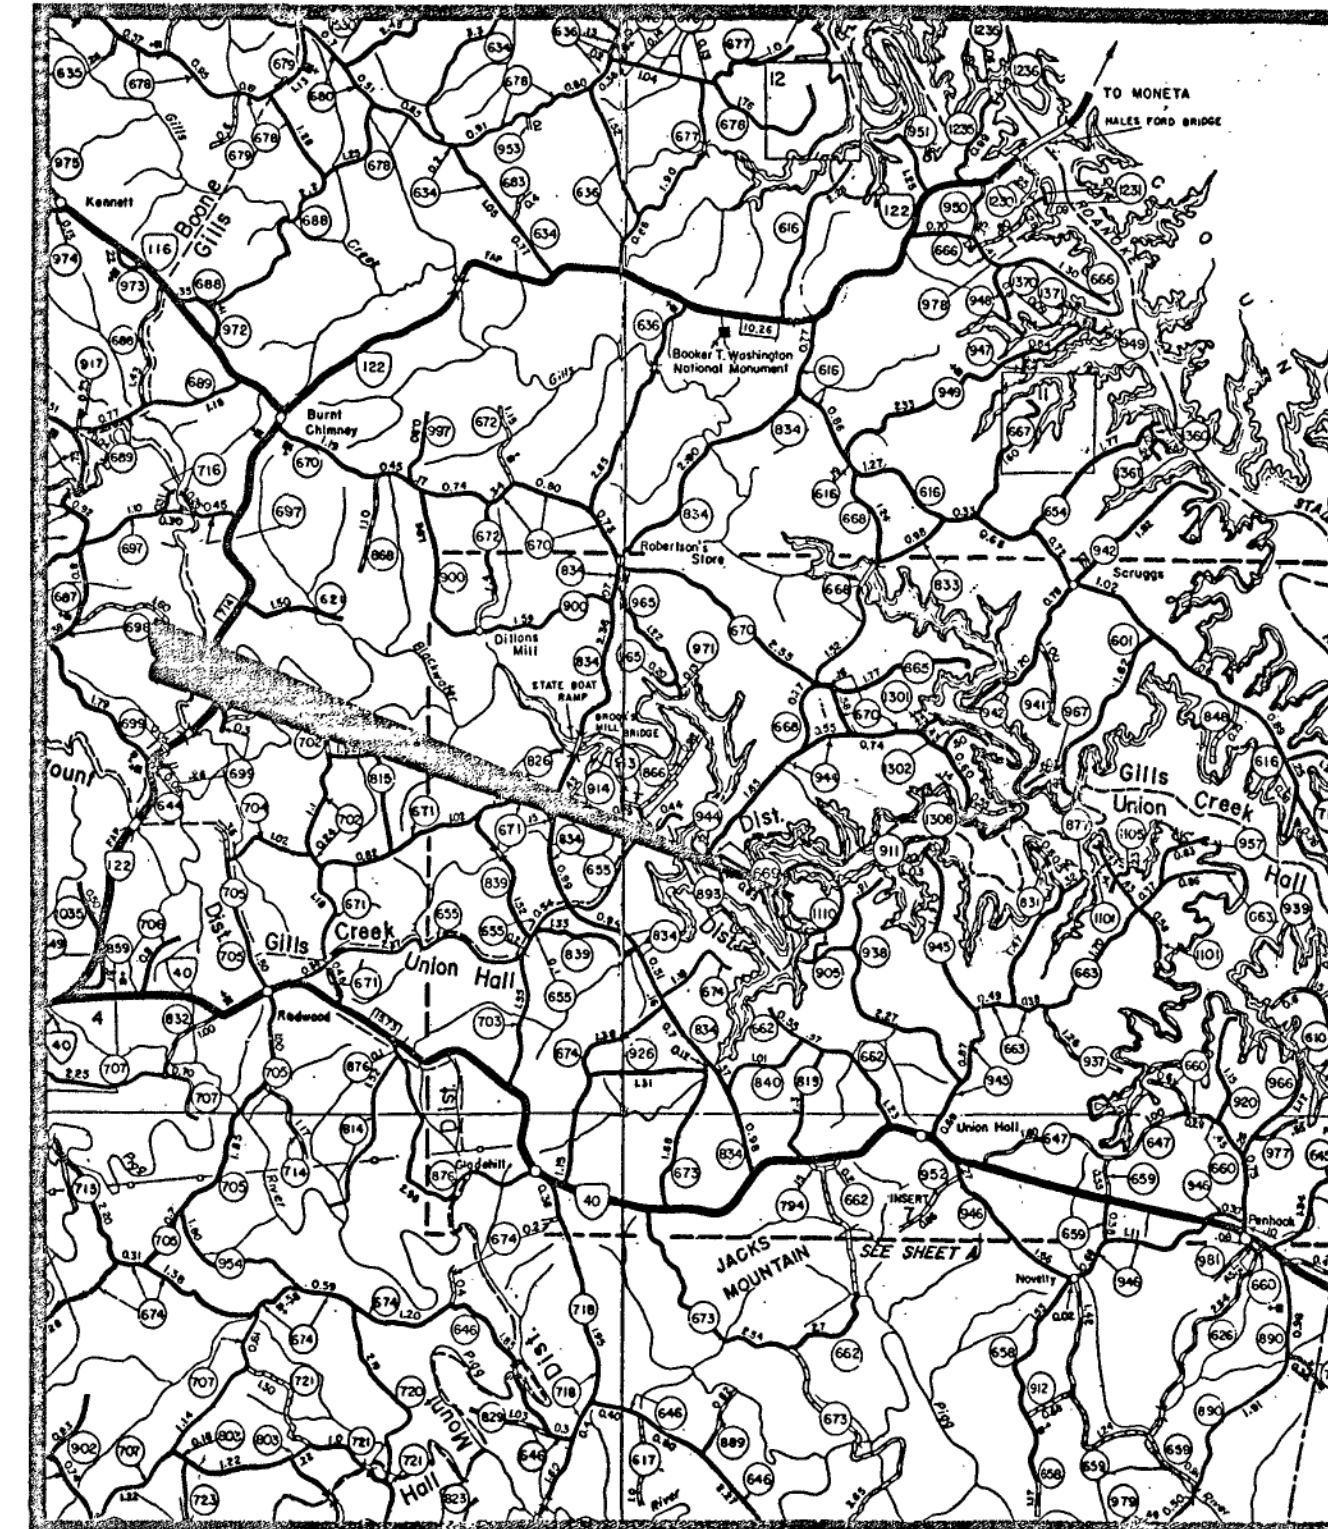

VICINITY MAP

SHEETS 2 THROUGH 10 ARE BASED ON TOPOGRAPHIC INFORMATION
AND PLAN AND PROFILE DRAWINGS PROVIDED BY: PHILIP W. NESTER,
INC., P. O. BOX 827, ROCKY MOUNT, VIRGINIA 24151.

BERKLEY HOWELL & ASSOC., P.C.

ENGINEERS • SURVEYORS • PLANNERS
306 ENTERPRISE DRIVE, SUITE C
FOREST, VIRGINIA 24551
PH: (434) 385-7548 FAX: (434) 385-6178



THE RETREAT
WATER SYSTEM
UNION HALL DISTRICT FRANKLIN CO., VA.

DATE: 10-1-02

TECHNICIAN:

CHECKED BY:

REVISIONS

NO.	DATE
1	2-26-03

SCALES
AS SHOWN

PROJ. NO.
020097

DIV.
1 OF 16

SHEET NO.
DRAWING NO.
"COVER"