



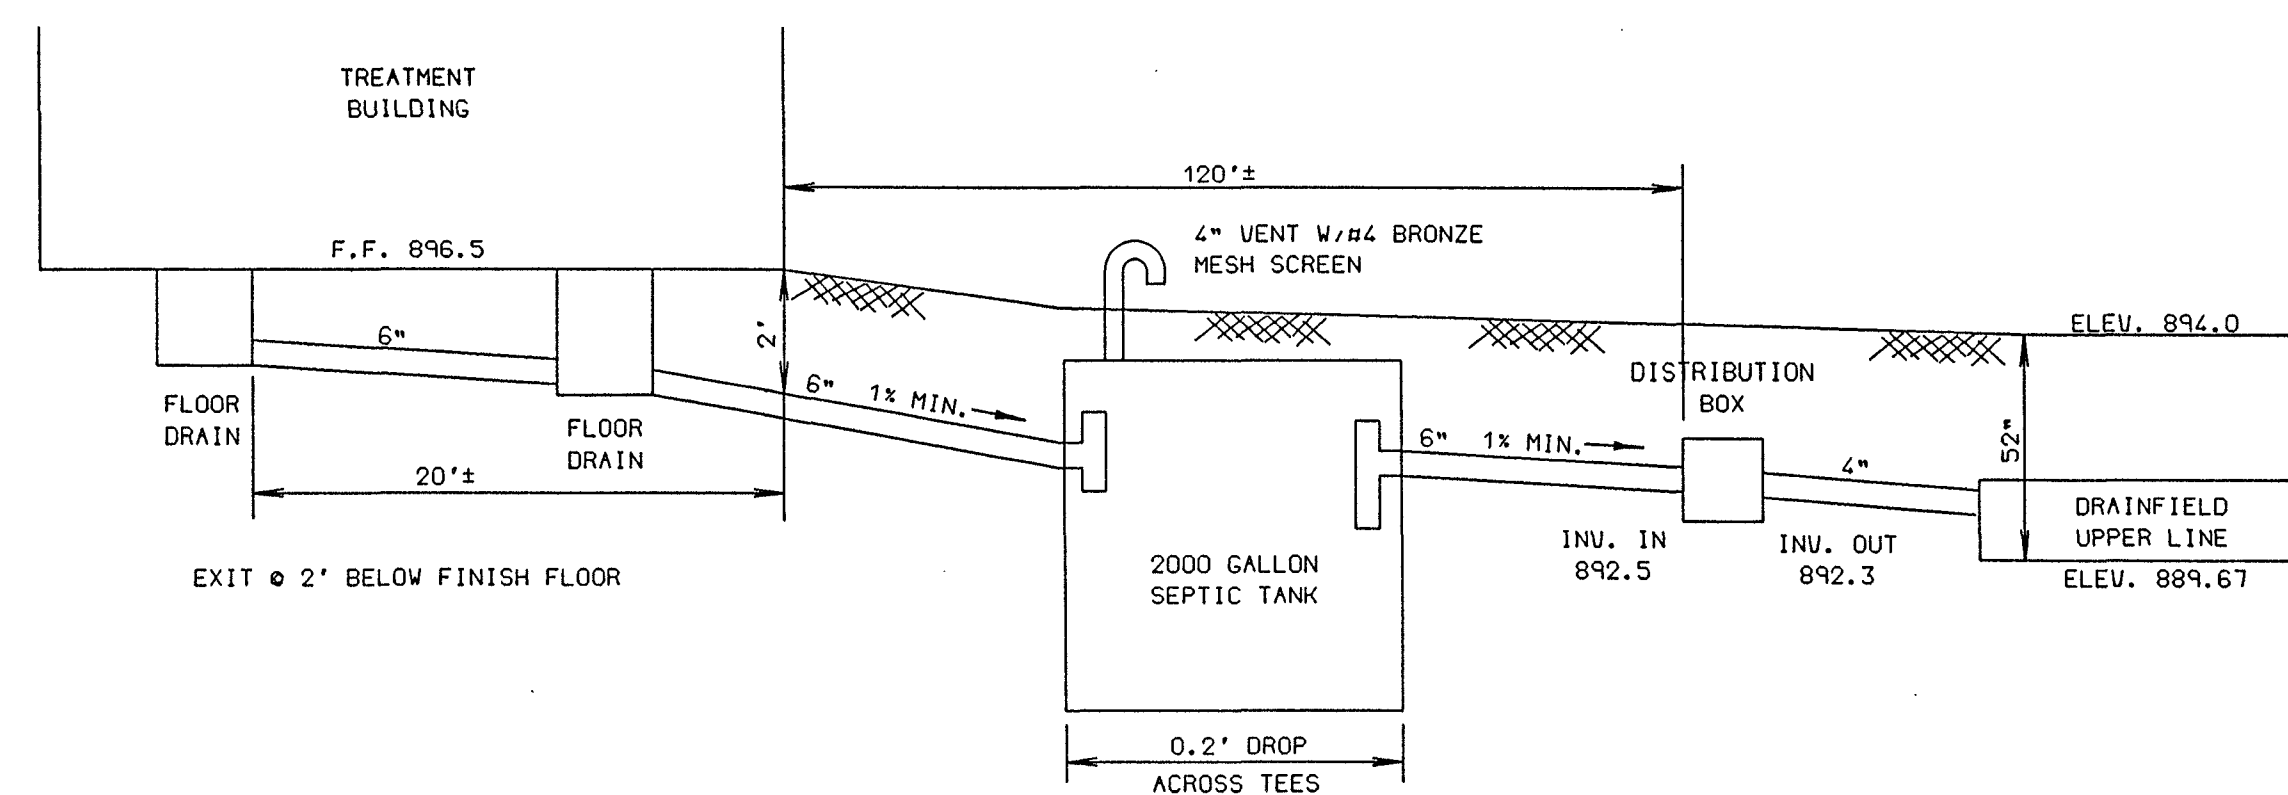

BACKWASH DISPOSAL SYSTEM
N.T.S.

BERKLEY HOWELL & ASSOC., P. C.
ENGINEERS • SURVEYORS • PLANNERS
306 ENTERPRISE DRIVE, SUITE C
FOREST, VIRGINIA 24551
PH: (434) 395-7548 FAX: (434) 395-6178

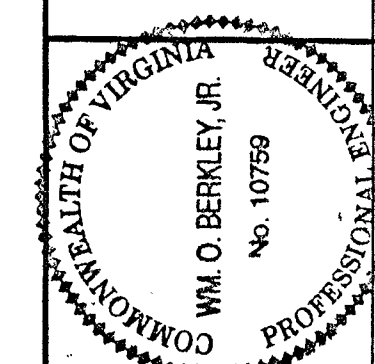

THE RETREAT
WATER SYSTEM

SITE PLAN

DATE: 10-1-02

TECHNICIAN:

CHECKED BY:

REVISIONS

NO.	DATE
	2-26-0

SCALES
AS SHOWN

PROJ. NO. 020097	DI
---------------------	----

SHEET NO.
10 OF 16

DRAWING NO.

SURVEY DATUM USED:

FIELDBOOK IDENTIFICATION:

VIEWS TO CREATE THIS DRAWING: -

MANUSCRIPT DRAWING NUMBER: 1