




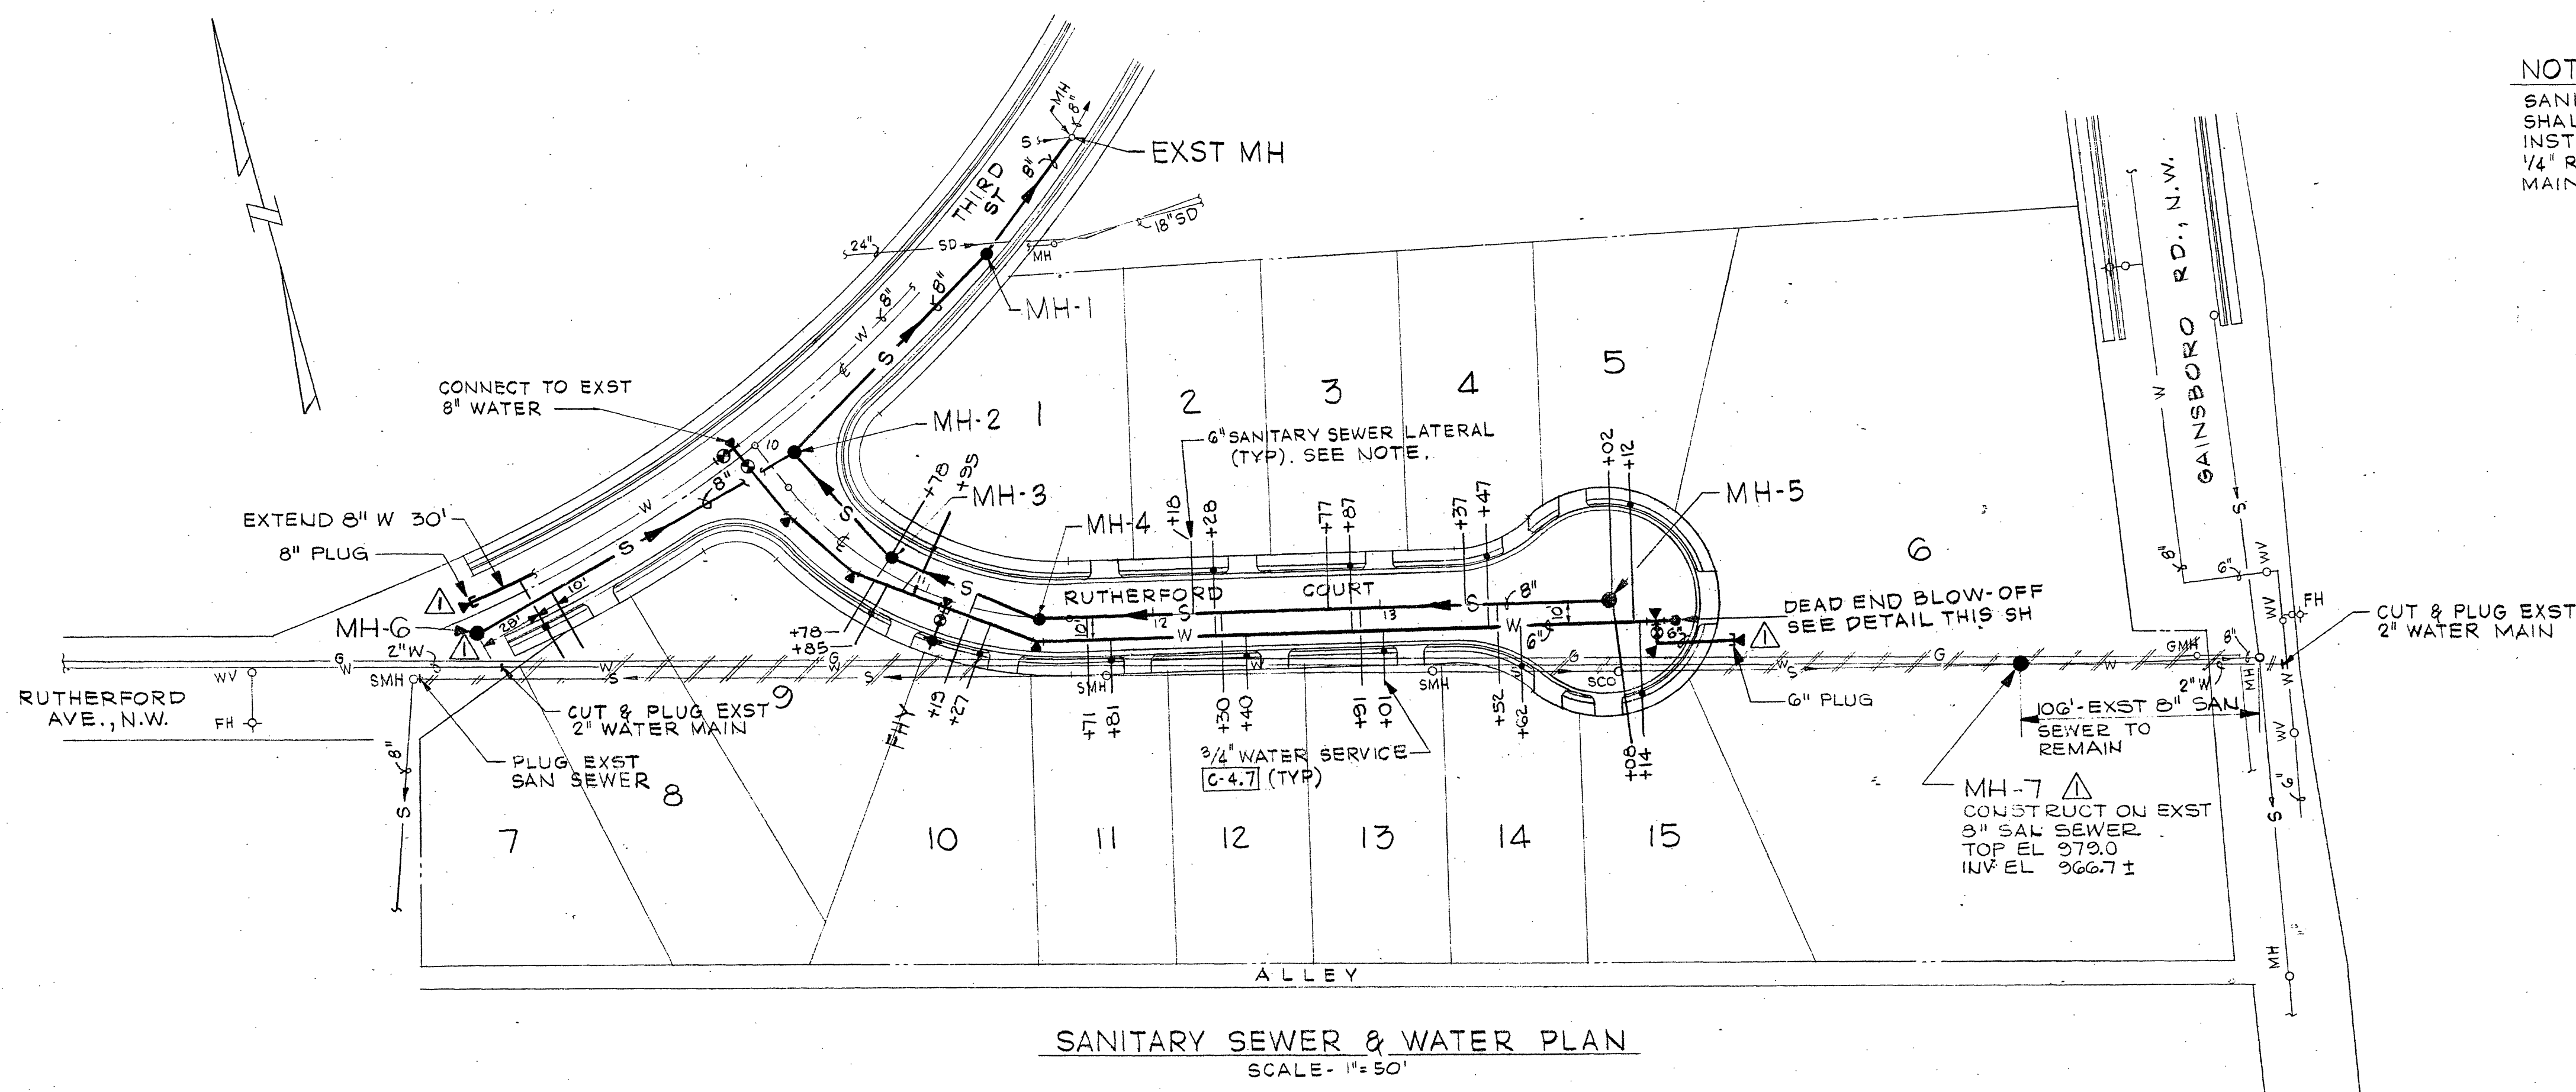


NOTE:
SANITARY SEWER SERVICE LATERALS SHALL BE 6" DIAMETER AND SHALL BE INSTALLED AT A UNIFORM GRADE OF 1/4" RISE PER FOOT FROM THE SEWER MAIN.

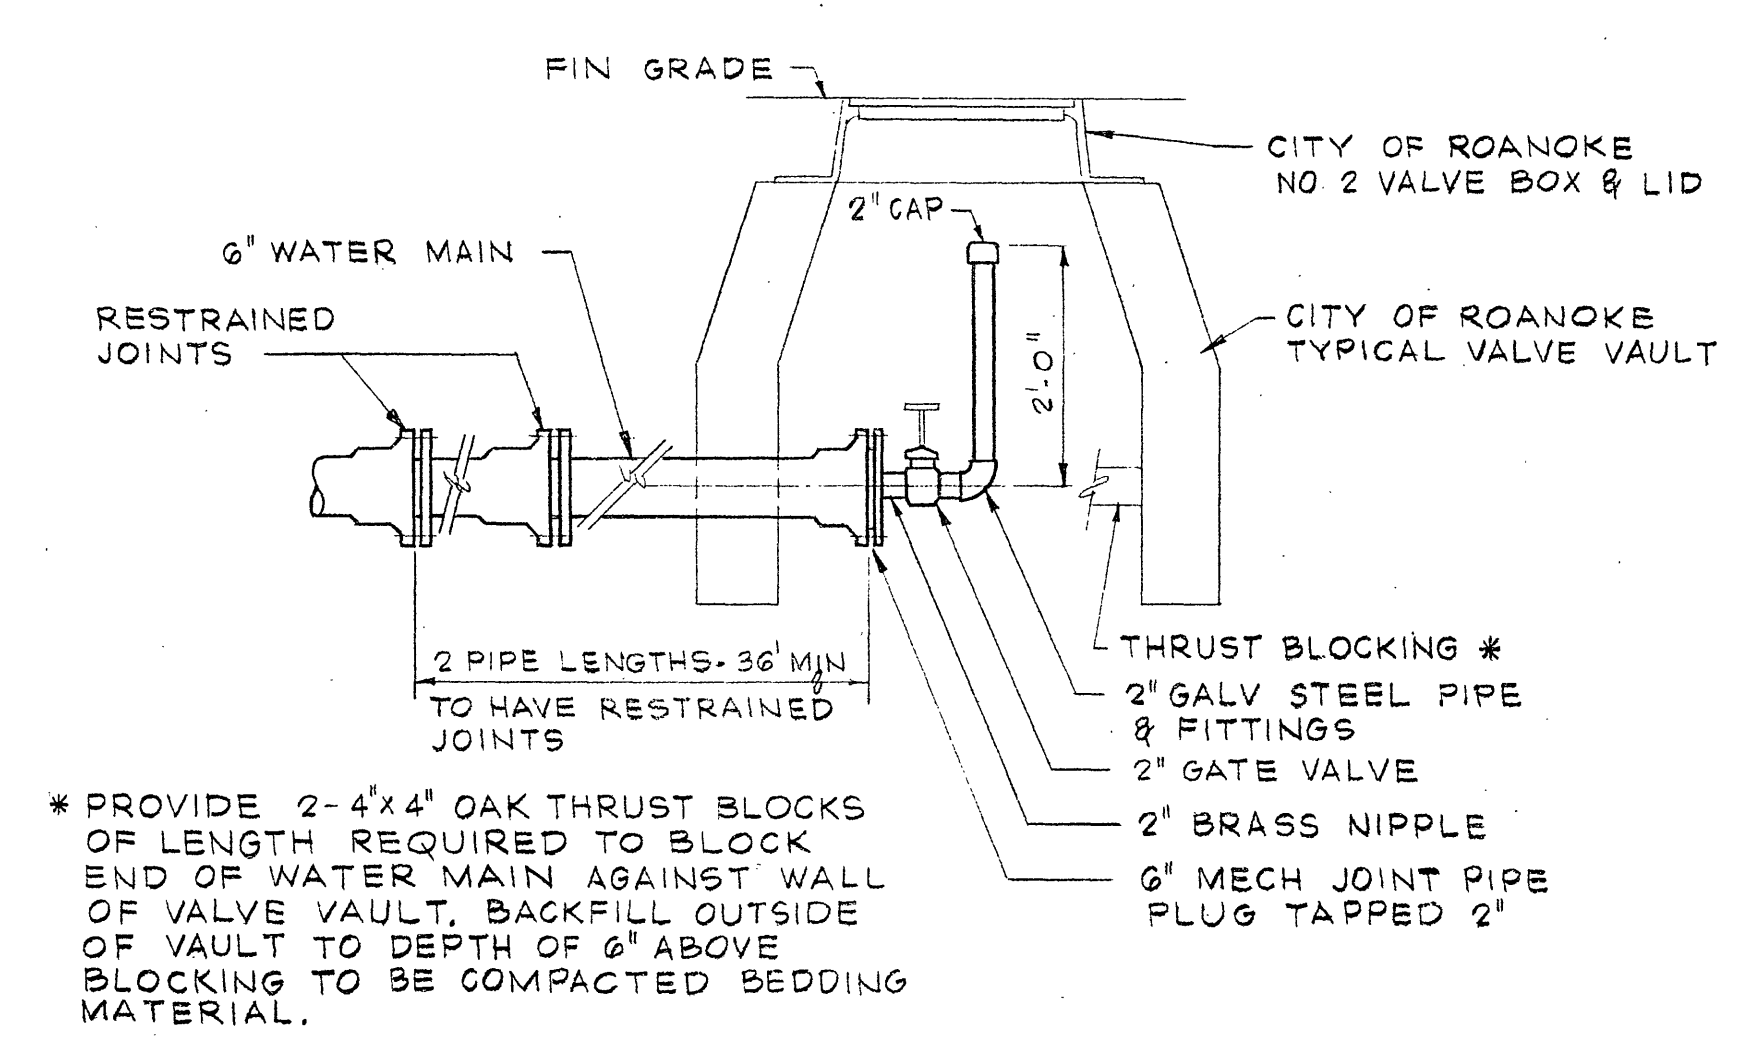


DETAIL OF DEAD END BLOW-OFF
NO SCALE

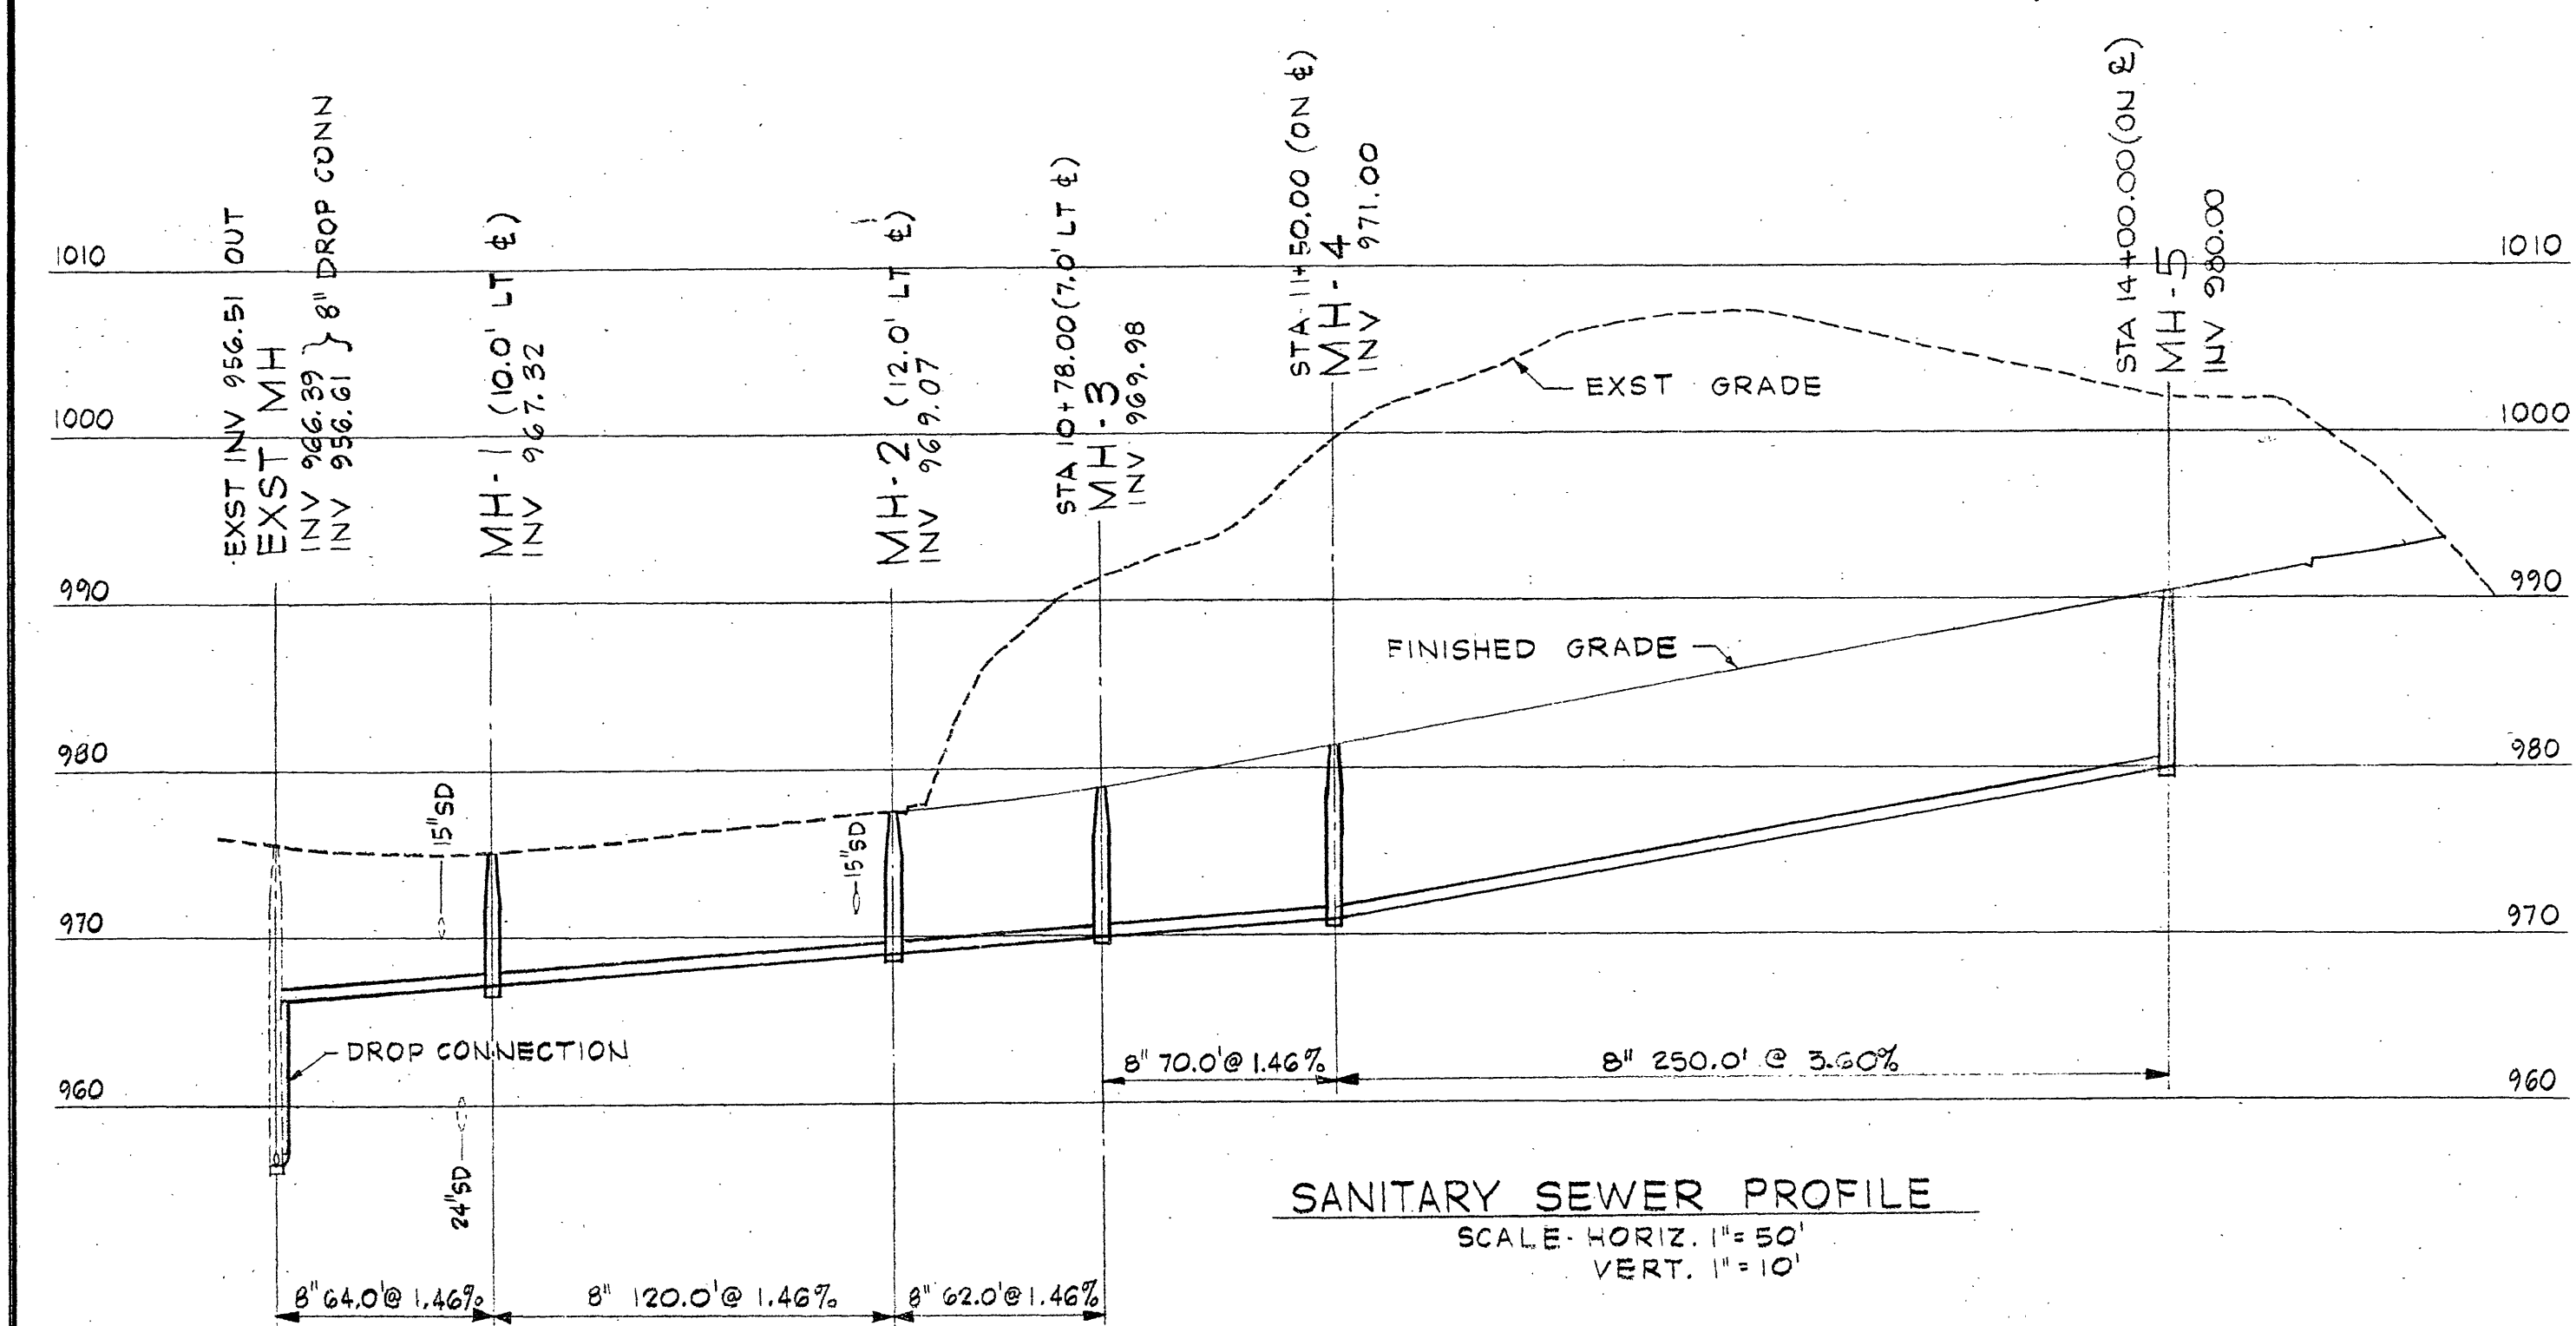


SANITARY SEWER PROFILE
SCALE - HORIZ. 1" = 50'
VERT. 1" = 10'

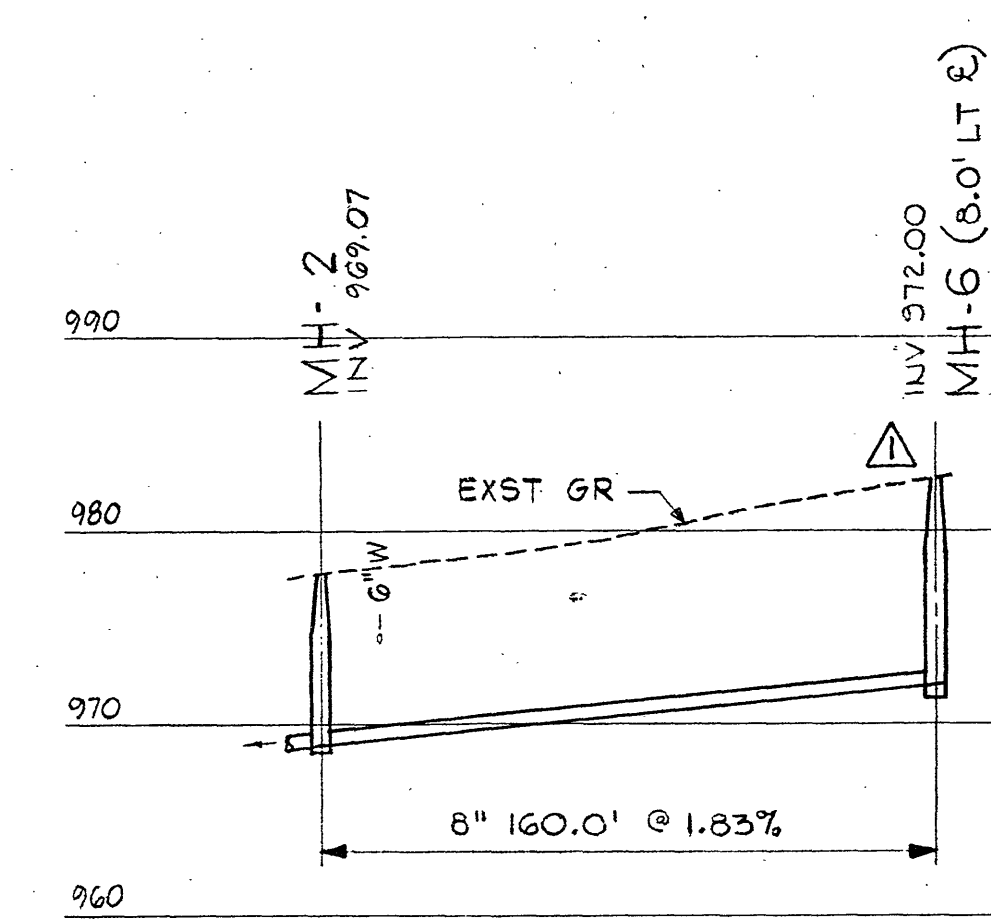


SANITARY SEWER PROFILE
SCALE - HORIZ. 1" = 50'
VERT. 1" = 10'

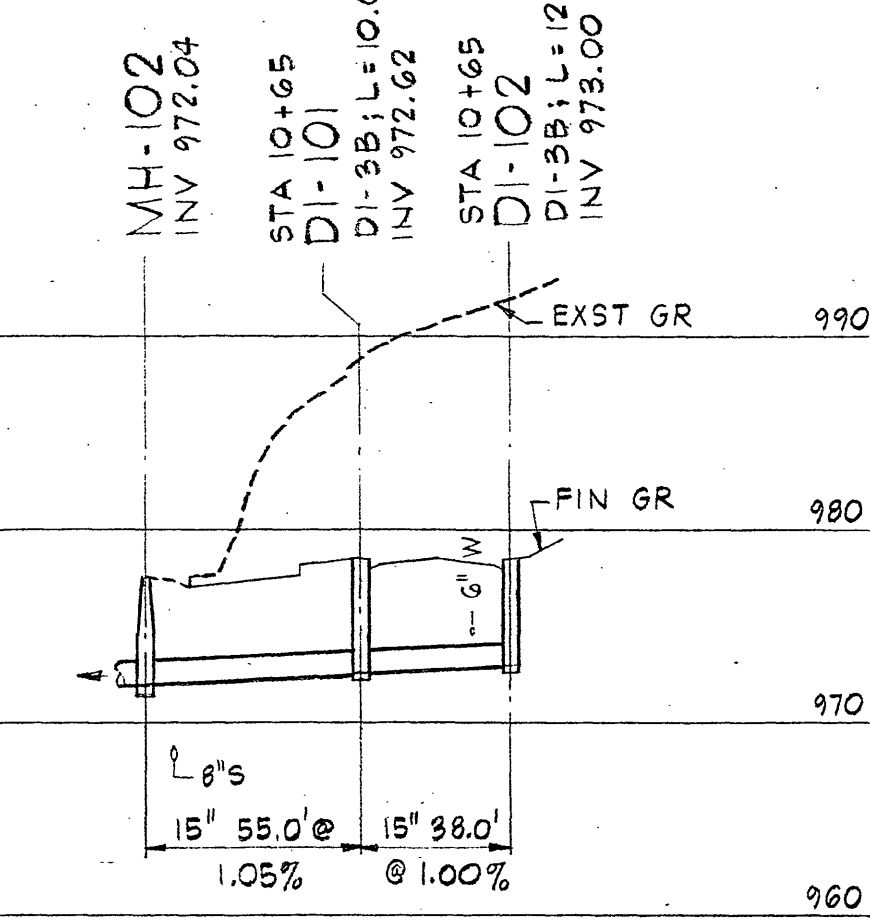


STORM DRAIN PROFILE
SCALE - HORIZ. 1" = 50'
VERT. 1" = 10'

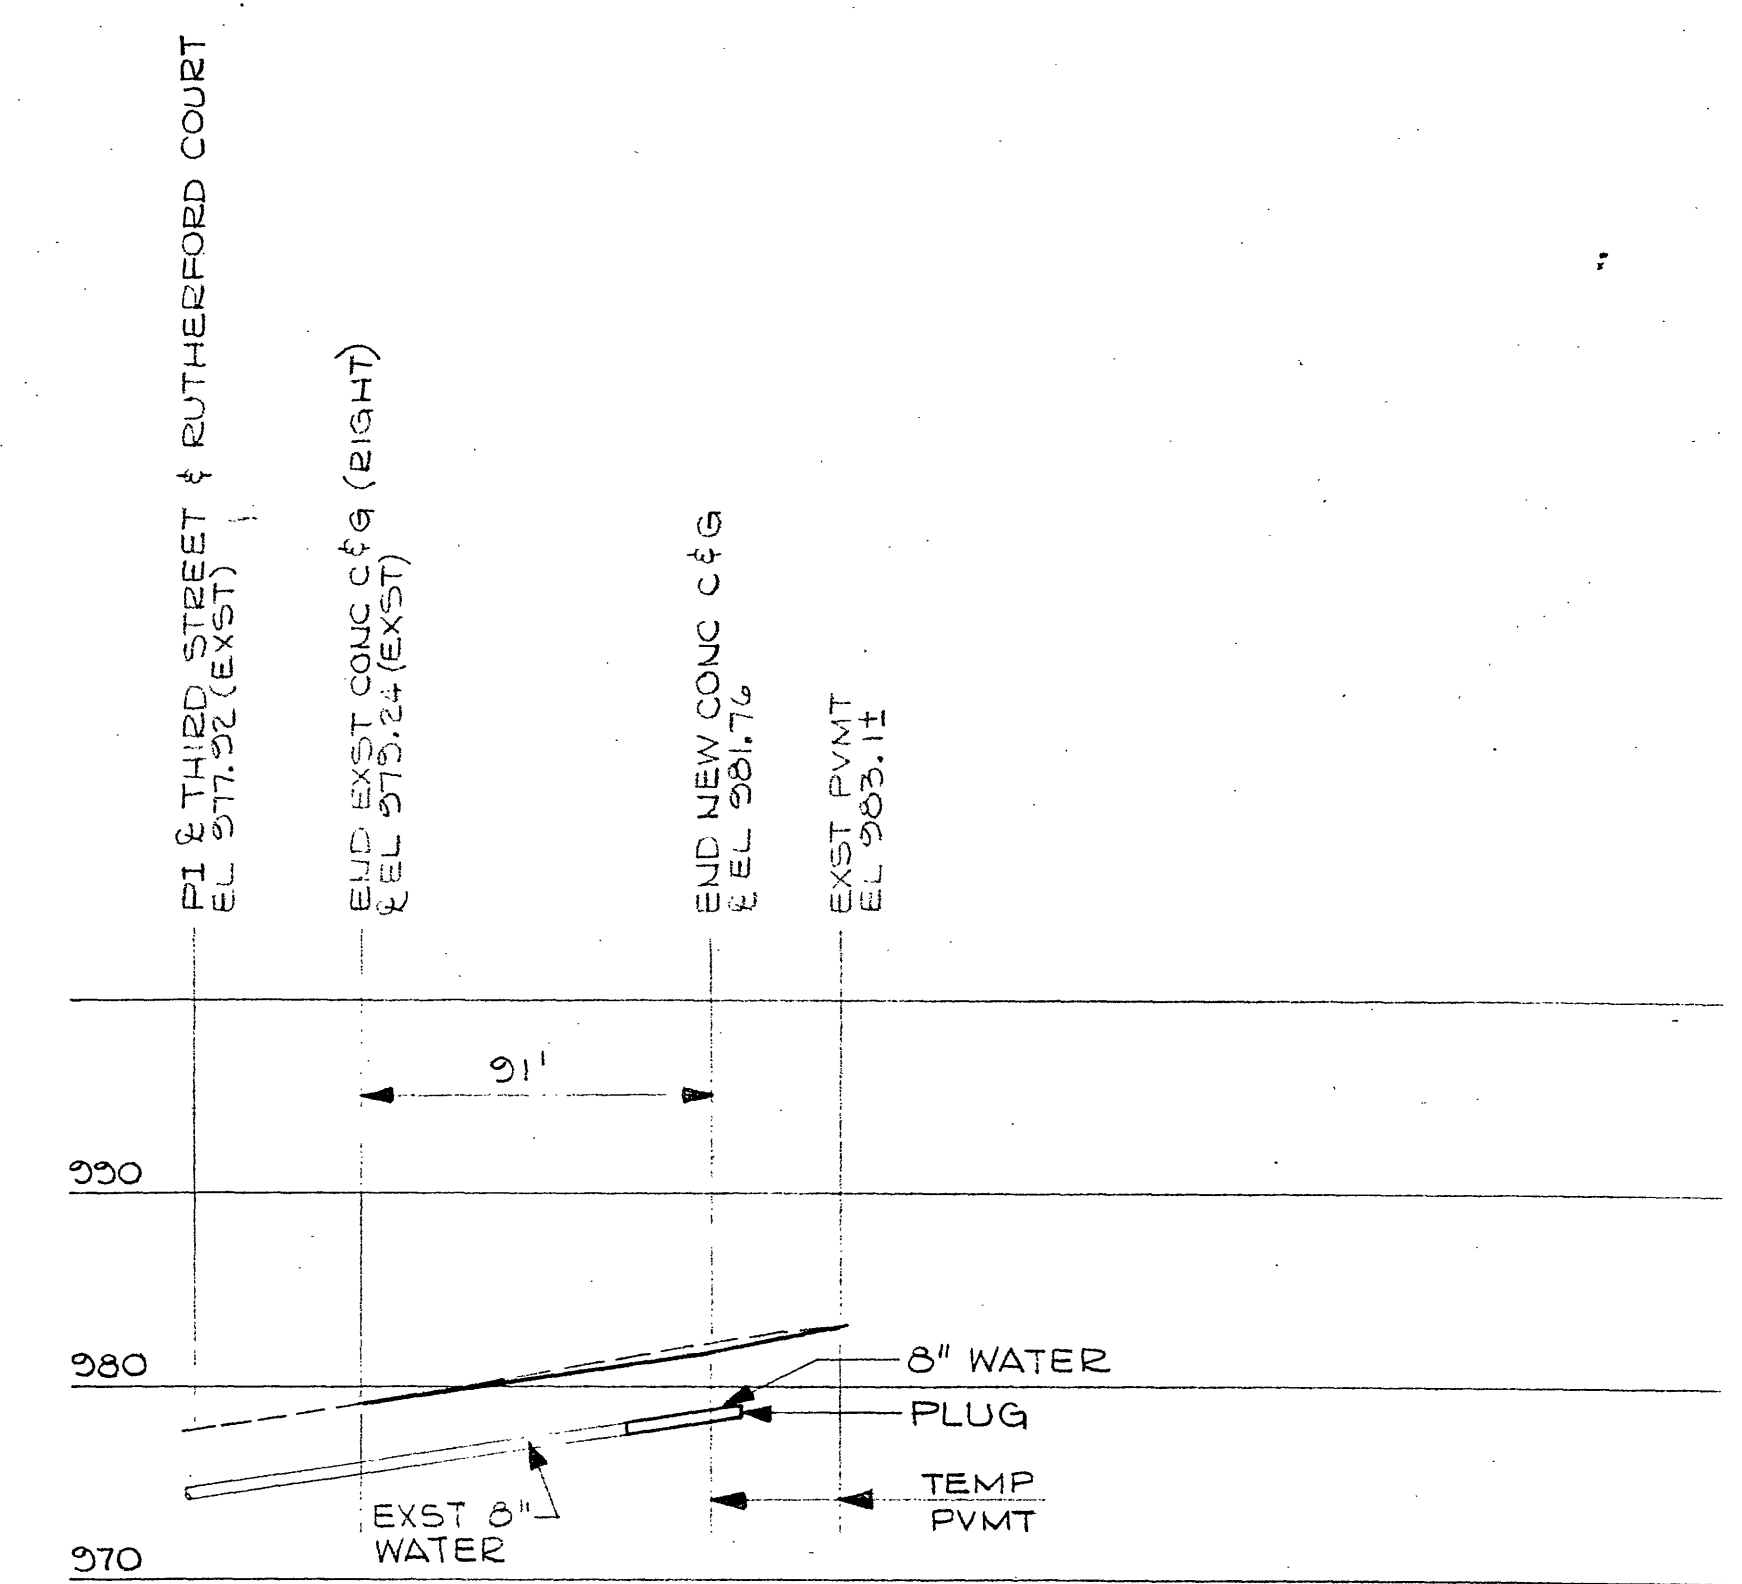

THIRD STREET &
STREET & WATER PROFILES
SCALE - HORIZ. 1" = 50'
VERT. 1" = 10'

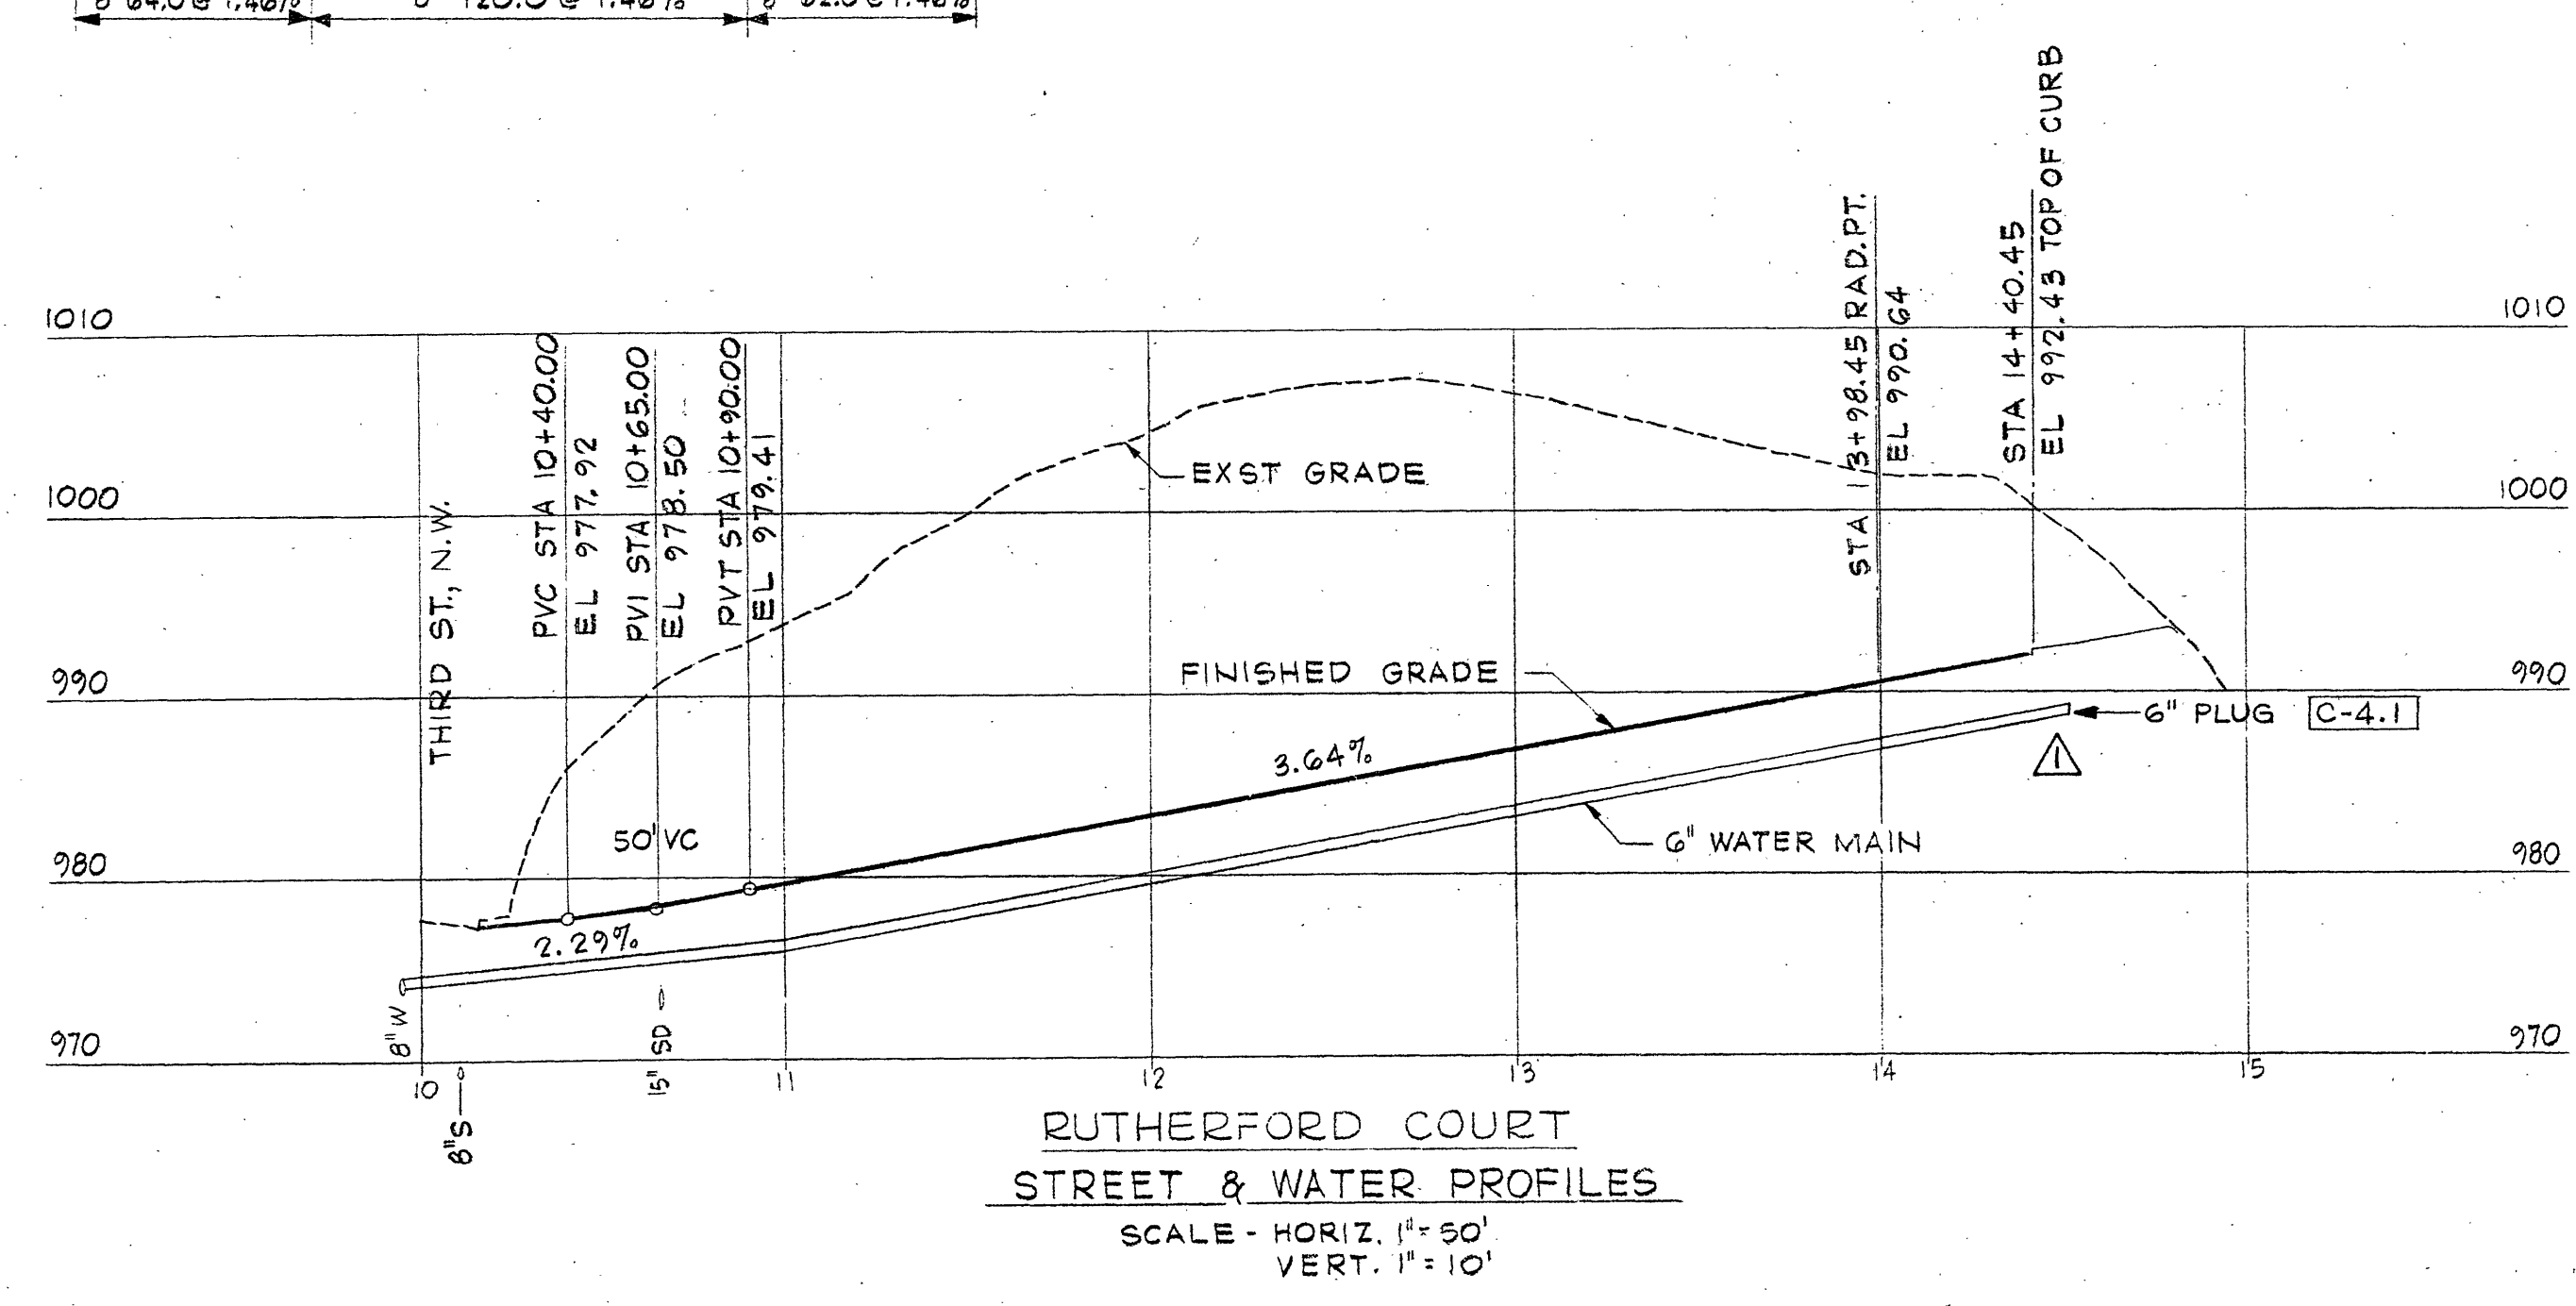

RUTHERFORD COURT
STREET & WATER PROFILES
SCALE - HORIZ. 1" = 50'
VERT. 1" = 10'

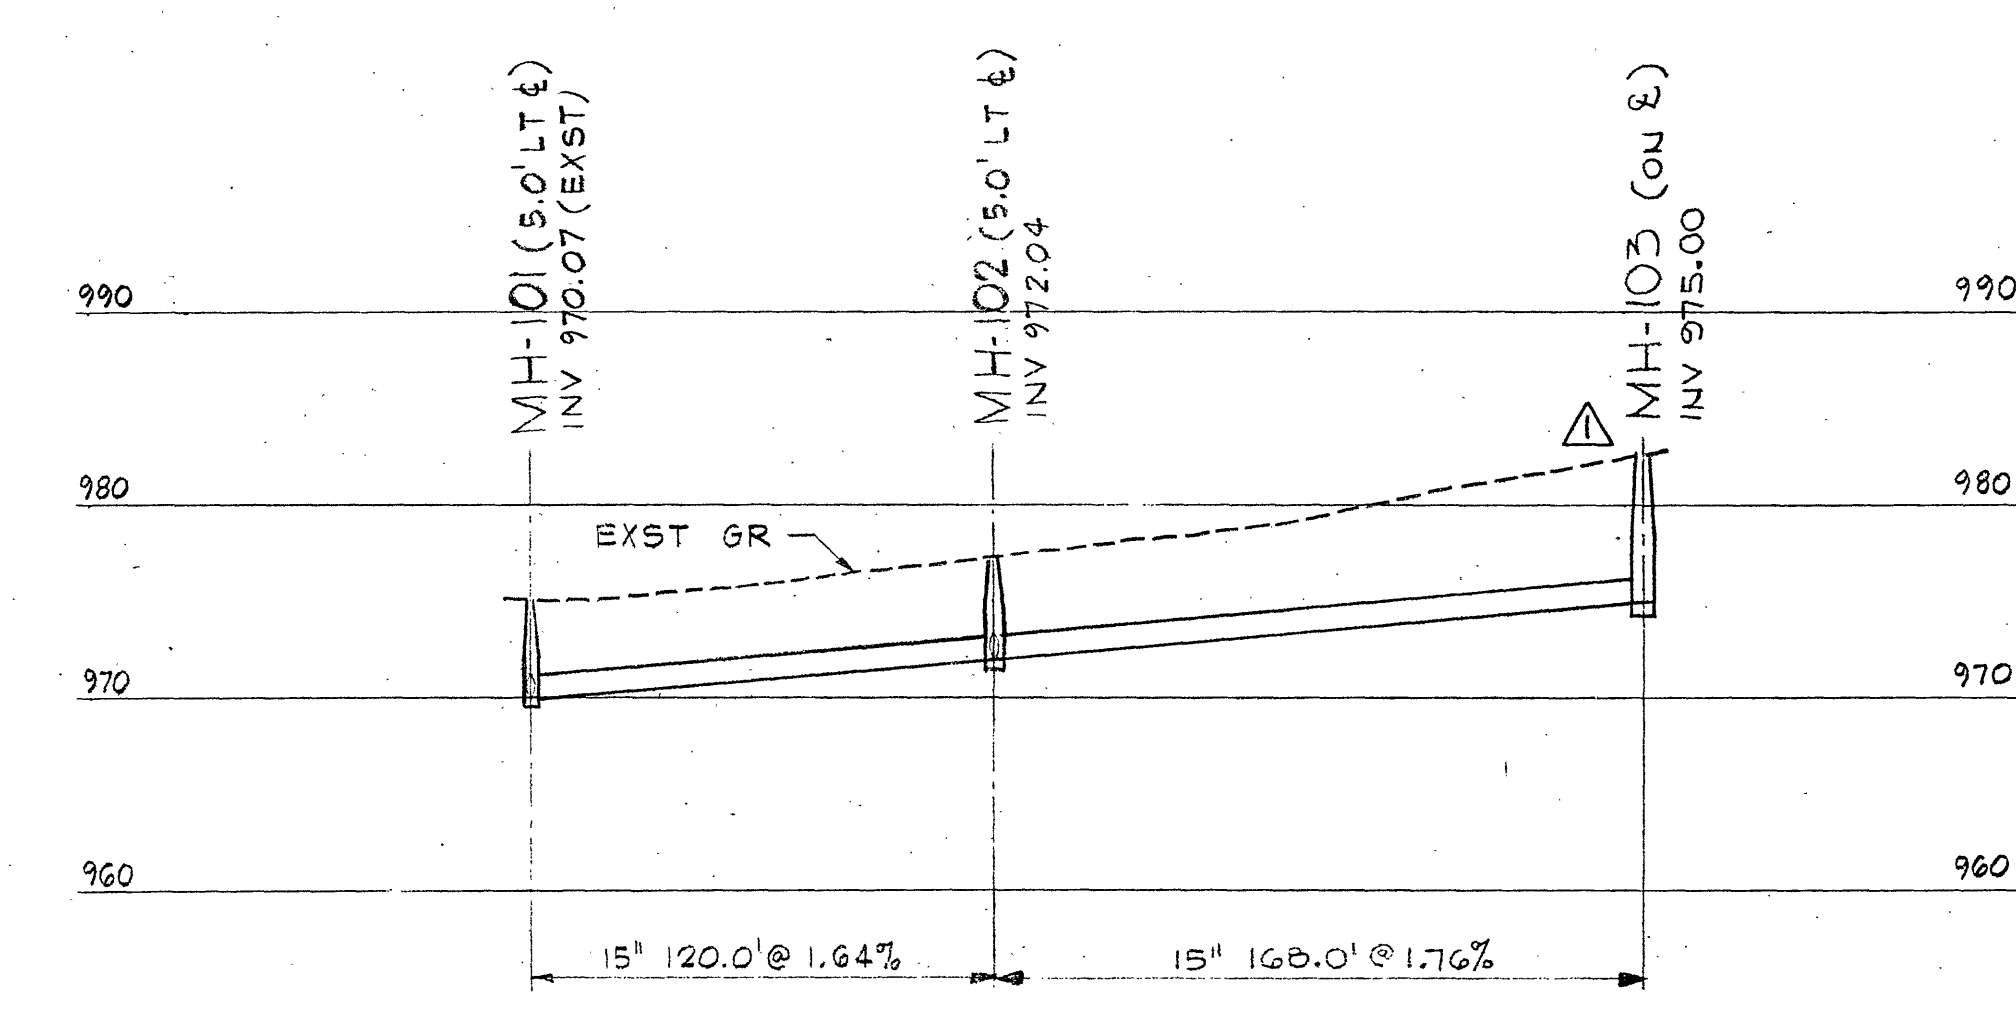

STORM DRAIN PROFILE
SCALE - HORIZ. 1" = 50'
VERT. 1" = 10'

REVISION	DATE	DESCRIPTION	BY	APP.
1	6-3-81	REVISE LOT LAYOUT & WATER & SEWER CONNECT. JOUS. ADD WATER & SEWER MAINS & MH ON EXST SEWER	JWB	
DESIGNED	JHW	SITE IMPROVEMENTS CONTRACT SI-5 SECTION NINE GAINSBORO COMMUNITY DEVELOPMENT PROGRAM SANITARY SEWER & WATER PLAN AND PROFILES		
DRAWN	JHW			
CHECKED	WMZ			
APPROVED	WMZ			
SUBMITTED	JWB			
HAYES, SEAY, MATTERN & MATTERN ARCHITECTS - ENGINEERS - PLANNERS ROANOKE, VIRGINIA		SCALE AS NOTED	COMM. NO. 3756J	
		DATE JAN 30, 1981	SHEET 2	