


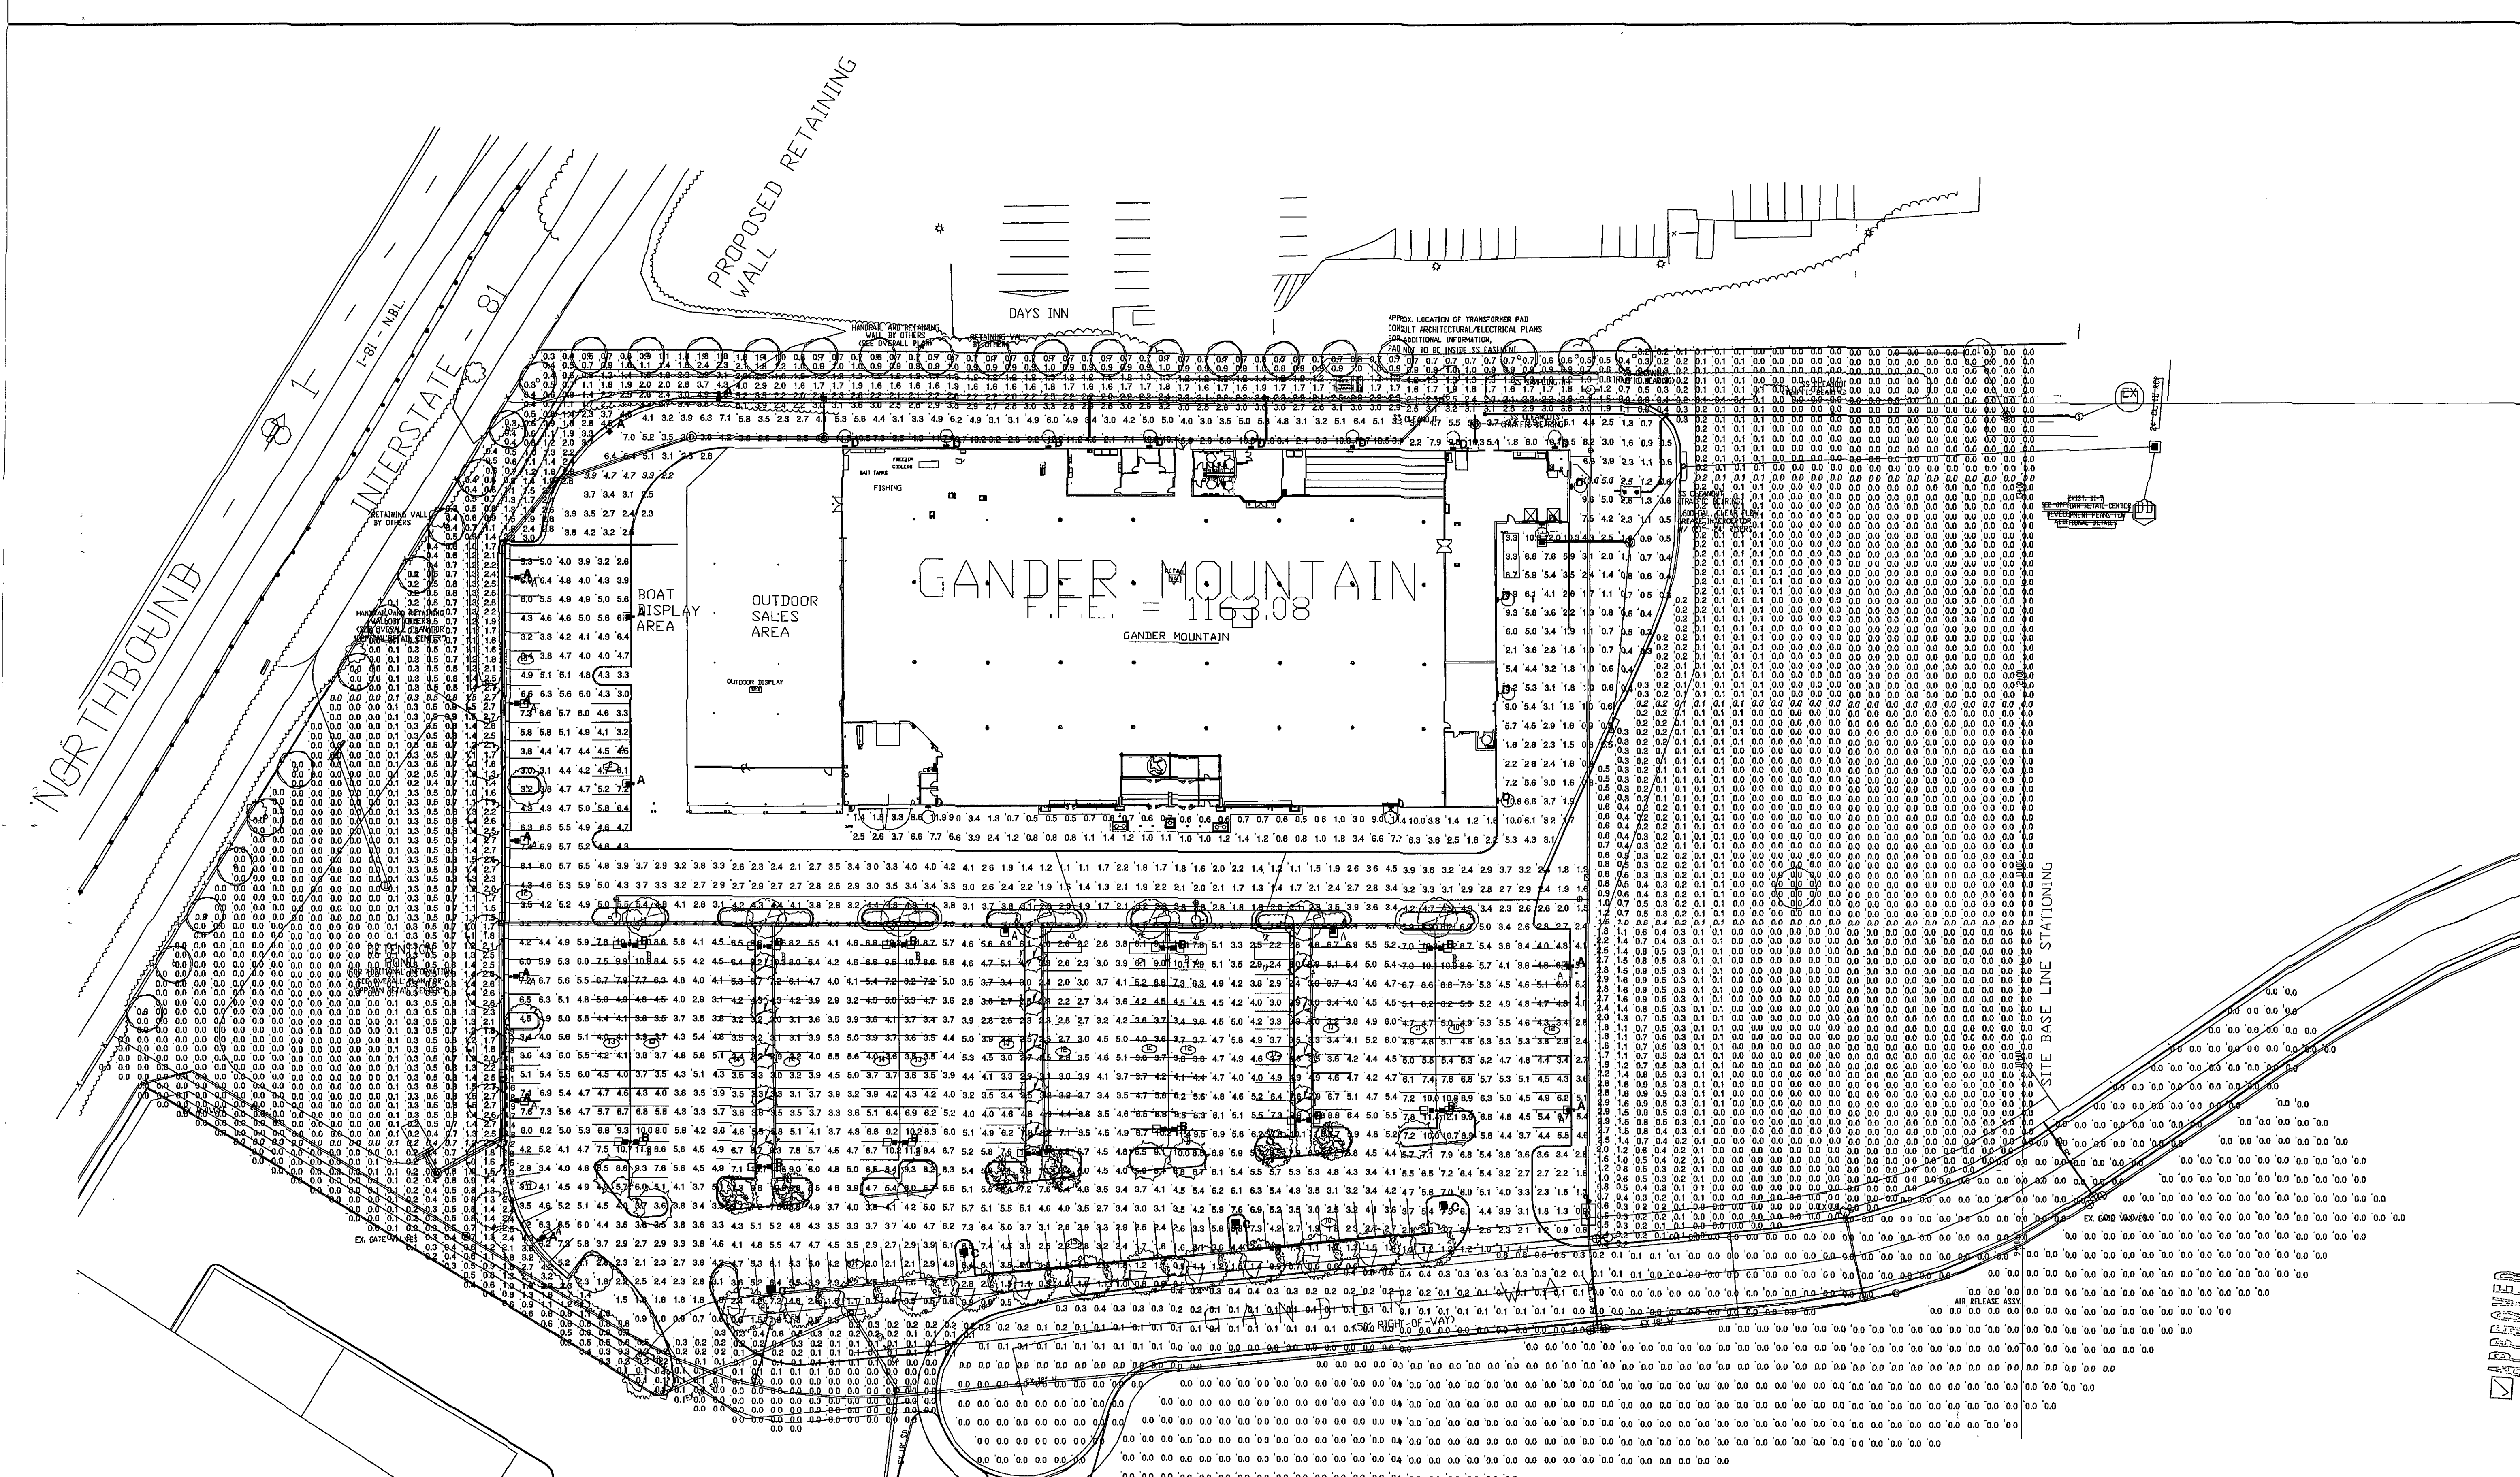

Lawrence Perry & Associates, Inc.
Mechanical and Electrical Engineers
30 W. Church Avenue
Roanoke, Virginia 24011
PH: (540) 541-1814
FAX: (540) 541-1810
©2001 Lawrence Perry and Associates, Inc.

GANDER MOUNTAIN AT THE OPIDAN RETAIL CENTER SITE LIGHTING CALCULATION

Designer
RWH
Date
10-16-07
Scale
1" = 40'-0"
Drawing No.
E-1 OF 3

LUMINAIRE SCHEDULE									
Symbol	Label	Qty	Catalog Number	Description	Lamp	File	Lumens	LLF	Watts
■	A	14	EALM-400-3V W/FCO SHIELD	EAL SERIES 400W MH, TYPE 3 OPTICS, W/FCO SHIELD		EALM403F.IE S	36000	0.75	465
■	B	12	EALM-400-3V W/FCO SHIELD	EAL SERIES 400W MH, TYPE 3 OPTICS, W/FCO SHIELD		EALM403F.IE S	36000	0.75	930
■	C	4	EALM-400-4V W/FCO SHIELD AND GLARE SHIELD	EAL SERIES 400W MH, TYPE 4 OPTICS, W/FCO SHIELD AND GLARE SHIELD		EALM404S.IE S	36000	0.75	465
■	D	15	TWH 250M	GENERAL PURPOSE BUILDING MOUNTED LUMINAIRE, 250W MH, W/ CLEAR LAMP.	ONE 250-WATT CLEAR ED-28 METAL HALIDE, HORIZONTAL POSITION.	95011902.IES	20500	0.75	297