



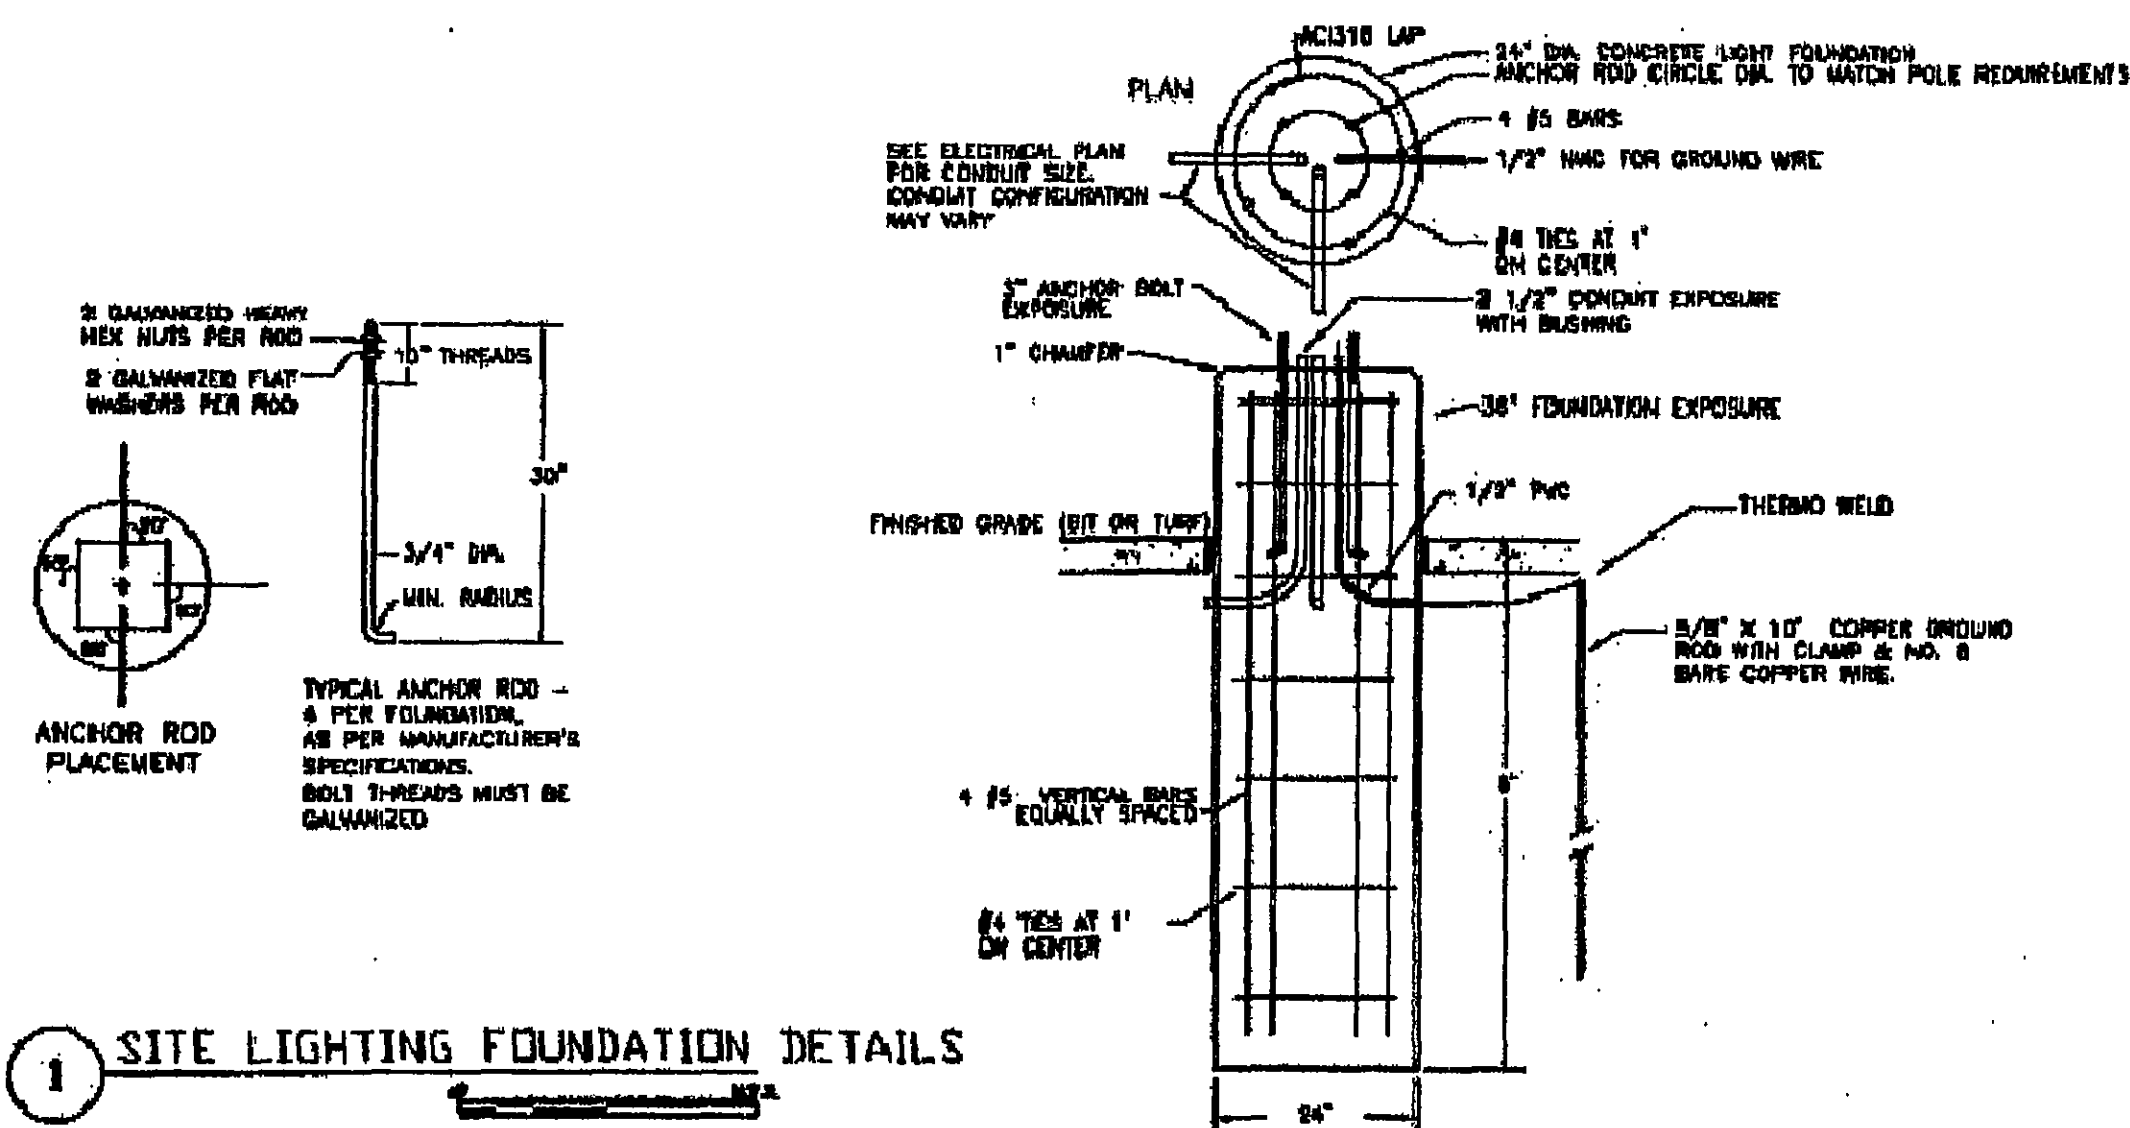

LIGHTING FIXTURE SCHEDULE				
TYPE	MOUNTING	LAMP	DESCRIPTION	REMARKS
A	POLE	1-400W MH	WIDELITE ELAM-400-3V-480-S-F2 AND FCD SHIELD. 22 FOOT SQUARE STRAIGHT STEEL POLE WITH FULL BASE COVER.	
B	POLE	2-400W MH	2 WIDELITE ELAM-400-3V-480-S-F2 AND FCD SHIELD. 22 FOOT SQUARE STRAIGHT STEEL POLE WITH FULL BASE COVER.	


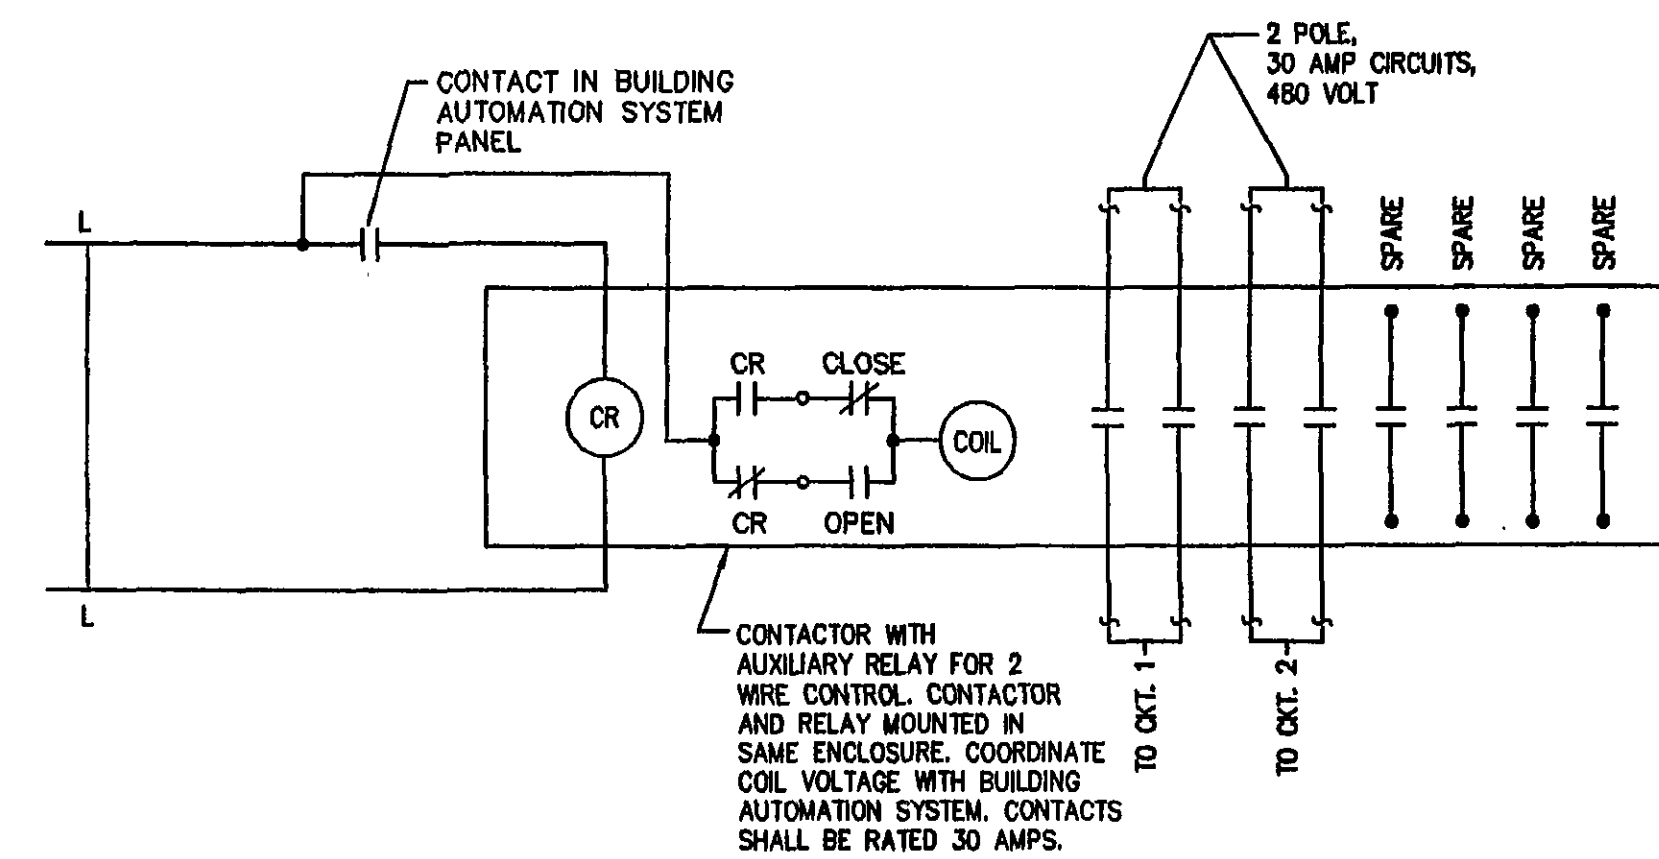


WIRING DIAGRAM FOR
LIGHTING CONTACTOR LC-1
NO SCALE

APPROVED

LAWRENCE PERRY & ASSOCIATES, INC. CONSULTING ENGINEERS ROANOKE, VA.		DATE: AUGUST 13, 2007 SCALE: 1" = 40'0"
DESIGNER: RWI DRAWN: RWI COMM. NO: 07108.01	CHECKED: WDC DATE: 08-13-07	COMMISSION NO: 07108.01 SHEET E-3 OF 3

LUMSDEN ASSOCIATES, P.C.
 ENGINEERS-SURVEYORS-PLANNERS
 ROANOKE, VIRGINIA

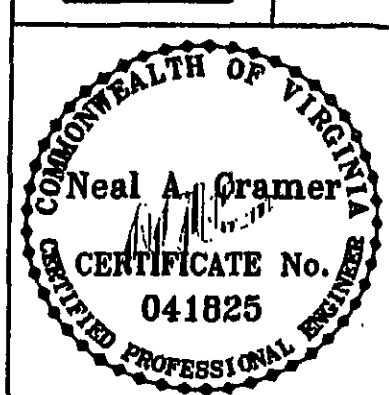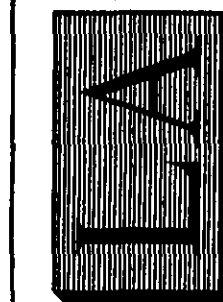

FIXTURE SCHEDULE
AND DETAILS

GANDER MOUNTAIN
 AT THE OPPIDAN RETAIL CENTER
 PREPARED FOR
OPPIDAN INVESTMENT COMPANY
 HOLLINS MAGISTERIAL DISTRICT
 ROANOKE COUNTY, VIRGINIA

NO.	DATE	DESCRIPTION
1		
2		
3		
4		
5		

PHONE: (540) 774-4411
 FAX: (540) 772-9445
 E-MAIL: MAIL@LUMSDENPC.COM

4664 BRAMBLETON AVENUE
 P.O. BOX 20569
 ROANOKE, VIRGINIA 24018