


PROJECT LOCATION MAP

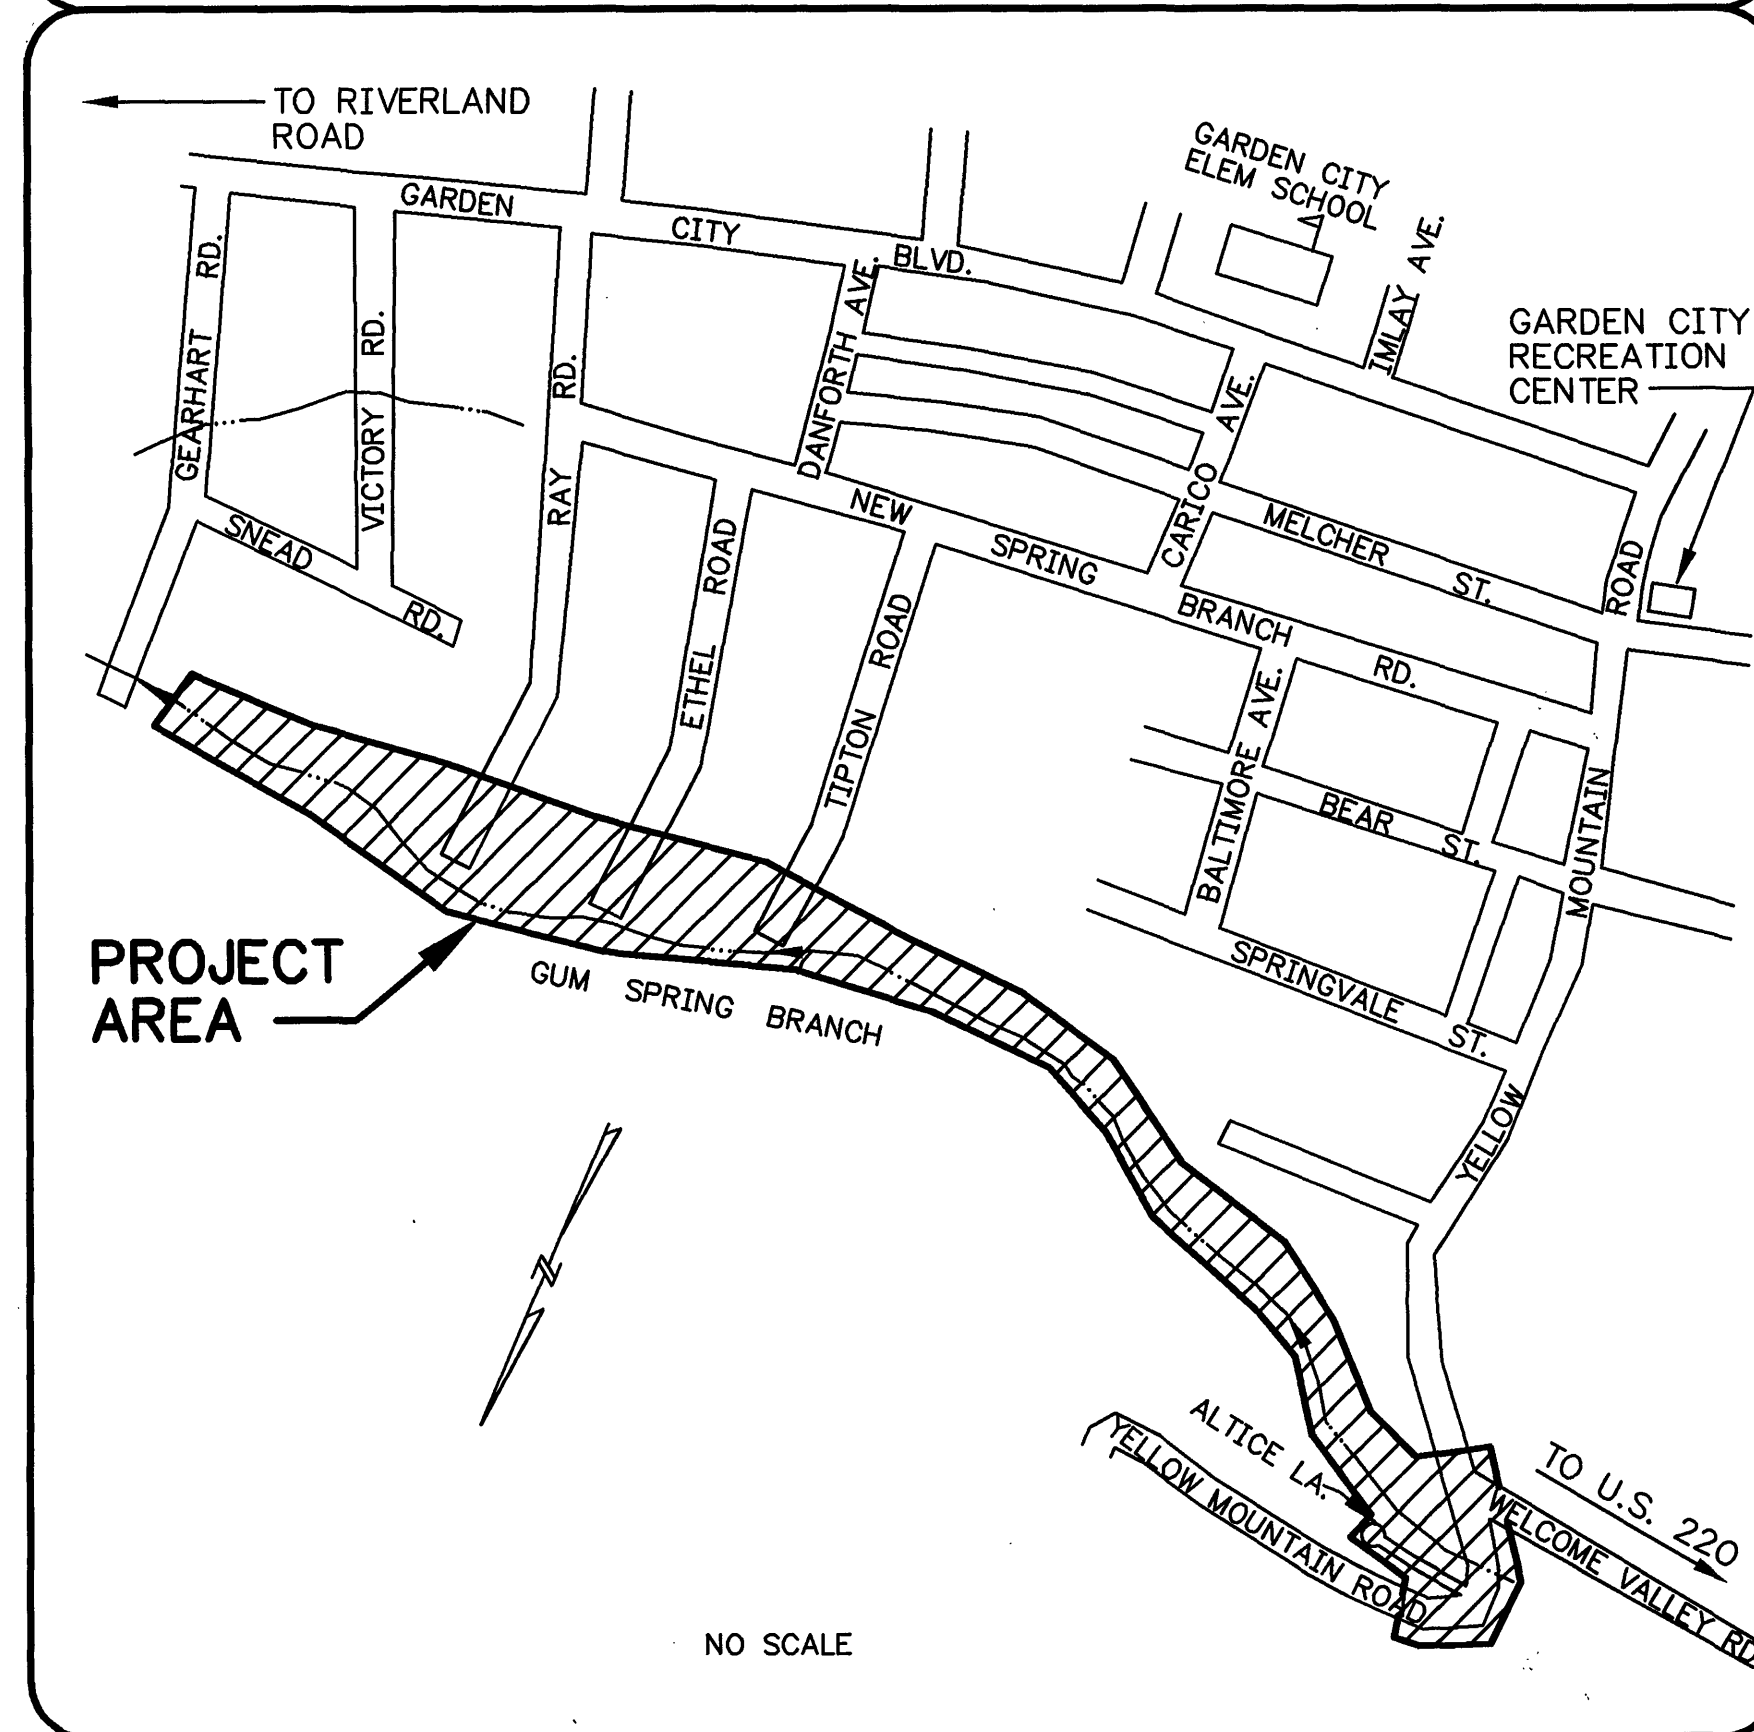

OFFICE OF CITY ENGINEER
ROOM 350
MUNICIPAL BUILDING
215 CHURCH AVENUE, S.W.
ROANOKE, VIRGINIA 24011

INDEX OF SHEETS

1. TITLE
2. ABBREVIATIONS, LEGEND & SUMMARY OF QUANTITIES
3. SHEET INDEX & GENERAL NOTES
4. PLAN AND PROFILE
5. PLAN AND PROFILE
6. PLAN AND PROFILE
7. PLAN AND PROFILE

CONSULTING ENGINEERS

HAYES, SEAY, MATTERN AND MATTERN
ARCHITECTS - ENGINEERS - PLANNERS

1315 FRANKLIN ROAD
ROANOKE, VIRGINIA

COMMISSION NUMBER: 7122B

PROJECT NAME

SEWER REPLACEMENT PROJECT GC-1
GARDEN CITY SEWERSHED
ROANOKE, VIRGINIA

PROJECT NUMBER: 6272

REVISION BY	DESCRIPTION: RECORD DRAWINGS PREPARED FROM DRAWINGS AND INFORMATION PROVIDED BY PRILLAMAN AND PACE, INC.	JULY 8 1997 DATE
REVISION BY	DESCRIPTION:	DATE
REVISION BY	DESCRIPTION:	DATE
REVISION BY	DESCRIPTION:	DATE

RECORD DRAWING

APPROVED FOR CONSTRUCTION

ROANOKE CITY ENGINEER

DATE

DIRECTOR OF PUBLIC WORKS

DATE

DIRECTOR OF UTILITIES AND OPERATIONS

DATE

DATE

DATE

ADVERTISED DATE: JUNE 23 1996

SET NUMBER:

SHEET NUMBER: 1 OF 7