
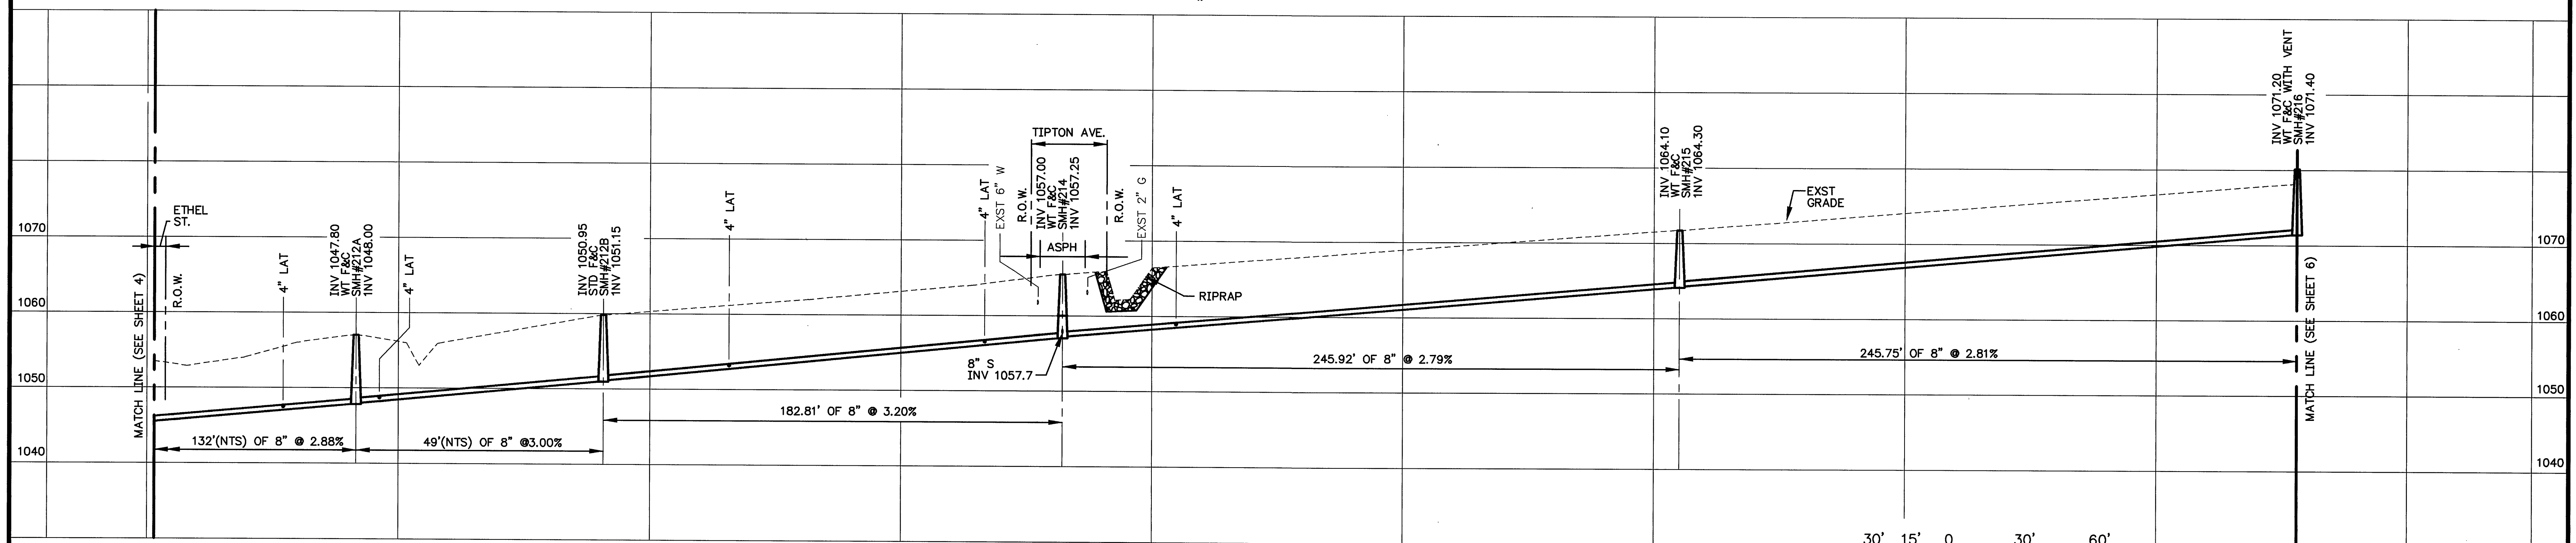


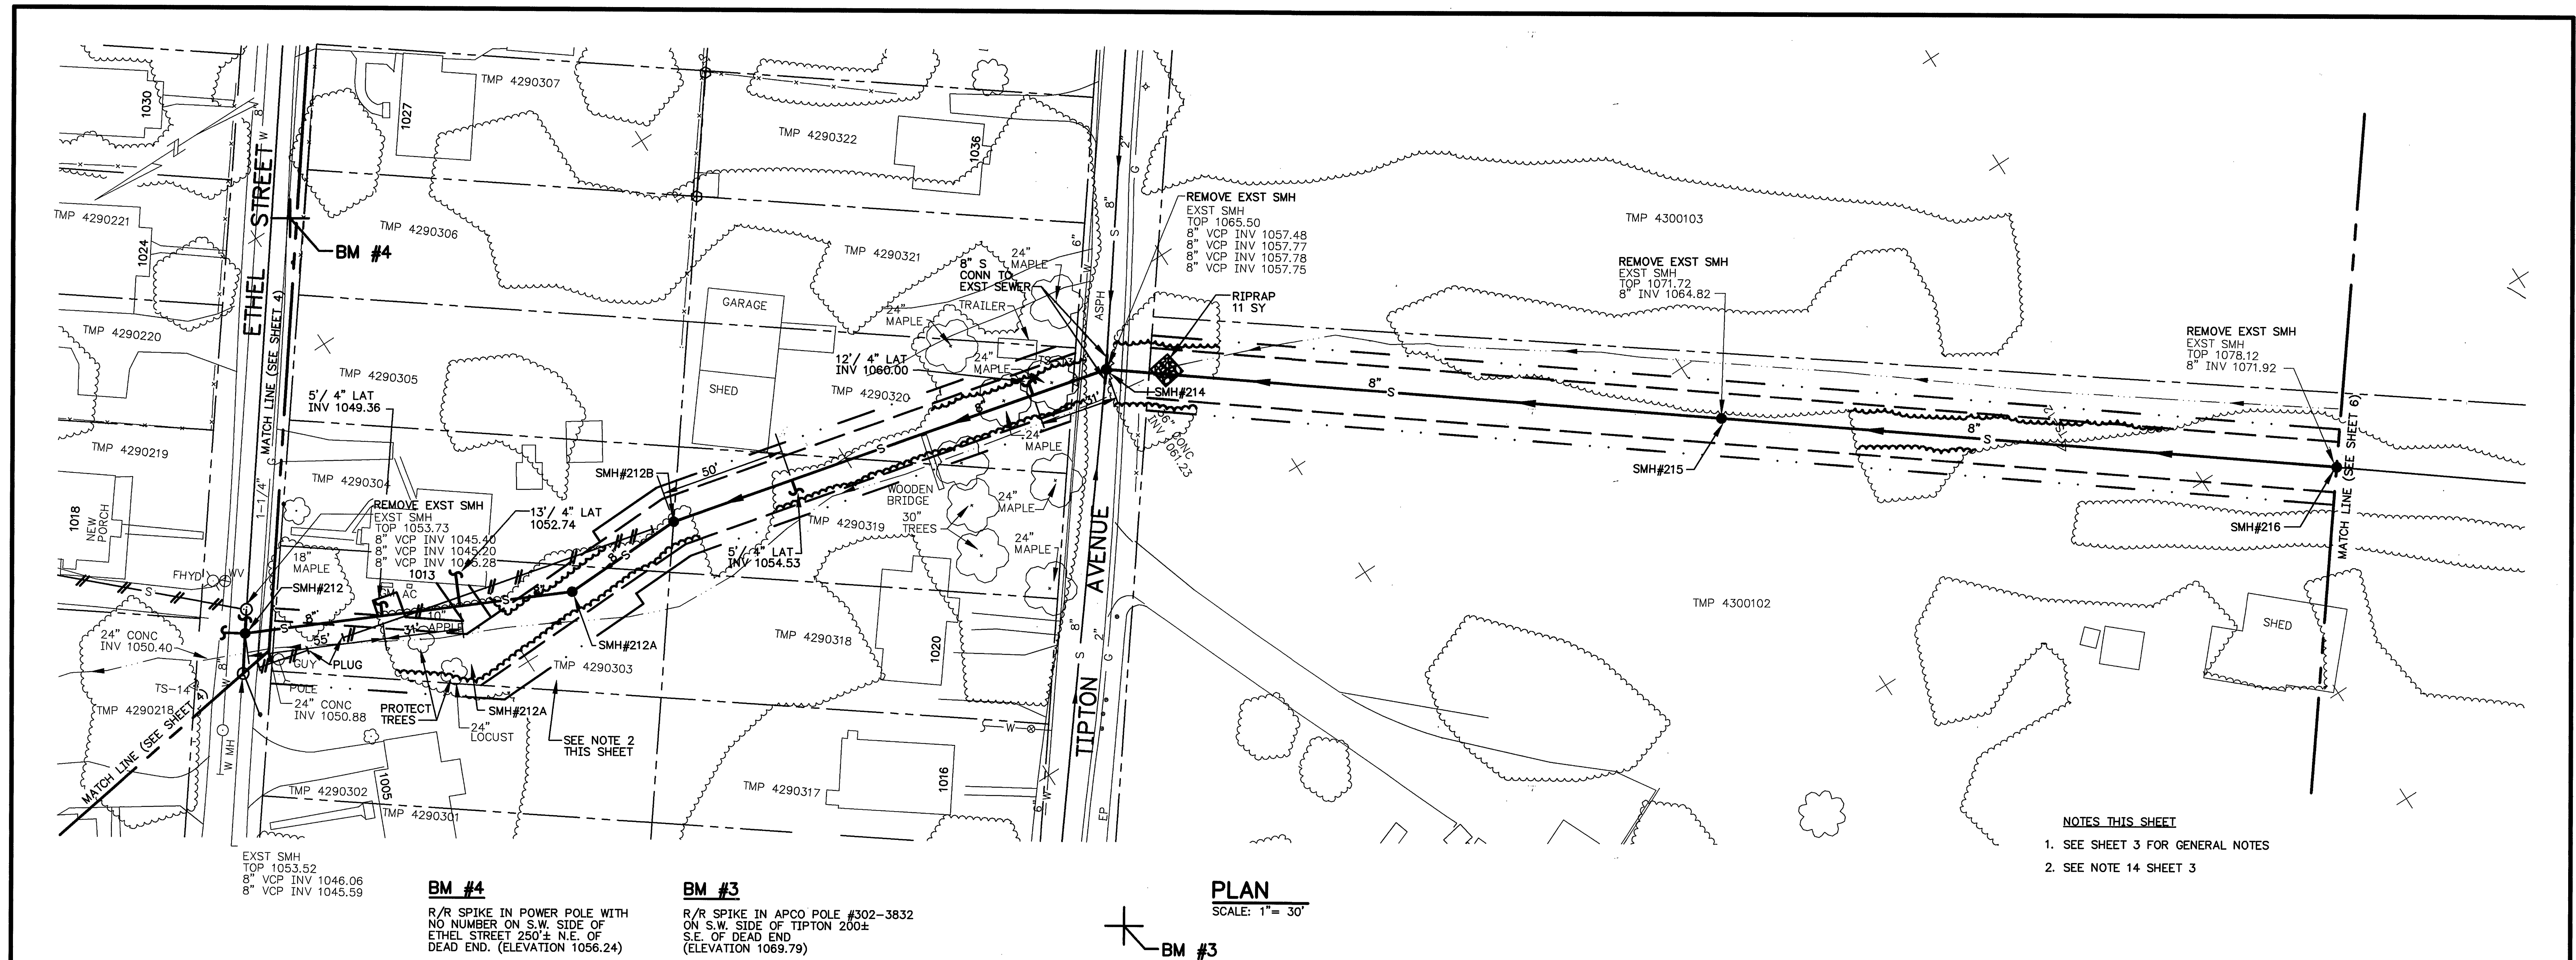

1" = 30' 1" = 10'		1" = 30' 1" = 10'																								
		GRAPHIC SCALES																								
HAYES, SEAY, MATTERN AND MATTERN ARCHITECTS/ENGINEERS/PLANNERS		DESIGNED: DMC DRAWN: DMC CHECKED: DMH APPROVED: DMH	REVISIONS <table><thead><tr><th>DATE</th><th>BY</th><th>DESCRIPTION</th></tr></thead><tbody><tr><td>7/3/97</td><td>DMC</td><td>RECORD DRAWINGS PREPARED FROM DRAWINGS AND INFORMATION PROVIDED BY PRILLAMAN AND PACE, INC</td></tr><tr><td></td><td></td><td></td></tr><tr><td></td><td></td><td></td></tr><tr><td></td><td></td><td></td></tr><tr><td></td><td></td><td></td></tr><tr><td></td><td></td><td></td></tr></tbody></table>	DATE	BY	DESCRIPTION	7/3/97	DMC	RECORD DRAWINGS PREPARED FROM DRAWINGS AND INFORMATION PROVIDED BY PRILLAMAN AND PACE, INC																SEWER REPLACEMENT PROJECT GC-1 GARDEN CITY SEWERSHED ROANOKE, VIRGINIA PLAN AND PROFILE COMM. NO.: 7122B SCALE: AS NOTED DATE: JUNE 19 1996	SHEET NO. 5
				DATE	BY	DESCRIPTION																				
7/3/97	DMC	RECORD DRAWINGS PREPARED FROM DRAWINGS AND INFORMATION PROVIDED BY PRILLAMAN AND PACE, INC																								