


PLAN SHEET NO. 88-02-S
 NOTE BOOK ALIGNMENT CHECKED BY [Signature]
 No. [Number]

PROFILE SHEET NO. 88-02-S
 NOTE BOOK GRADE CHECKED BY [Signature]
 No. [Number]

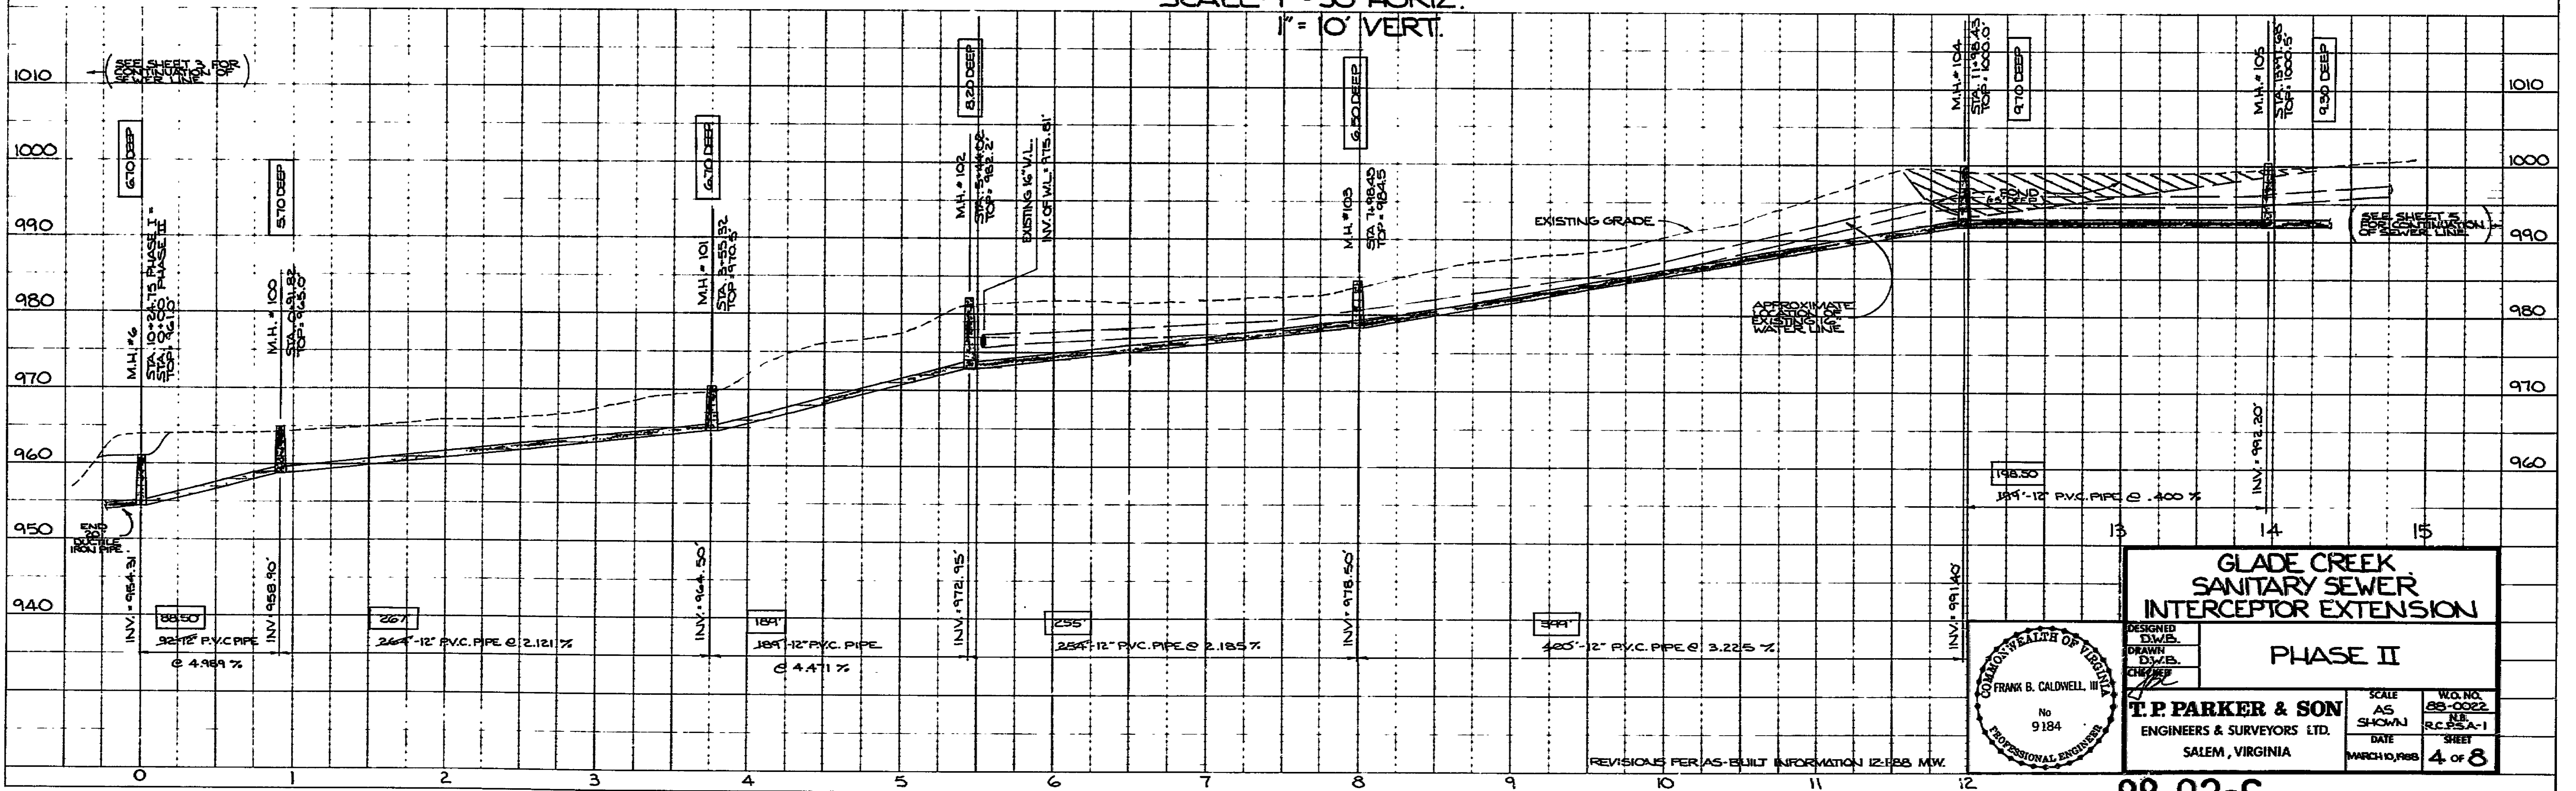

**GLADE CREEK
 SANITARY SEWER
 INTERCEPTOR EXTENSION**

PHASE II

DESIGNED BY: FRANK B. CALDWELL, III
 DRAWN BY: [Signature]
 CHECKED BY: [Signature]

T.P. PARKER & SON
 ENGINEERS & SURVEYORS LTD.
 SALEM, VIRGINIA

SCALE: AS SHOWN
 DATE: MARCH 10, 1988

NO. 88-02-S
 SHEET 4 OF 8

PLATE 1-SINGLE PLAN AND PROFILE FULL LINE
 PRINTED IN U.S.A.

