


MATCH LINE SEE SHEET #4

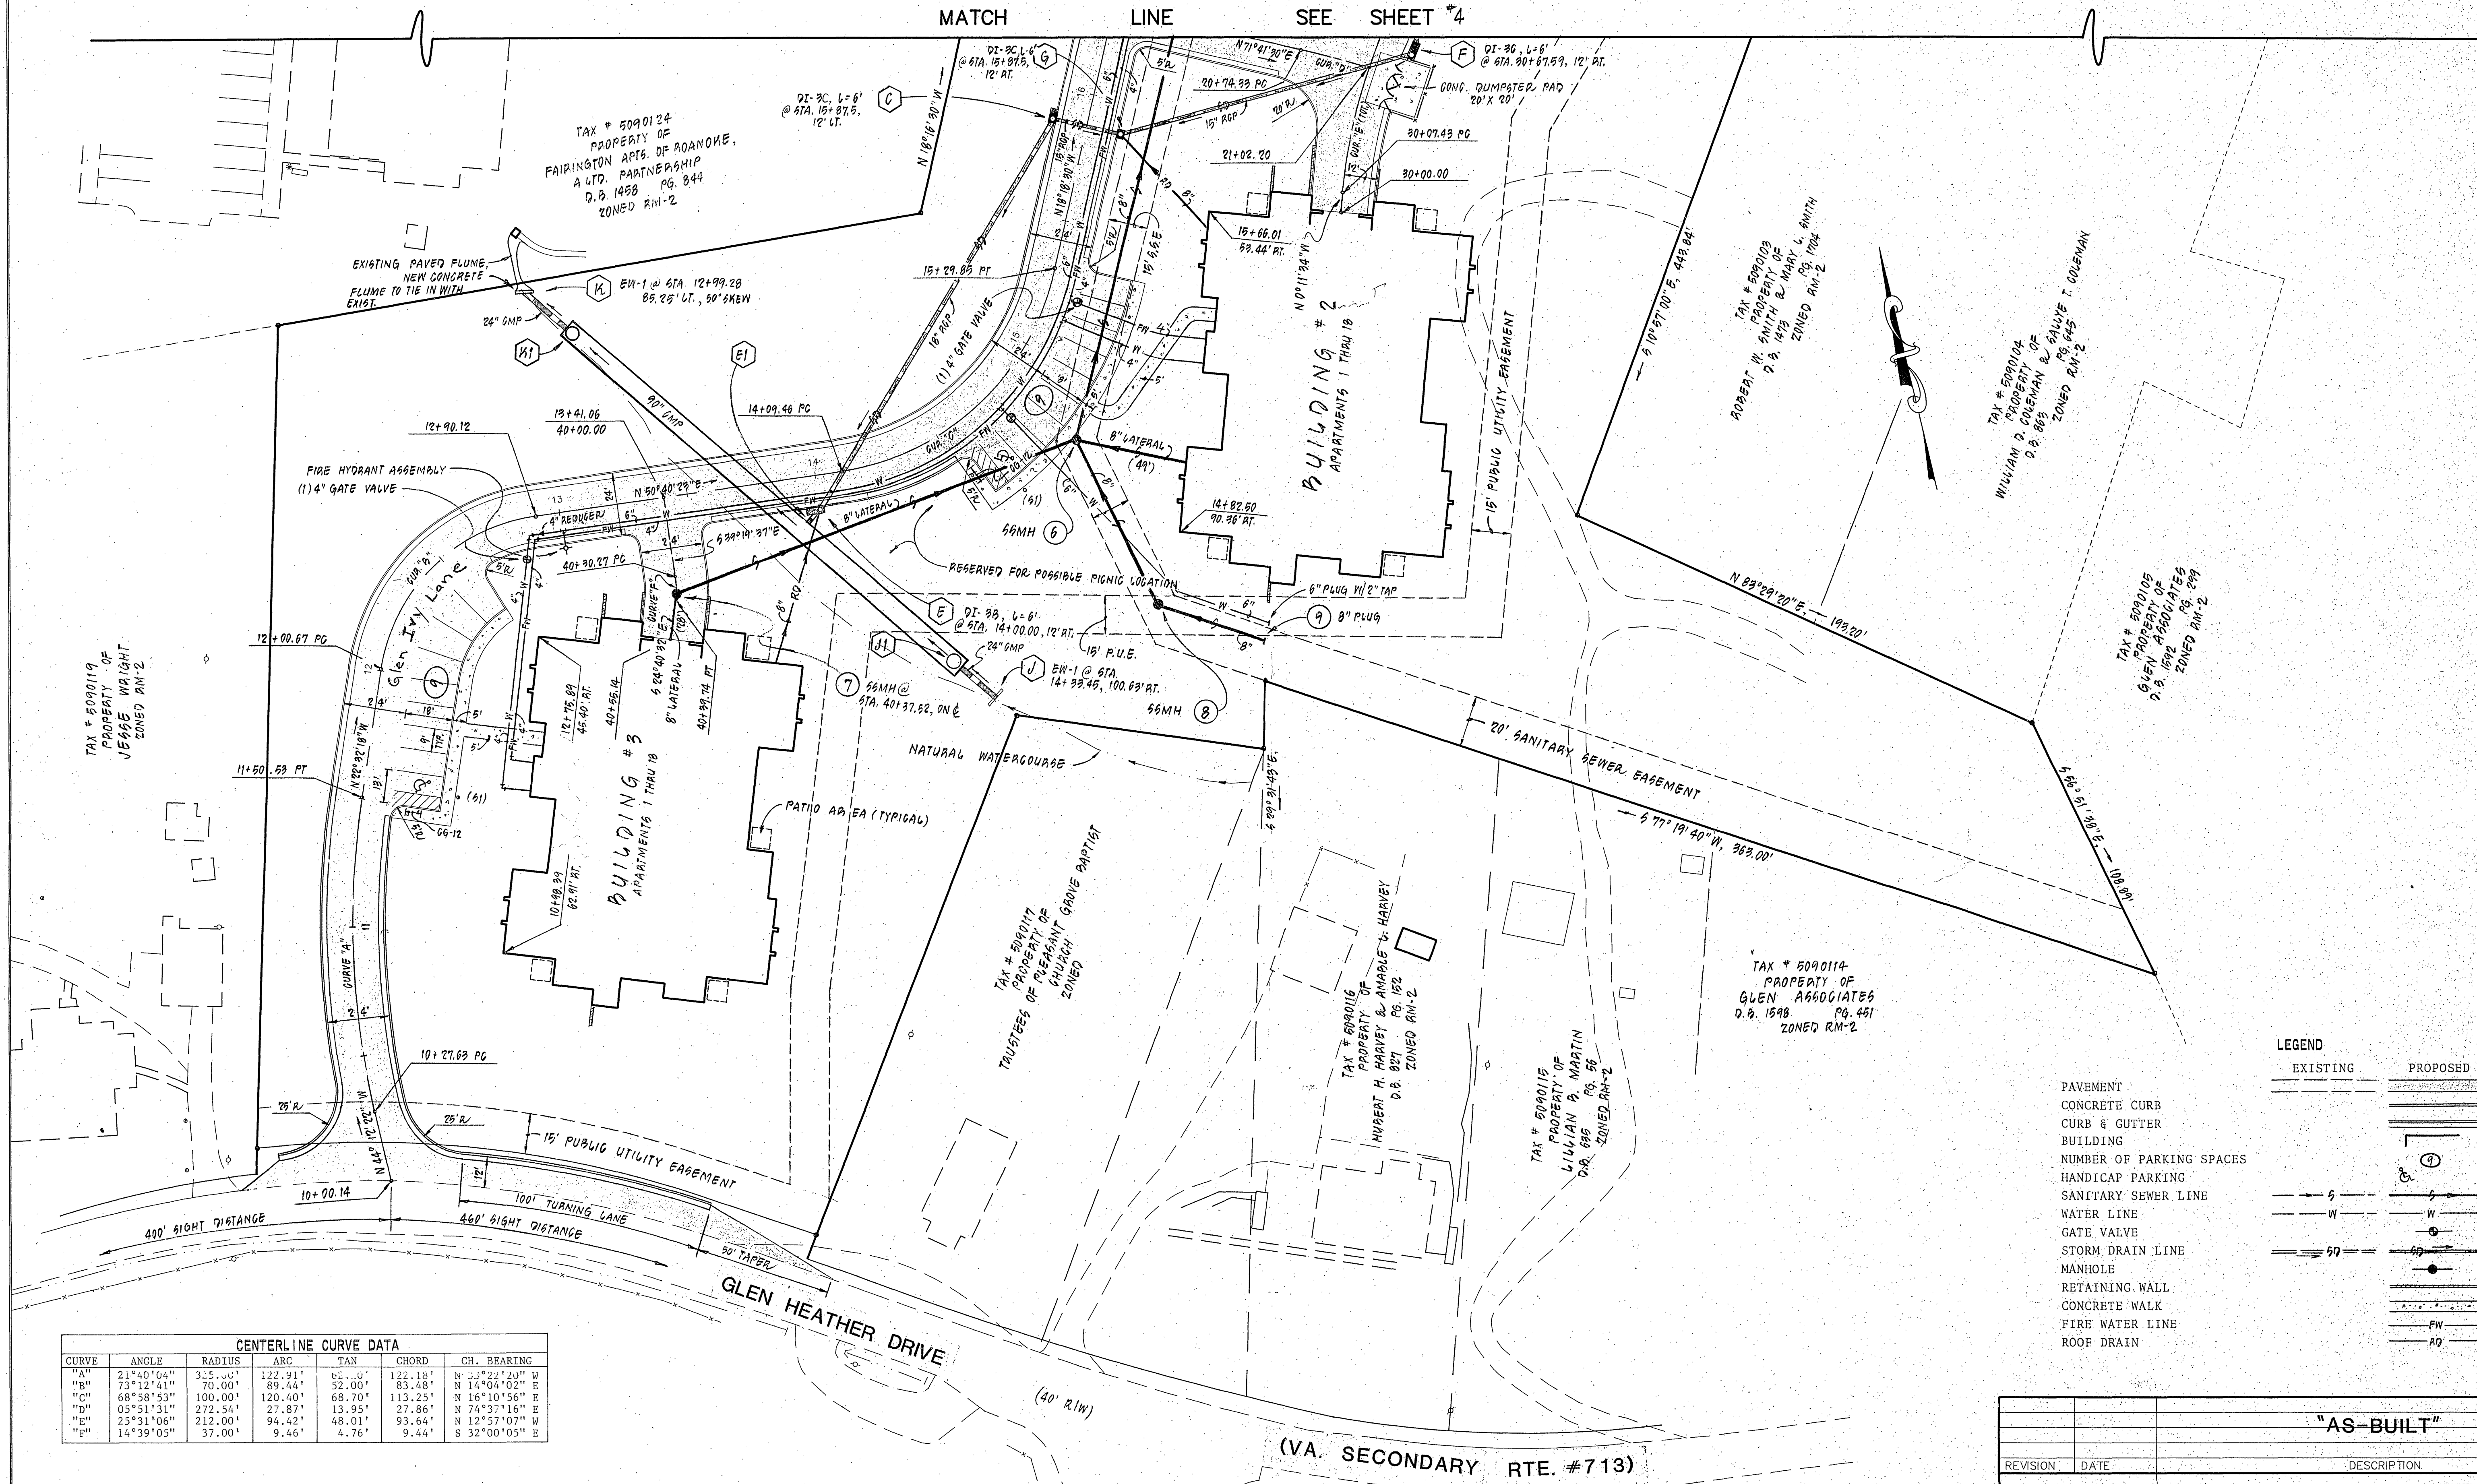

CENTERLINE CURVE DATA						
CURVE	ANGLE	RADIUS	ARC	TAN	CHORD	CH. BEARING
"A"	21°40'04"	325.00'	122.91'	85.00'	122.18'	N 72°22'20" W
"B"	73°12'41"	70.00'	89.44'	32.00'	83.48'	N 14°04'02" E
"C"	68°58'53"	100.00'	120.40'	68.70'	113.25'	N 16°10'56" E
"D"	05°51'31"	272.54'	27.87'	13.95'	27.86'	N 74°37'16" E
"E"	25°31'06"	212.00'	94.42'	48.01'	93.64'	N 12°57'07" W
"F"	14°39'05"	37.00'	9.46'	4.76'	9.44'	S 32°00'05" E

LEGEND	
EXISTING	PROPOSED
PAVEMENT	
CONCRETE CURB	
CURB & GUTTER	
BUILDING	
NUMBER OF PARKING SPACES	
HANDICAP PARKING	
SANITARY SEWER LINE	
WATER LINE	
GATE VALVE	
STORM DRAIN LINE	
MANHOLE	
RETAINING WALL	
CONCRETE WALK	
FIRE WATER LINE	
ROOF DRAIN	

"AS-BUILT"		
REVISION	DATE	DESCRIPTION
DESIGNED	LWH	DIMENSIONAL LAYOUT & UTILITY PLAN FOR "GLEN IVY" PREPARED FOR RADFORD & COMPANY ROANOKE, VIRGINIA
DRAWN	PVA, RAG	
CHECKED	MSH	
LUMSDEN ASSOCIATES, P.C. ENGINEERS-SURVEYORS-PLANNERS ROANOKE, VIRGINIA		SCALE: 1" = 30' DATE: 1 MAR. 1995 COMM: #94-53 SHEET 3 of 15

