



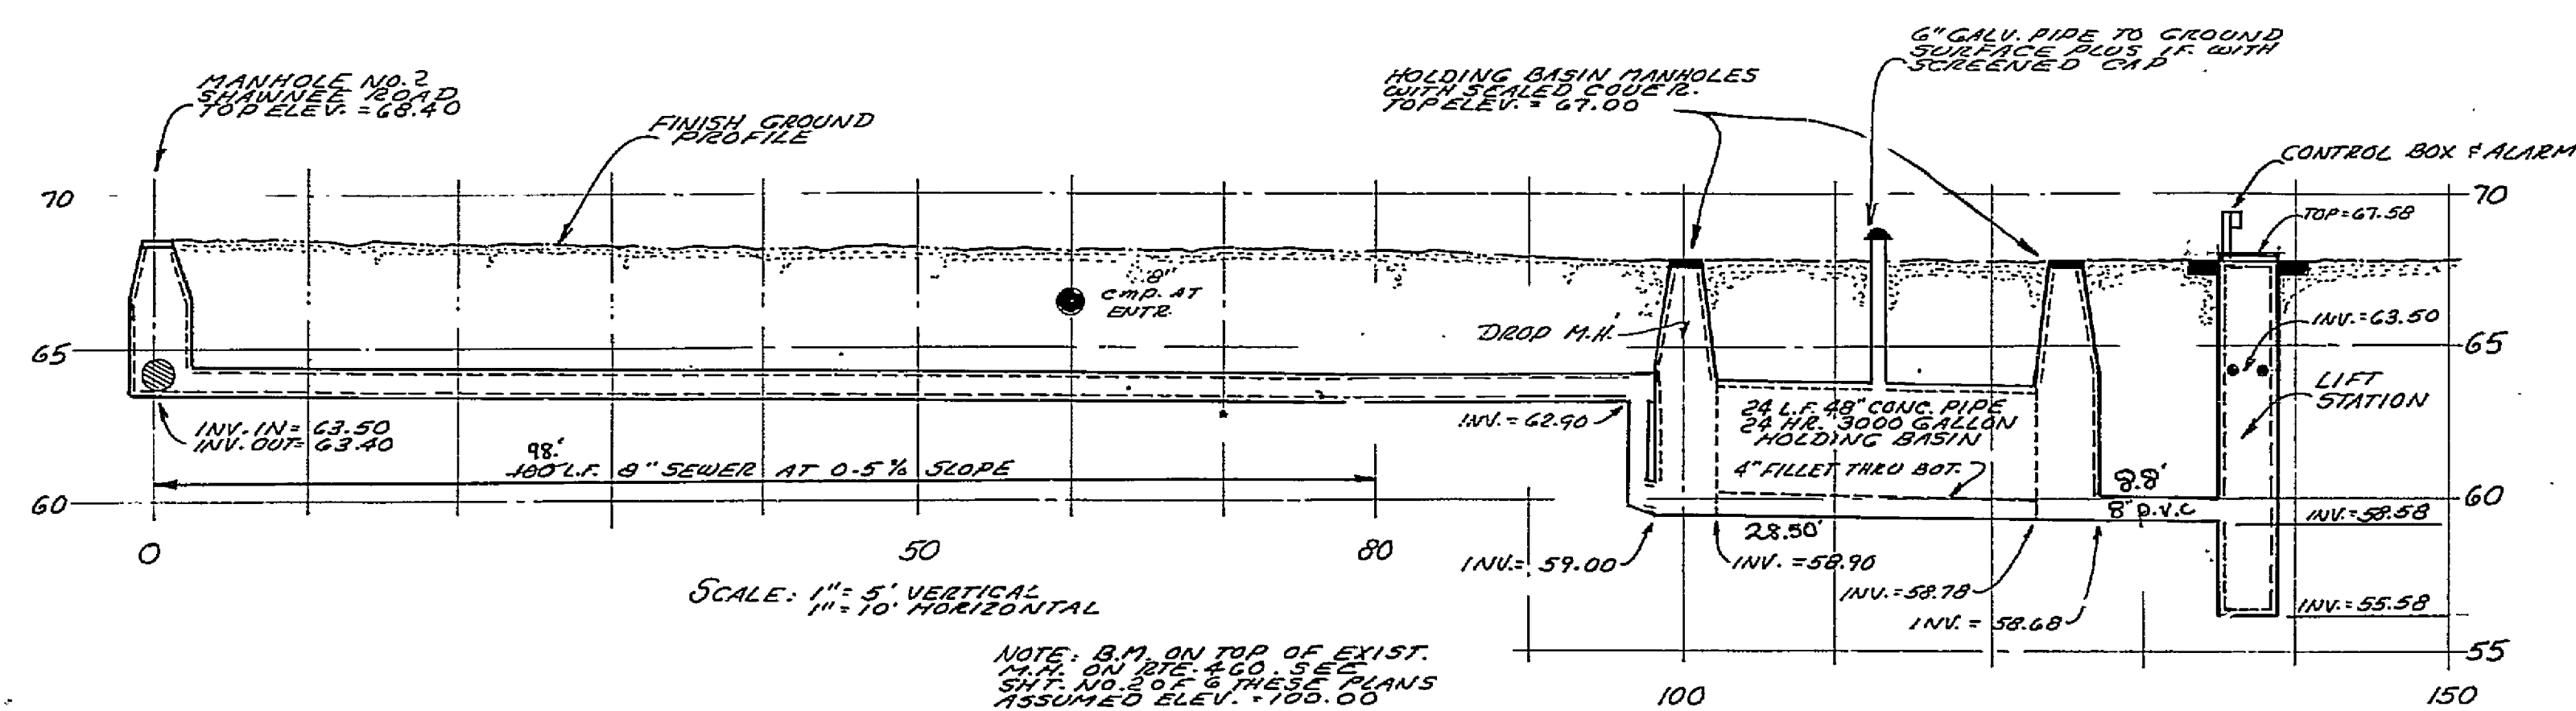

A.H. 1 6.30
" 2 3.70

SEWER PROFILE - MANHOLE NO. 3 TO PUMP STATION

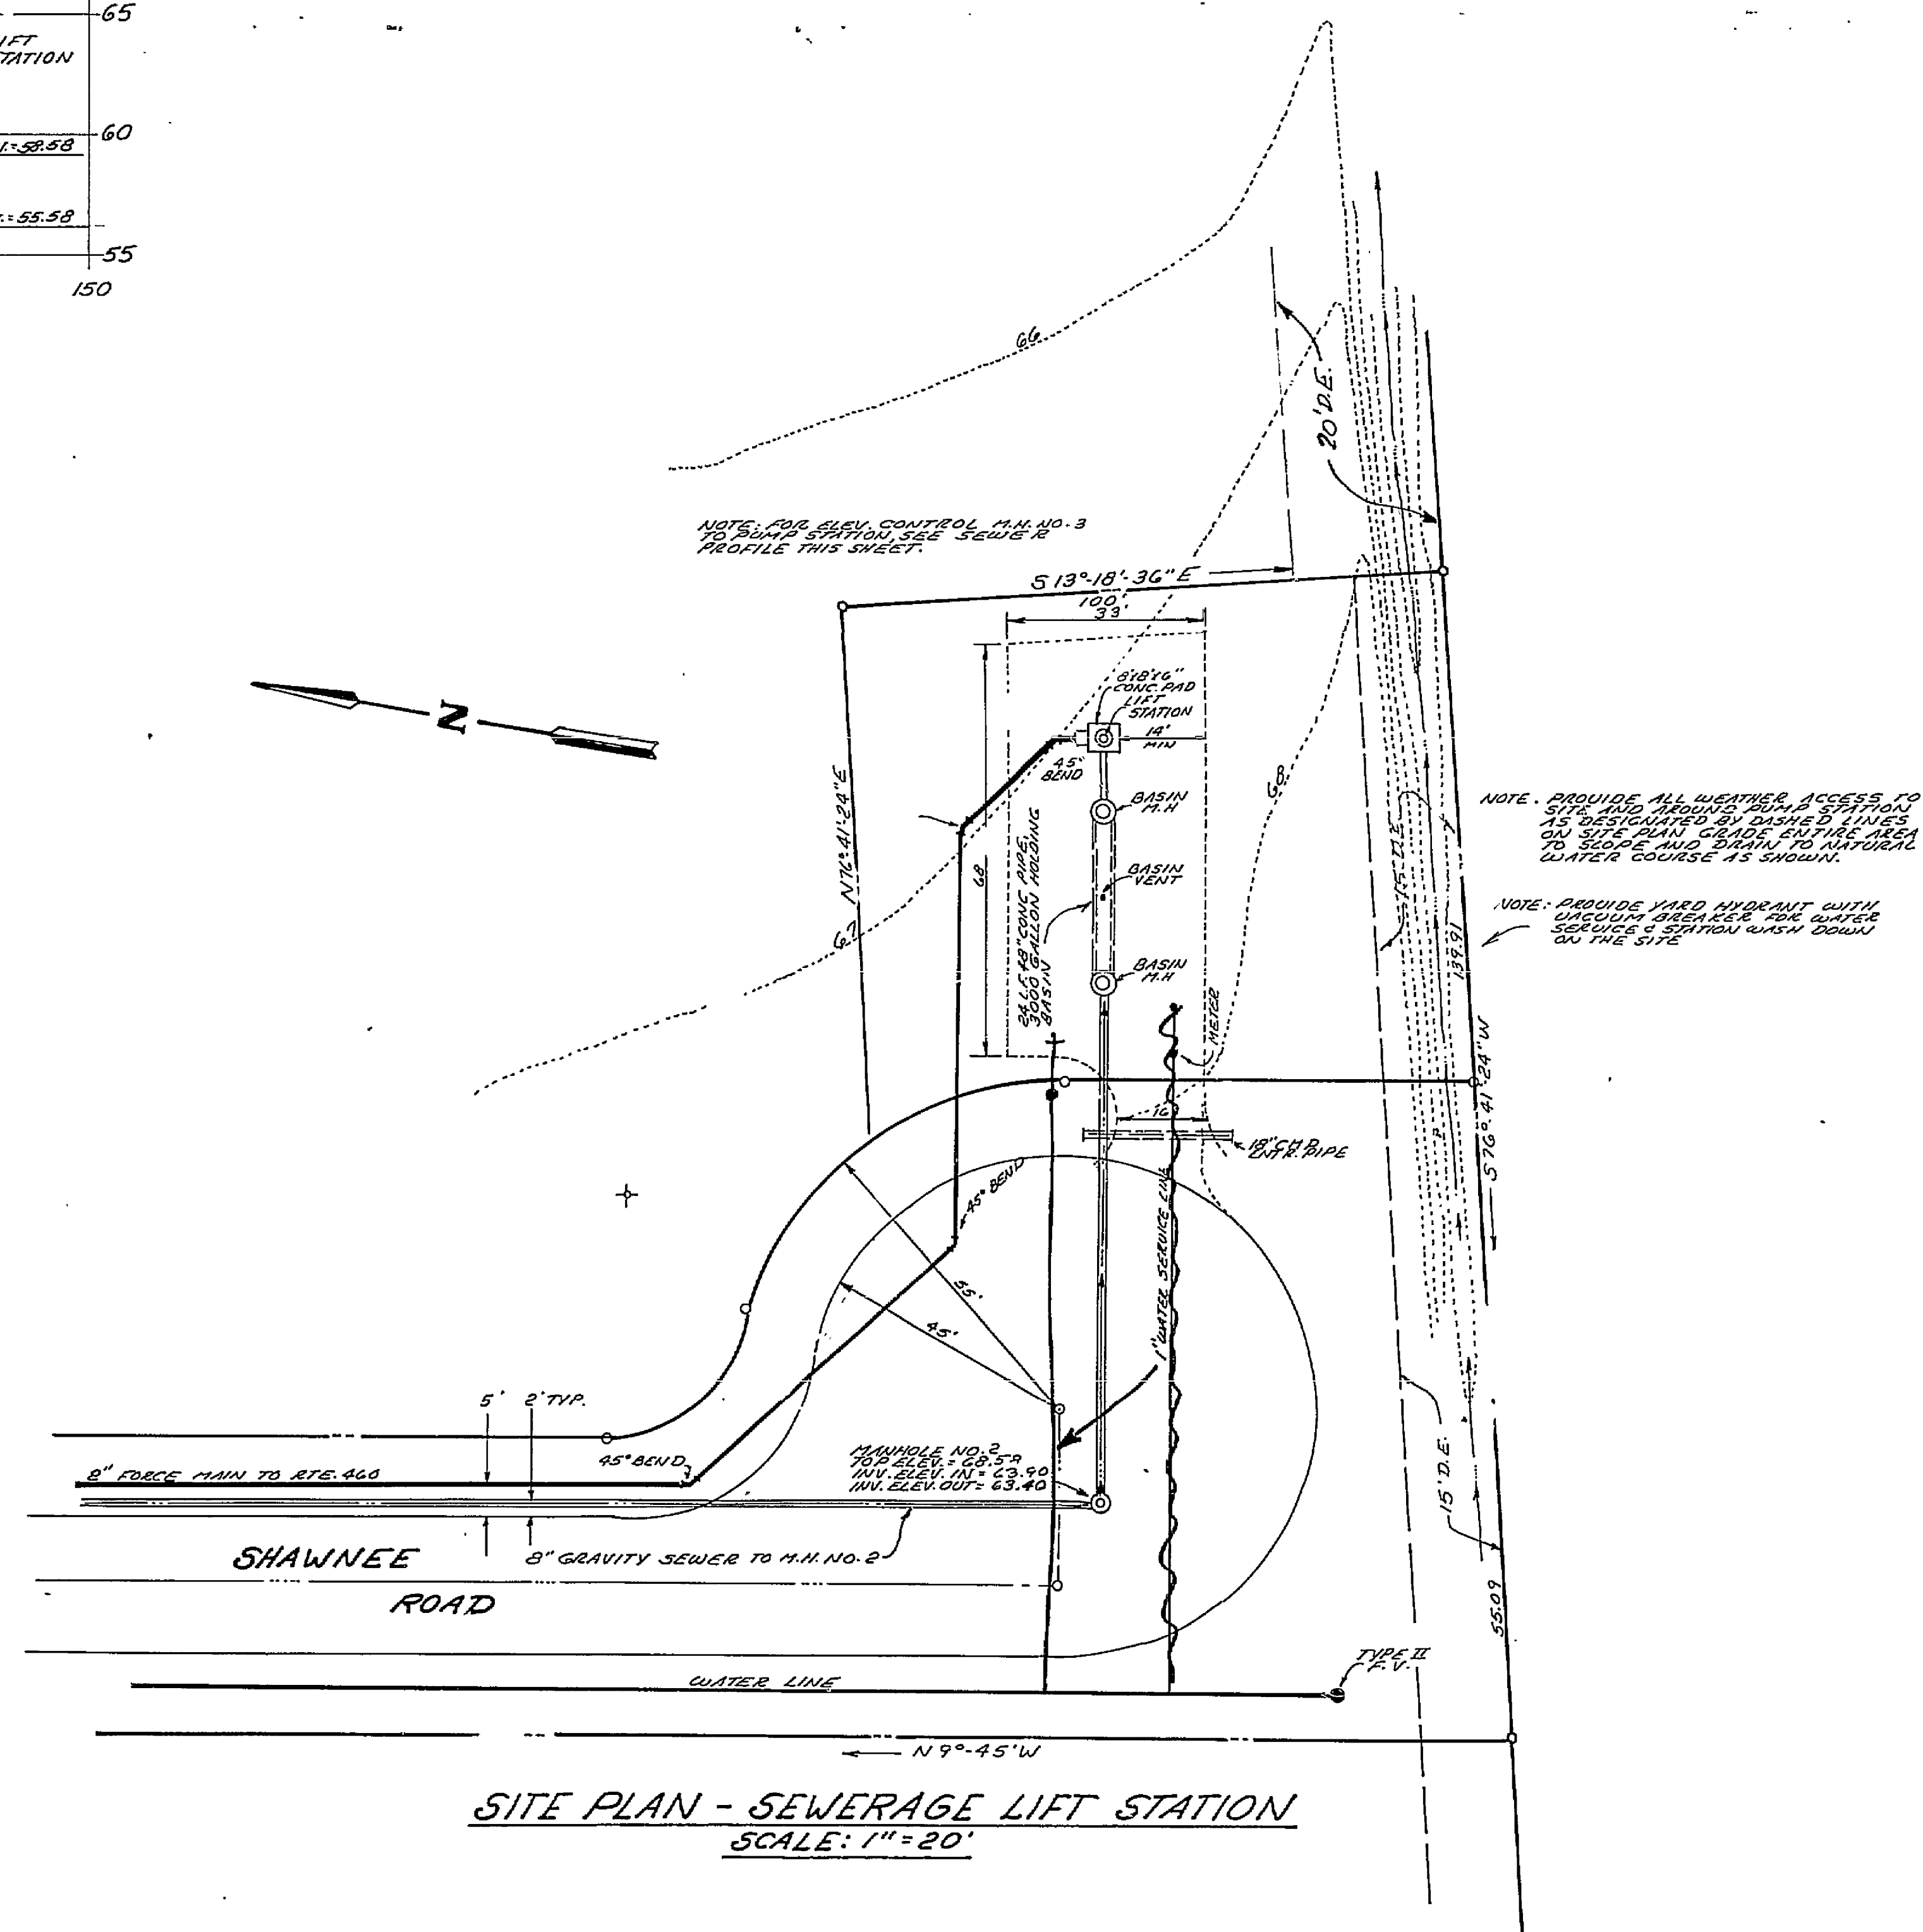

SITE PLAN - SEWERAGE LIFT STATION
SCALE: 1" = 20'

DRAWN BY:	REVISIONS		
	DATE	REMARKS	BY
E.S.			
E.S.			
APPROVED:			
DATE: 7-6-81			
N.R. 12-38			

T. P. PARKER & SON
engineers & surveyors, ltd.

TELEPHONE (703) 387-1153
P.O. BOX 367, SALEM, VIRGINIA 24153

FORT LEWIS INDUSTRIAL PARK
ROANOKE COUNTY VIRGINIA
LIFT STATION SITE PLAN & CONNECTION PROFILES
SCALE: AS NOTED

JULY 6, 1981

SHEET 4
OF 6

RL-1631