



MATCHLINE - SEE SHEET C109

KEY PLAN

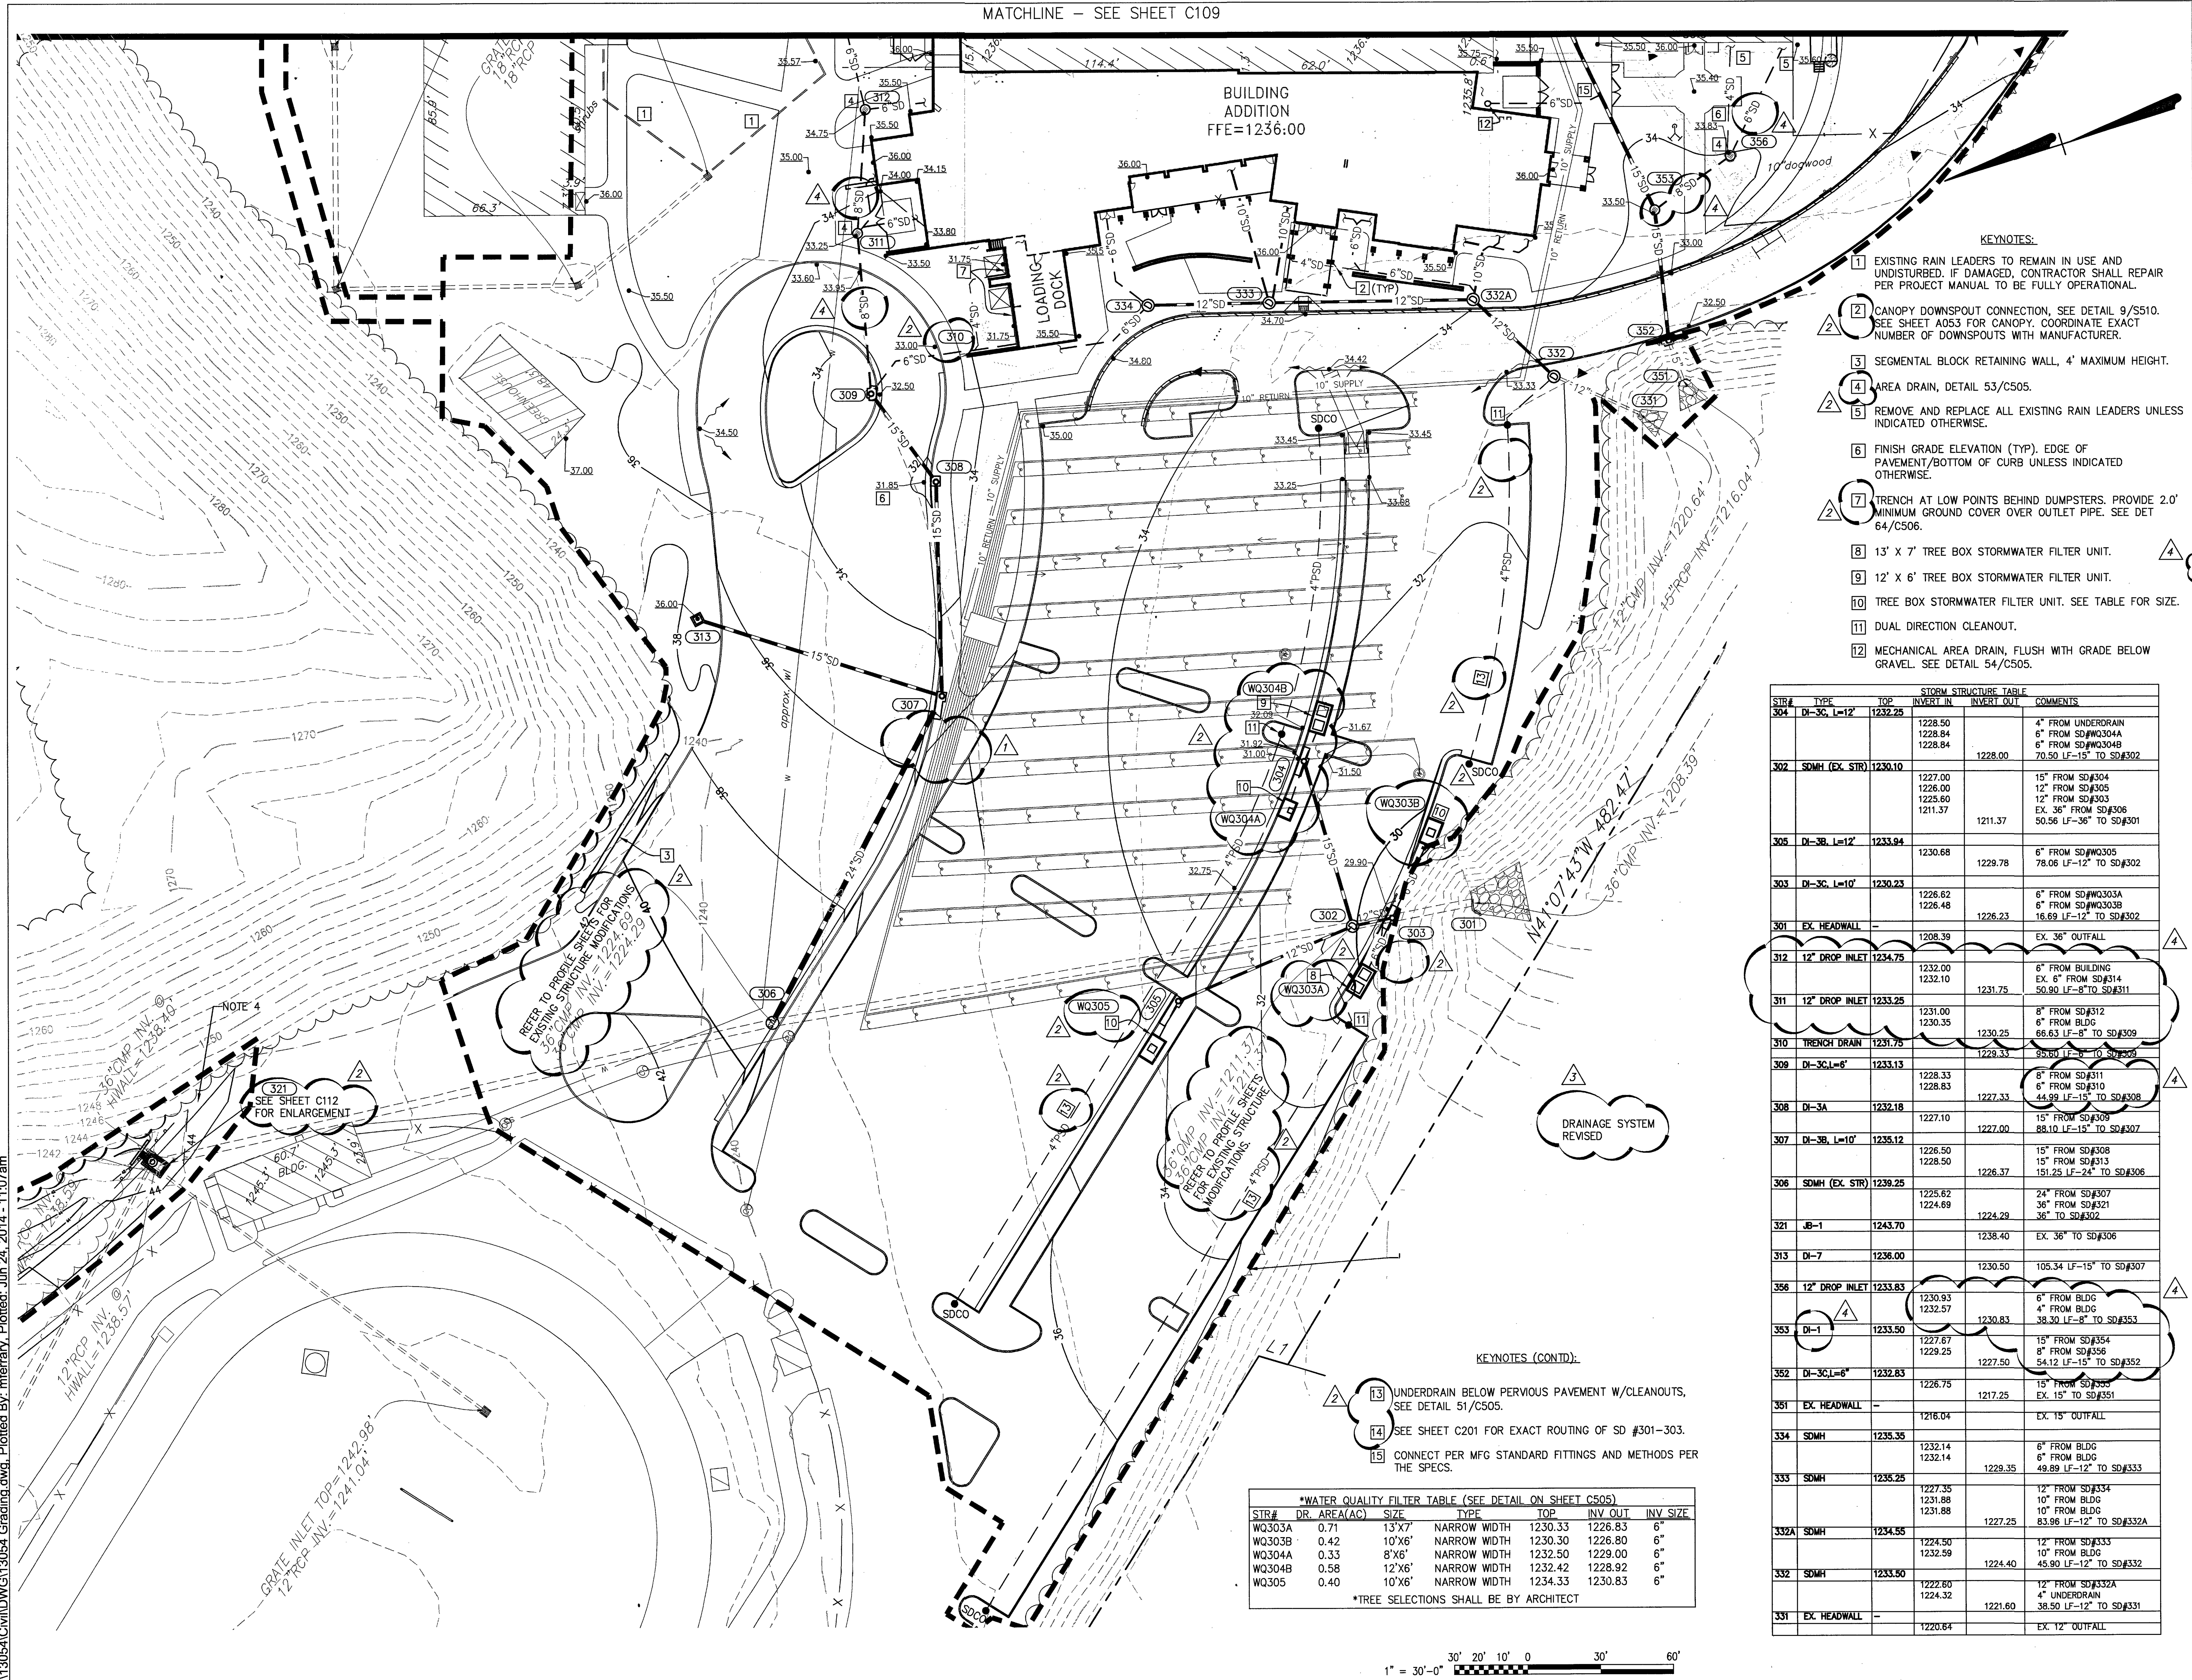

- GENERAL NOTES**
- LENGTH OF STORM DRAIN PIPE IS HORIZONTAL DISTANCE FROM CENTER OF STRUCTURE TO CENTER OF STRUCTURE.
 - "SPILL" GUTTER WHERE DRAINAGE PATTERN IS AWAY FROM GUTTER TO PREVENT TRAPPED OR STANDING WATER.
 - ALL RAIN LEADERS 12" DIAMETER OR LESS SHALL BE INSTALLED AT 1.0% MINIMUM SLOPE UNLESS NOTED OTHERWISE.
 - GRADE AS NEEDED TO PROVIDE POSITIVE DRAINAGE. REFER TO OUTLET PROTECTION SCHEDULE, DETAIL 1/C503.

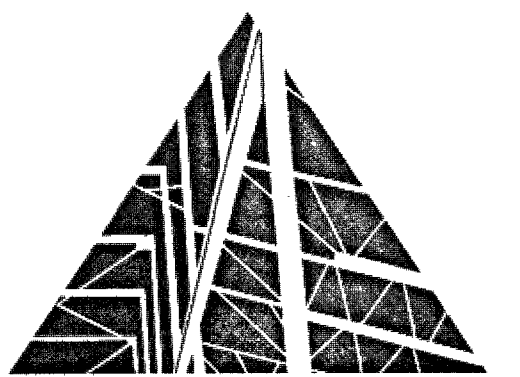

SPECTRUM DESIGN
architects | engineers

10 CHURCH AVE SE, PLAZA SUITE 1 ROANOKE, VIRGINIA 24011 540.342.6001

GLENVAR HIGH SCHOOL RENOVATIONS & ADDITIONS

ROANOKE COUNTY

VA DOE PROJECT#:80-61-00-101

SPECTRUM DESIGN PROJECT NO. 13054



DATE: 06 APRIL 2014

DESIGN ARCHITECT: CZV

PROJECT ARCHITECT: MF

CHECKED BY: MF

DRAWN BY: MF

REVISIONS:

ADDENDUM	NUMBER	DATE
1	1	04/17/14
2	2	05/12/14
3	3	06/05/14
4	4	06/20/14

SHEET TITLE

GRADING PLAN - WEST

C108