


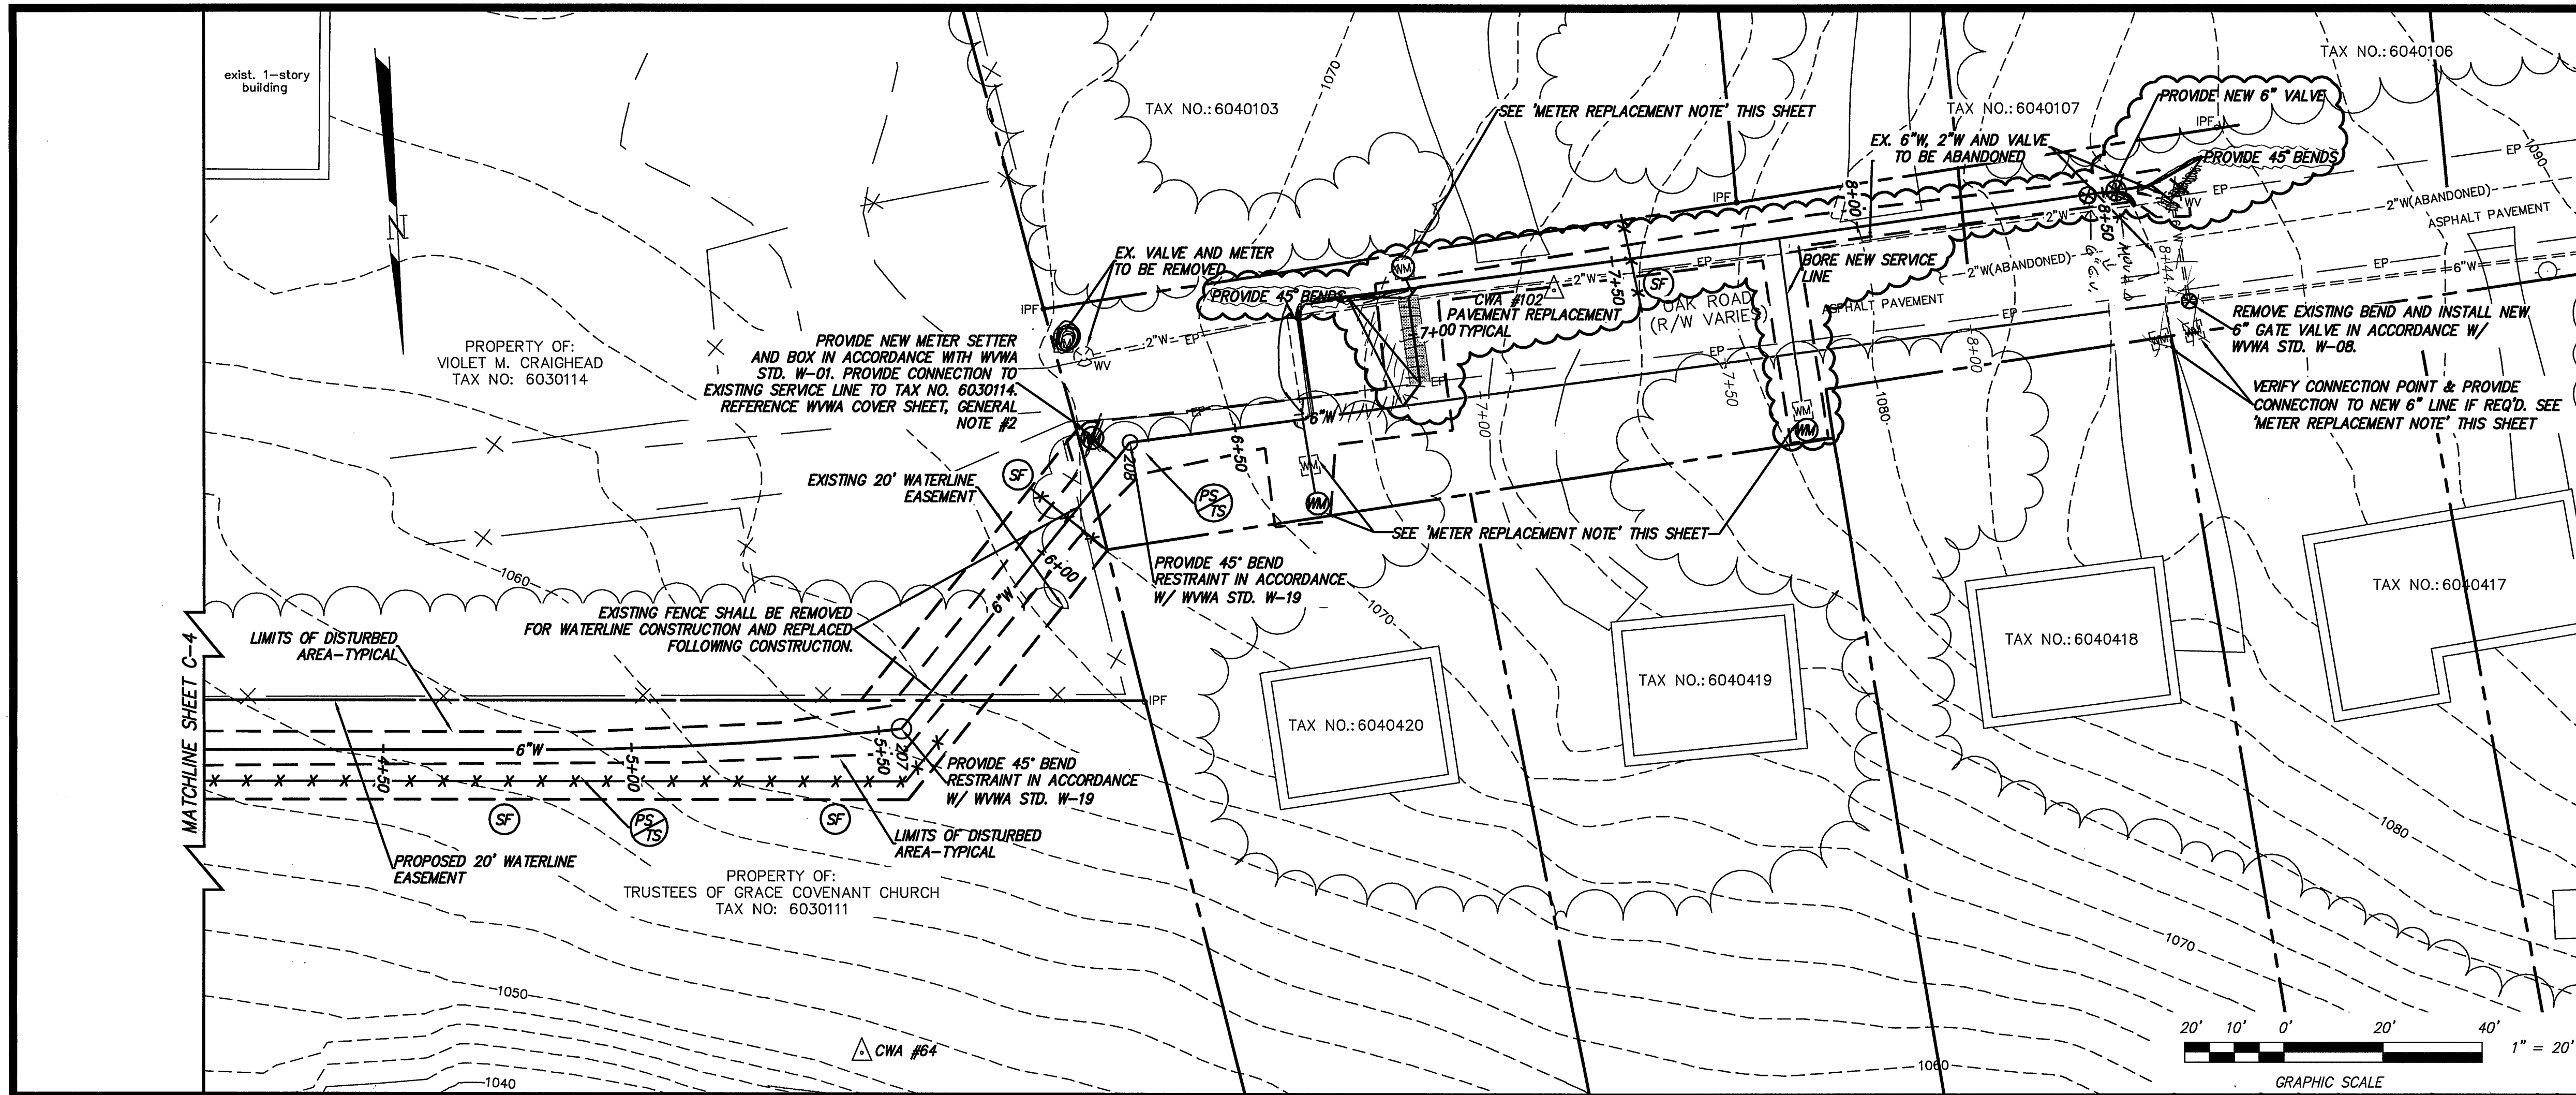

WATER NOTES

BUILDINGS, PAVEMENT, RIGHT-OF-WAY AND PROPERTY LINES SHOWN ARE FROM AERIAL MAPPING PROVIDED TO CALDWELL WHITE ASSOCIATES BY THE CITY OF ROANOKE. LOCATION OF ALL EXISTING VALVES, WATERLINES, AND METERS ARE FROM GEOGRAPHIC INFORMATION SYSTEMS INFORMATION PROVIDED TO CALDWELL WHITE ASSOCIATES BY THE WESTERN VIRGINIA WATER AUTHORITY.

ALL OTHER UTILITIES SHOWN ARE FROM AERIAL MAPPING PROVIDED TO CALDWELL WHITE ASSOCIATES BY THE CITY OF ROANOKE. NO UTILITIES HAVE BEEN FIELD LOCATED AND A MISS UTILITY TICKET HAS NOT BEEN CLEARED FOR THIS PROJECT. THE CONTRACTOR SHALL CONTACT MISS UTILITY PRIOR TO BEGINNING CONSTRUCTION.

THE CONTRACTOR SHALL BE REQUIRED TO PROVIDE A MEANS OF KEEPING EXISTING 2" LINE IN SERVICE DURING CONSTRUCTION. FOLLOWING ACCEPTANCE OF THE NEW 6" LINE BY WVWA, THE 2" LINE SHALL BE ABANDONED AND THE METERS/SETTERS SHALL BE REMOVED.

METER REPLACEMENT NOTE

CONTRACTOR SHALL BE RESPONSIBLE FOR COORDINATING REMOVAL OF THE EXISTING WATER METER WITH THE WVWA. CONTRACTOR SHALL FURTHER BE RESPONSIBLE FOR REMOVAL OF THE EXISTING METER SETTER AND BOX AND FOR THE INSTALLATION OF THE NEW METER SETTER AND BOX IN ACCORDANCE WITH WVWA STANDARD W-01. REFERENCE WVWA COVER SHEET, GENERAL NOTE #2.

INDICATES EXISTING WATER METER


INDICATES NEW 5/8" METER AND SETTER WITH 1" SERVICE LINE REFERENCE WVWA COVER SHEET, GENERAL NOTE #2. NEW METERS SHALL BE INSTALLED AT THE RIGHT-OF-WAY LINE AS SHOWN.

VERTICAL CONTROL POINTS

POINT NO.	DESCRIPTION	ELEVATION
CWA #64	BR. SPK.	1051.11
CWA #102	PK SET	1074.35

PAVEMENT REPLACEMENT DETAIL

NOTES:
-21-B BACKFILL SHALL BE COMPACTED TO 95% STANDARD PROCTOR

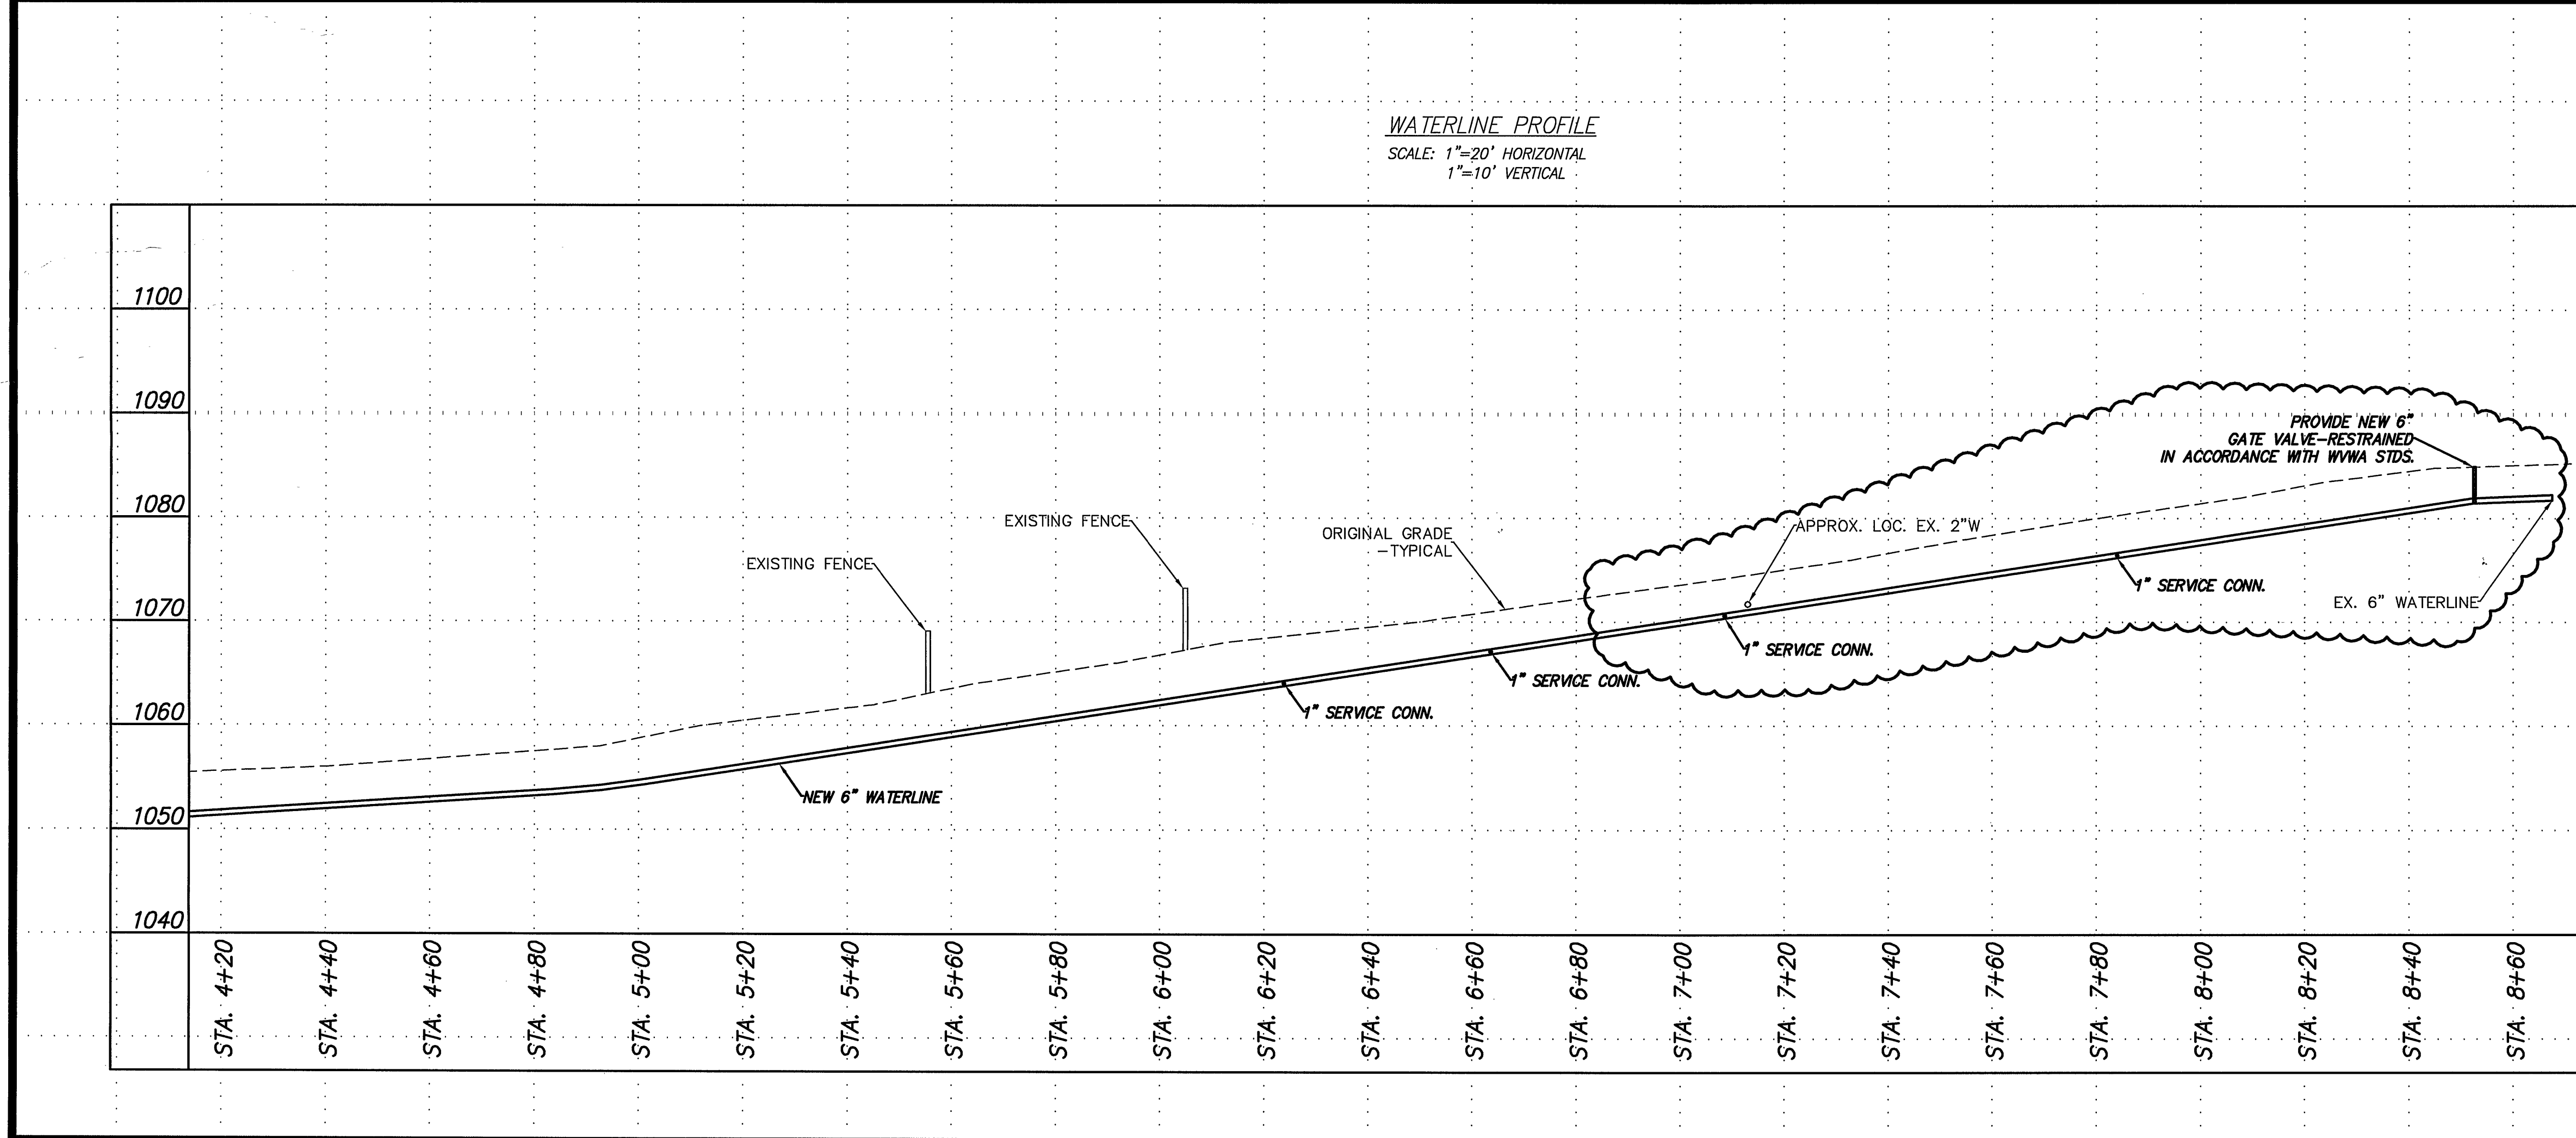

CITY OF ROANOKE
PLANNING BUILDING & DEVELOPMENT

APPROVED

Development Reviewer: *George R. Neergaard* Date: 10-13-10

Digitally signed by George Neergaard I attest to the accuracy and integrity of this document
Date: 2010.10.13 12:02:01 -0400

FIELD REVISION #1

REVISED WATERLINE LOCATION FROM APPROXIMATELY STA. 6+50 TO END, PER WESTERN VA. WATER AUTHORITY SKETCH DATED OCTOBER 6, 2010.

FIELD REVISION #1

EROSION CONTROL AND WATERLINE PLAN AND PROFILE STA. 4+13.8 TO 8+65.9

FOR
GRACE COVENANT CHURCH

SITUATE 766 PETERS CREEK ROAD
CITY OF ROANOKE, VIRGINIA

COMMONWEALTH OF VIRGINIA
JASON W. KNIGHT
LIC. NO. 0402 C35531
10/13/10
PROFESSIONAL ENGINEER

CWA
CALDWELL WHITE ASSOCIATES
ENGINEERS / SURVEYORS / PLANNERS
4203 MELROSE AVENUE, N.W.
P.O. BOX 6260
ROANOKE, VIRGINIA 24017-0260
(540) 366-3400
FAX: (540) 366-8702

Designed: JWK
Drawn: JWK
Checked: FBC
Date: FEB 17 2009
Rev: OCT 12 2010
Scale: AS SHOWN
Tax Parcel: 6030114
W.O. No.: 09-0003