


PROJECT LOCATION MAP

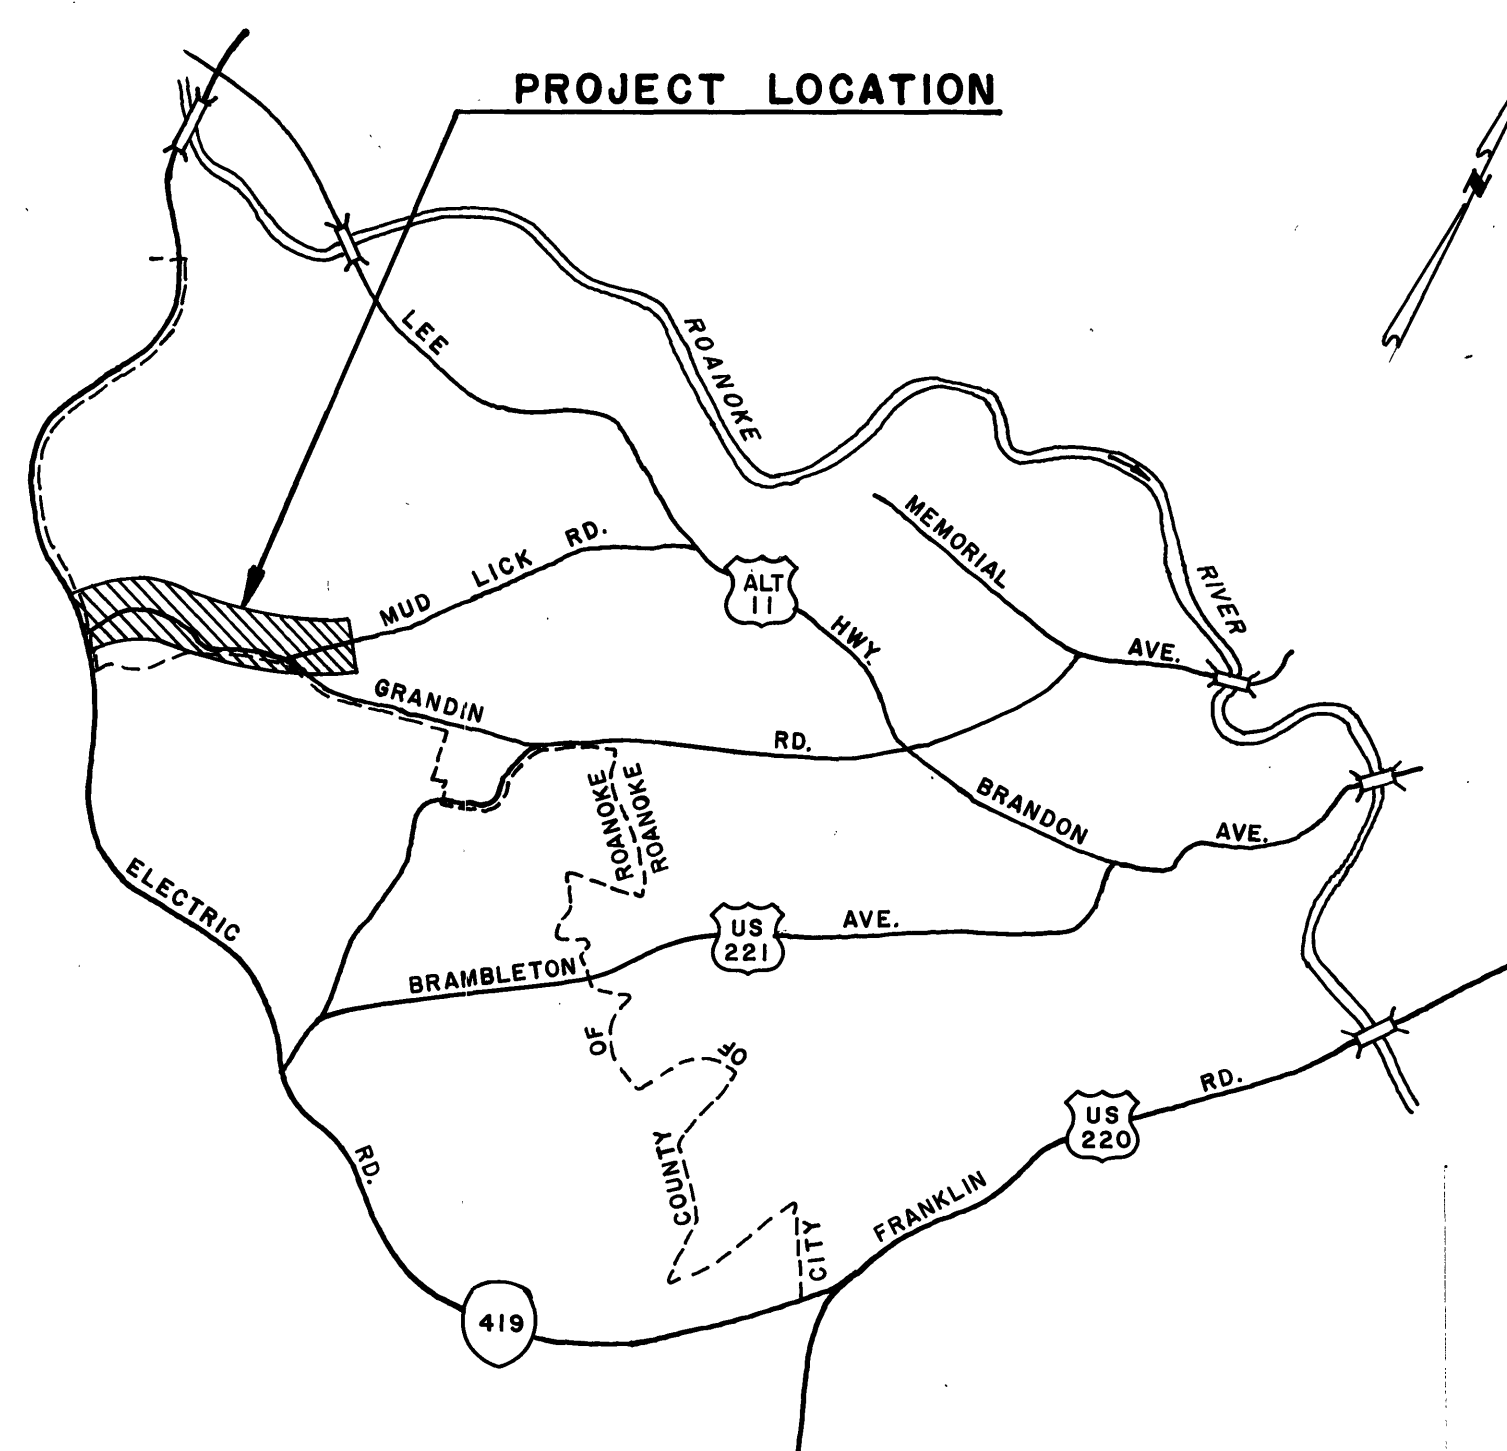

OFFICE OF CITY ENGINEER
ROOM 350
MUNICIPAL BUILDING
215 CHURCH AVENUE, S.W.
ROANOKE, VIRGINIA 24011


INDEX OF SHEETS

- SHEET 1 TITLE SHEET
- SHEET 2 QUANTITY SHEET
- SHEET 3 ABBREVIATIONS, LEGEND AND GENERAL NOTES
- SHEET 4 PLAN AND PROFILE
- SHEET 5 PLAN AND PROFILE
- SHEET 6 PLAN AND PROFILE
- SHEET 7 PLAN AND PROFILE
- SHEET 8 PLAN AND PROFILE
- SHEET 9 PLAN AND PROFILE
- SHEET 10 PLAN AND PROFILE

CONSULTING ENGINEERS

MATTERN AND CRAIG
CONSULTING ENGINEERS
ROANOKE, VIRGINIA

COMMISSION NUMBER: **469**

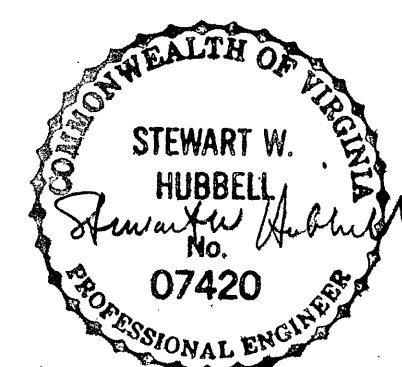

PROJECT NAME

GRANDIN ROAD WATERLINE

PROJECT NUMBER: **84-09**

REVISION	BY	DESCRIPTION:	DATE
REVISION	BY	DESCRIPTION:	DATE
REVISION	BY	DESCRIPTION:	DATE
REVISION	BY	DESCRIPTION:	DATE

APPROVED FOR CONSTRUCTION

<i>Richard B. Berra</i> ROANOKE CITY ENGINEER	10 MAY '84 DATE
<i>William M. Mullins Jr.</i> DIRECTOR OF PUBLIC WORKS	5/9/84 DATE
<i>Art B. Li</i> DIRECTOR OF UTILITIES AND OPERATIONS	5/10/84 DATE
	DATE
	DATE

ADVERTISED DATE: **MAY 13, 1984**

SET NUMBER: _____

SHEET NUMBER: **1** OF **10**