



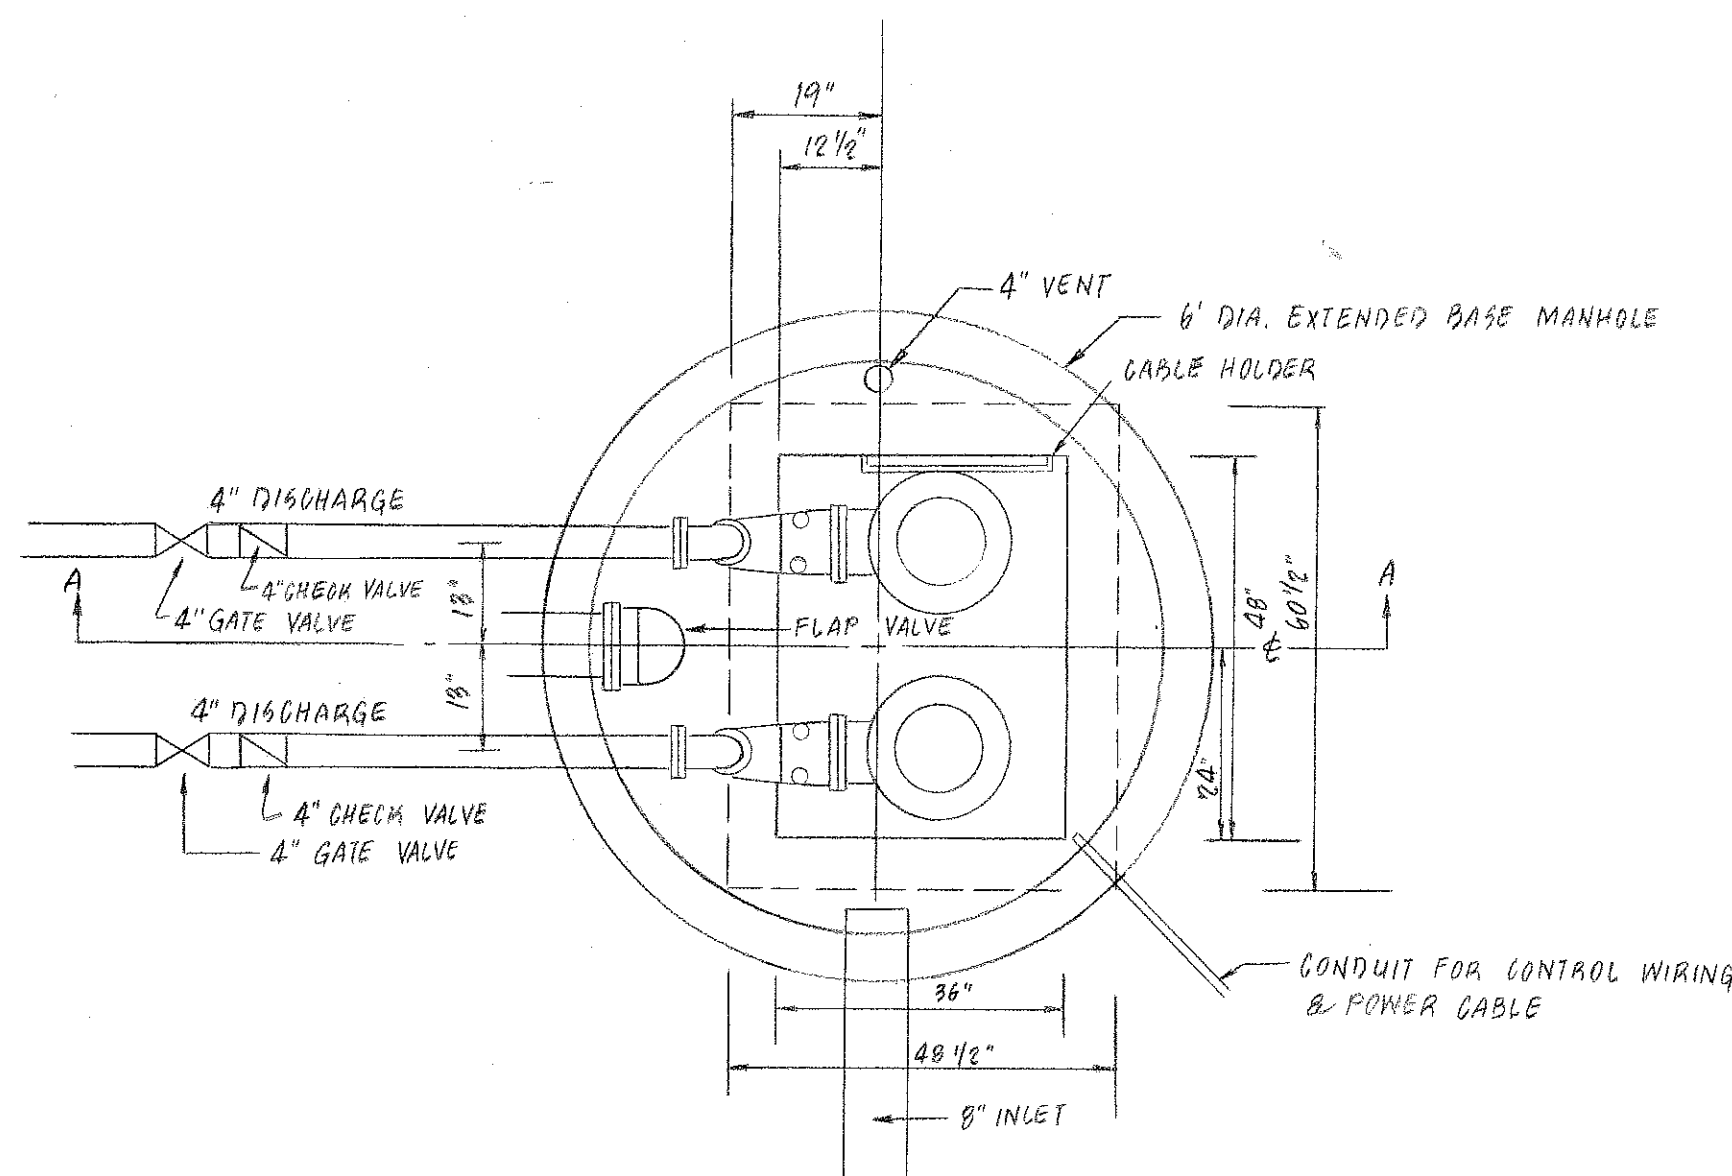


PLAN

SCALE: 1" = 2'

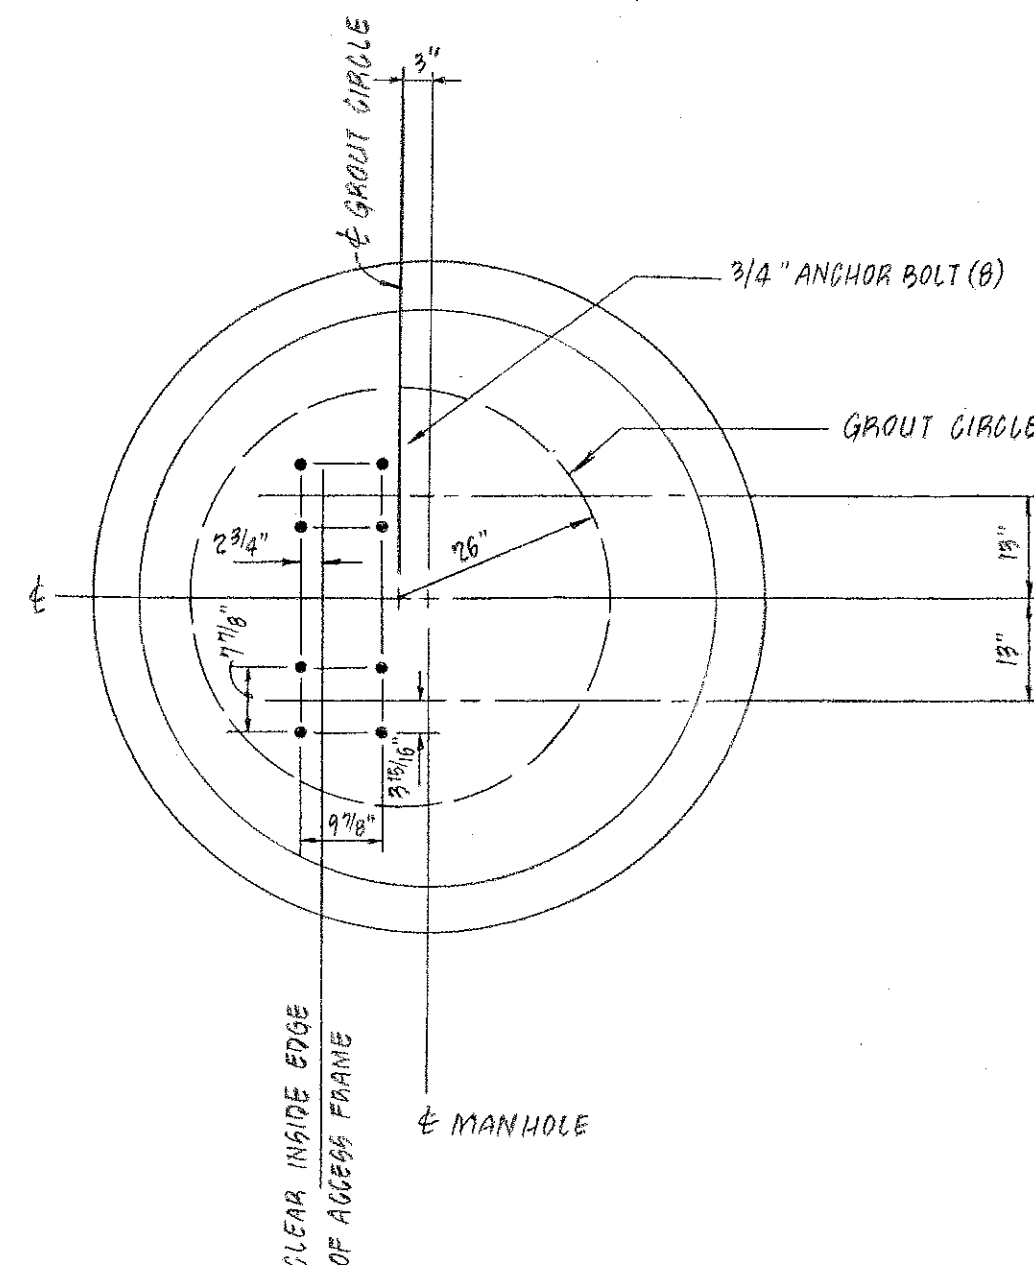


BASE DETAIL

SCALE: 1" = 2'

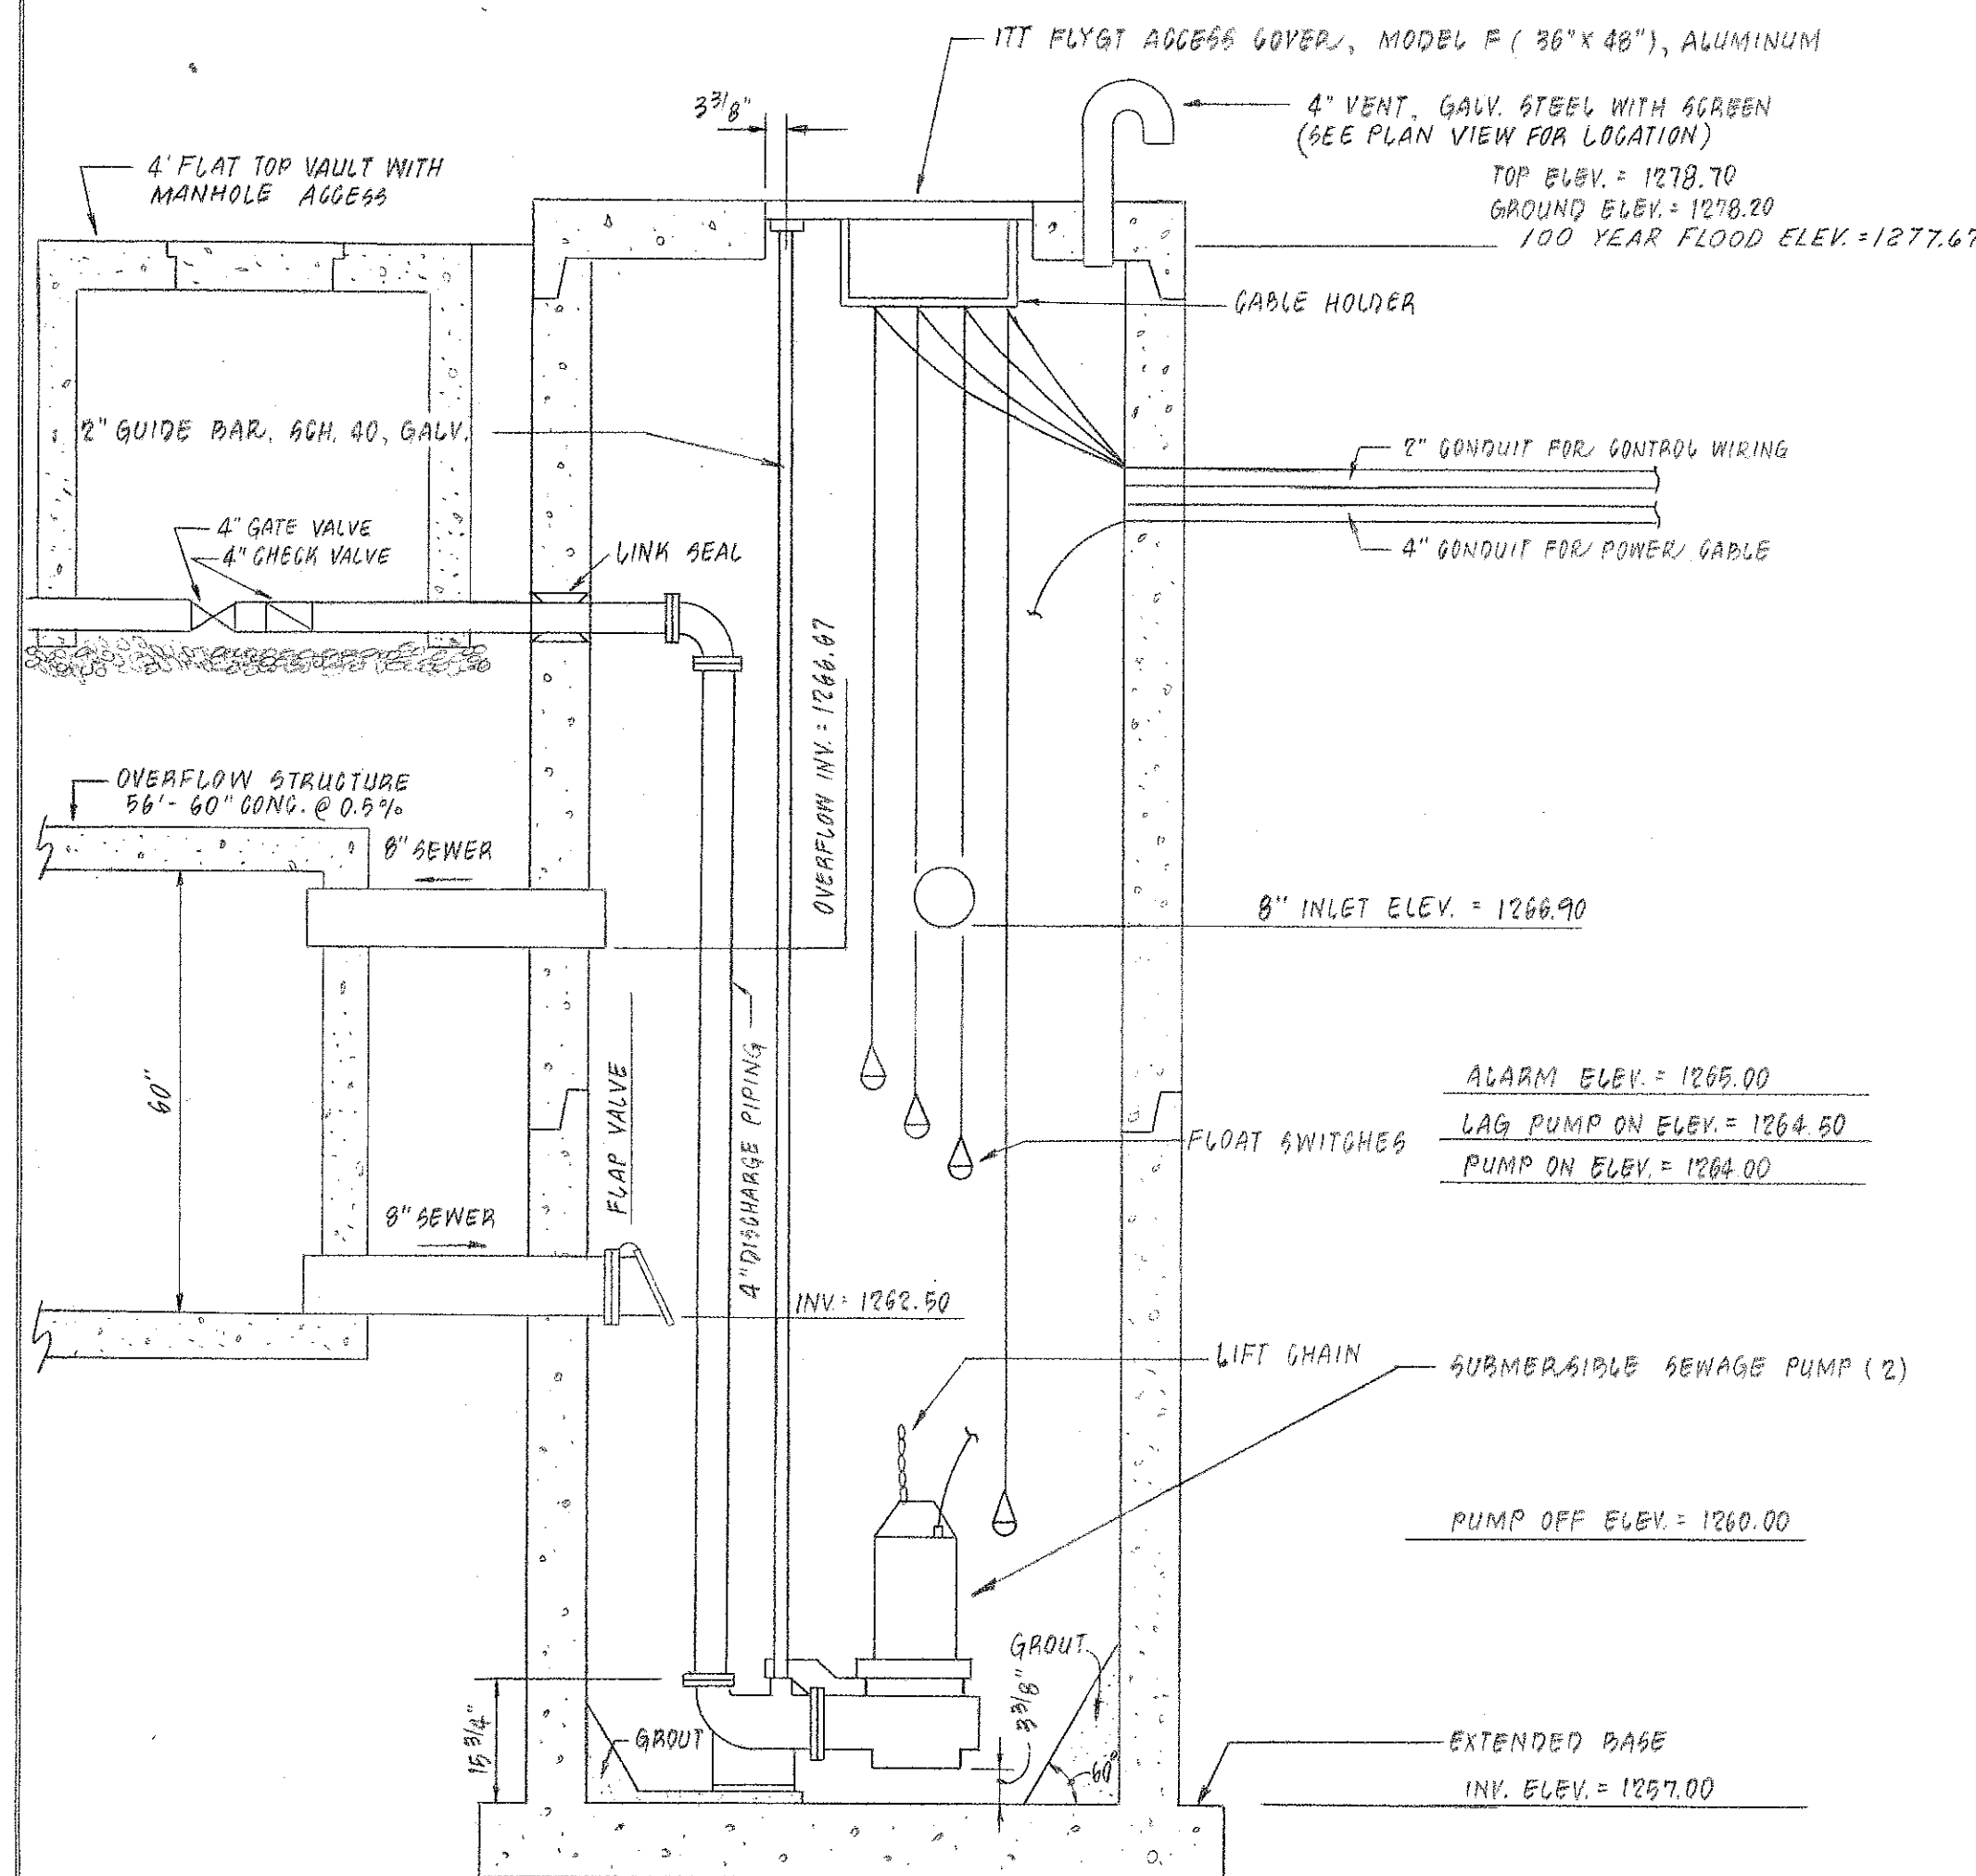

SECTION "A-A"



SCALE: 1" = 2'

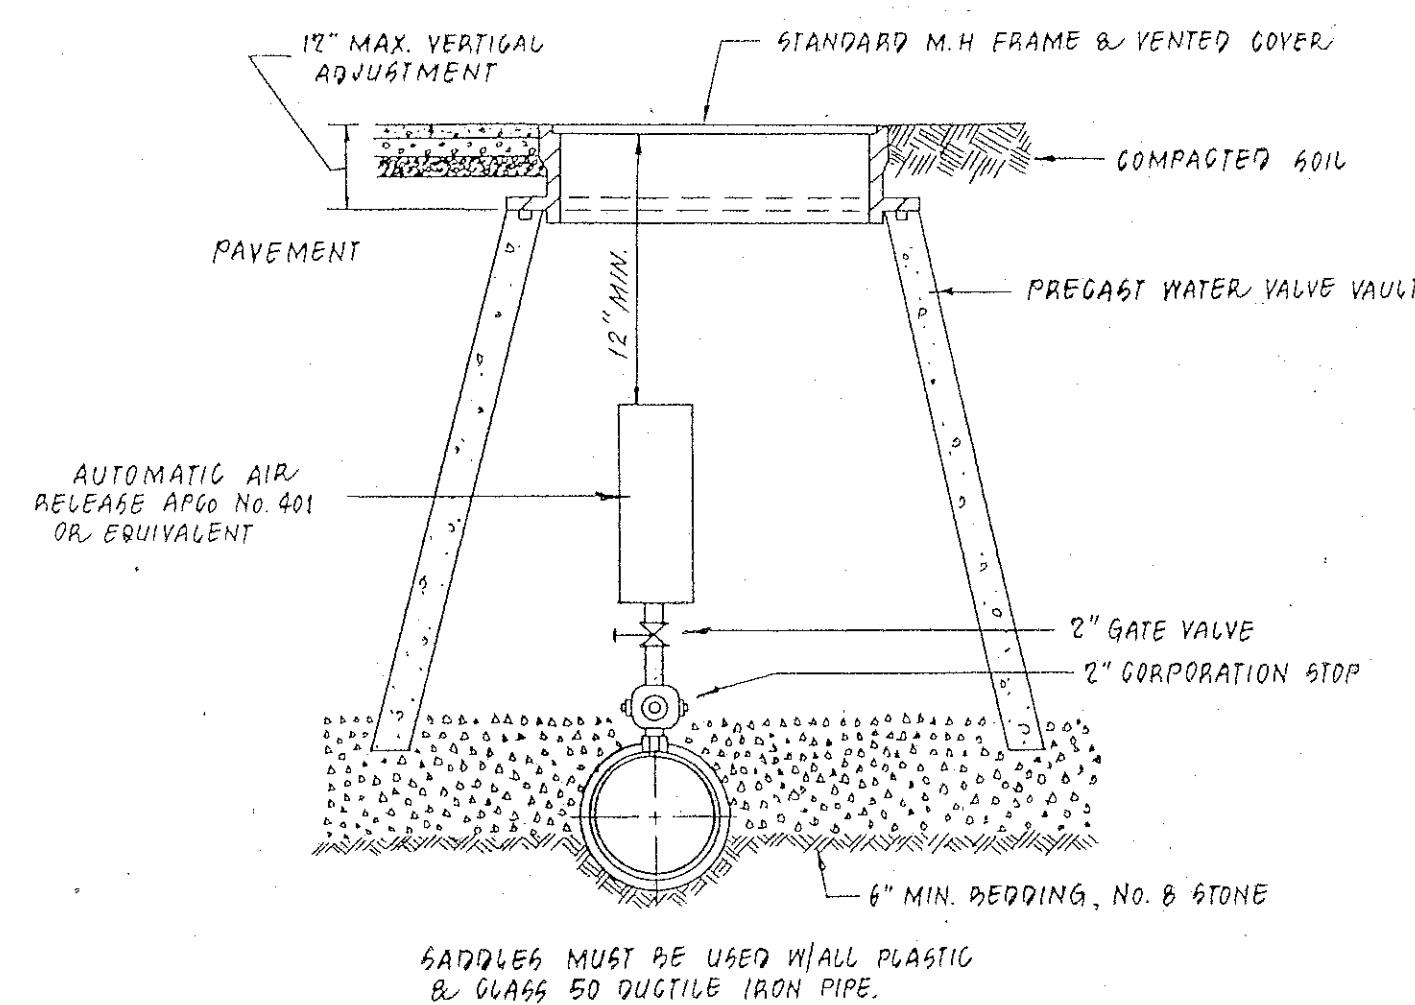

AUTOMATIC AIR RELEASE ASSEMBLY


NO SCALE

NOTE: INSTALL AT HIGH POINT ON FORCE MAIN.

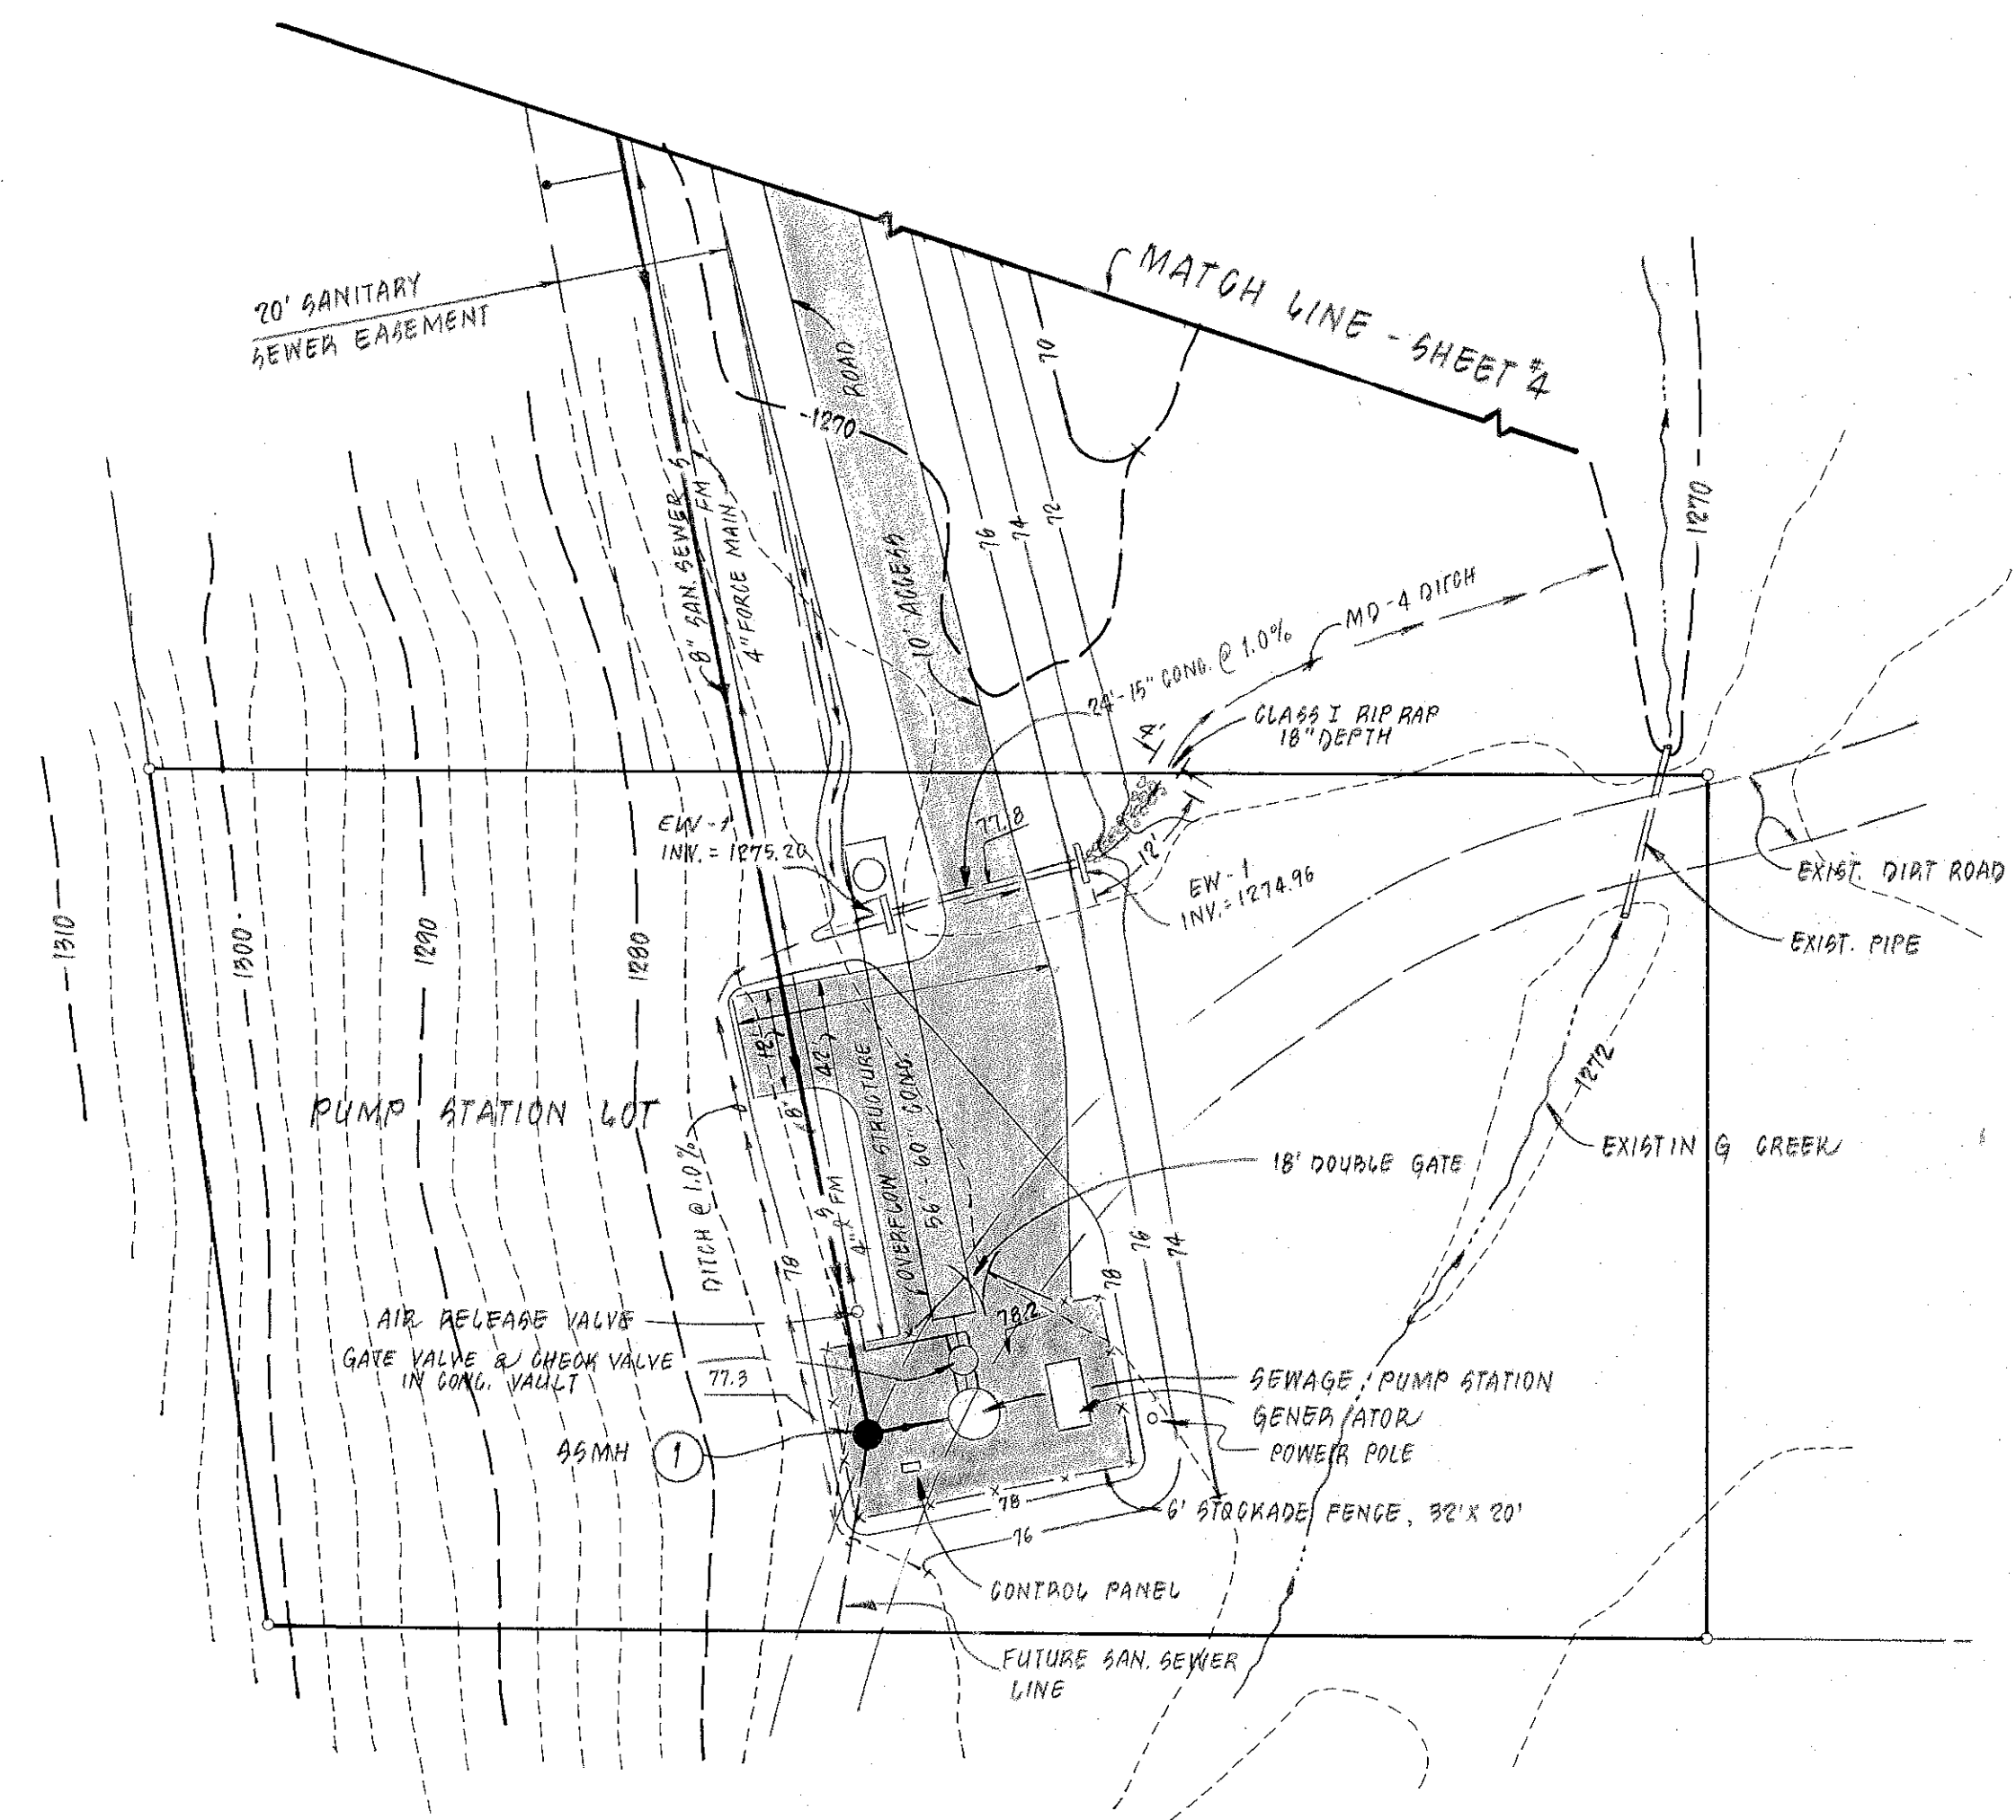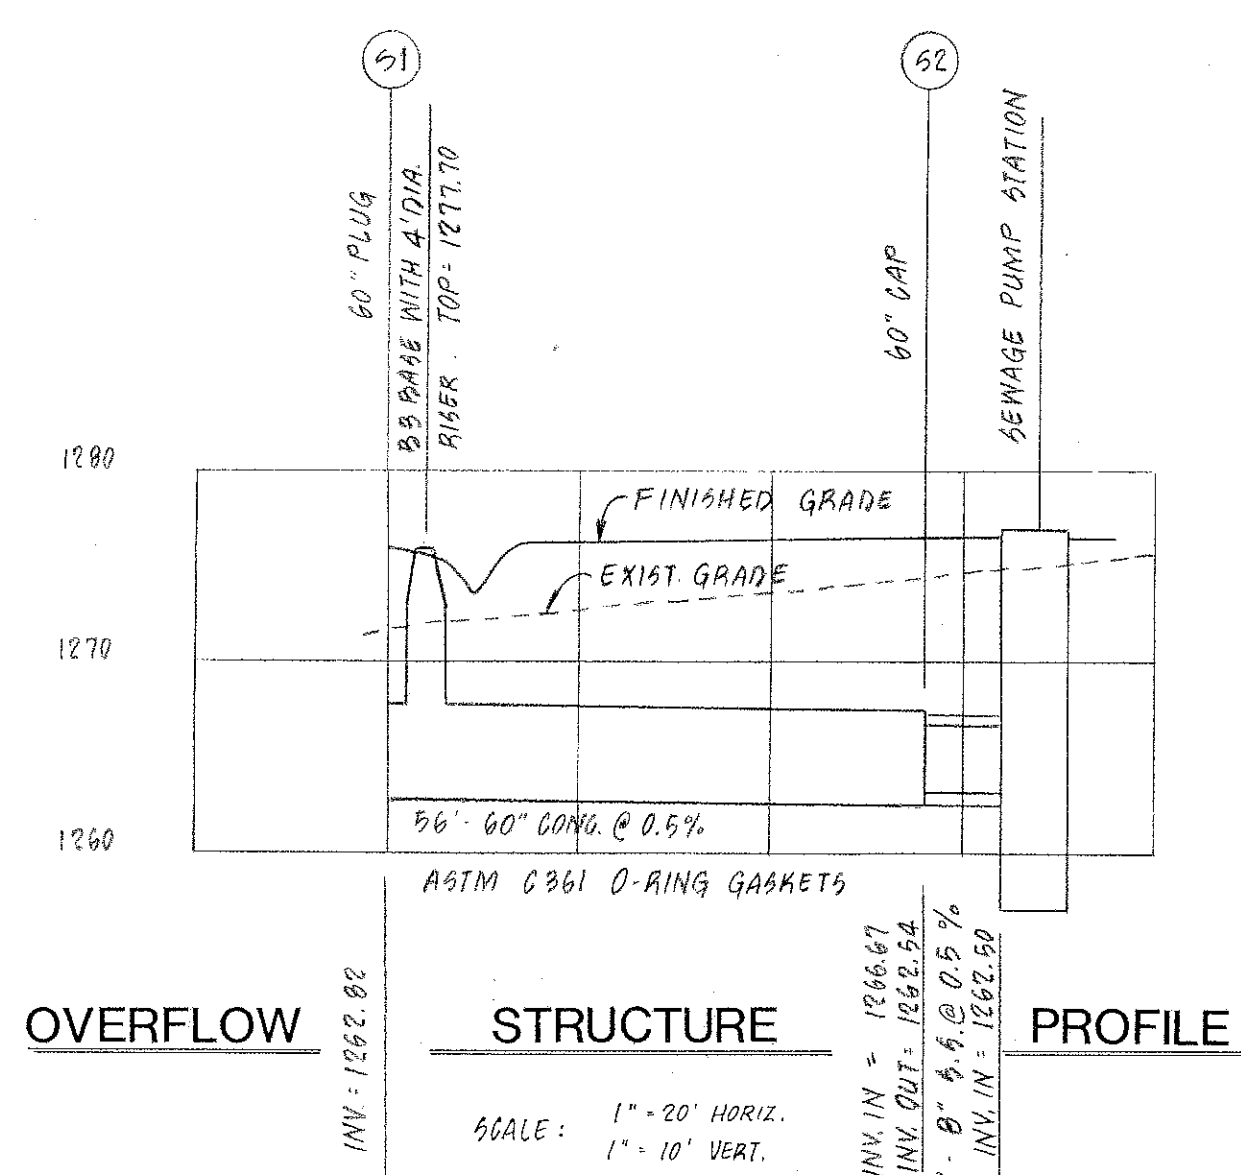

SITE PLAN


SCALE: 1" = 20'

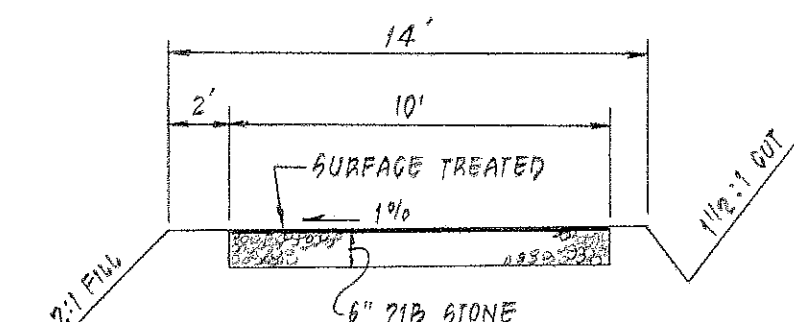

ACCESS DRIVE

NO SCALE

REVISION	DATE	DESCRIPTION
1	2 DEC. 1994	POWER CONDUIT SIZED.
2		
3		
4		
100		

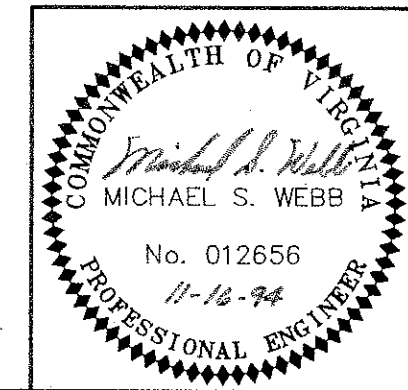

LUMSDEN ASSOCIATES, P.C.
ENGINEERS-SURVEYORS-PLANNERS
ROANOKE, VIRGINIA

SCALE: AS SHOWN
DATE: 15 DEC. 1994
SHEET 9 of 12