
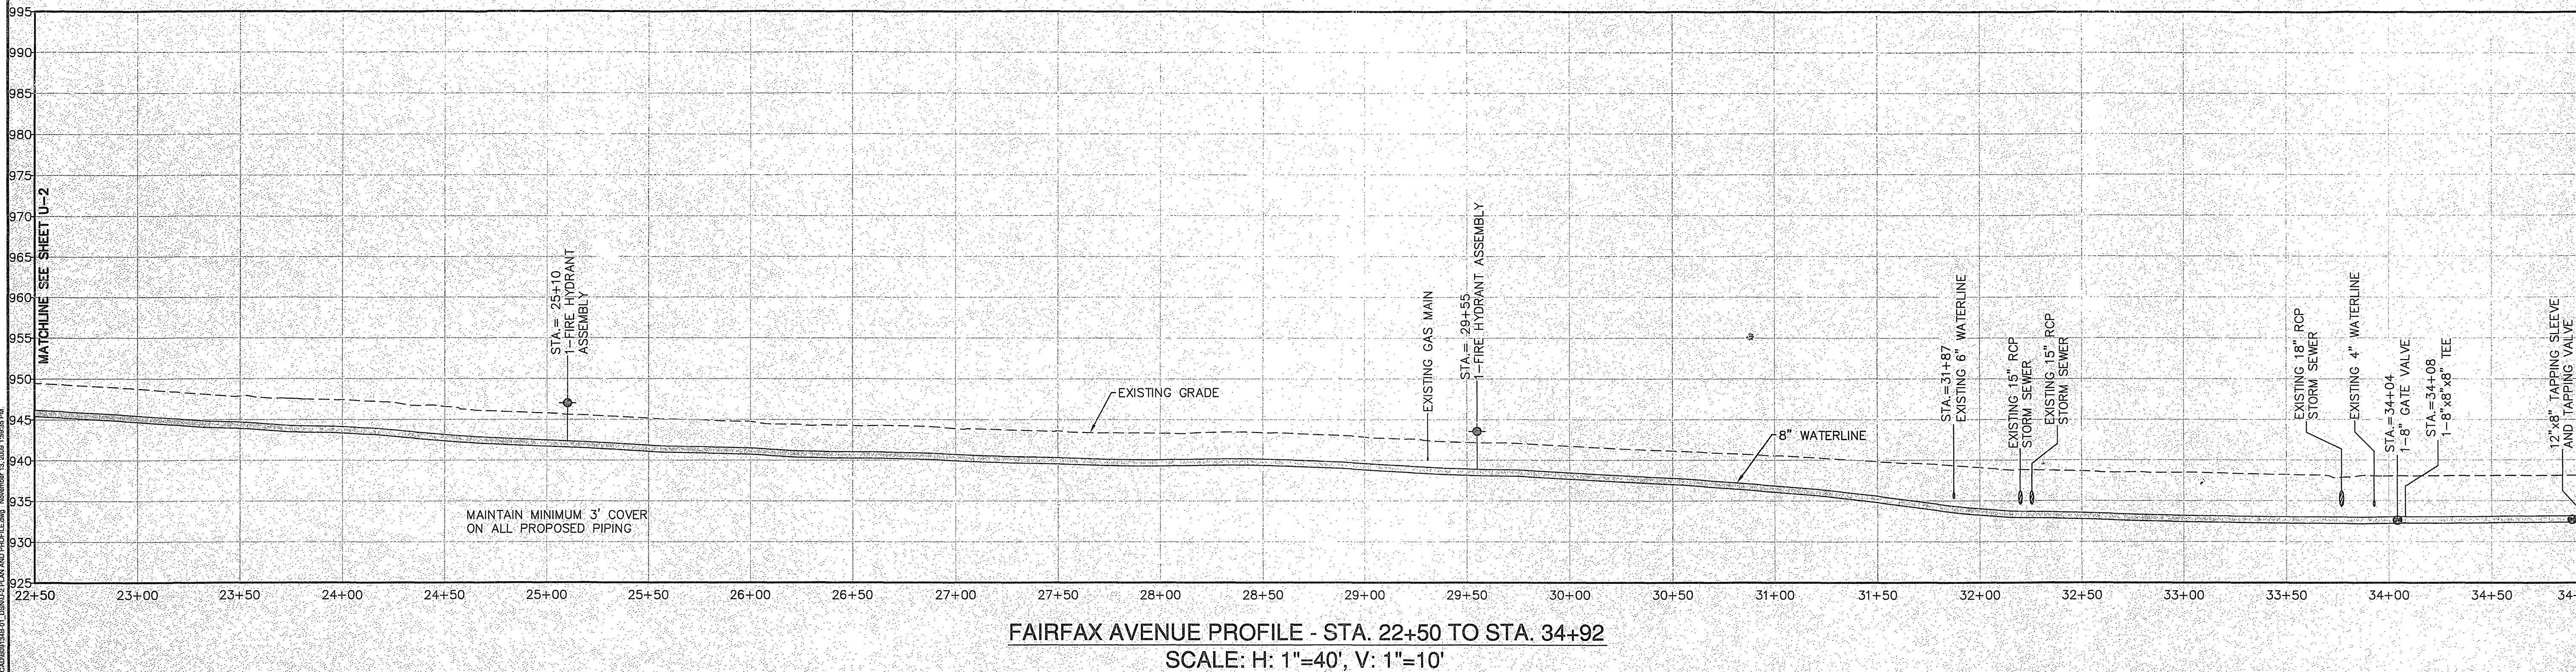


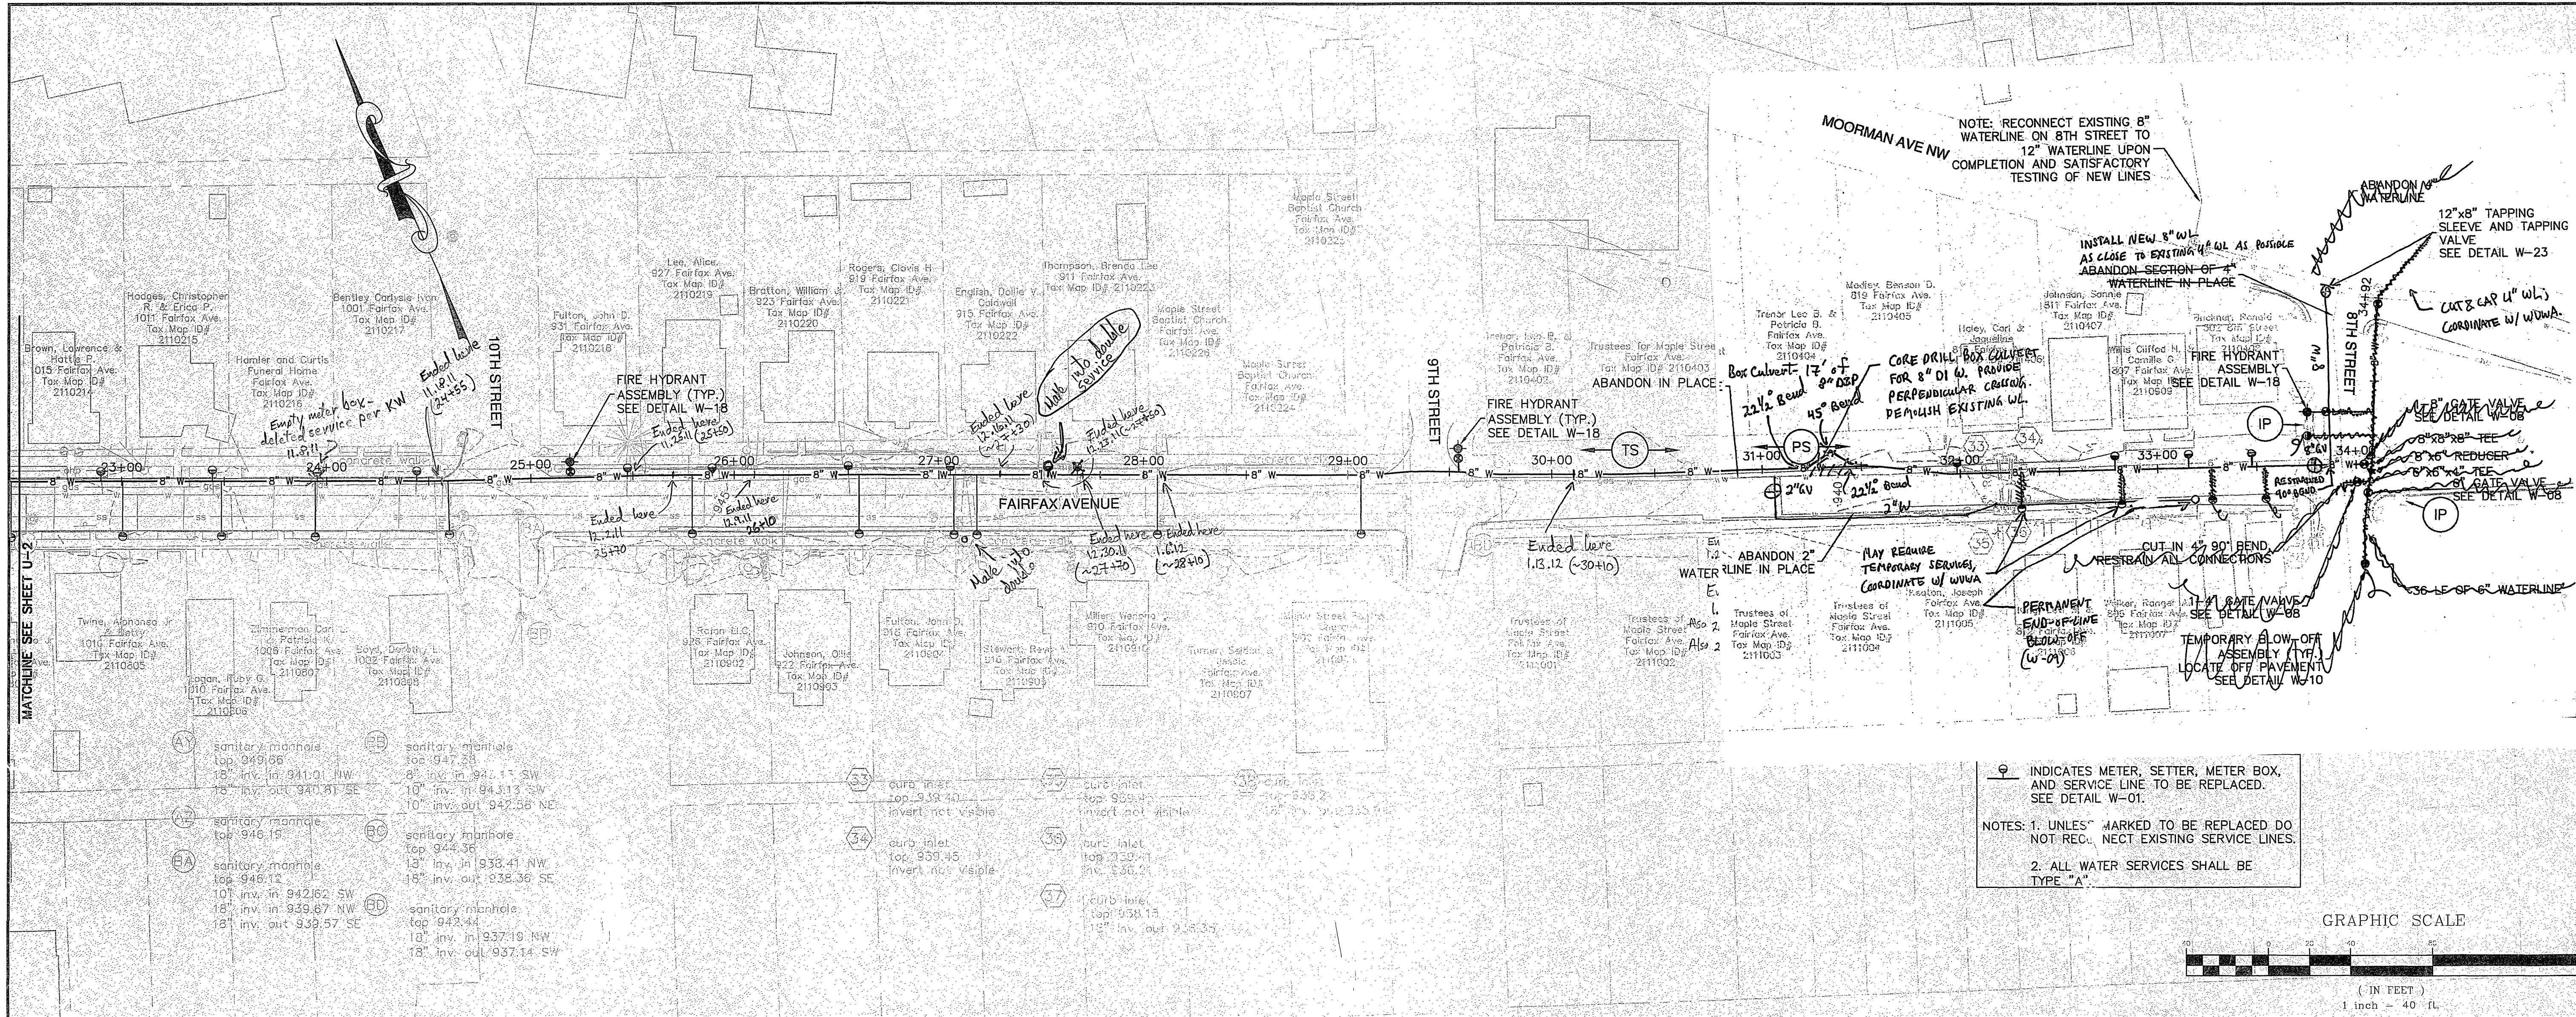

FAIRFAX AVENUE PROFILE - STA. 22+50 TO STA. 34+92
SCALE: H: 1"=40', V: 1"=10'

COMMONWEALTH OF VIRGINIA
RANDALL M. HANCOCK
Lic. No. 14541
11/13/09
PROFESSIONAL ENGINEER

Draper Aden Associates
Engineering • Surveying • Environmental Services
Richmond, VA
Charlottesville, VA
Hampton Roads, VA
Blackburg, VA
Blacksburg, VA
540-552-0444 Fax: 540-552-0291
www.daa.com

FAIRFAX AVE. PLAN AND PROFILE
HARRISON AREA PHASE 3 WATERLINE REPLACEMENTS
CITY OF ROANOKE, VIRGINIA

REVISIONS	
Δ	OCTOBER 15, 2009
Δ	OCTOBER 29, 2009 PER WWA AND CITY OF ROANOKE COMMENTS
Δ	NOVEMBER 12, 2009 PER WWA COMMENTS
APPROVED DEC 14 2009	
DESIGNED BY:	RMH
DRAWN BY:	SAK
CHECKED BY:	TOM
SCALE:	1" = 40'
DATE:	SEPTEMBER 30, 2009
PROJECT NUMBER:	B09134B-01
U-3	