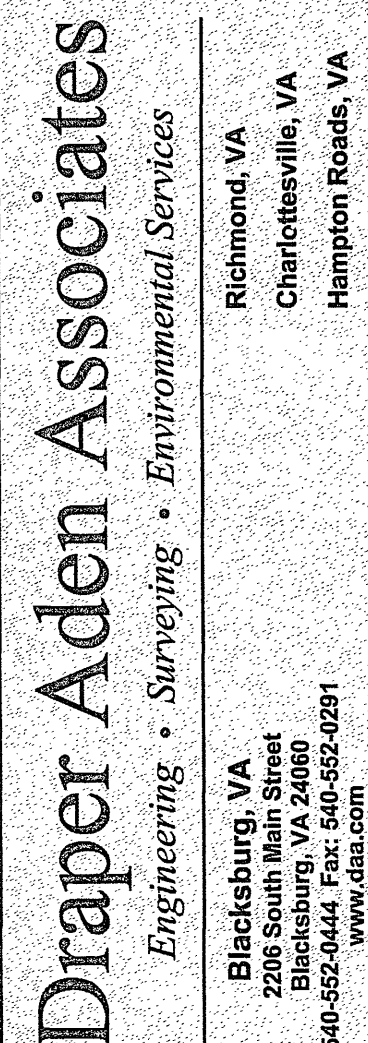


RUTHERFORD AVE. PLAN AND PROFILE
HARRISON AREA PHASE 3 WATERLINE
REPLACEMENT
CITY OF ROANOKE, VIRGINIA

REVISIONS



① OCTOBER 15, 2009

② OCTOBER 29, 2009
PER WVWA AND CITY OF
ROANOKE COMMENTS

APPROVED
DEC 14 2009

DESIGNED BY:	RMH
DRAWN BY:	SAK
CHECKED BY:	TOM
SCALE:	1" = 40'
DATE:	SEPTEMBER 30, 2009
PROJECT NUMBER:	B09134B-01

U-7

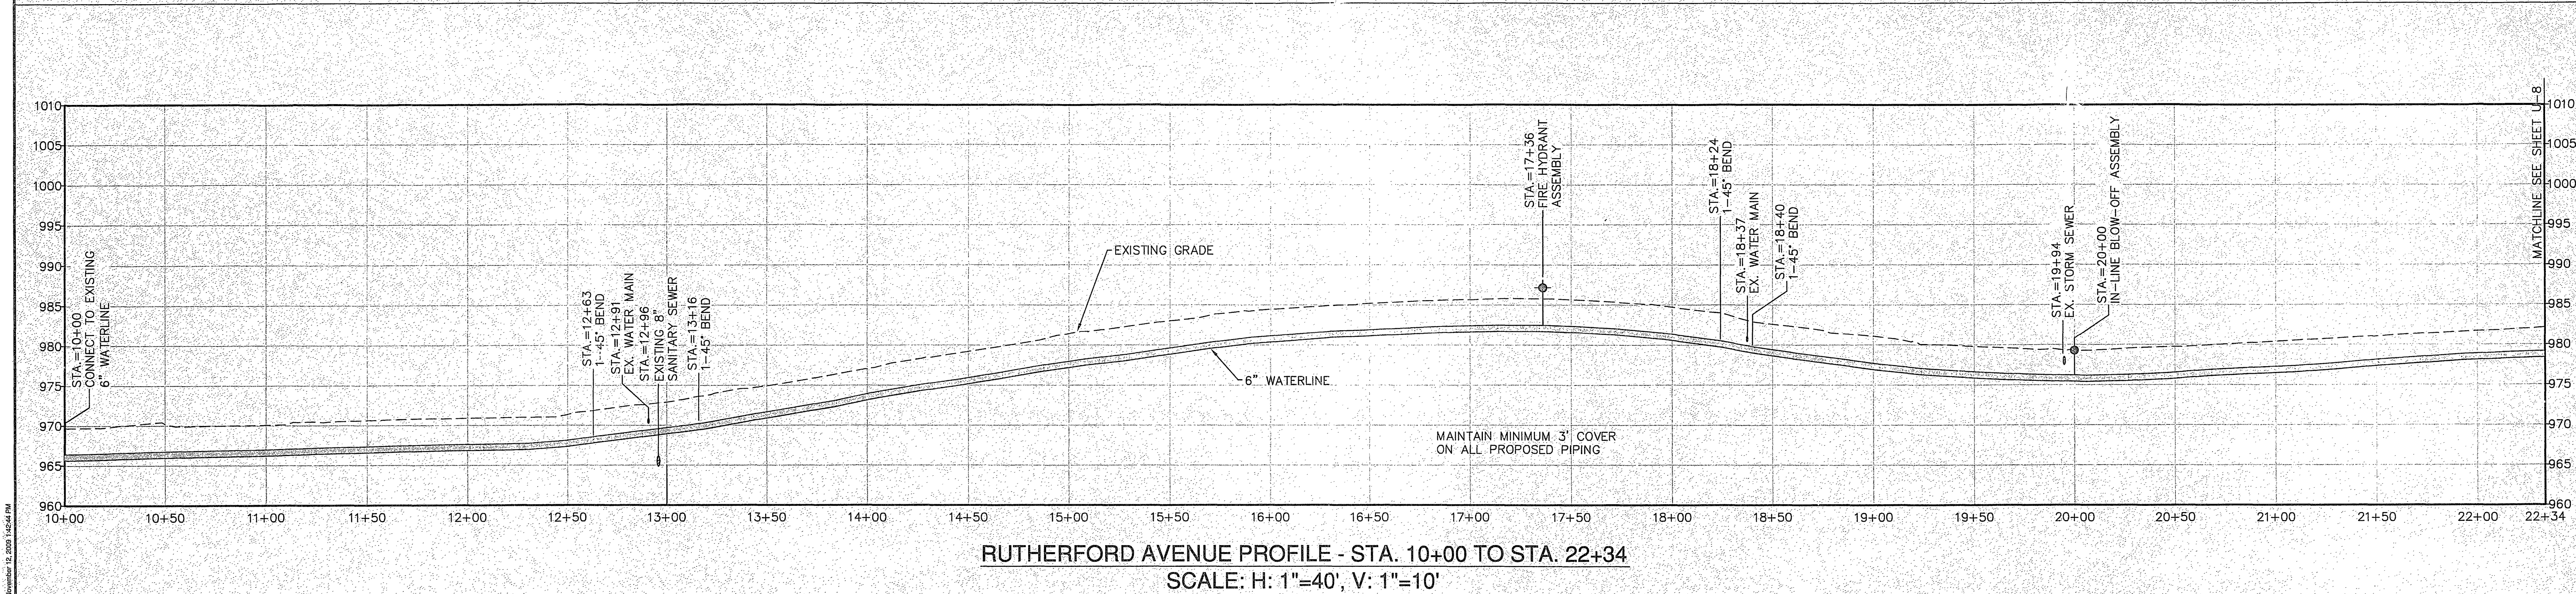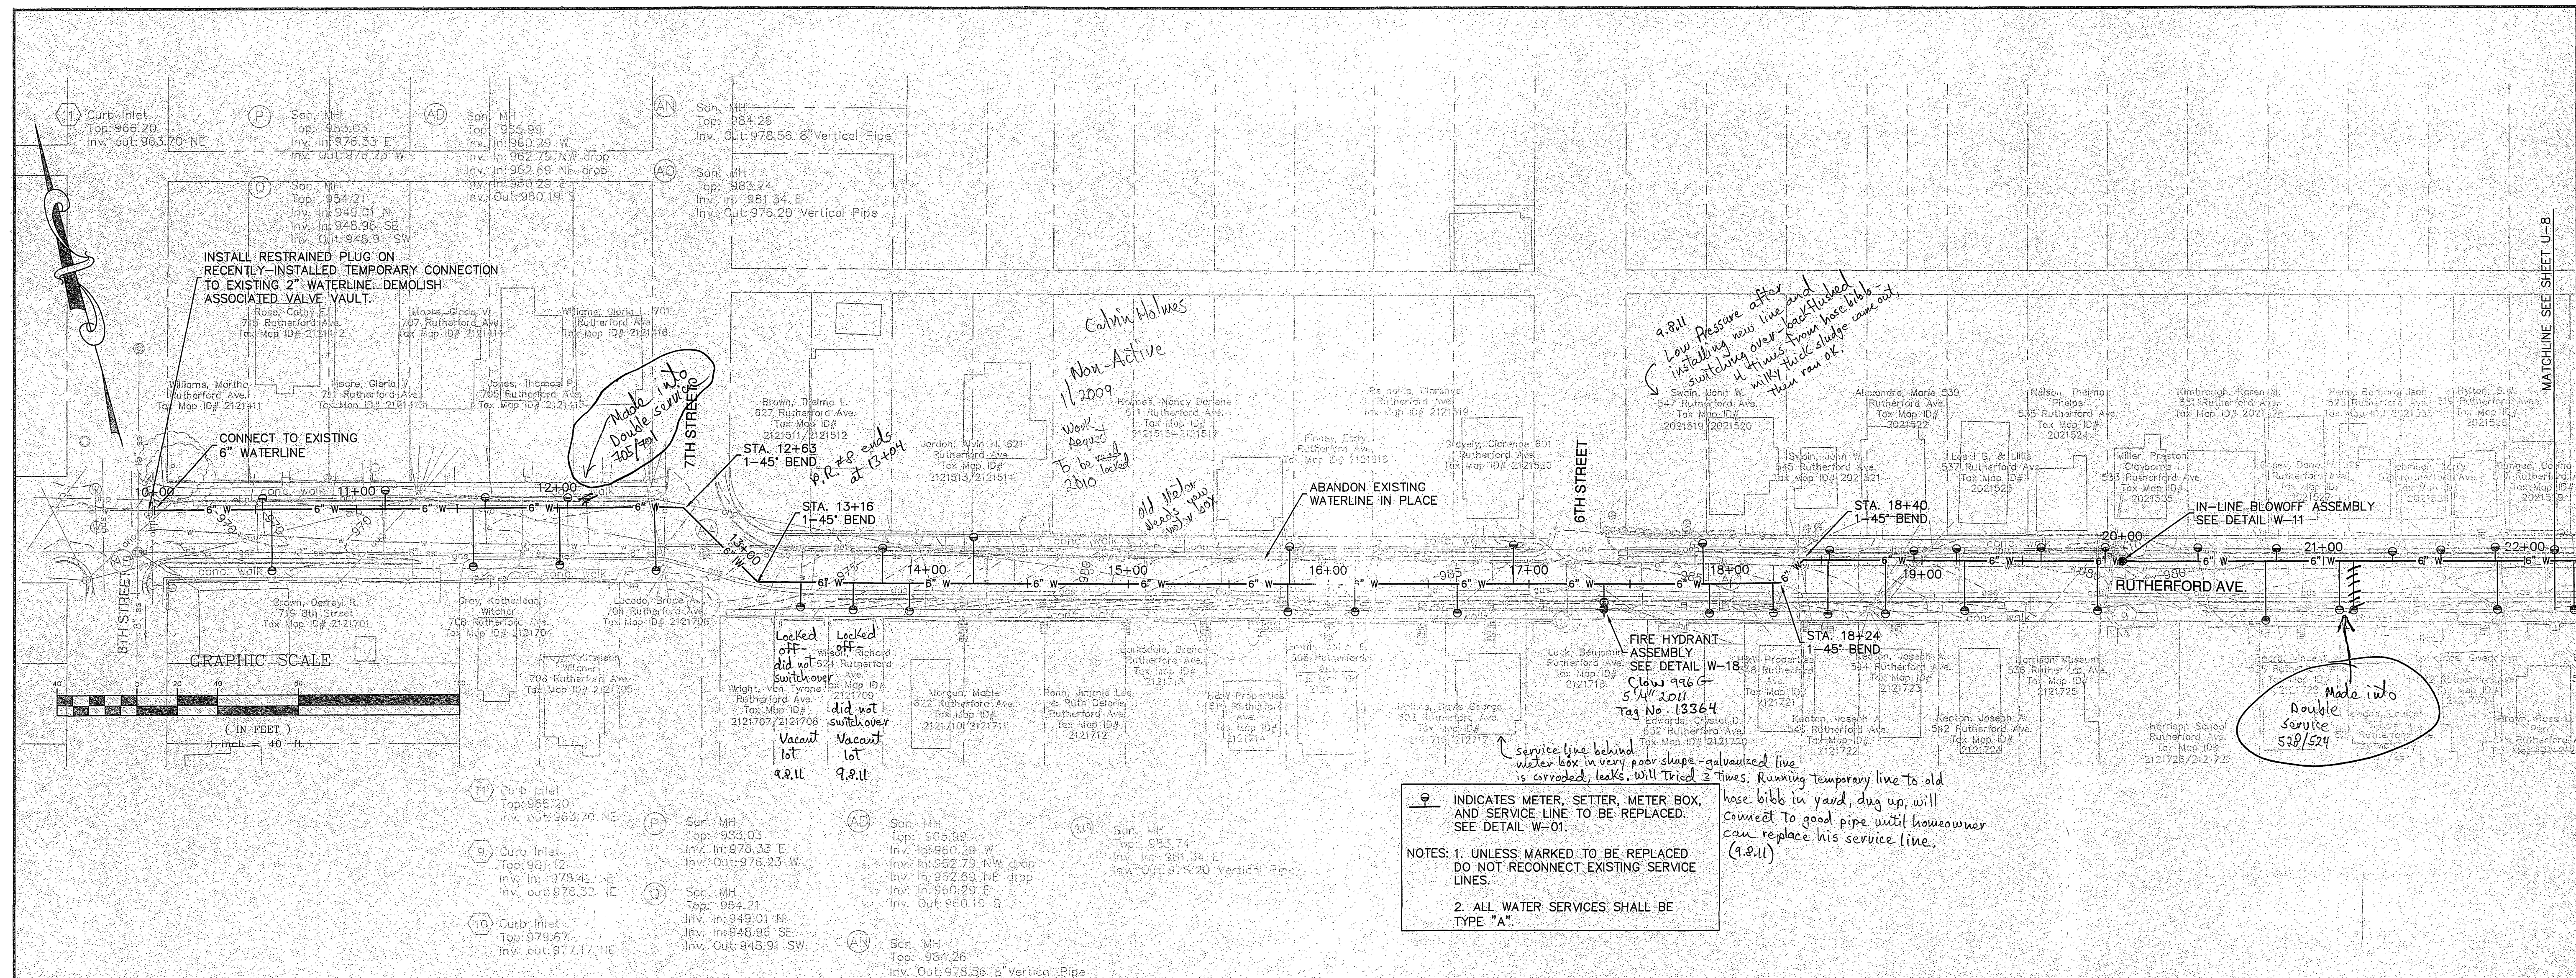

RUTHERFORD AVENUE PROFILE - STA. 10+00 TO STA. 22+34
SCALE: H: 1"=40', V: 1"=10'

$$\begin{array}{r} 1316 \\ 1263 \\ \hline 53 \end{array}$$