
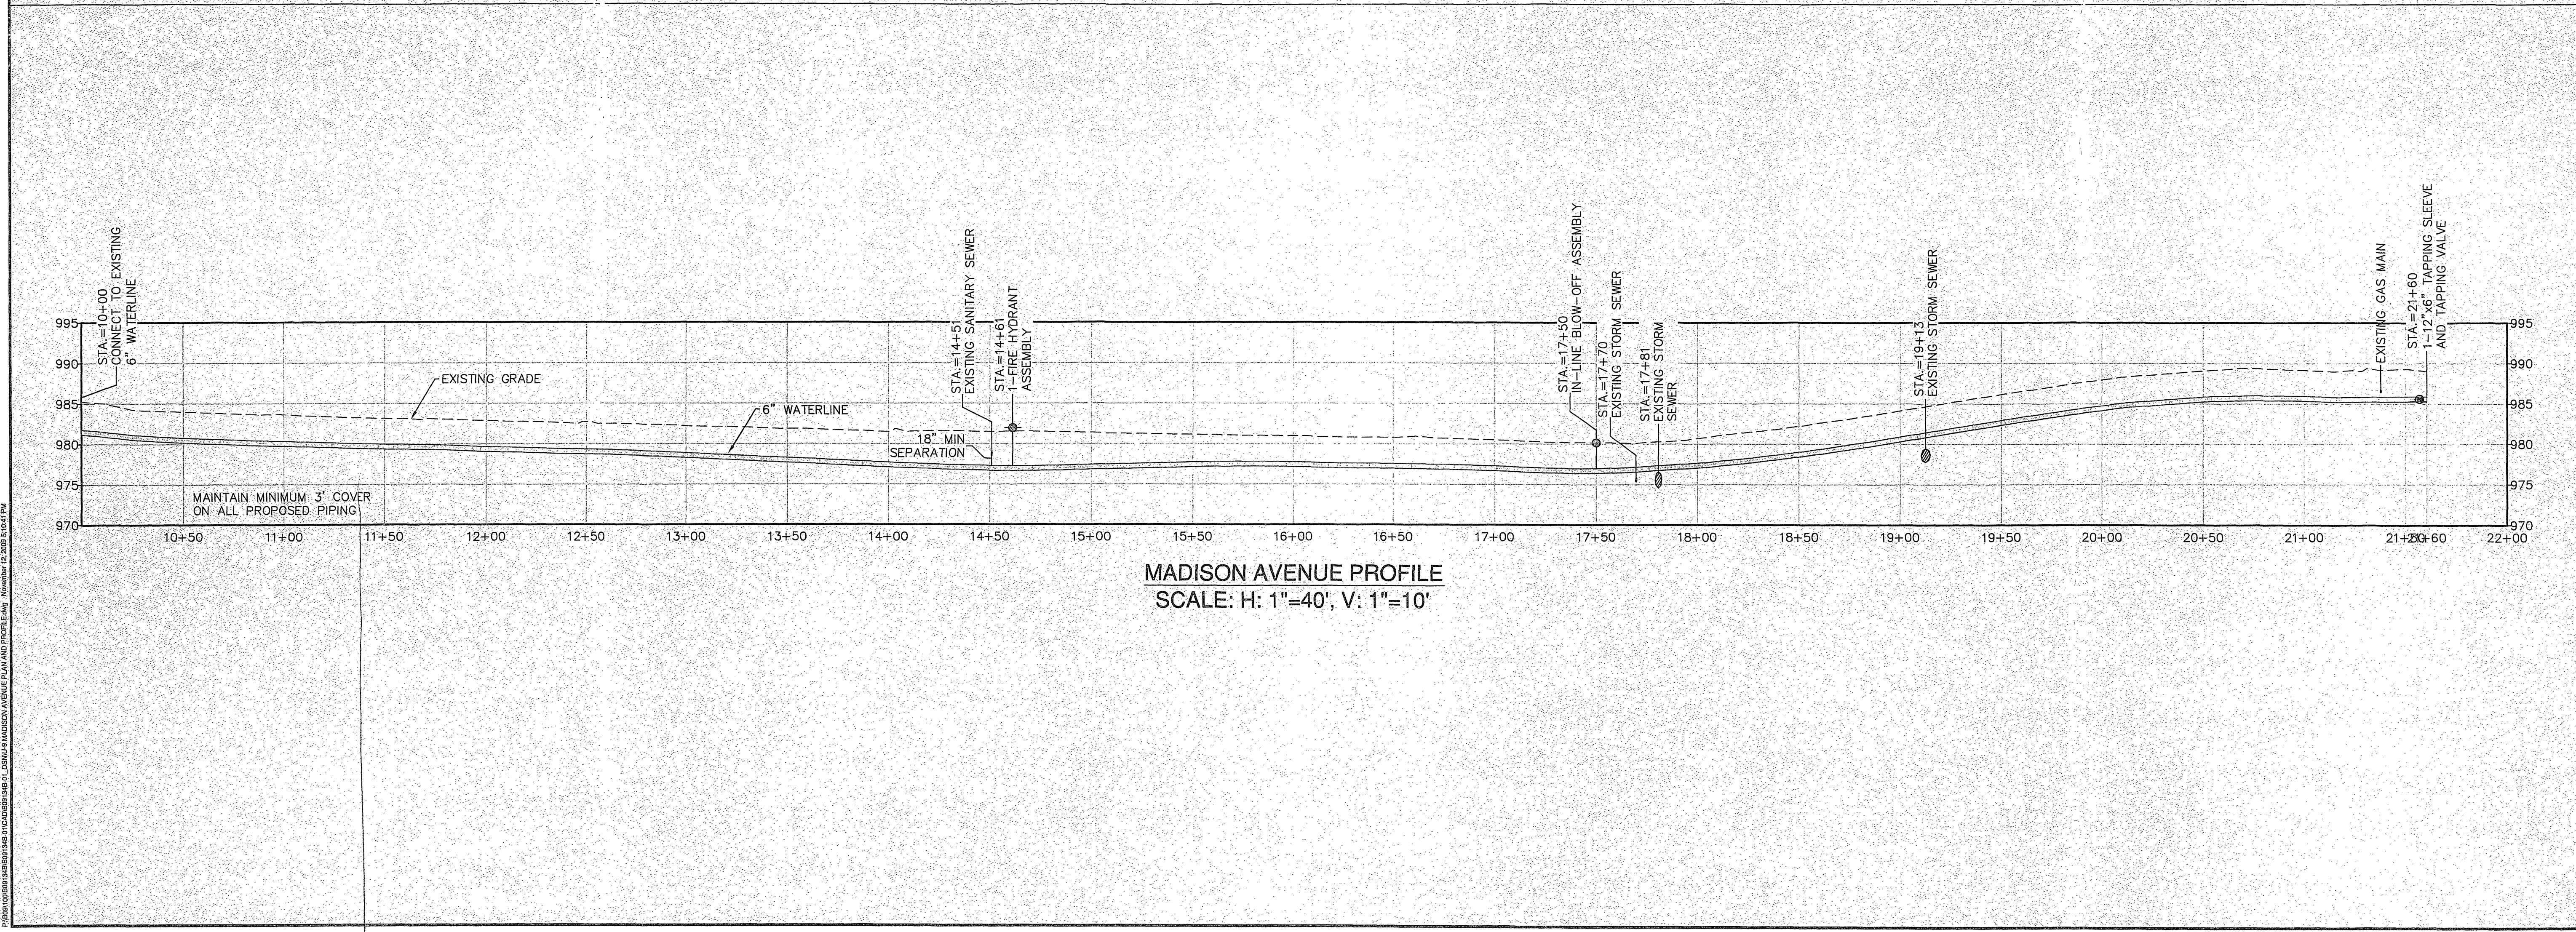


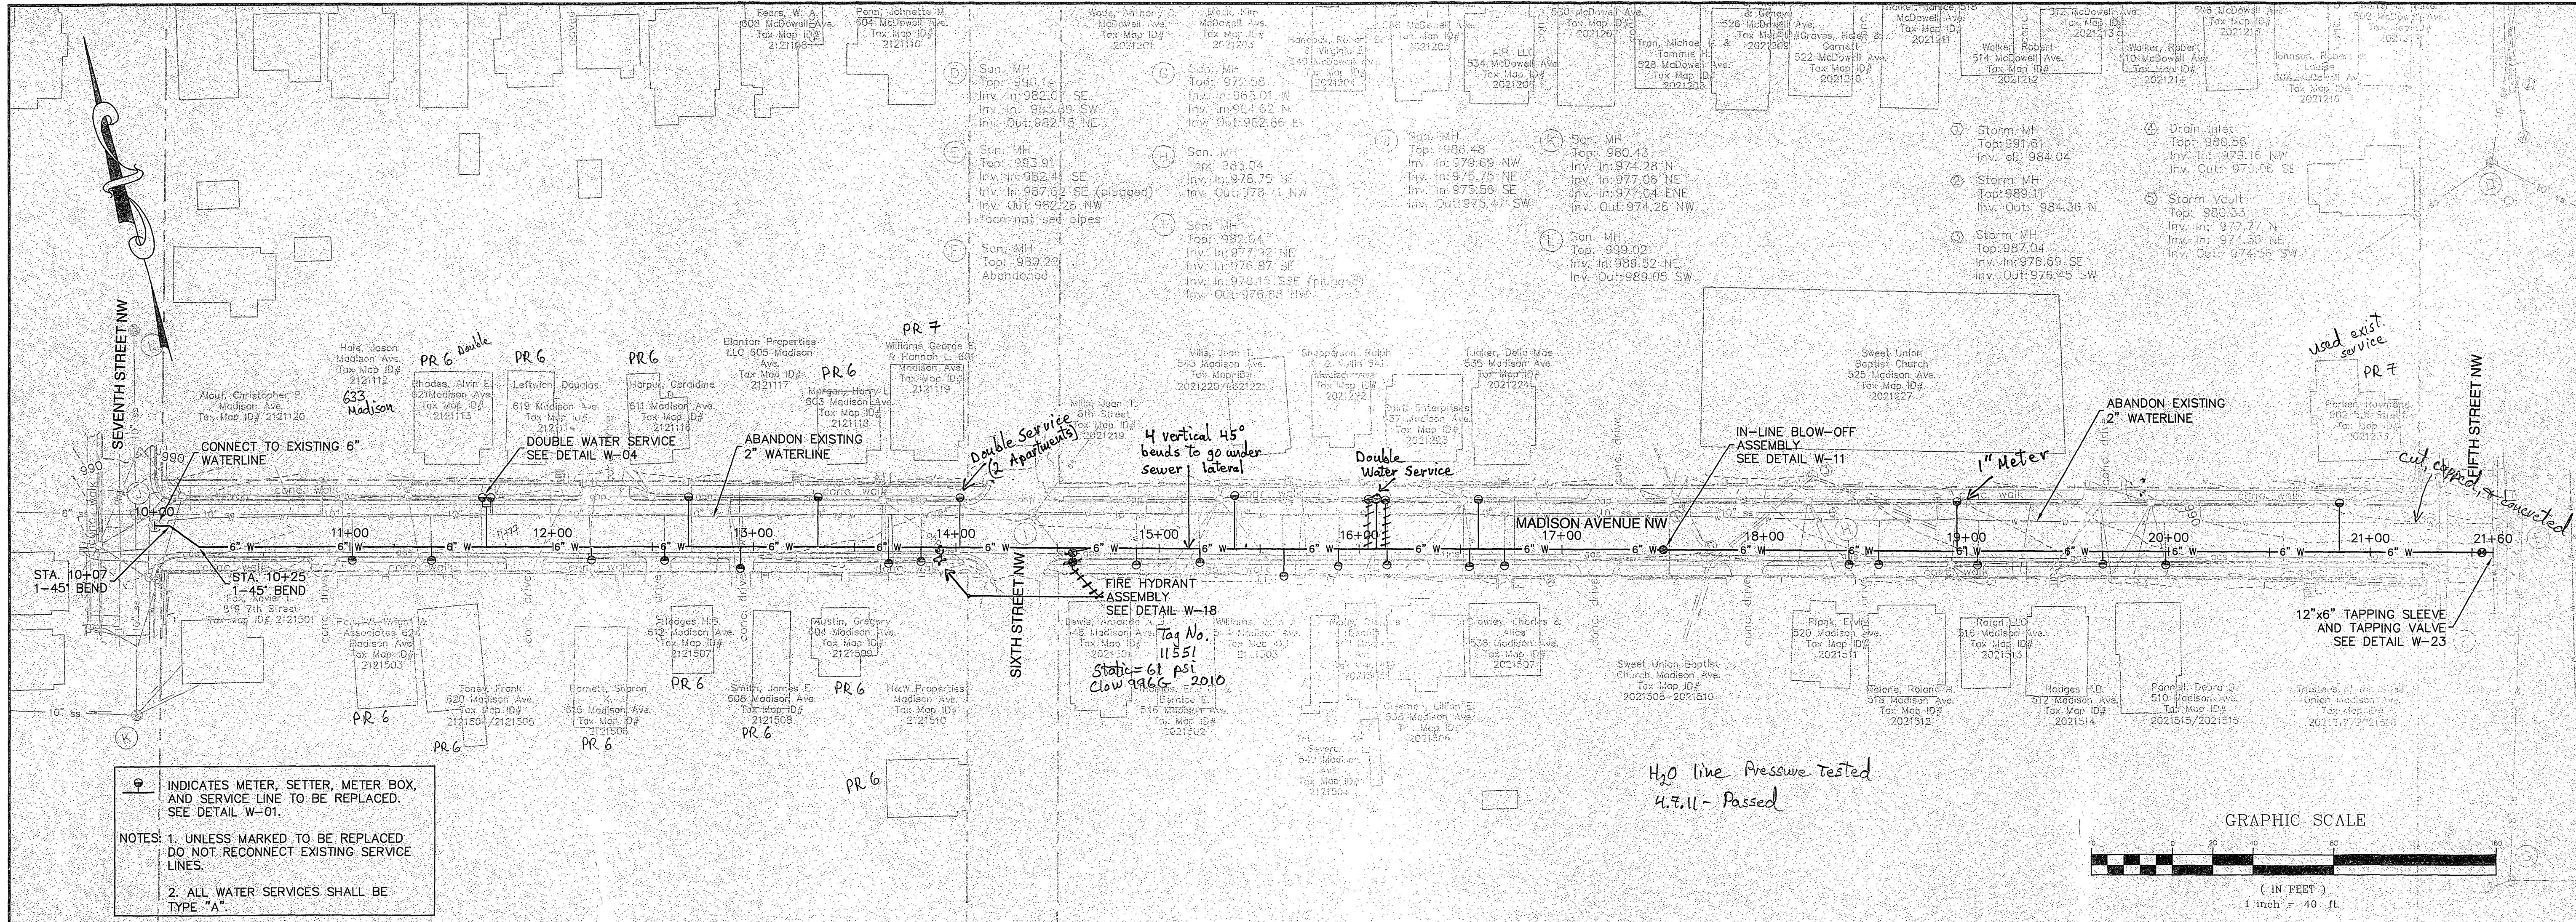

Draper Aden Associates
Engineering • Surveying • Environmental Services
Richmond, VA
Charlottesville, VA
Hampton Roads, VA

MADISON AVE. PLAN AND PROFILE
HARRISON AREA PHASE 3 WATERLINE REPLACEMENTS
CITY OF ROANOKE, VIRGINIA

REVISIONS
 OCTOBER 15, 2009
 OCTOBER 29, 2009 PER WWA AND CITY OF ROANOKE COMMENTS
 NOVEMBER 12, 2009 PER WWA COMMENTS

APPROVED
DEC 14 2009

DESIGNED BY: RMH
 DRAWN BY: SAK
 CHECKED BY: TOM
 SCALE: 1" = 40'
 DATE: SEPTEMBER 30, 2009
 PROJECT NUMBER: B09134B-01

U-9