
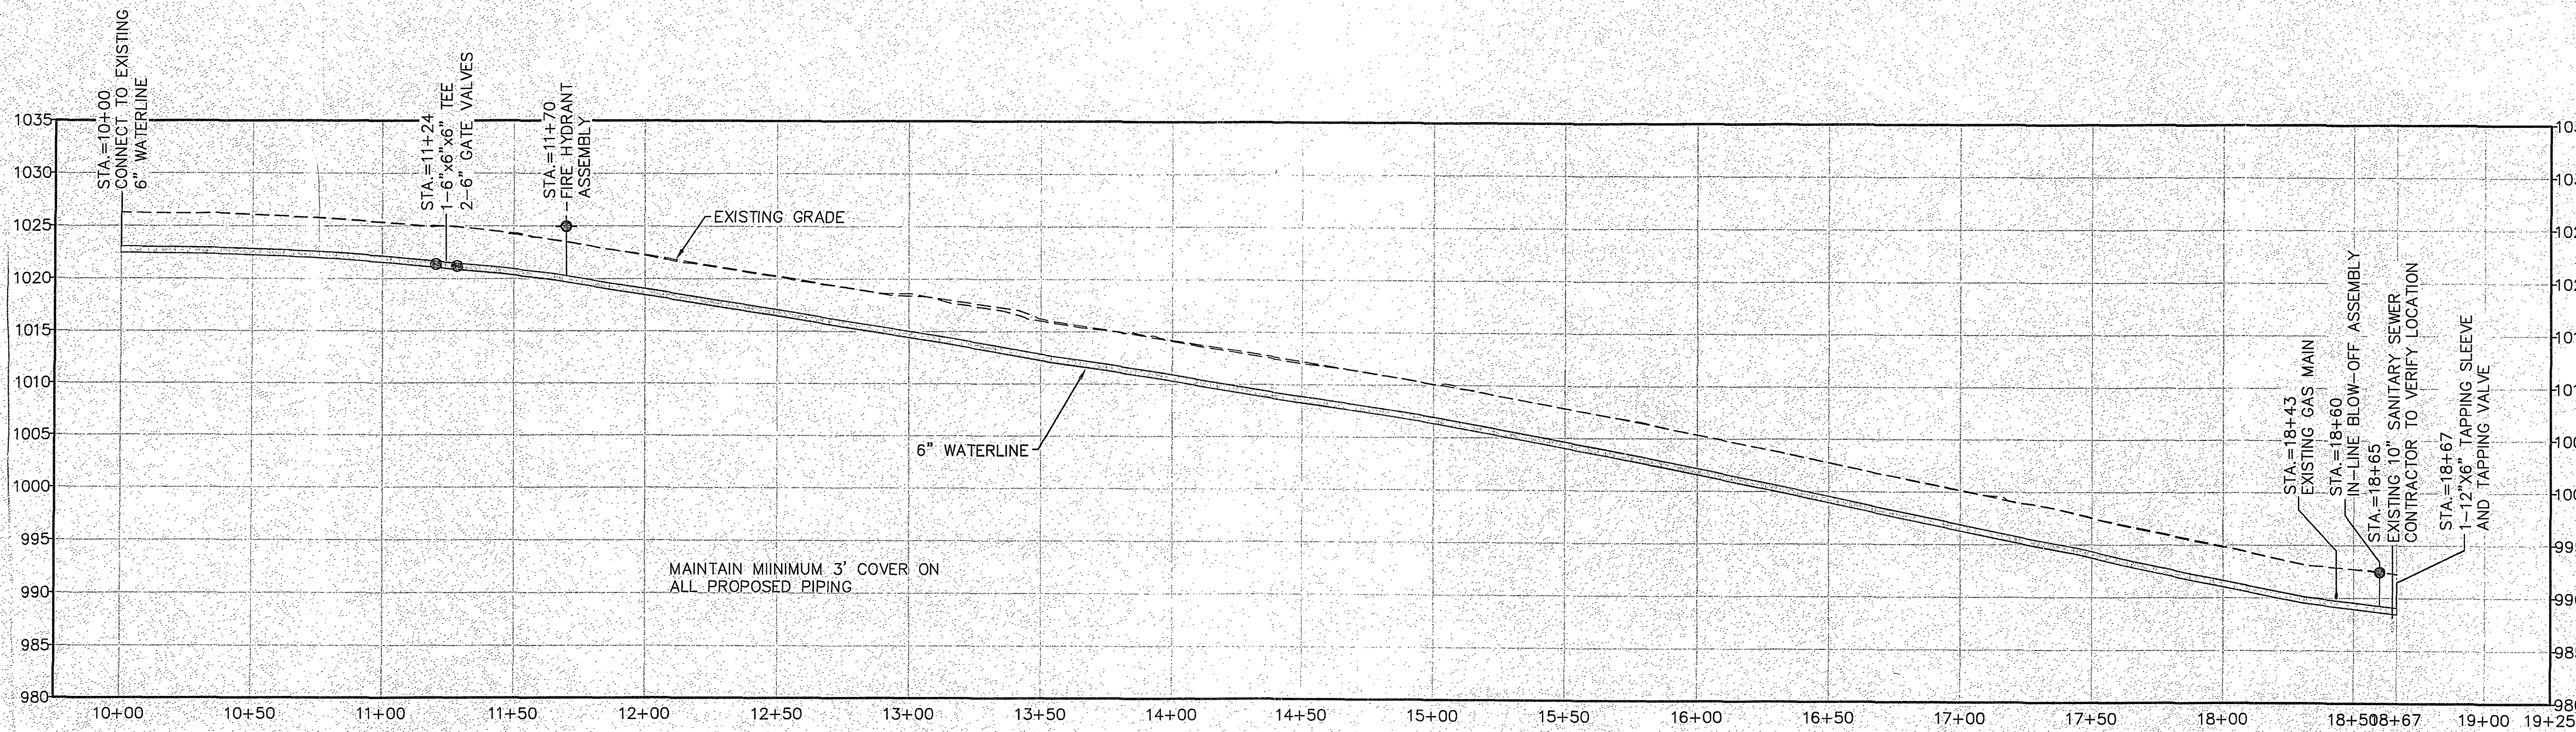
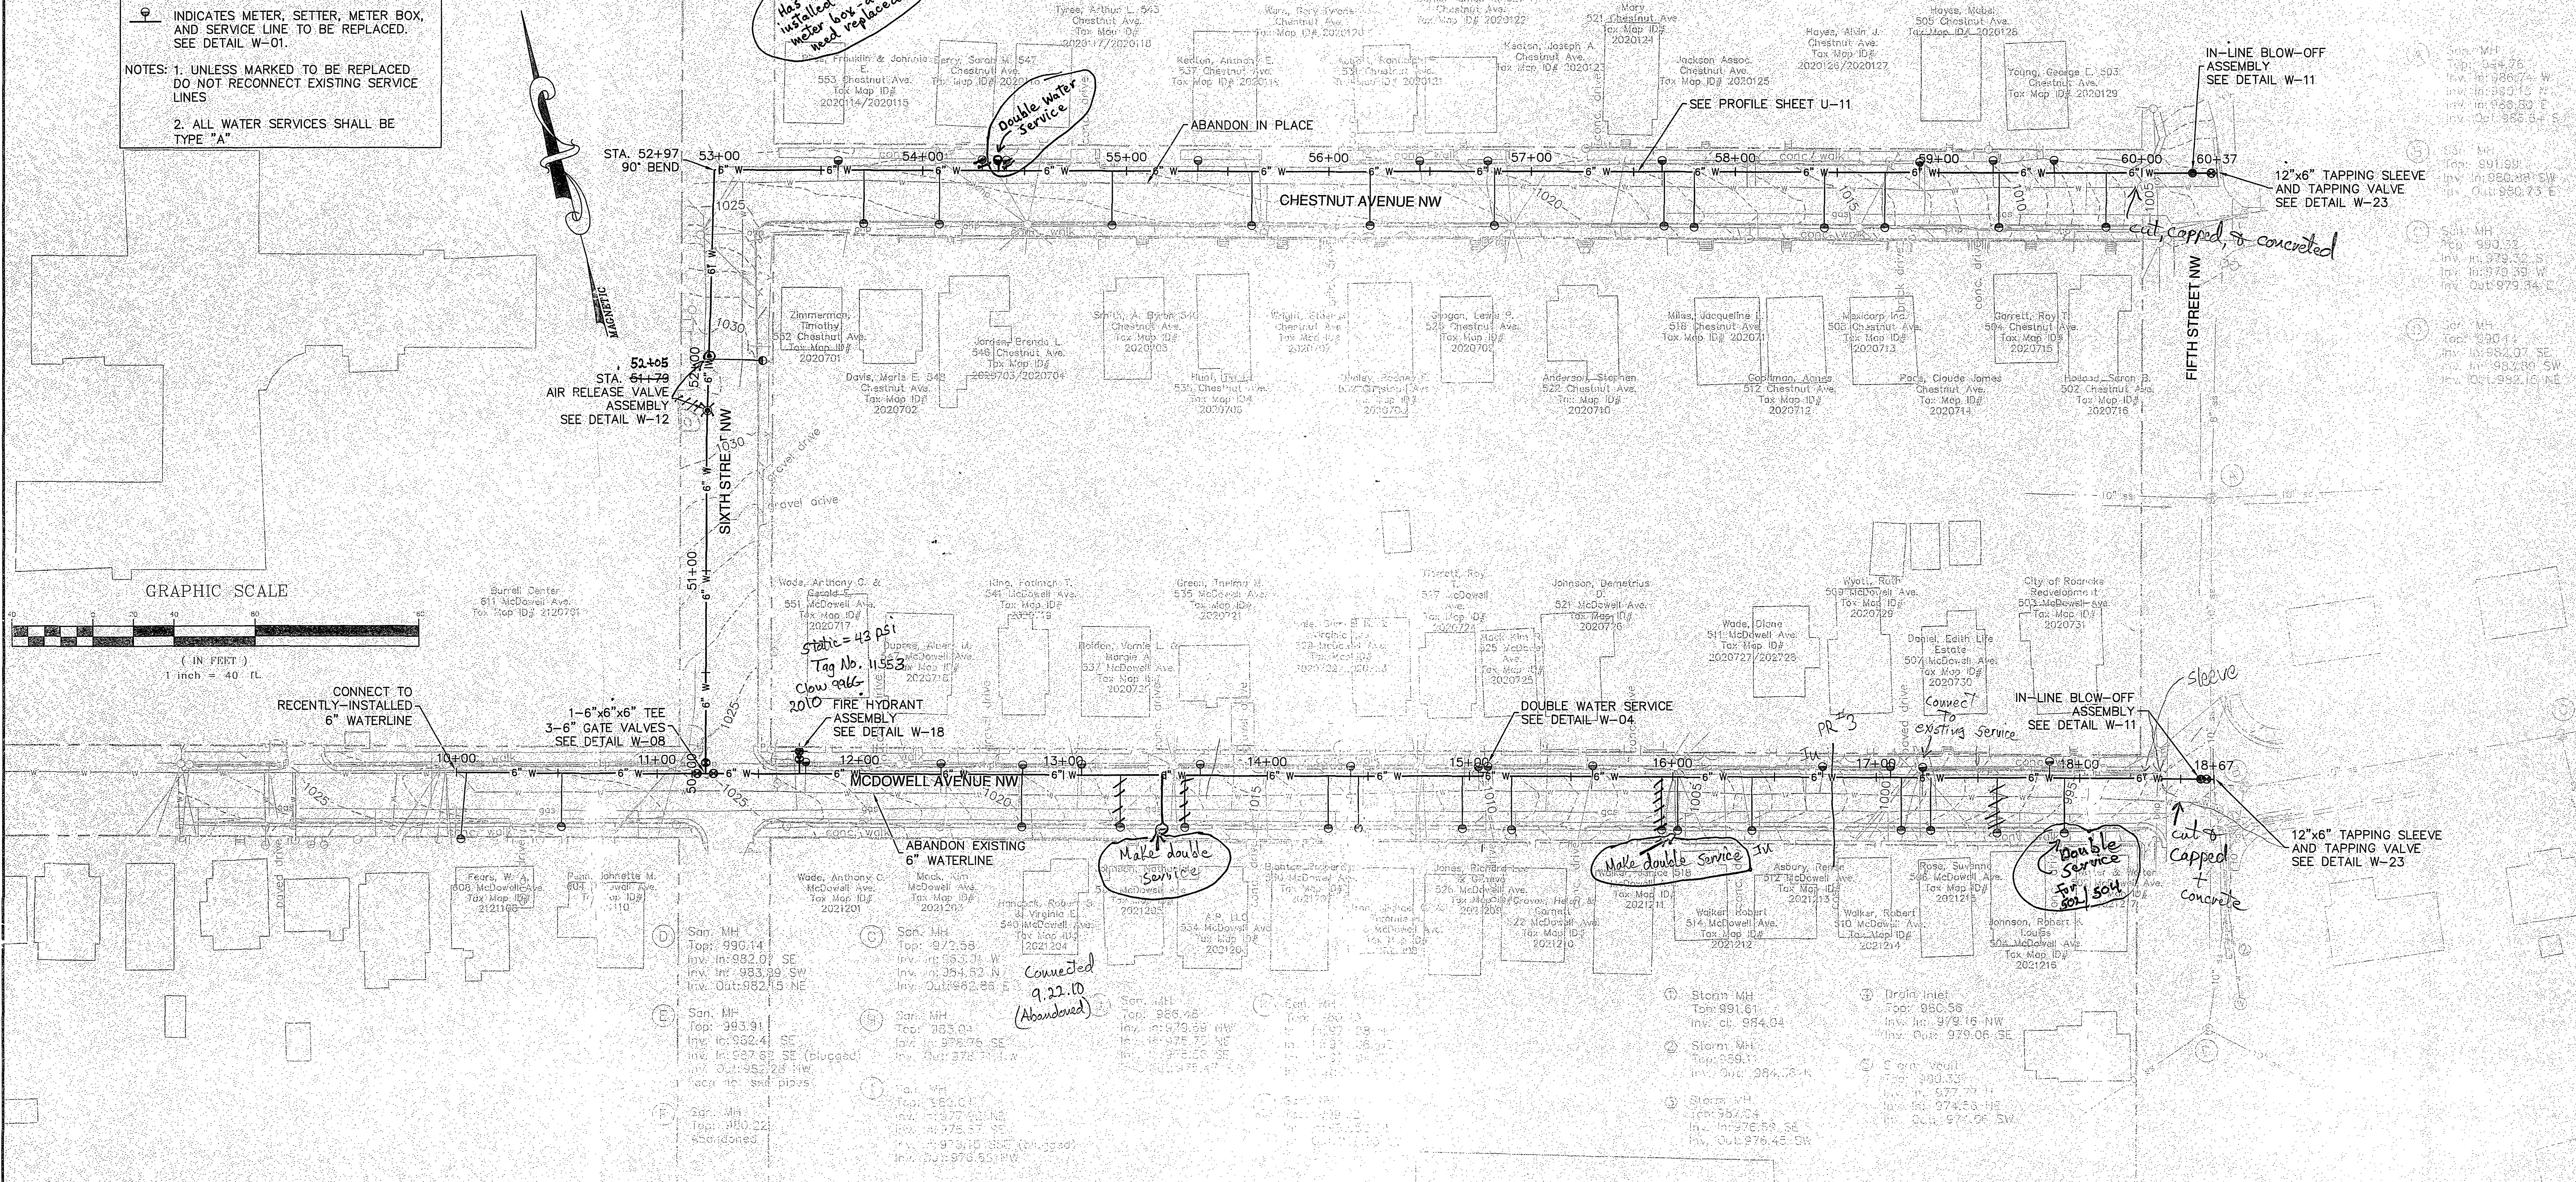


INDICATES METER, SETTER, METER BOX, AND SERVICE LINE TO BE REPLACED. SEE DETAIL W-01.


NOTES: 1. UNLESS MARKED TO BE REPLACED DO NOT RECONNECT EXISTING SERVICE LINES

2. ALL WATER SERVICES SHALL BE TYPE "A"

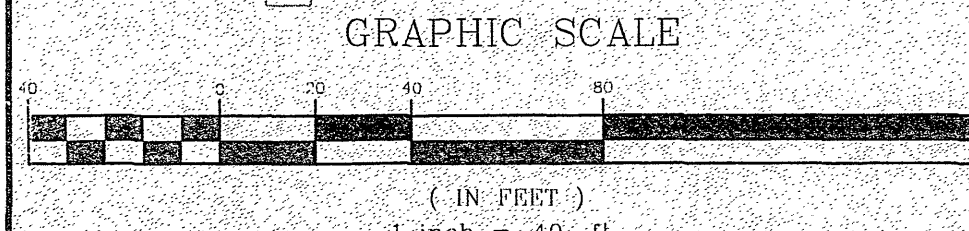

MCDOWELL AVENUE PROFILE

SCALE: H: 1"=40', V: 1"=10'

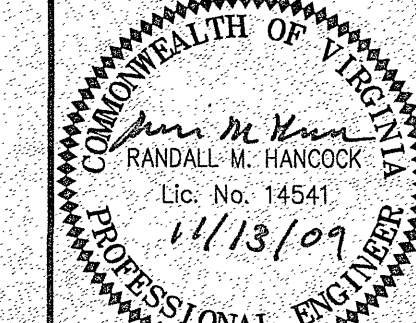

Draper Aden Associates

Engineering • Surveying • Environmental Services

Richmond, VA
Charlottesville, VA
Hampton Roads, VA

Blackburg, VA
2206 South Main Street
Blackburg, VA 22022
540-552-4291
www.daa.com

MCDOWELL AVE. PLAN AND PROFILE

HARRISON AREA PHASE 3 WATERLINE REPLACEMENTS

CITY OF ROANOKE, VIRGINIA

REVISIONS	
1	OCTOBER 15, 2009
2	OCTOBER 29, 2009 PER VVWA AND CITY OF ROANOKE COMMENTS
3	NOVEMBER 12, 2009 PER VVWA COMMENTS
APPROVED DEC 14 2009	
DESIGNED BY:	RMH
DRAWN BY:	SAK
CHECKED BY:	TOM
SCALE:	1" = 40'
DATE:	SEPTEMBER 30, 2009
PROJECT NUMBER:	B09134B-01
U-10	