





Draper Aden Associates
Engineering • Surveying • Environmental Services
2000 South Main Street, Suite A
Blacksburg, VA 24060
540-532-6444 • Fax: 540-532-6291
www.daa.com

Virginia Beach, VA • Hampton Roads, VA • Charlottesville, VA • Lynchburg, VA • Roanoke, VA • Salem, VA • Staunton, VA • Virginia Beach, VA

PLAN AND PROFILE
HARVEST LANE SEWER EXTENSION
ROANOKE, VIRGINIA

REVISIONS
REVISION NO. 1
DATE 11-1-97
BY JES
CHECKED BY JES
DESIGNED BY JES
DRAWN BY JES
PROJECT NO. 200004-06
SHEET NO. C-1

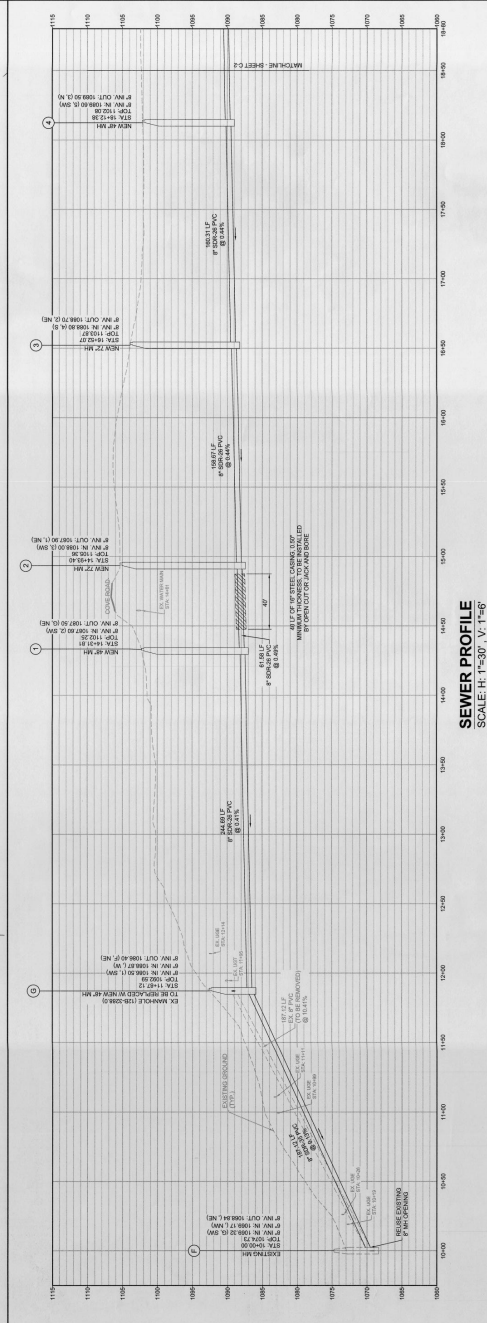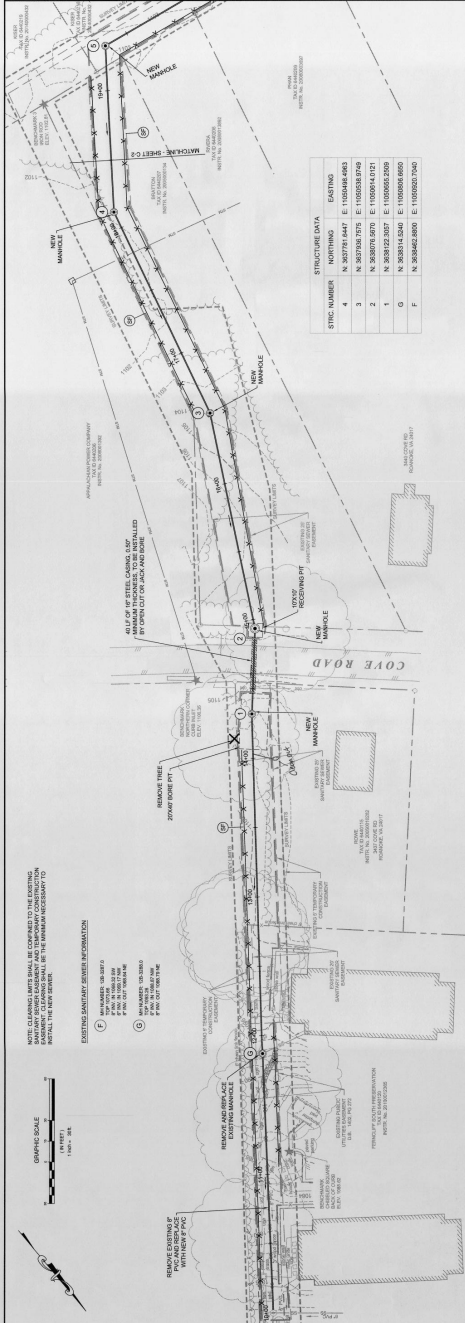

SEWER PROFILE
SCALE: H: 1"=30', V: 1"=6'