



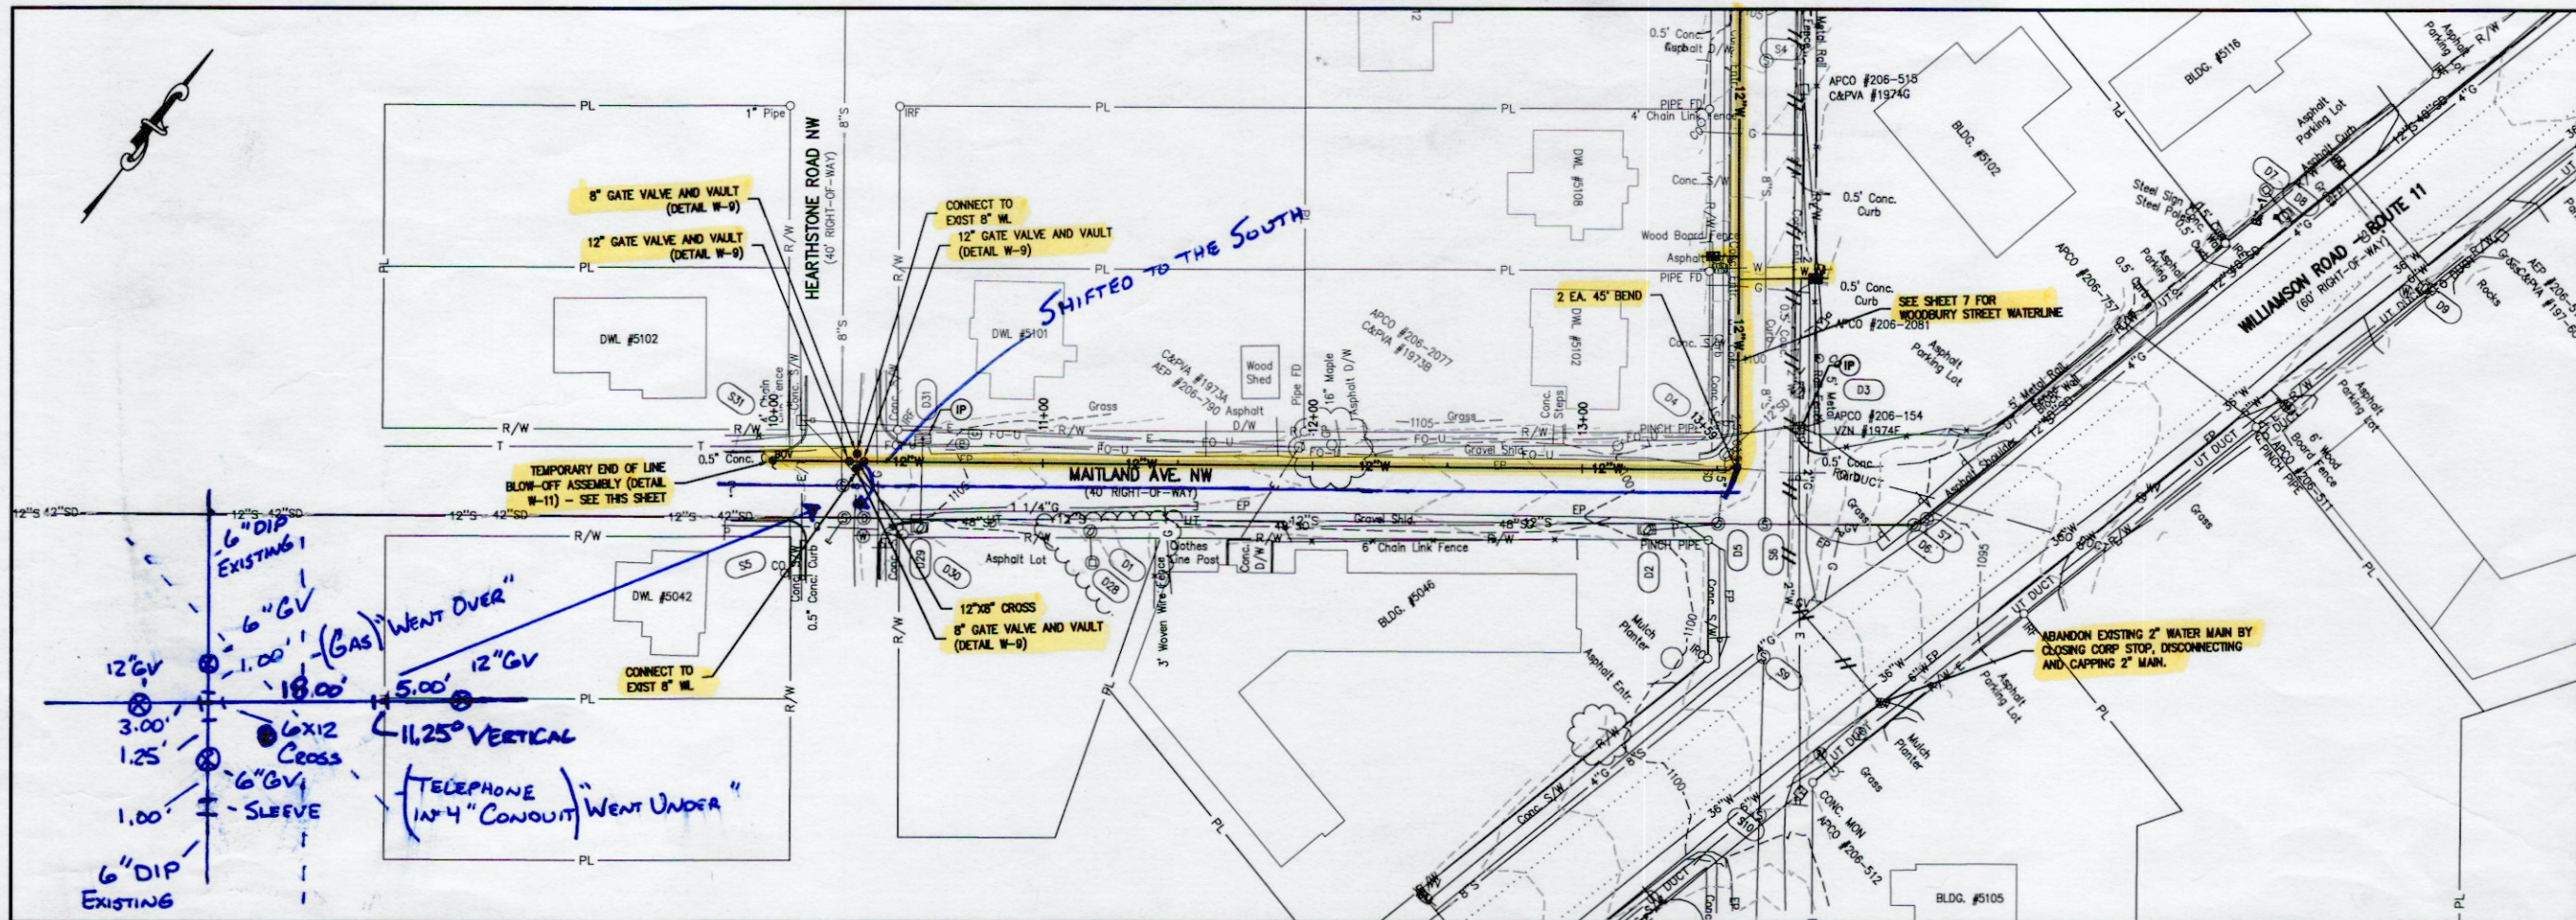

Issue Date:	NOV. 25, 2020
Drawn By:	DBL/AB
Designed By:	DB
Checked By:	BCC
Date:	11/25/2020

Mattern & Craig
ENGINEERS/SURVEYORS
701 FIRST STREET, S.W.
ROANOKE, VIRGINIA 24016
(540) 345-3342
FAX (540) 345-7691

1. THE 12\"/>

 
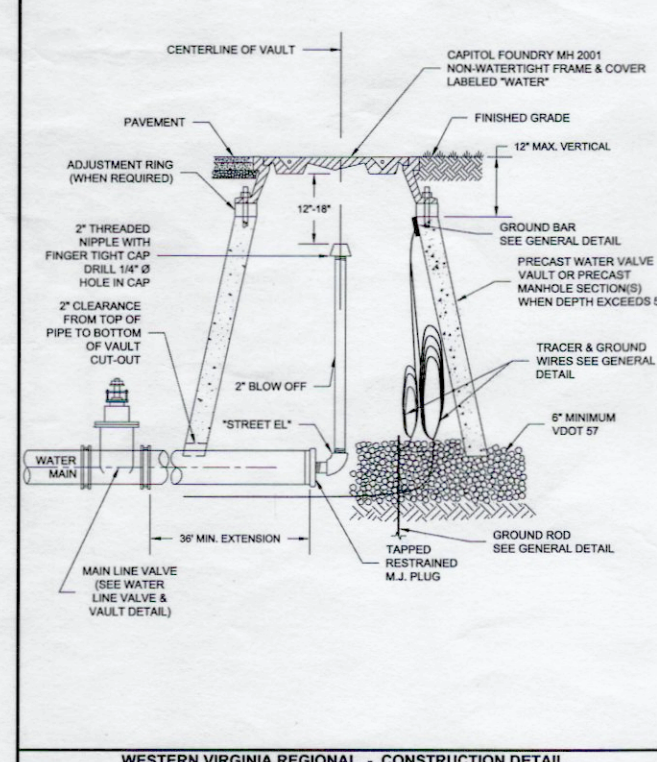


WESTERN VIRGINIA REGIONAL - CONSTRUCTION DETAIL

TEMPORARY END OF LINE BLOW-OFF ASSEMBLY

W-11

12 INCH WATERLINE - MAITLAND AVE. PROFILE

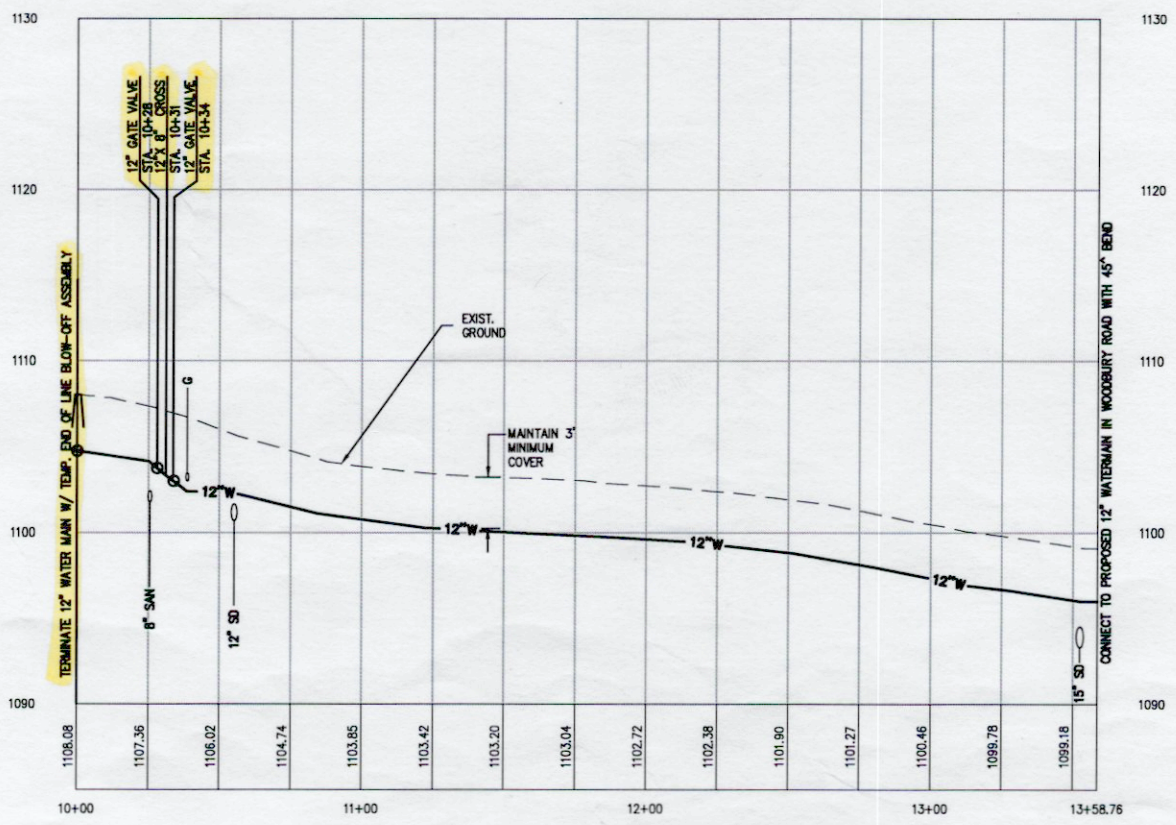

HAMTHORNE ROAD AREA WATERLINE REPLACEMENT PROJECT

PLAN AND PROFILE -
MAITLAND AVENUE
ROANOKE, VIRGINIA

Vertical Scale:	1" = 5'
Horizontal Scale:	1" = 30'
Commission Number:	3942
Sheet No.:	5

Ctry