



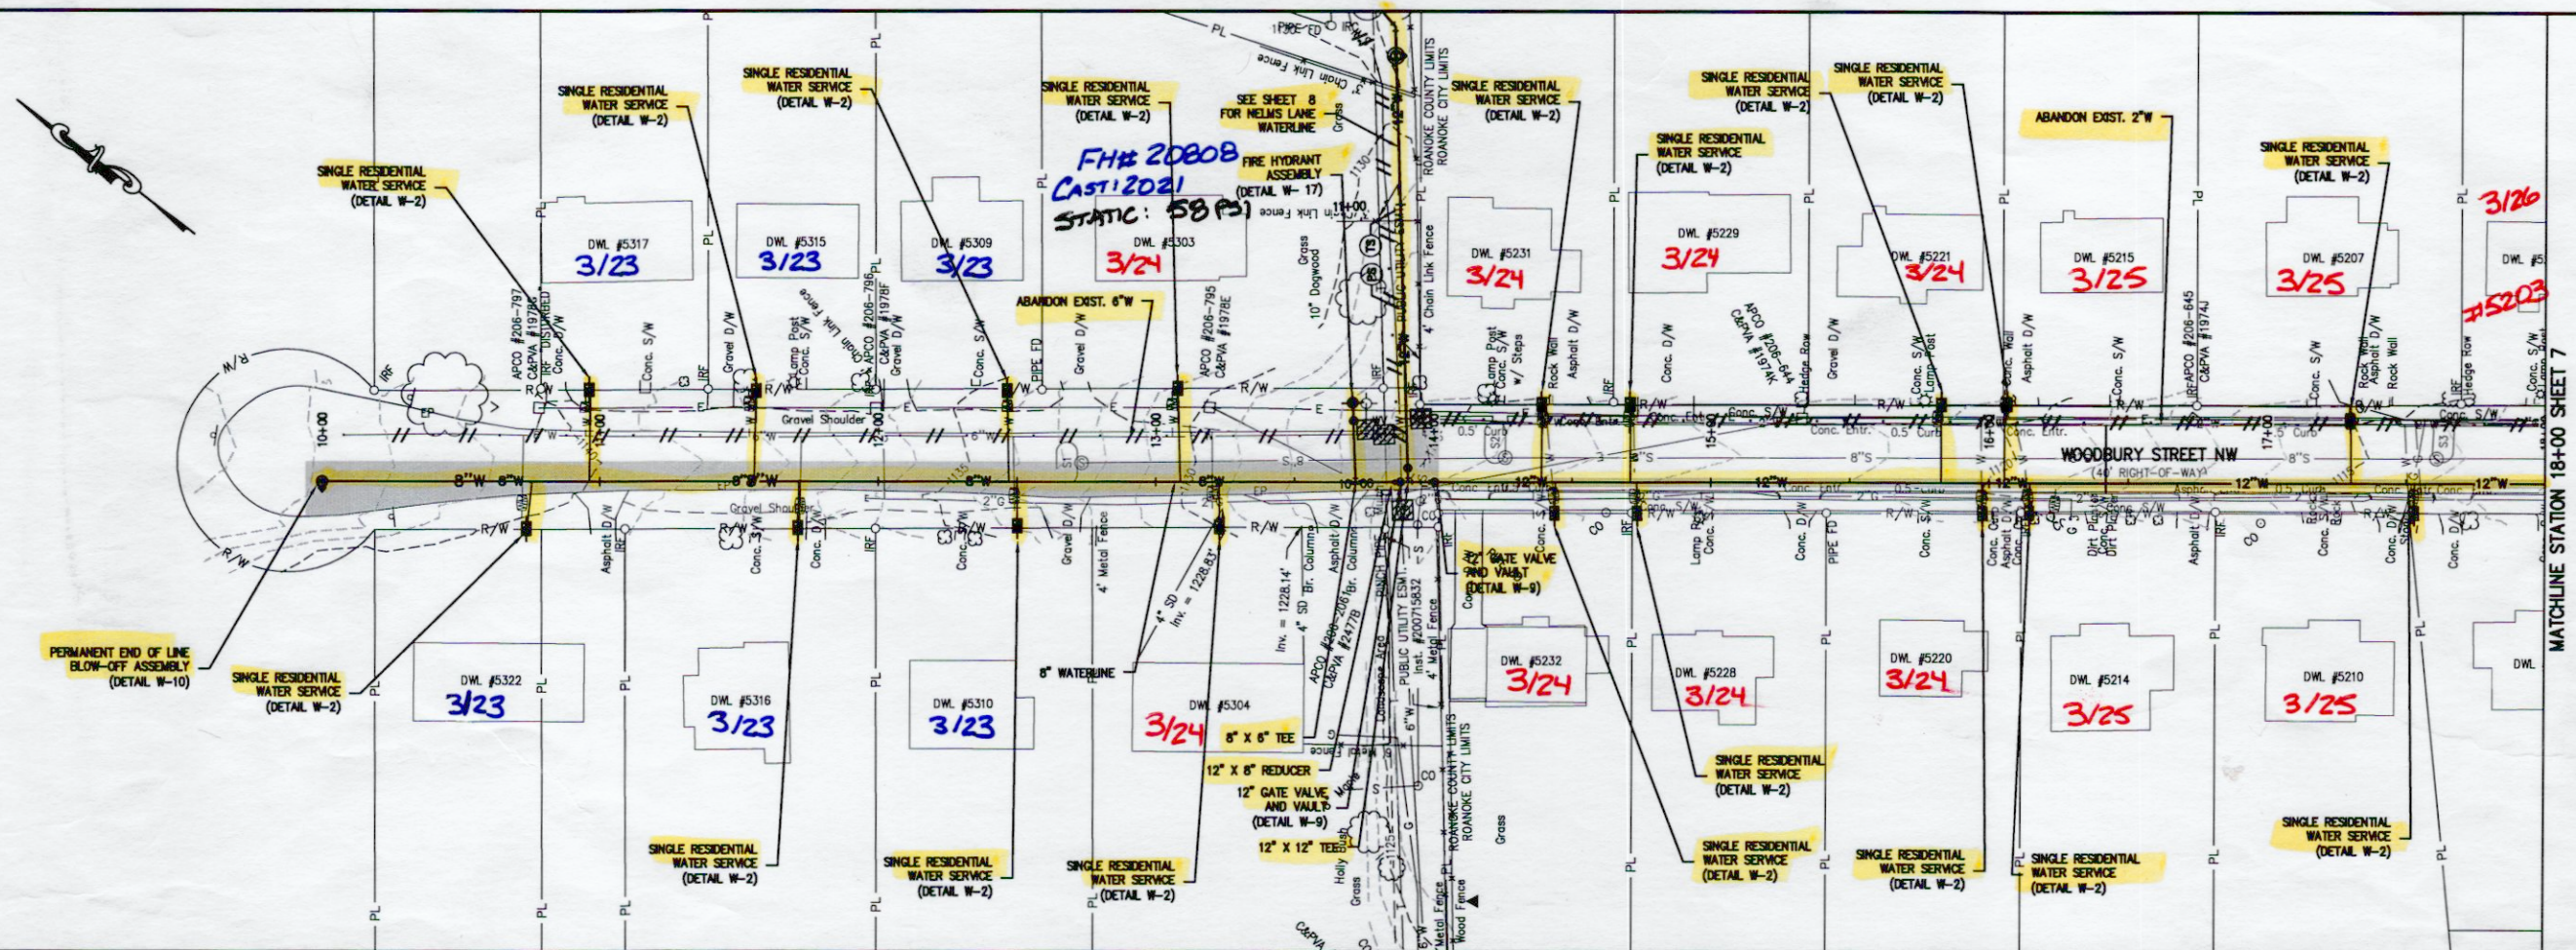

8 INCH & 12 INCH WATERLINE - WOODBURY ST. PROFILE

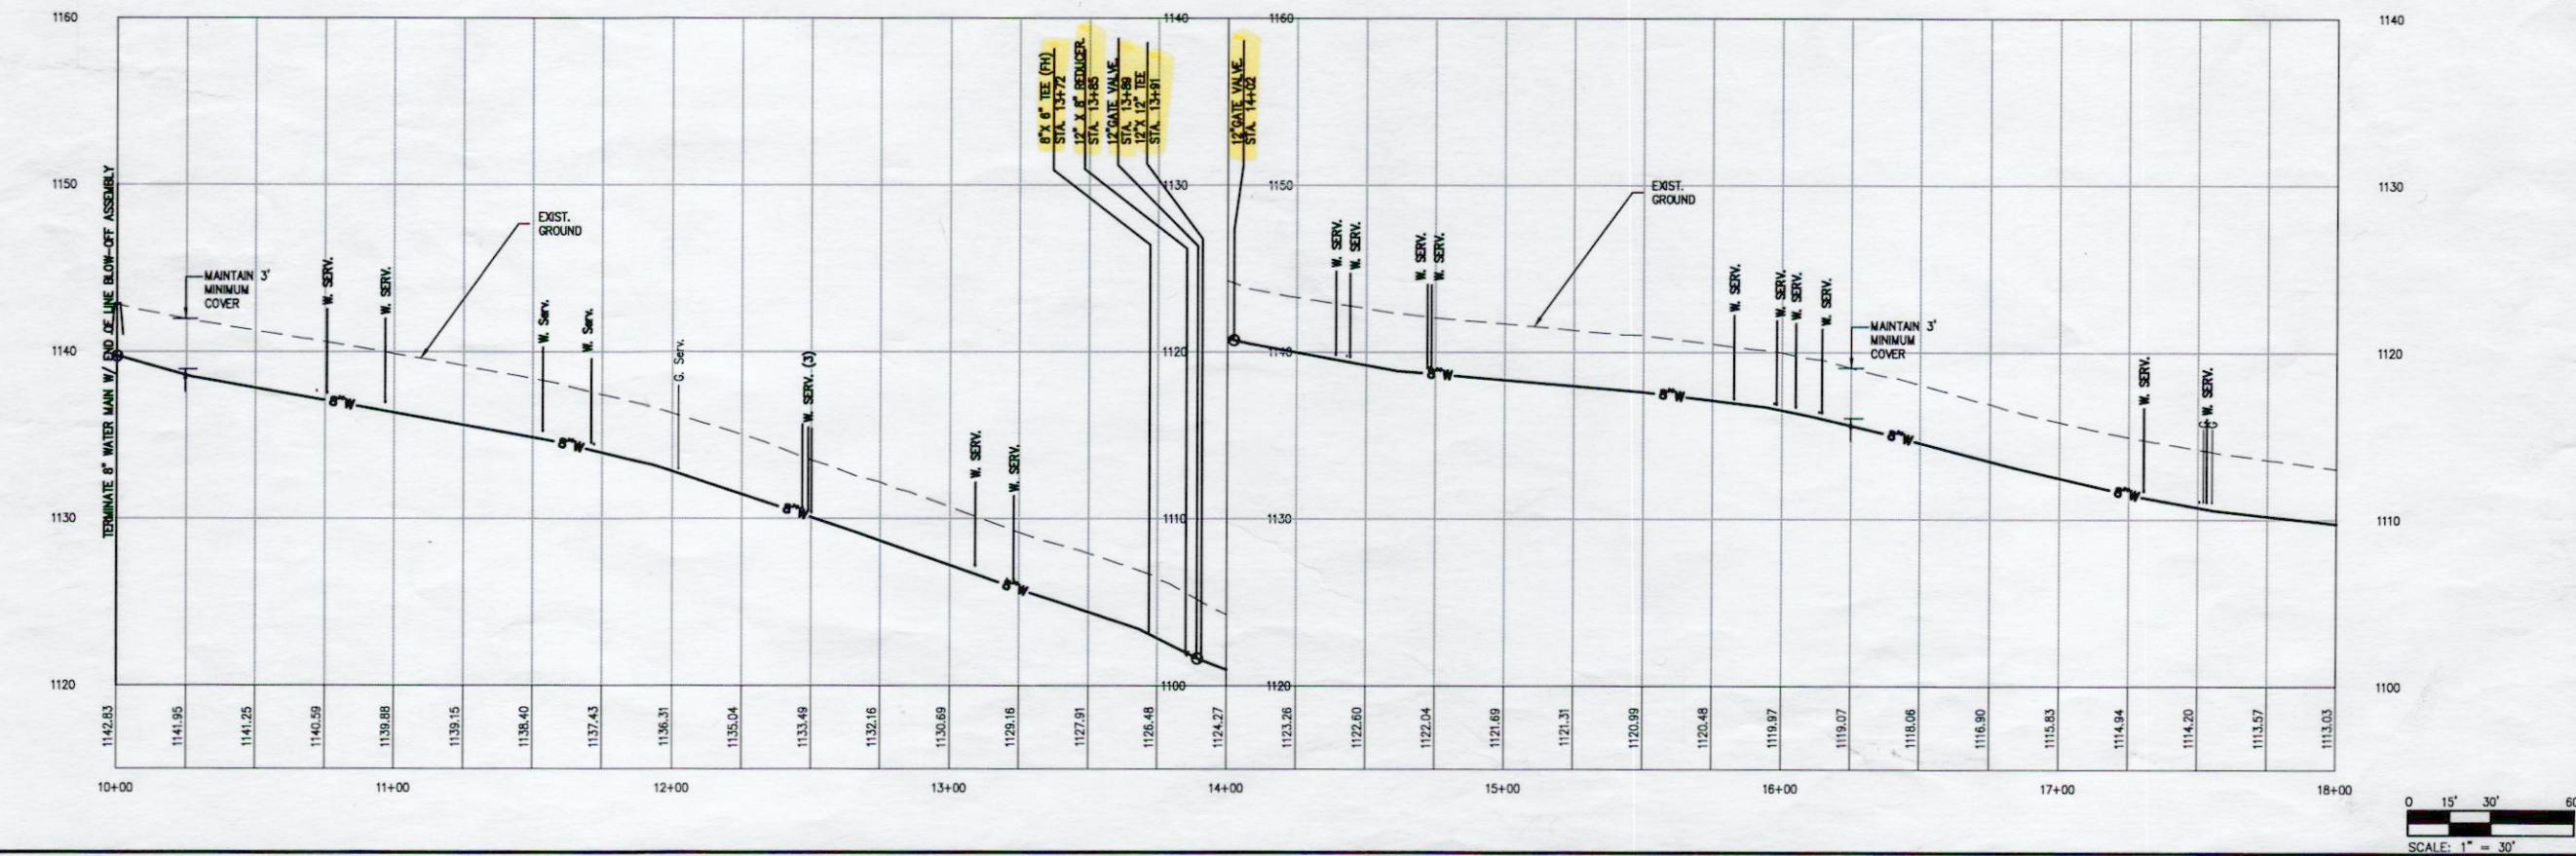

Revisions

Date	Revisions

Issue Date:
NOV. 25, 2020

Drawn By: DBL/ARB

Designed By: DBL

Checked By: BCC

Date: 11/25/2020

Mattern & Craig
ENGINEERS/SURVEYORS

701 FIRST STREET, S.W.
ROANOKE, VIRGINIA 24016
(540) 345-5492
FAX (540) 345-7691

HAWTHORNE ROAD AREA WATERLINE REPLACEMENT PROJECT

PLAN AND PROFILE -

WOODBURY STREET

ROANOKE, VIRGINIA

Vertical Scale:
1" = 5'

Horizontal Scale:
1" = 30'

Commission Number:
3942

Sheet No.:
6