
 
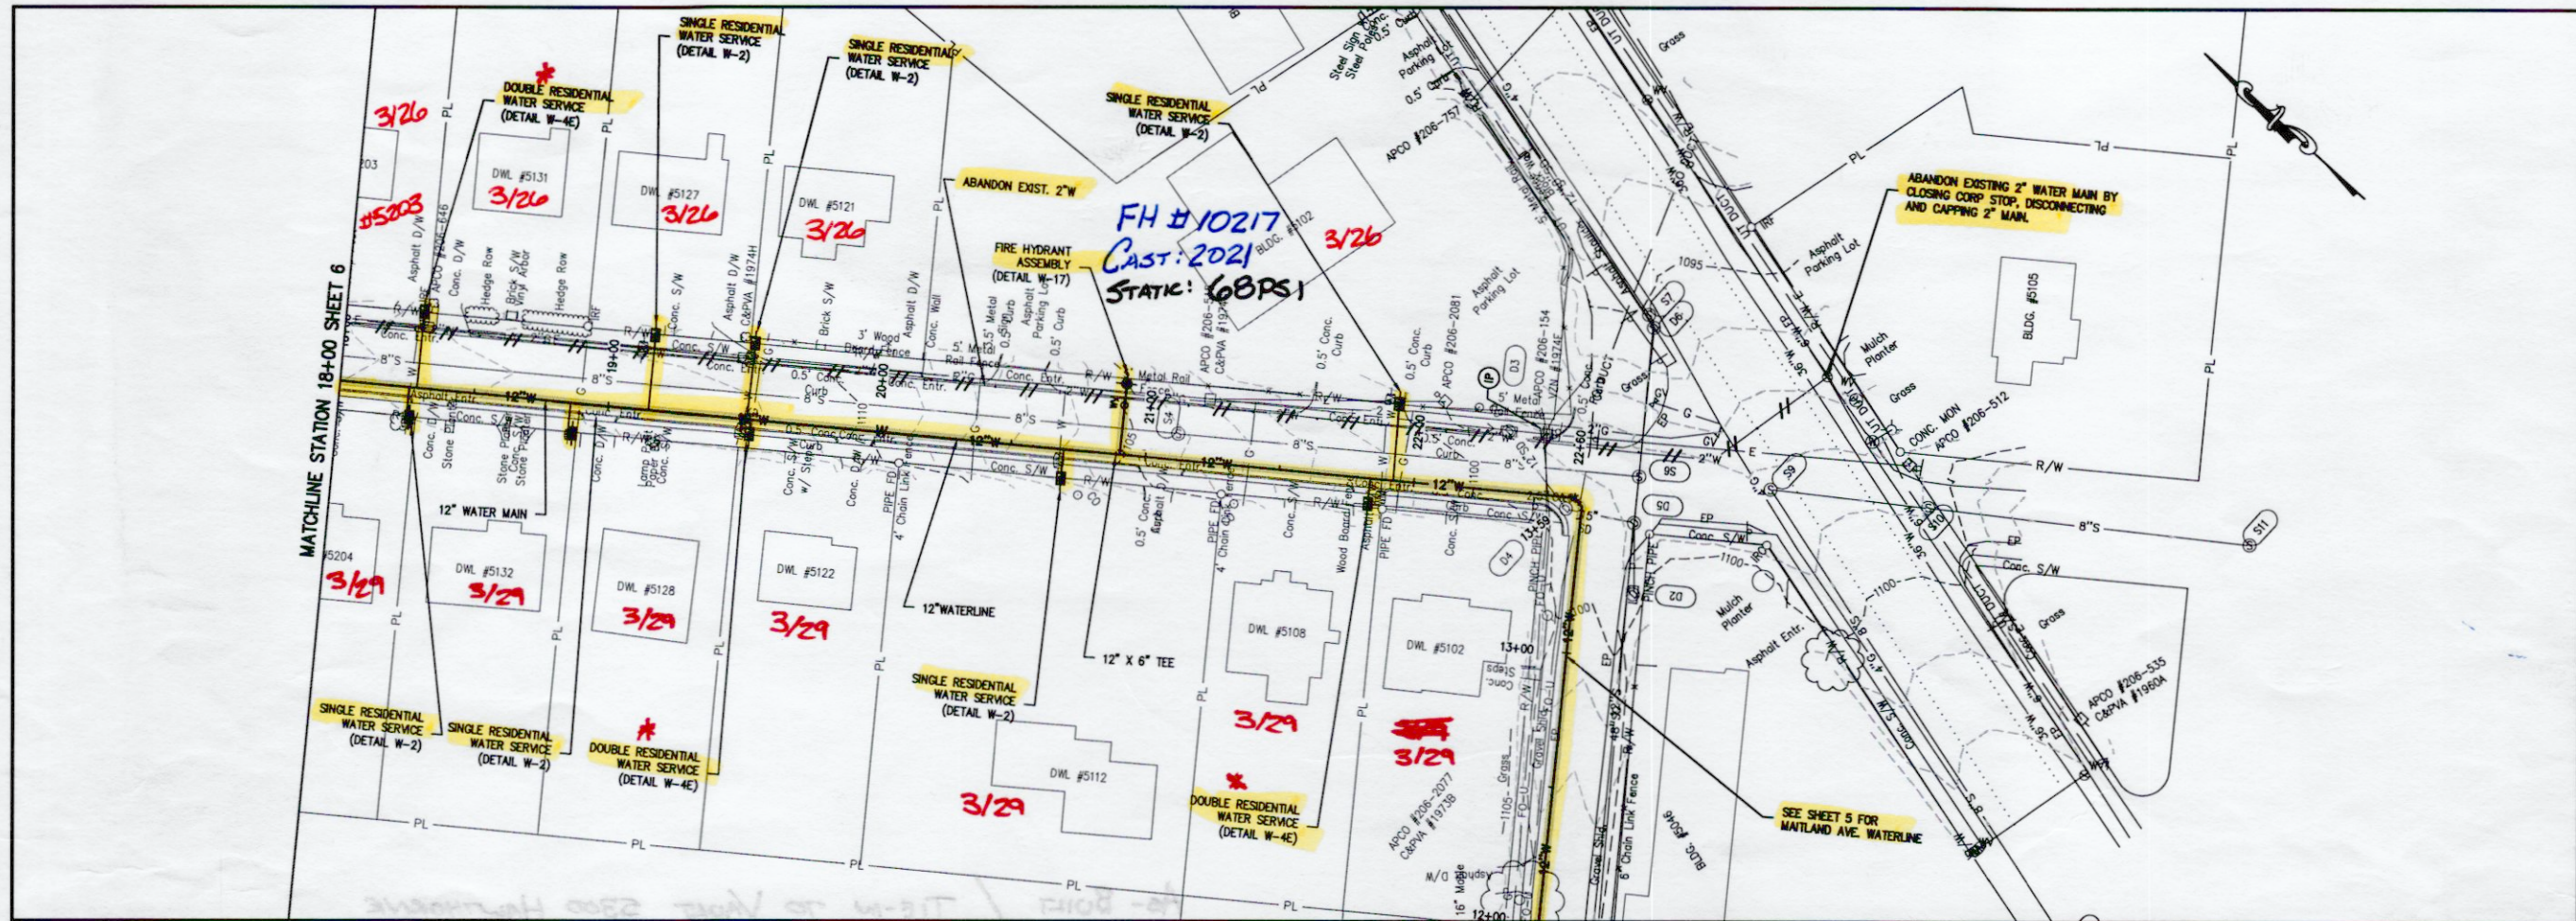




8 INCH & 12 INCH WATERLINE - WOODBURY ST. PROFILE

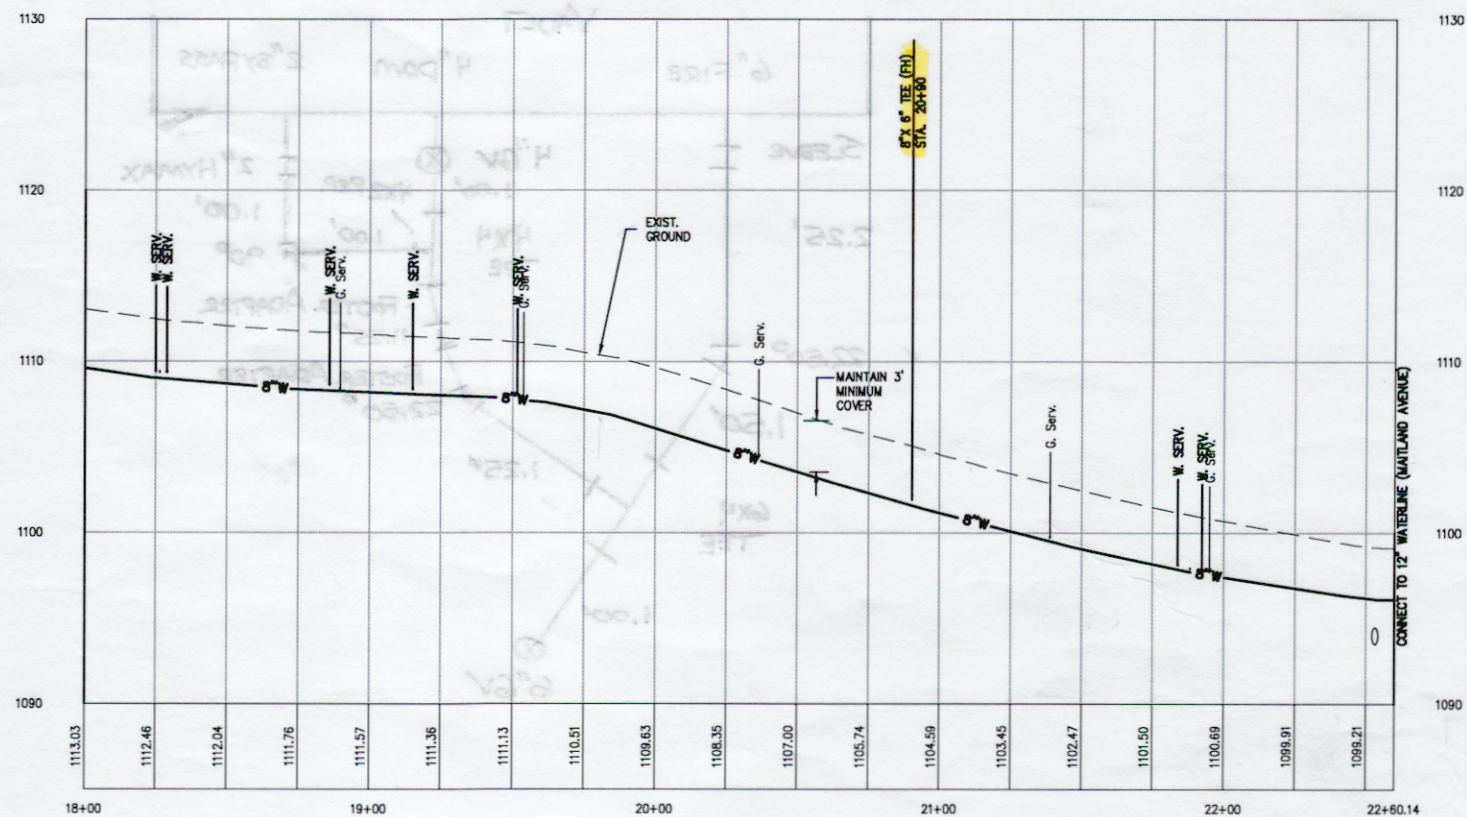

Date	
Revisions	

Issue Date:	NOV. 25, 2020
Drawn By:	DBL/ARB
Designed By:	DBL
Checked By:	BCC
Date:	11/25/2020

Mattern & Craig
ENGINEERS/SURVEYORS
701 FIRST STREET, S.W.
ROANOKE, VA 24016
PHONE (540) 345-7881
FAX (540) 345-7881

HAWTHORNE ROAD AREA WATERLINE REPLACEMENT PROJECT
PLAN AND PROFILE -
WOODBURY STREET
ROANOKE, VIRGINIA

Vertical Scale:	1" = 5'
Horizontal Scale:	1" = 30'
Commission Number:	3942
Sheet No.:	7