



Revisions	Date


Issue Date:	NOV. 25, 2020
Drawn By:	ARB
Designed By:	DBL
Checked By:	BCC
Date:	11/25/2020

Mattern & Craig
ENGINEERS/SURVEYORS
701 FIRST STREET, S.W.
ROANOKE, VIRGINIA 24016
(540) 345-9342
FAX (540) 345-7891

HAWTHORNE ROAD AREA WATERLINE REPLACEMENT PROJECT
PLAN AND PROFILE - NELMS LANE
ROANOKE, VIRGINIA

Vertical Scale:	1" = 5'
Horizontal Scale:	1" = 30'
Commission Number:	3942
Sheet No.:	9

County

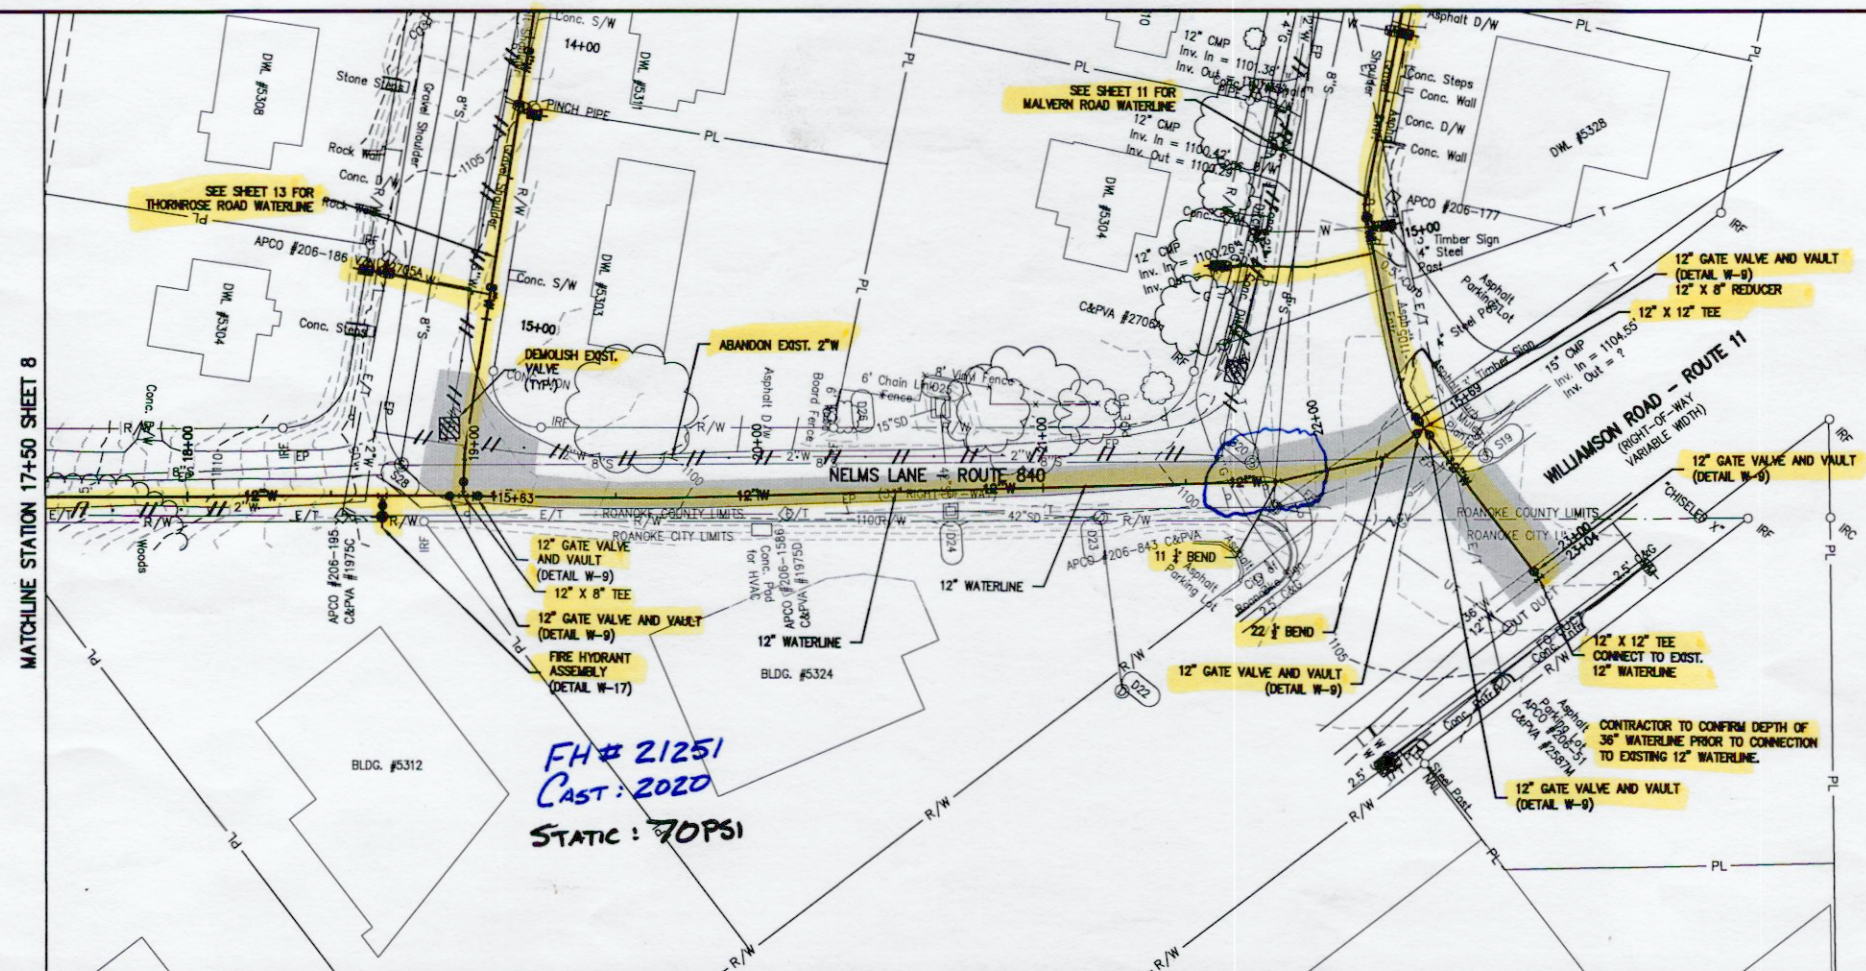

12 INCH WATERLINE - NELMS LANE PROFILE

