




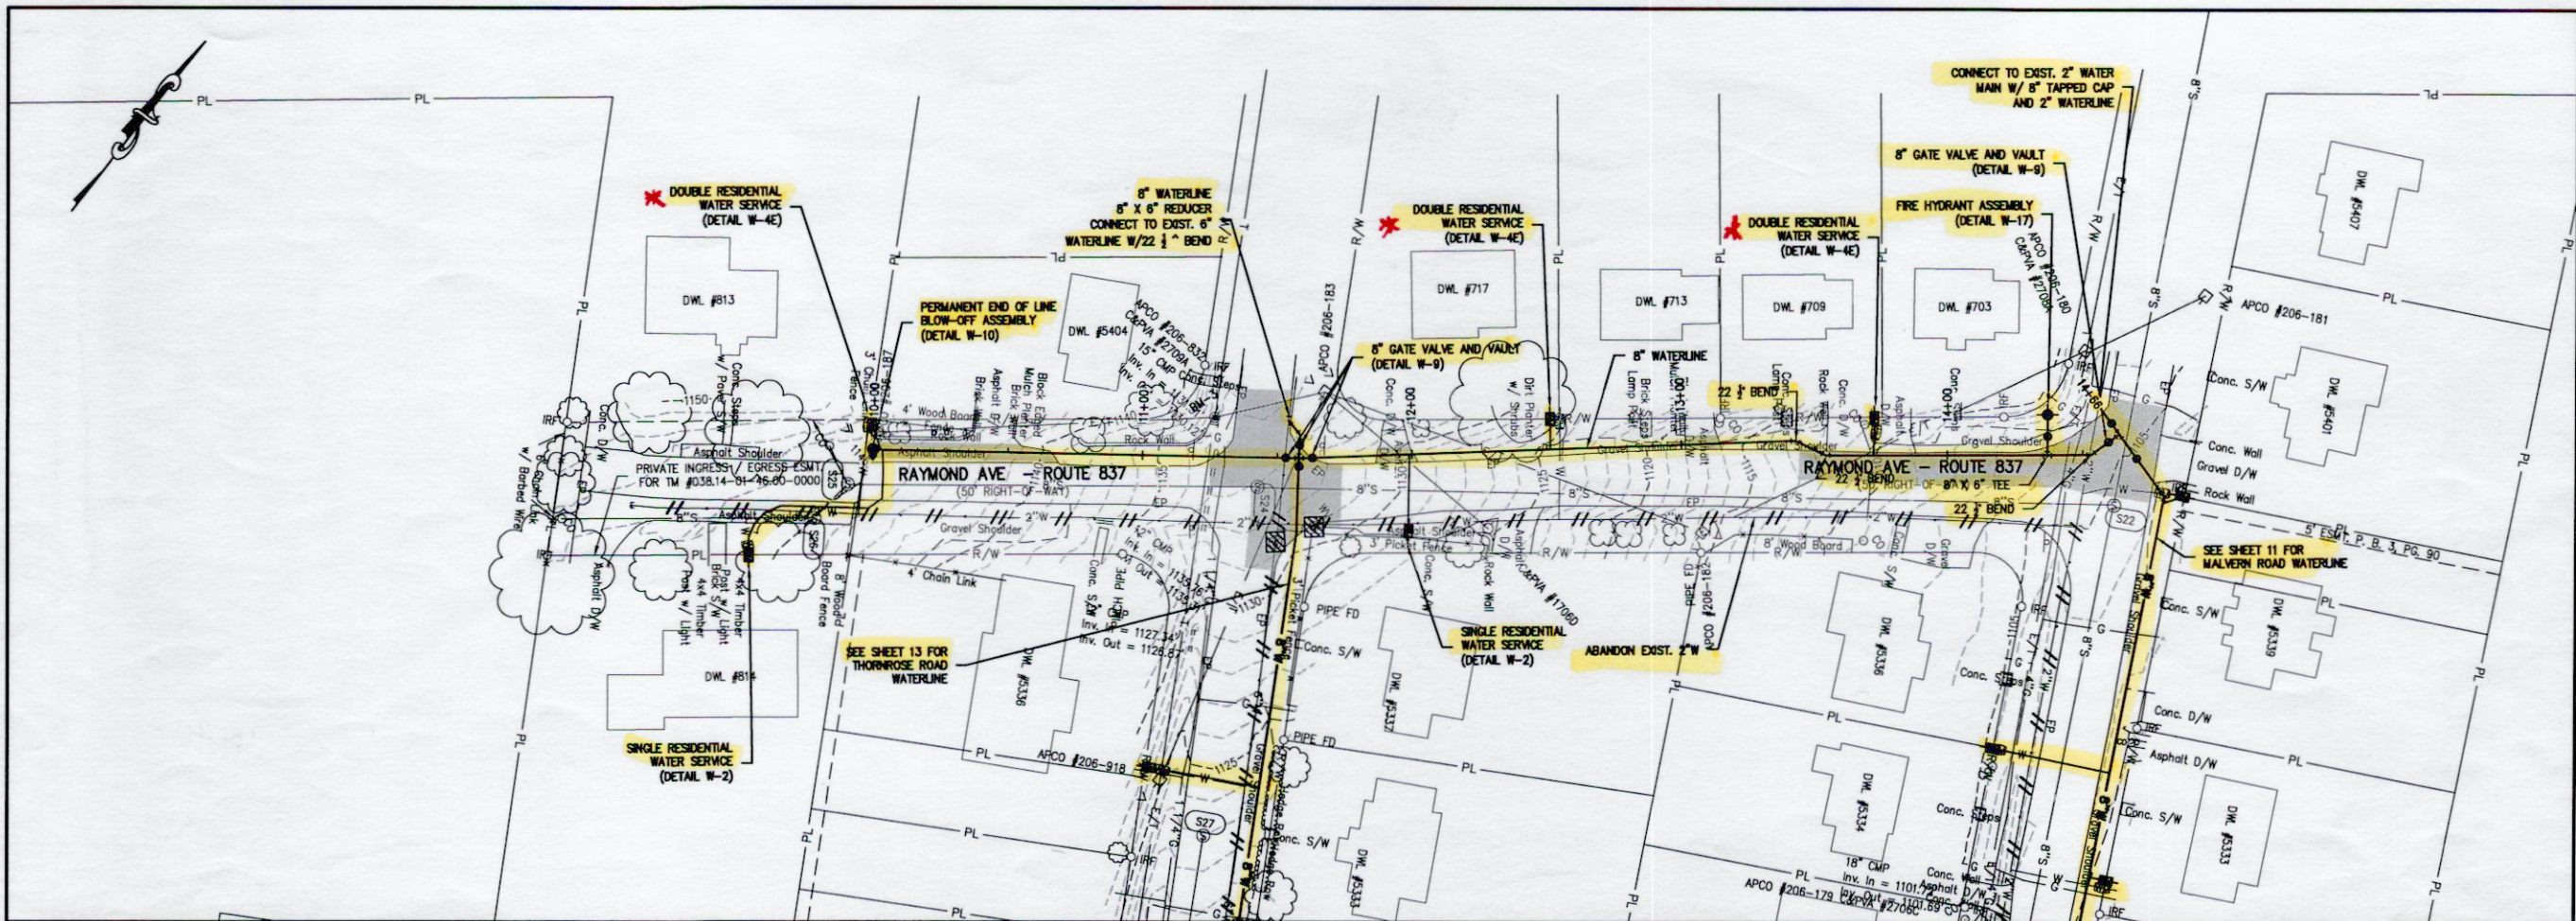

8 INCH WATERLINE - RAYMOND AVE. PROFILE

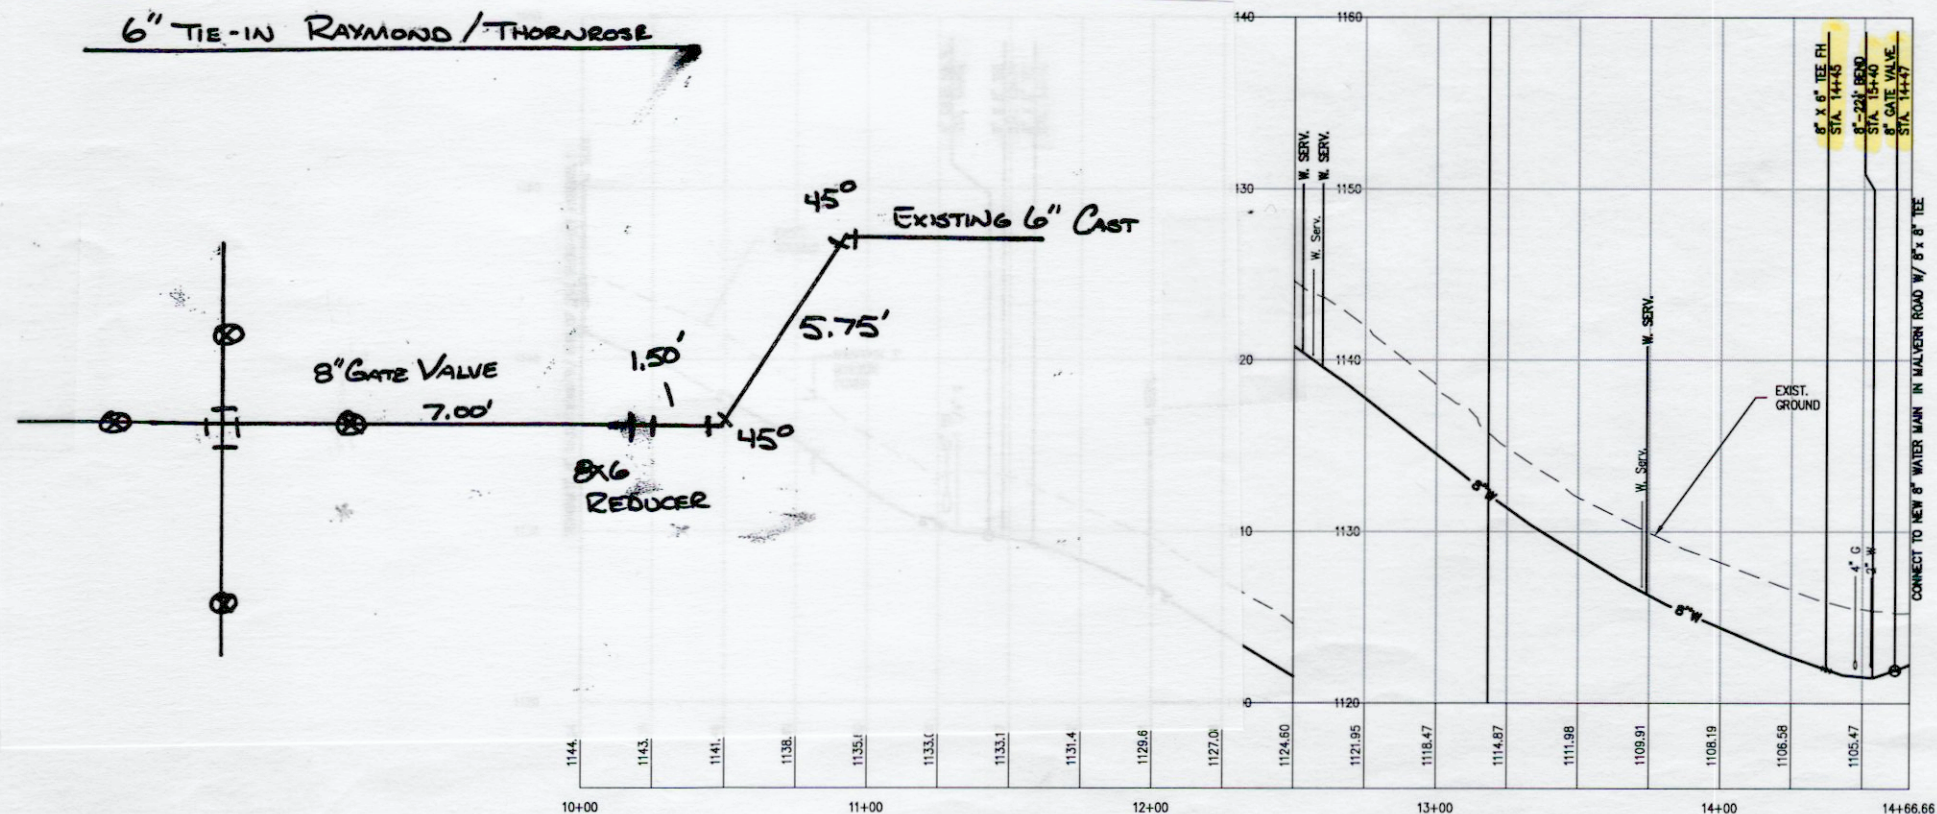

FH # 21252
CAST: 2021
STATIC: 68.0

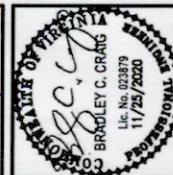

Revisions	Date

Issue Date: NOV. 25, 2020
Drawn By: DBL
Designed By: DBL
Checked By: BCC
Date: 11/25/2020

Mattern & Craig
ENGINEERS/SURVEYORS
701 FIRST STREET, S.W.
ROANOKE, VIRGINIA 24016
(540) 345-9342
FAX (540) 345-7691

HAWTHORNE ROAD AREA WATERLINE REPLACEMENT PROJECT
PLAN AND PROFILE -
RAYMOND AVENUE
ROANOKE, VIRGINIA

Vertical Scale:
1" = 5'
Horizontal Scale:
1" = 30'
Commission Number:
3942
Sheet No.:

12
County

