



SEE ARCHITECTURAL DRAWINGS FOR
BUILDING DIMENSIONS.

NORTH
PLANE
VIRGINIA STATE
COORDINATE SYSTEM
(SOUTH ZONE, NAD83)

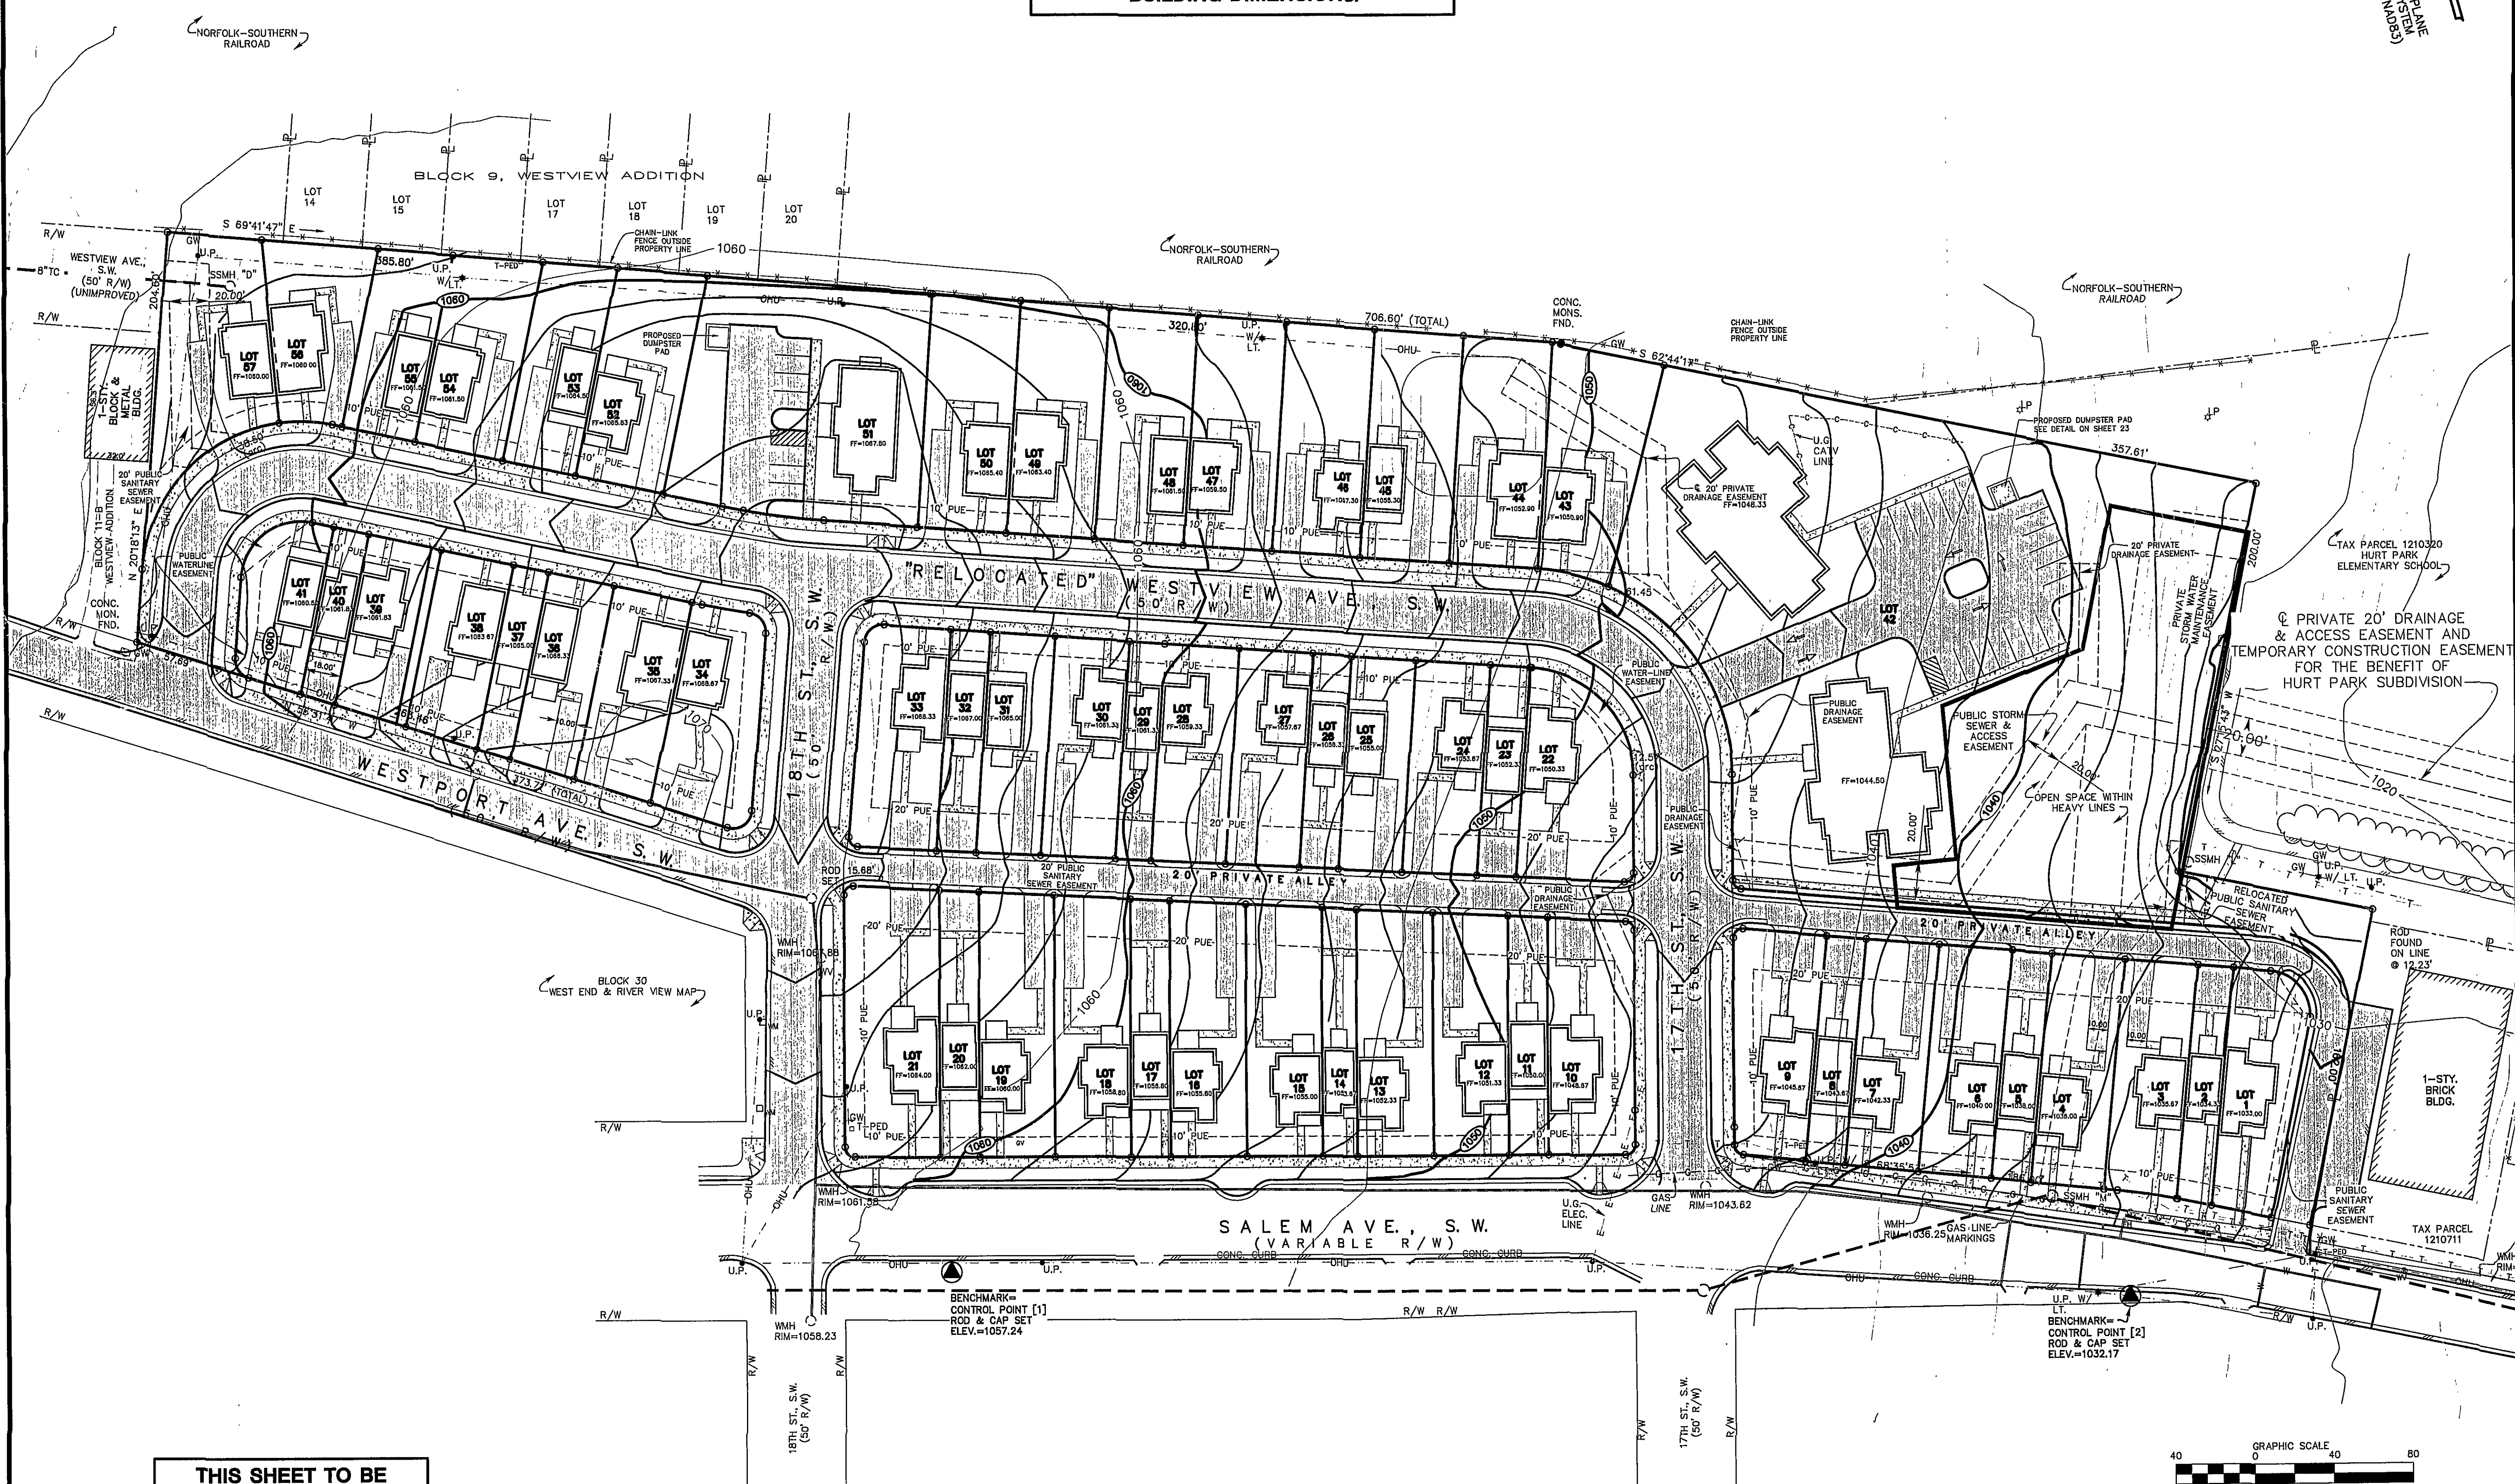

THIS SHEET TO BE
USED FOR OVERALL
SITE REVIEW. SEE OTHER
SHEETS FOR MORE
SPECIFIC DETAIL

STREET LANDSCAPING AND LIGHTING PLAN
SEE SHEET 28

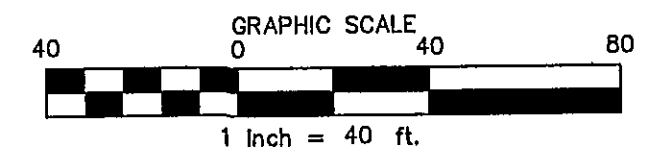

GAY AND NEEL, INC.
CIVIL ENGINEERING
LAND PLANNING
SURVEYING
328 Mountain Avenue S.W.
Roanoke, Virginia 24016
Phone: (540) 345-1100 Fax: (540) 345-5560
Email: info@gayandneel.com

Proposed Site Conditions

R.R.H.A.
Hurt Park Site Plan
City Of Roanoke, Virginia

COMMONWEALTH OF VIRGINIA
MICHAEL G. GAY
Lic. No. 17560
1/7/07
PROFESSIONAL ENGINEER

REVISED:
07/13/07
09/14/07
10/22/07

DESIGNED/CALC. MGG, AMC
CHECKED: AMC, PLJ
DRAWN: AMC, PLJ
SCALE: 1"=40'
DATE: 04/18/07

JOB NO. 1588.0
SHEET 4 OF 32

U:\Drawings\1588.dwg(C:\3D-MC\1588-SP-03-110507.dwg, Proposed Site Conditions, 11/7/2007 12:22:06 PM, jgibson, RCE HP DesignJet 500 p3, Arch D, 11)