


U:\Drawings\158\Burg\CV-3D-MC\158-SF-94-080808.dwg Utility Plan, 8/2/2008 3:51:43 PM, mcmilless, RVE HP Design\158 500.pcd, 11



GAY AND NEEL, INC.

CIVIL ENGINEERING
LAND PLANNING
SURVEYING

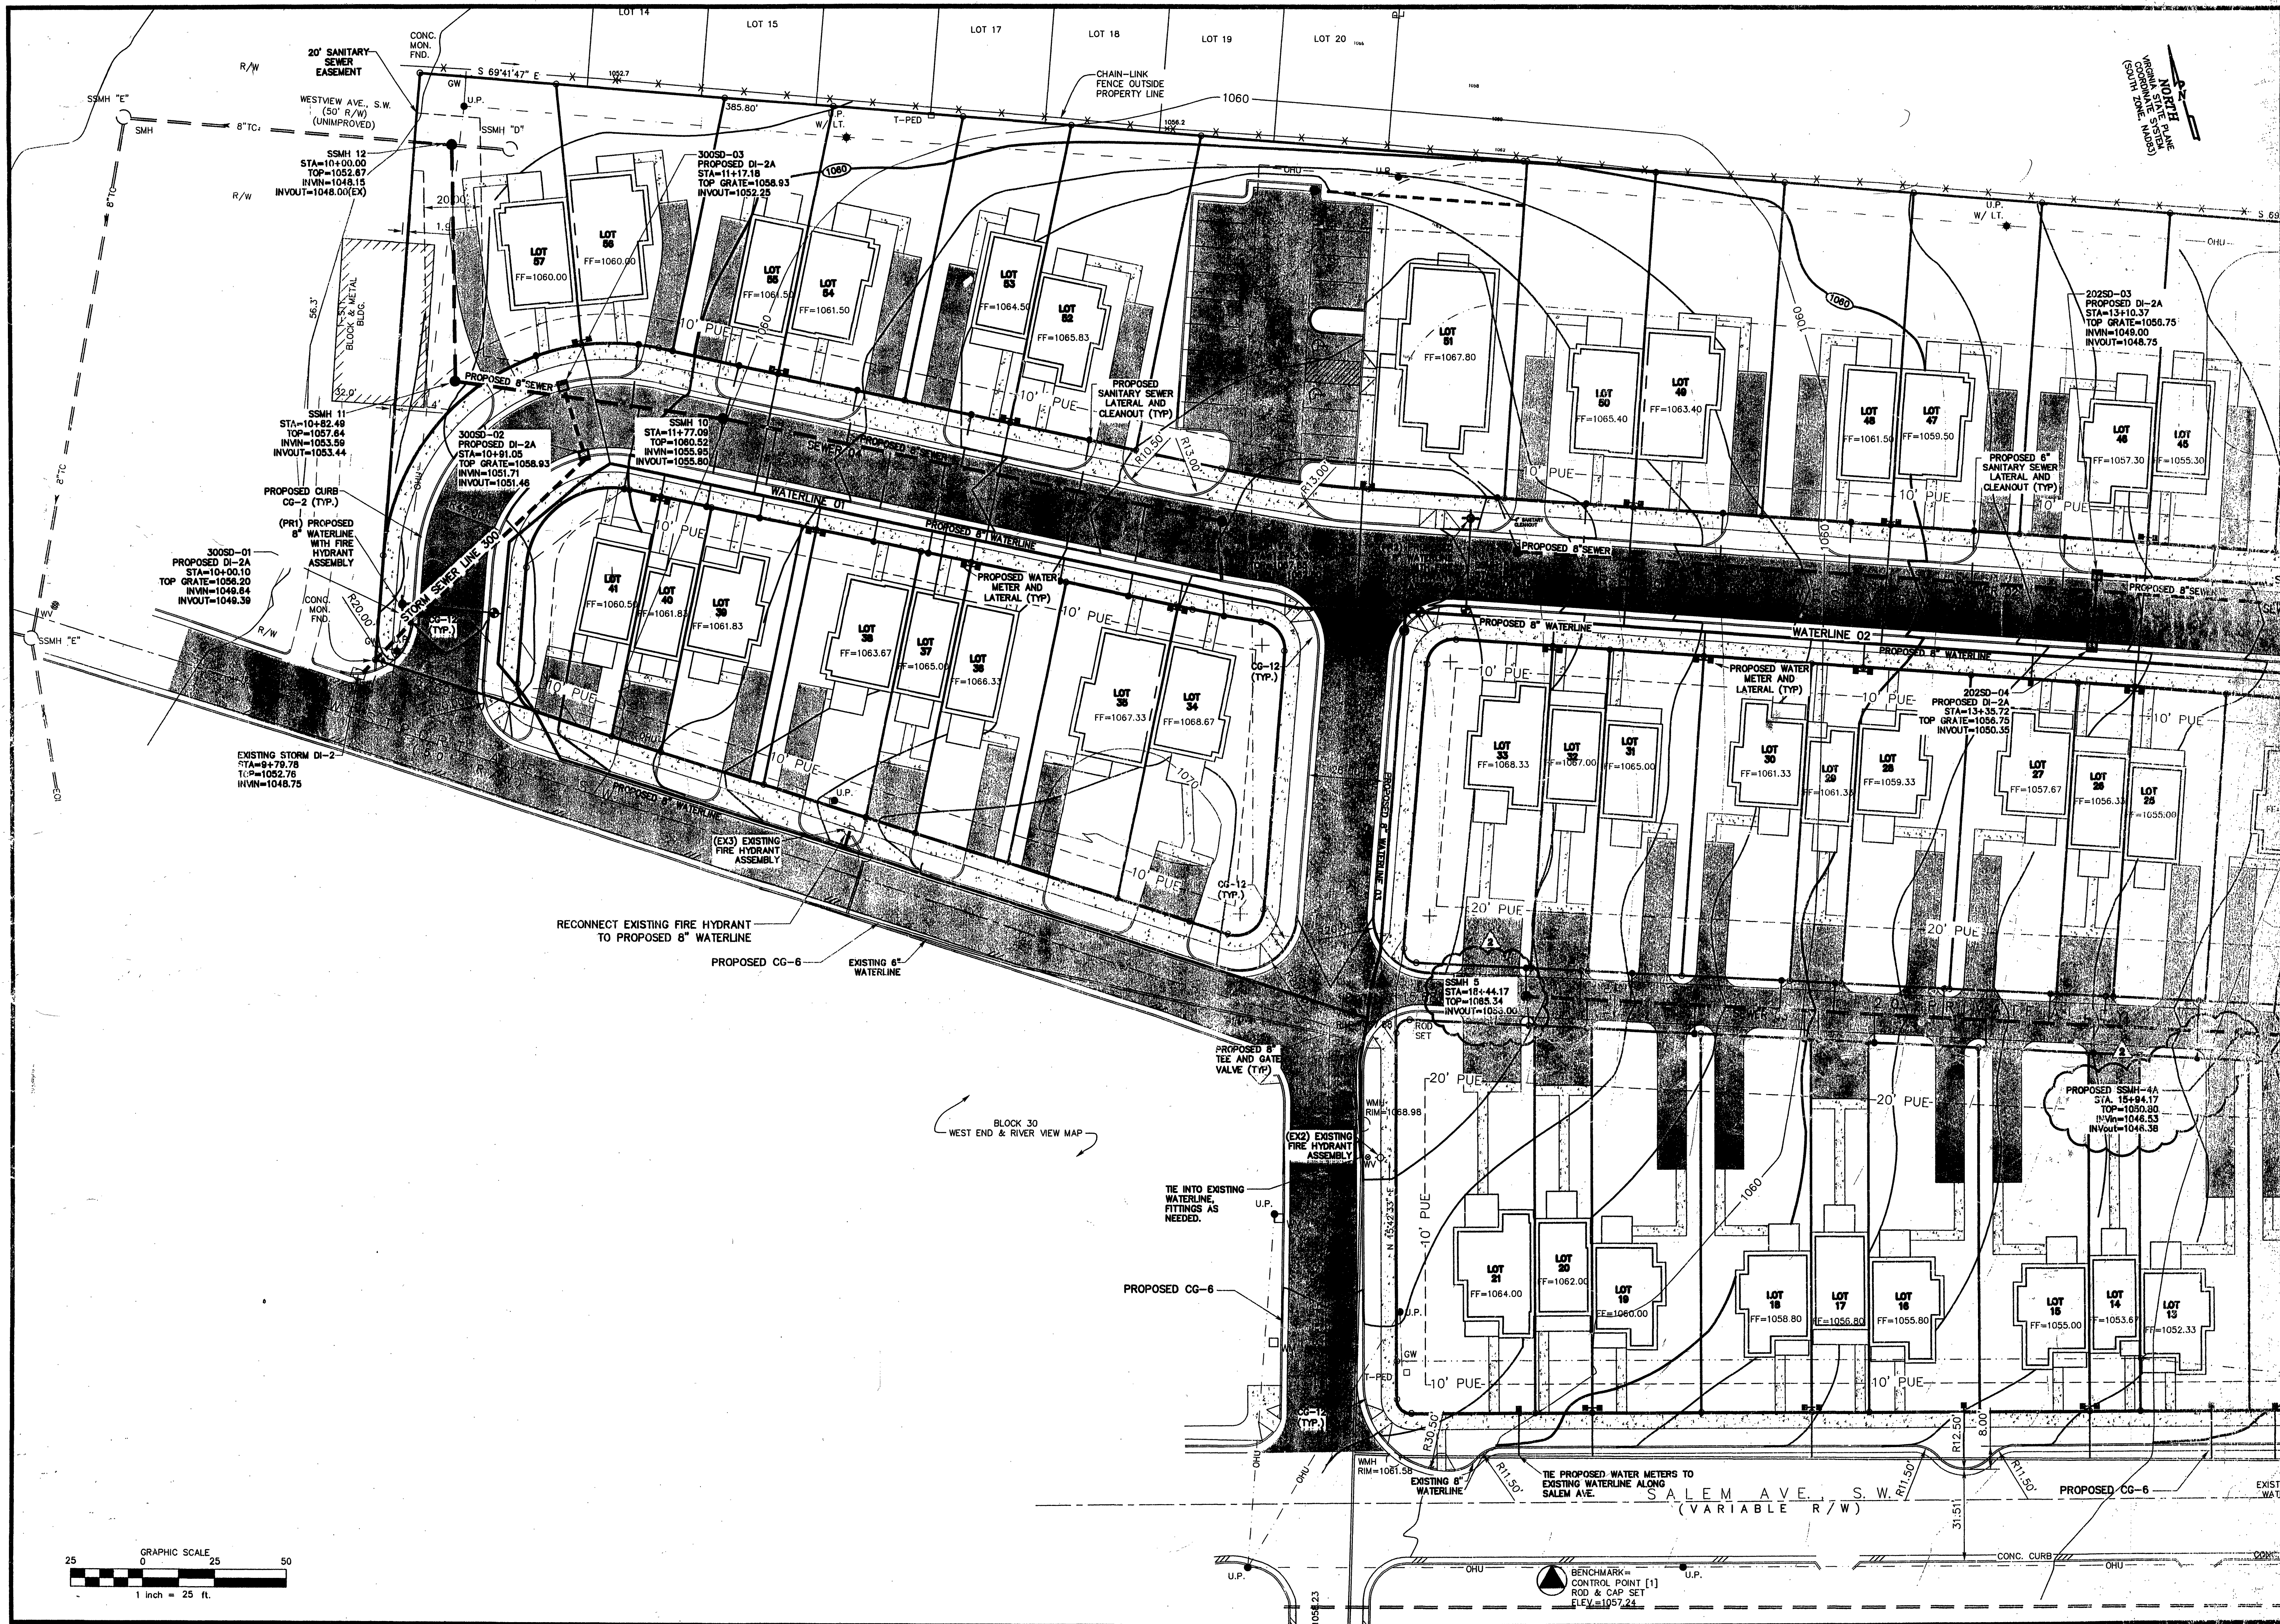


328 Mountain Avenue S.W.
Roanoke, Virginia 24016
Phone: (540) 345-1110 Fax: (540) 345-5560
Email: info@gayandneel.com

Utility Plan

Sewer

As Builts

R.R.H.A.
Hurt Park Site Plan
City of Roanoke, Virginia

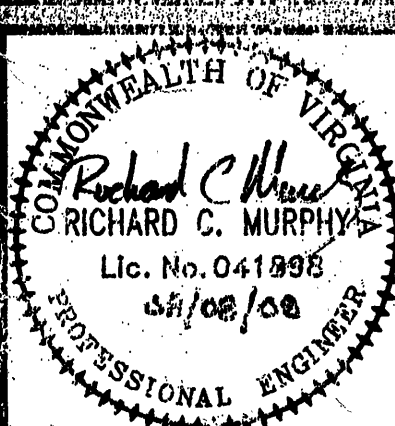

REVISED:
07/13/07
09/14/07
10/22/07
08/08/08

PRINTED ON
AUG 11 2008

DESIGNED/CALC. MCG, AMC
CHECKED: RCM
DRAWN: AMC, PLJ
SCALE: 1"=25'
DATE: 04/18/07

JOB NO. 1583.0

SHEET 11 OF 32