


U:\Drawings\1588\DWG\CIV-3D-ANCV1588-SP-R3-110507.dwg, Utility Plan (2), 11/7/2007 12:14:44 PM, plotjohnson, RKE HP Designer, 500.pc3, Arch D, 1:1

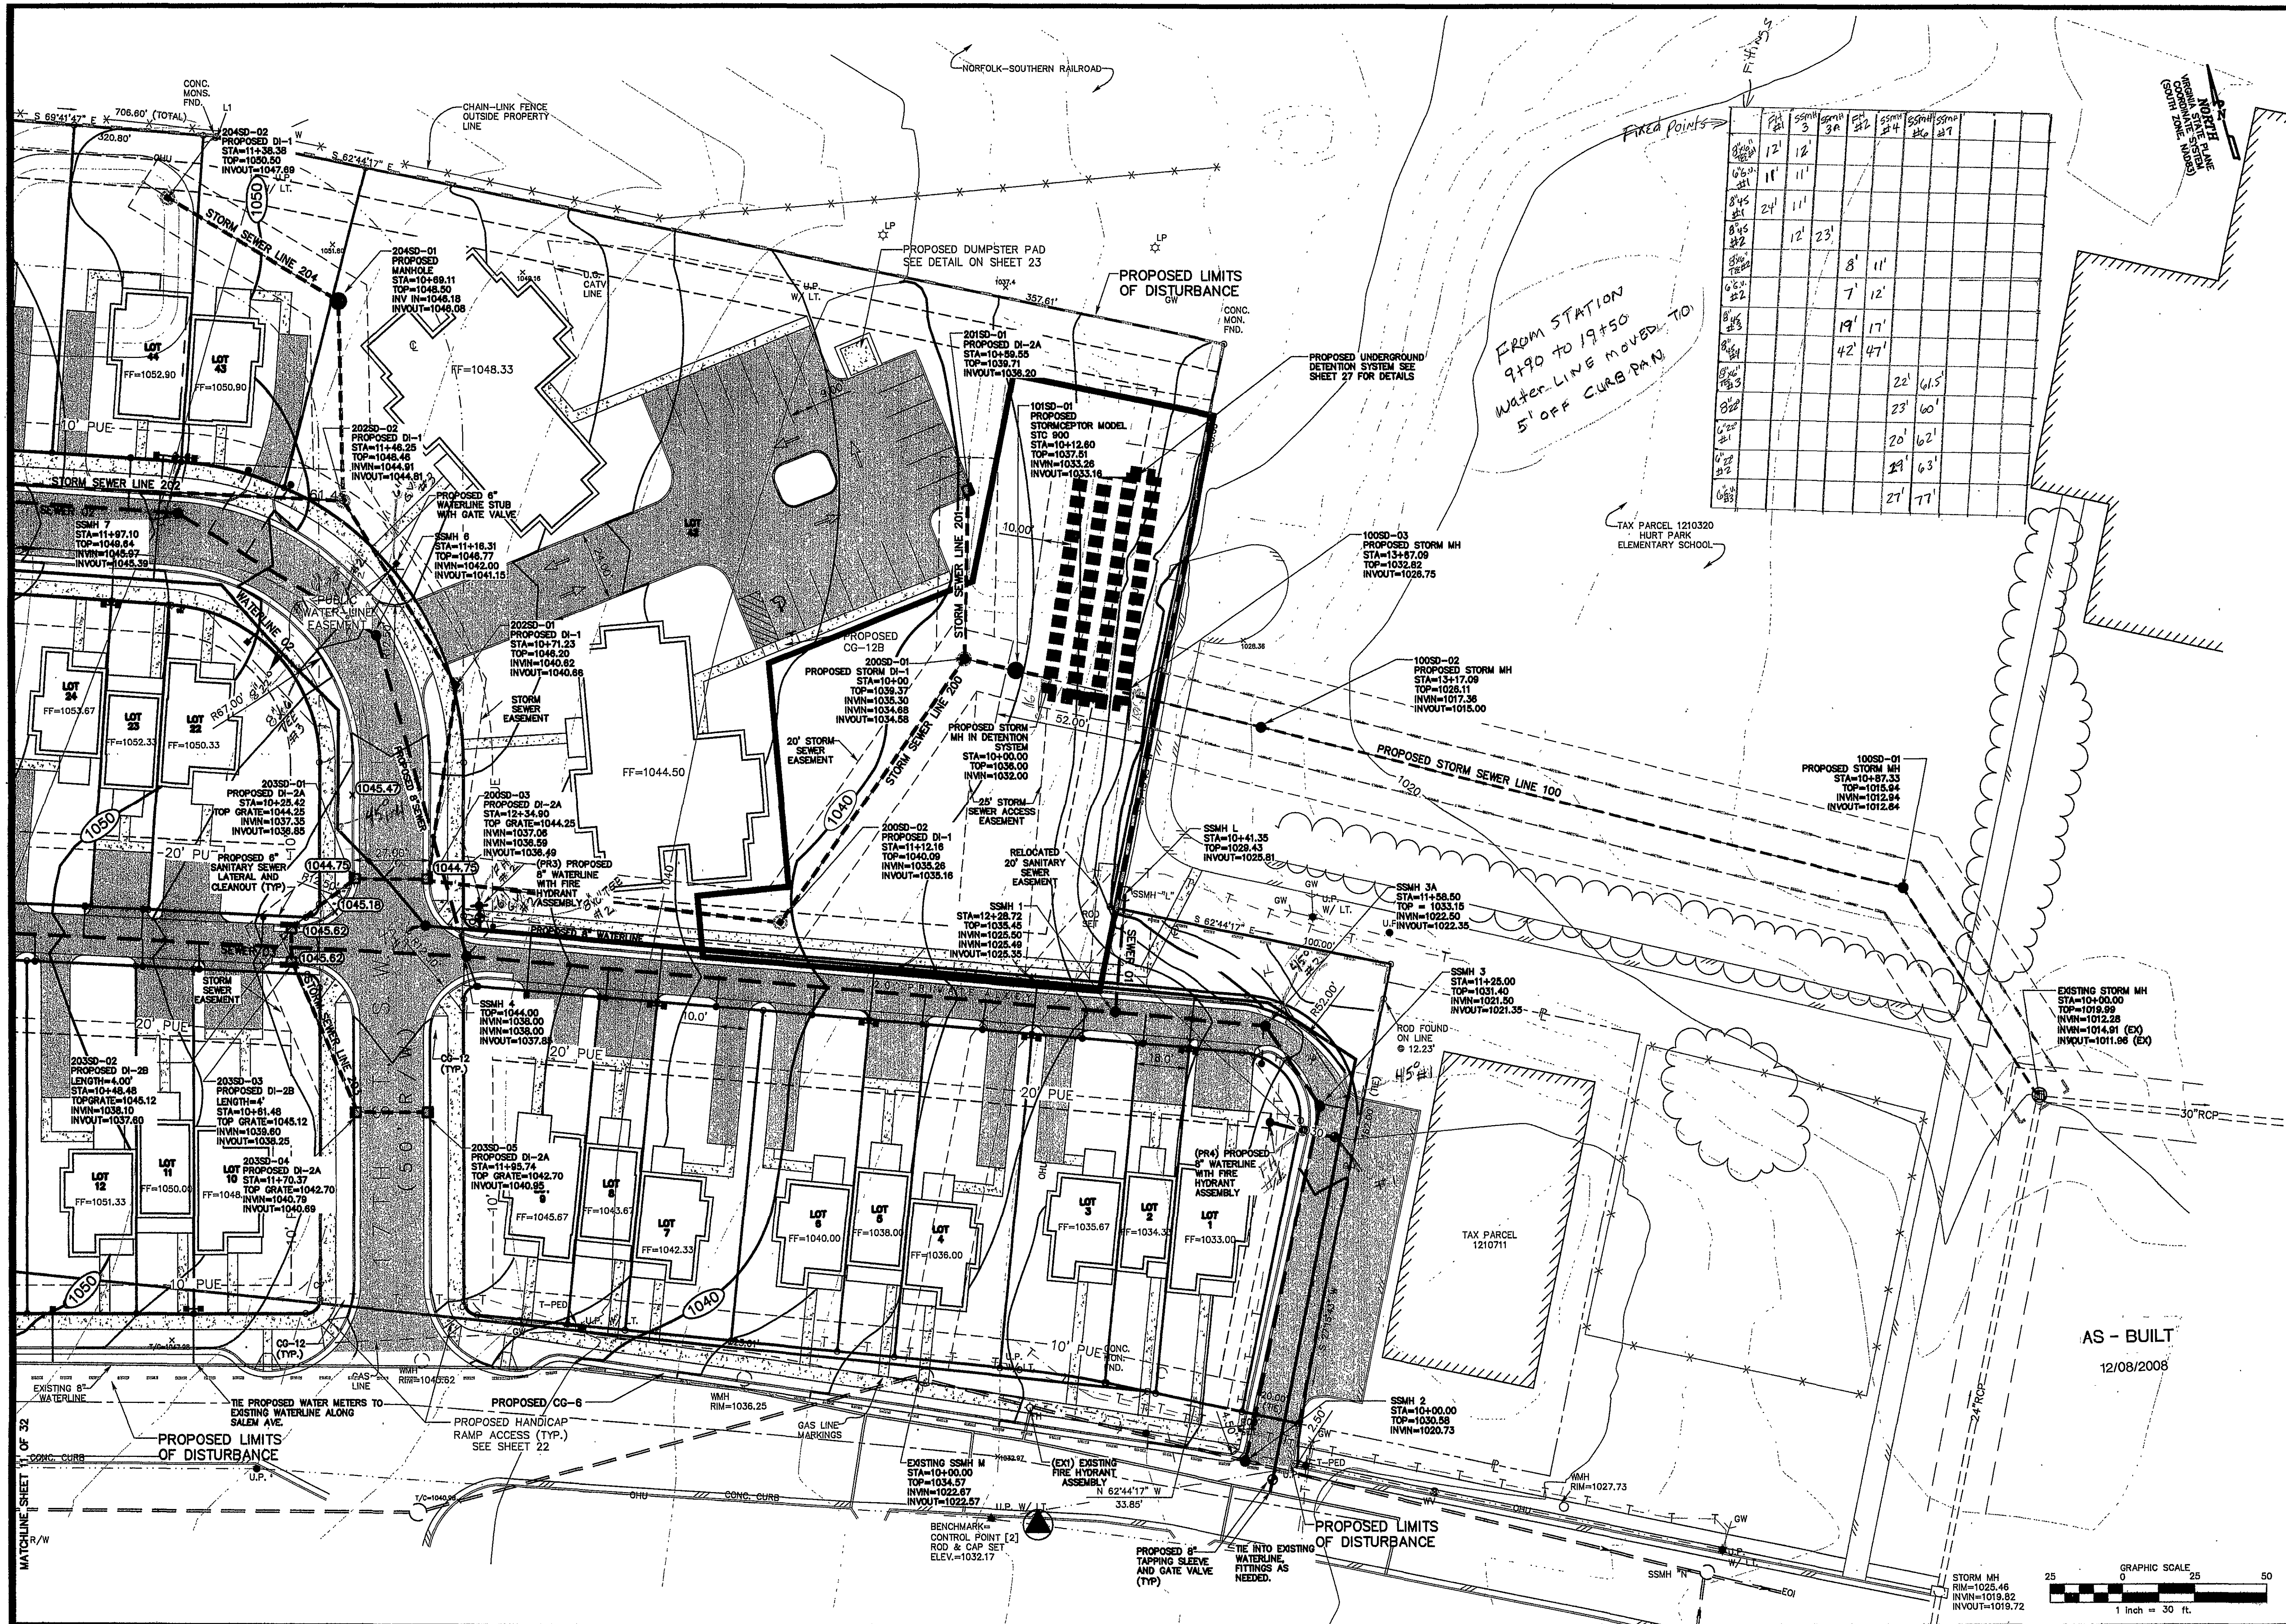

GAY AND NEEL, INC.
 CIVIL ENGINEERING
 LAND PLANNING
 SURVEYING
 328 Mountain Avenue S.W.
 Roanoke, Virginia 24016
 Phone: (540) 345-1170 Fax: (540) 345-5560
 Email: info@gayandneel.com

Utility Plan

R.R.H.A
 Hurt Park Site Plan
 City of Roanoke, Virginia

STATE OF VIRGINIA
 MICHAEL G. GAY
 Lic. No. 17560
 4/7/07
 PROFESSIONAL ENGINEER

REVISED:
 07/13/07
 09/14/07
 10/22/07

DESIGNED/CALC. MGG/AMC
 CHECKED: AMC/PLJ
 DRAWN: AMC/PLJ
 SCALE: 1"=25'
 DATE: 04/18/07

JOB NO. 1588.0
 SHEET 12 OF 32

AS - BUILT
 12/08/2008

