



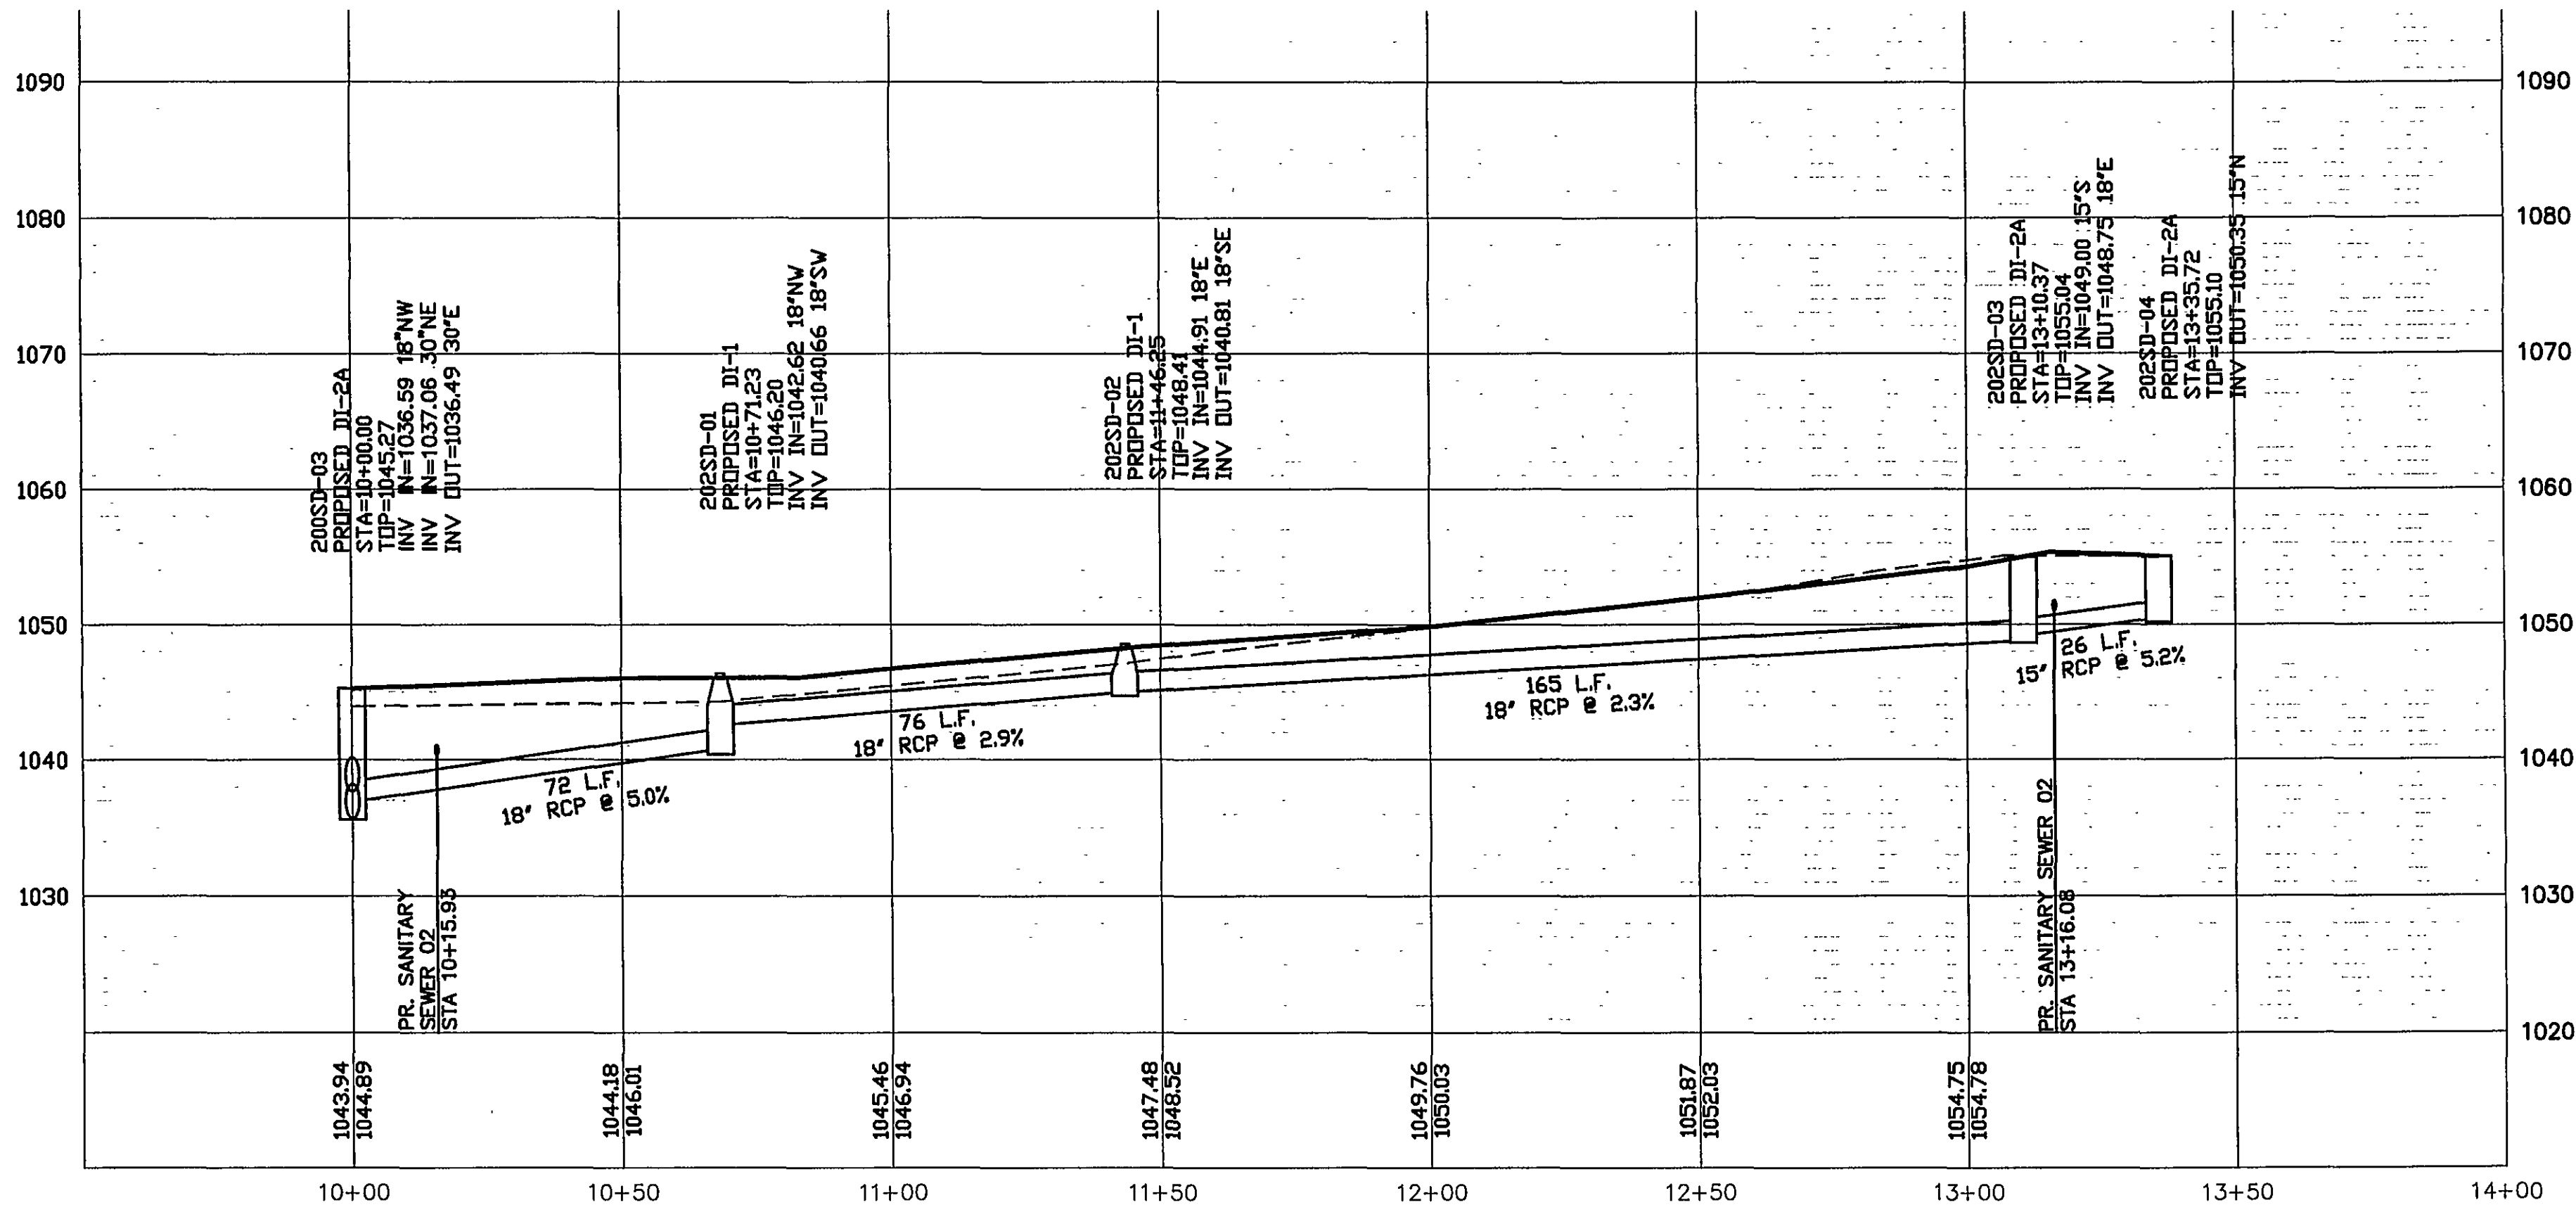

STORM SEWER LINE 202
SCALE = 1"=25'H, 1"=10'V

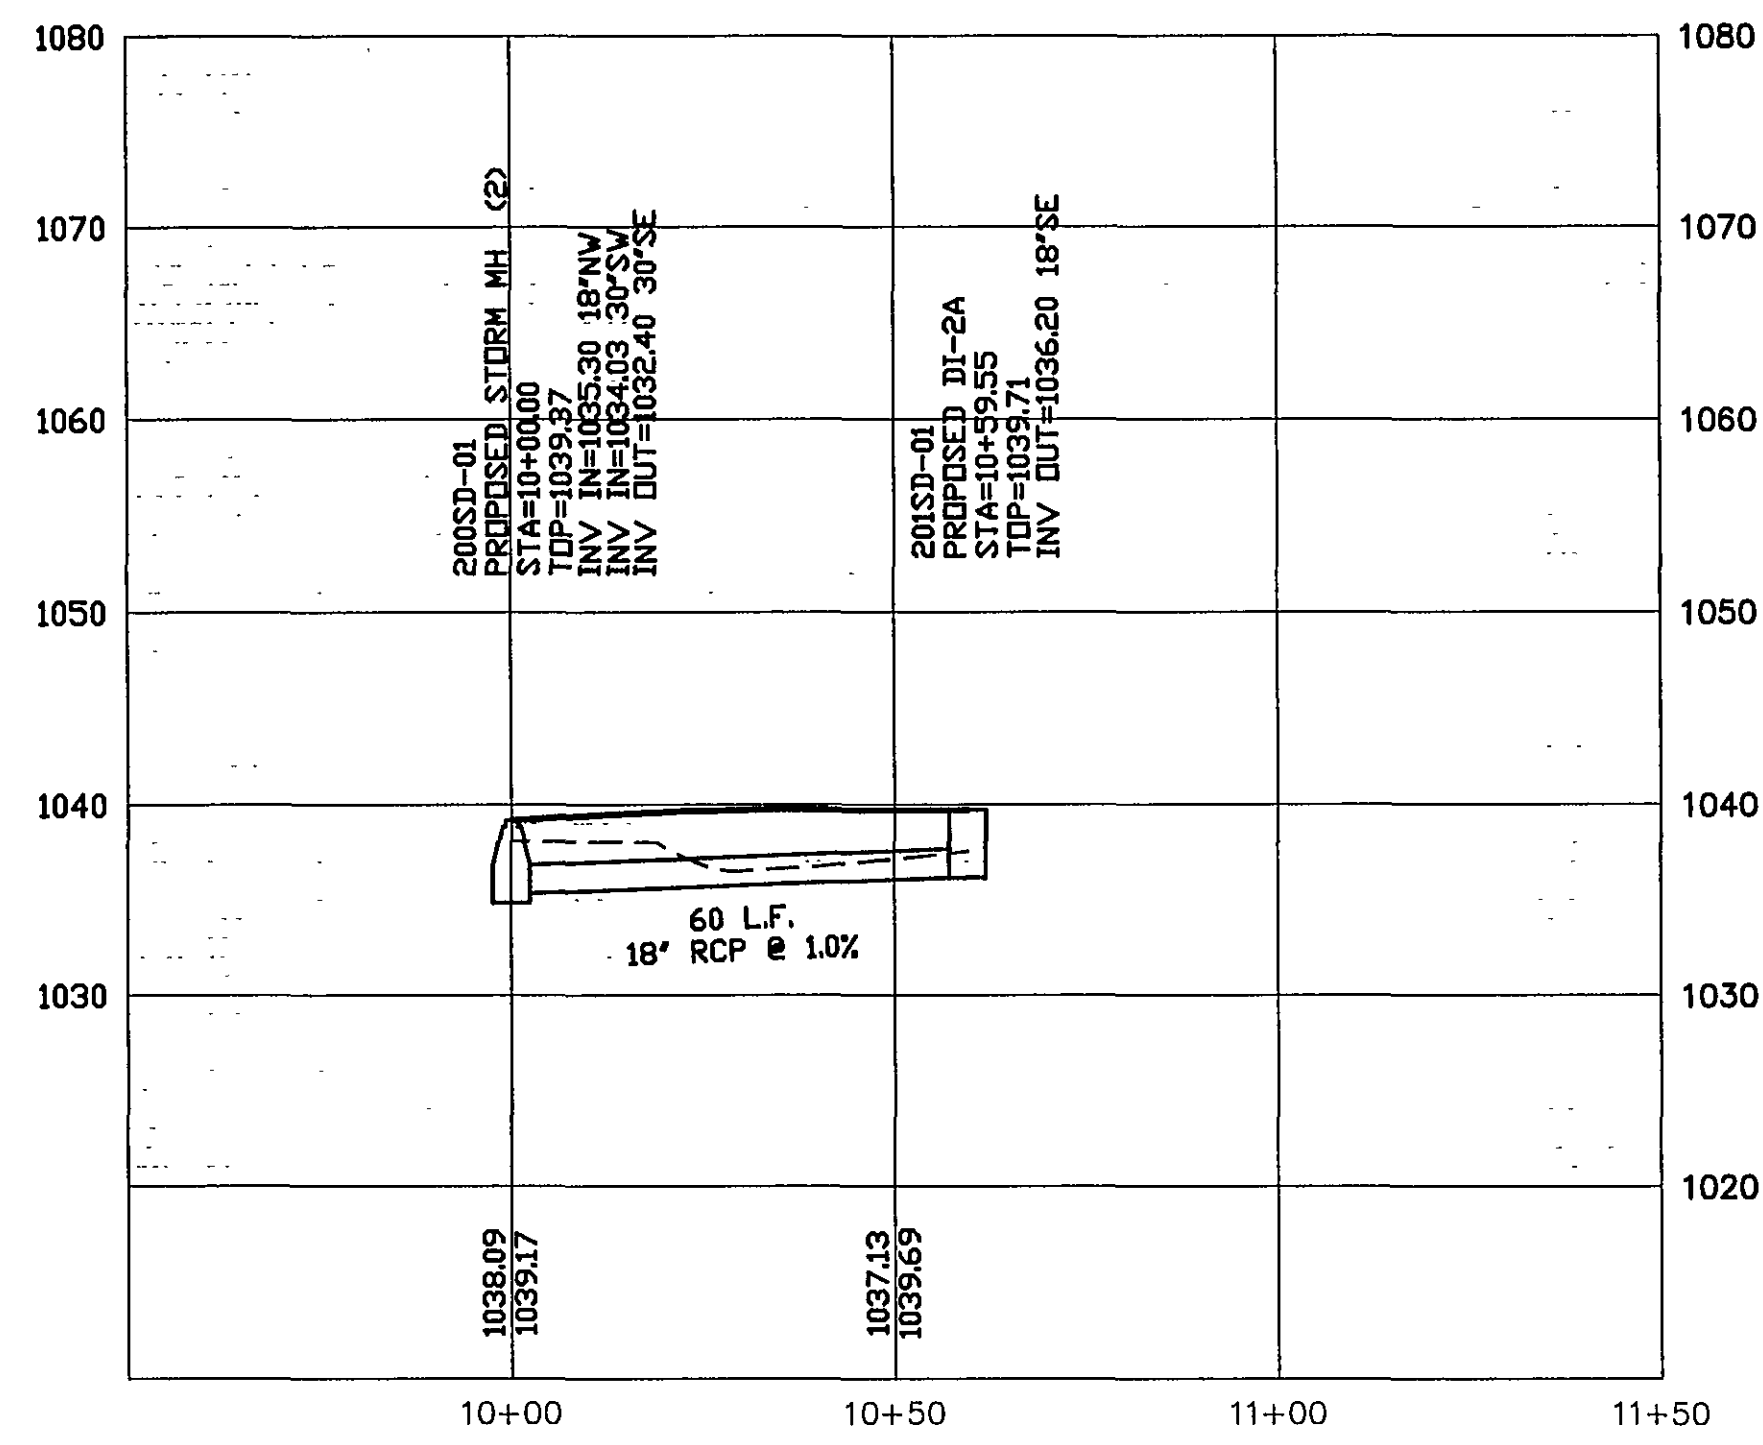


STORM SEWER LINE 201
SCALE = 1"=25'H, 1"=10'V



GAY AND NEEL, INC.
CIVIL ENGINEERING
LAND PLANNING
SURVEYING
328 Mountain Avenue S.W.
Roanoke, Virginia 24016
Phone: (540) 345-1110 Fax: (540) 345-5560
Email: info@gayandneel.com

Storm Sewer Profiles

R.R.H.A
Hurt Park Site Plan
City of Roanoke, Virginia

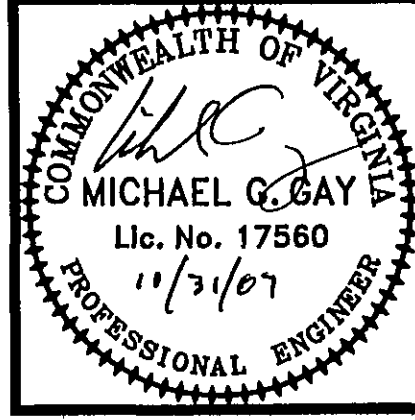

COMMONWEALTH OF VIRGINIA
MICHAEL G. GAY
Lic. No. 17560
11/3/07
PROFESSIONAL ENGINEER

REVISED:
07/13/07
09/14/07
10/22/07

DESIGNED/CALC.MGG,AMC
CHECKED: RCM
DRAWN: AMC,PLJ
SCALE: 1"=10'V, 1"=25'H
DATE: 04/18/07

JOB NO. 1588.0
SHEET 20 OF 32