



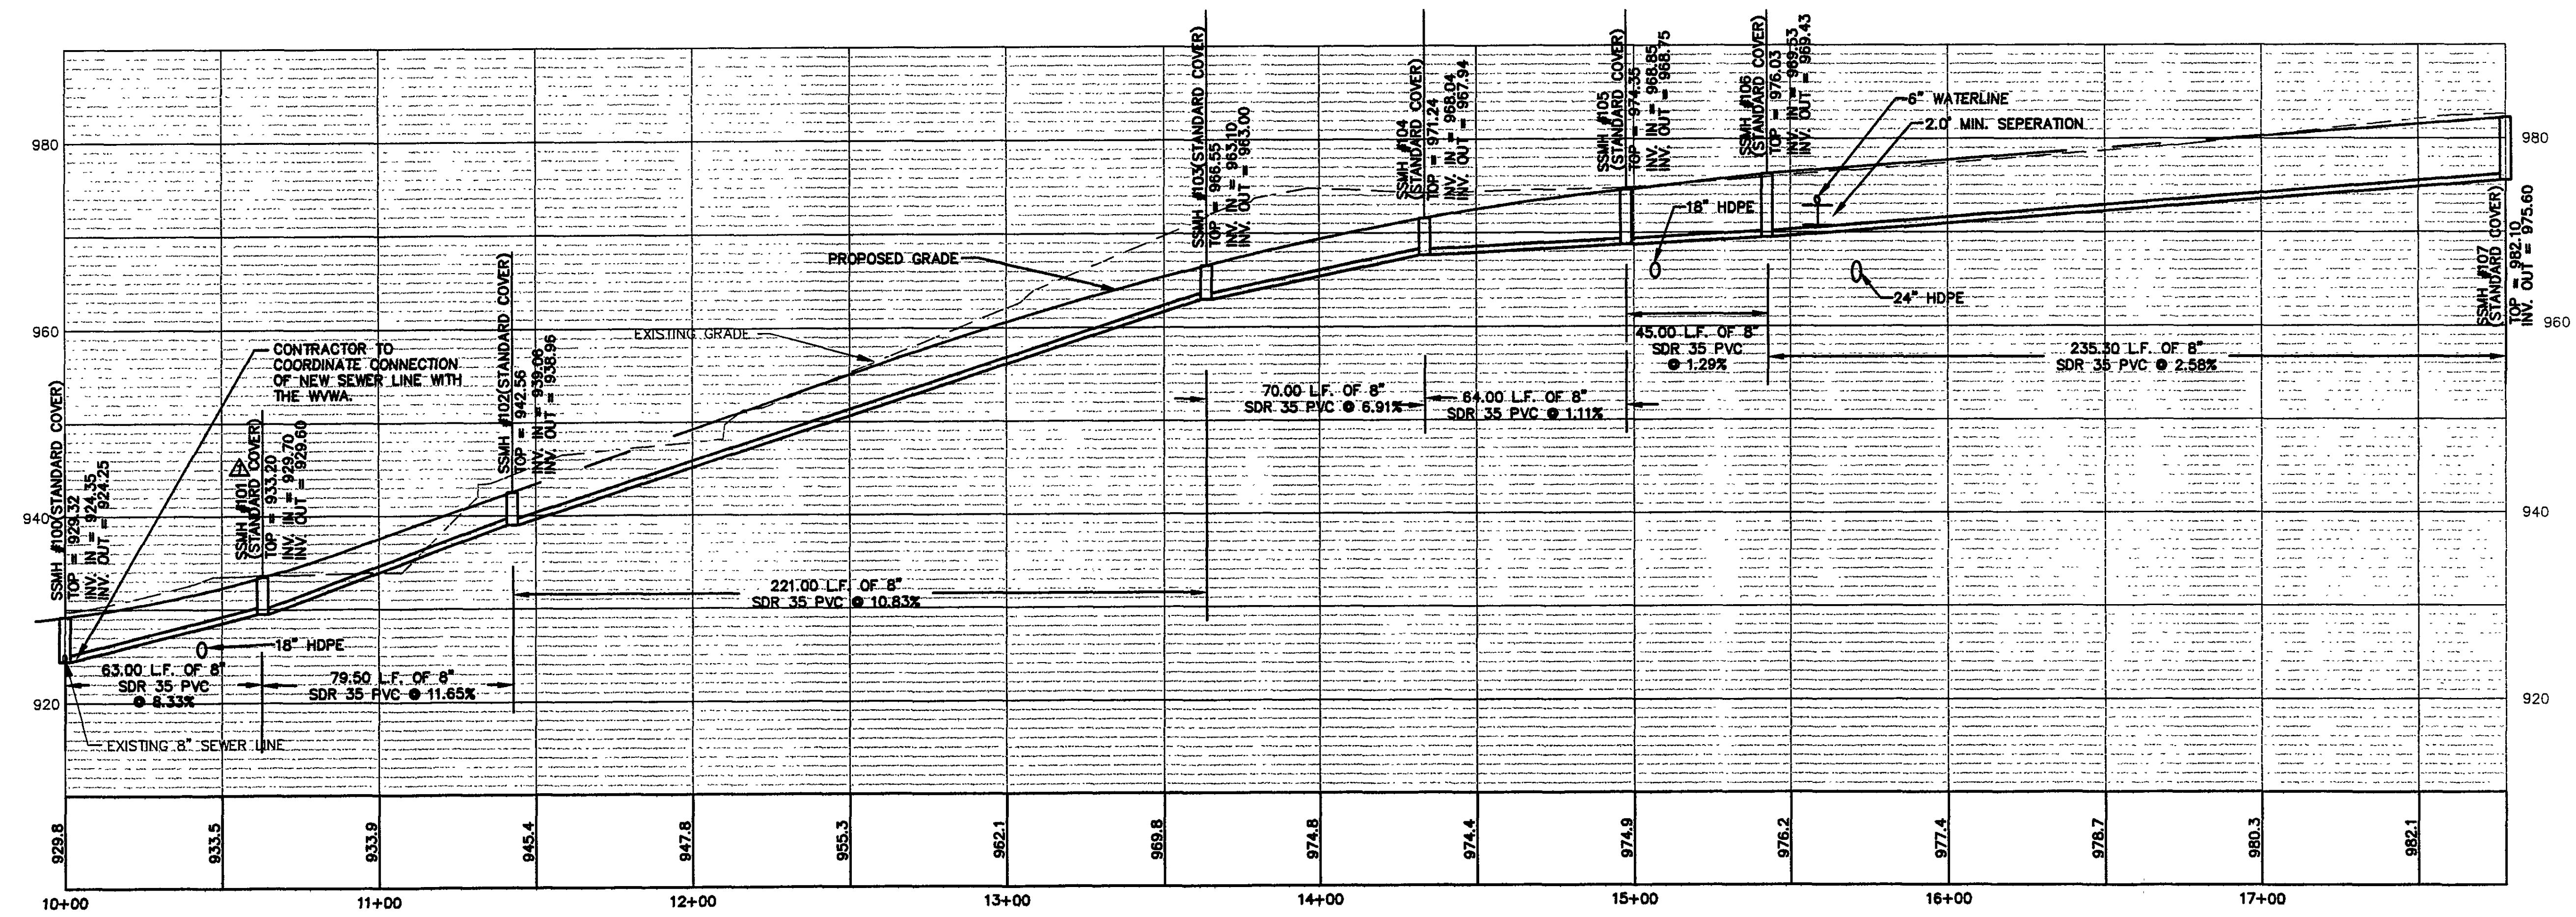

SANITARY SEWER PROFILE
 HORIZ. SCALE: 1" = 30'
 VERT. SCALE: 1" = 10'

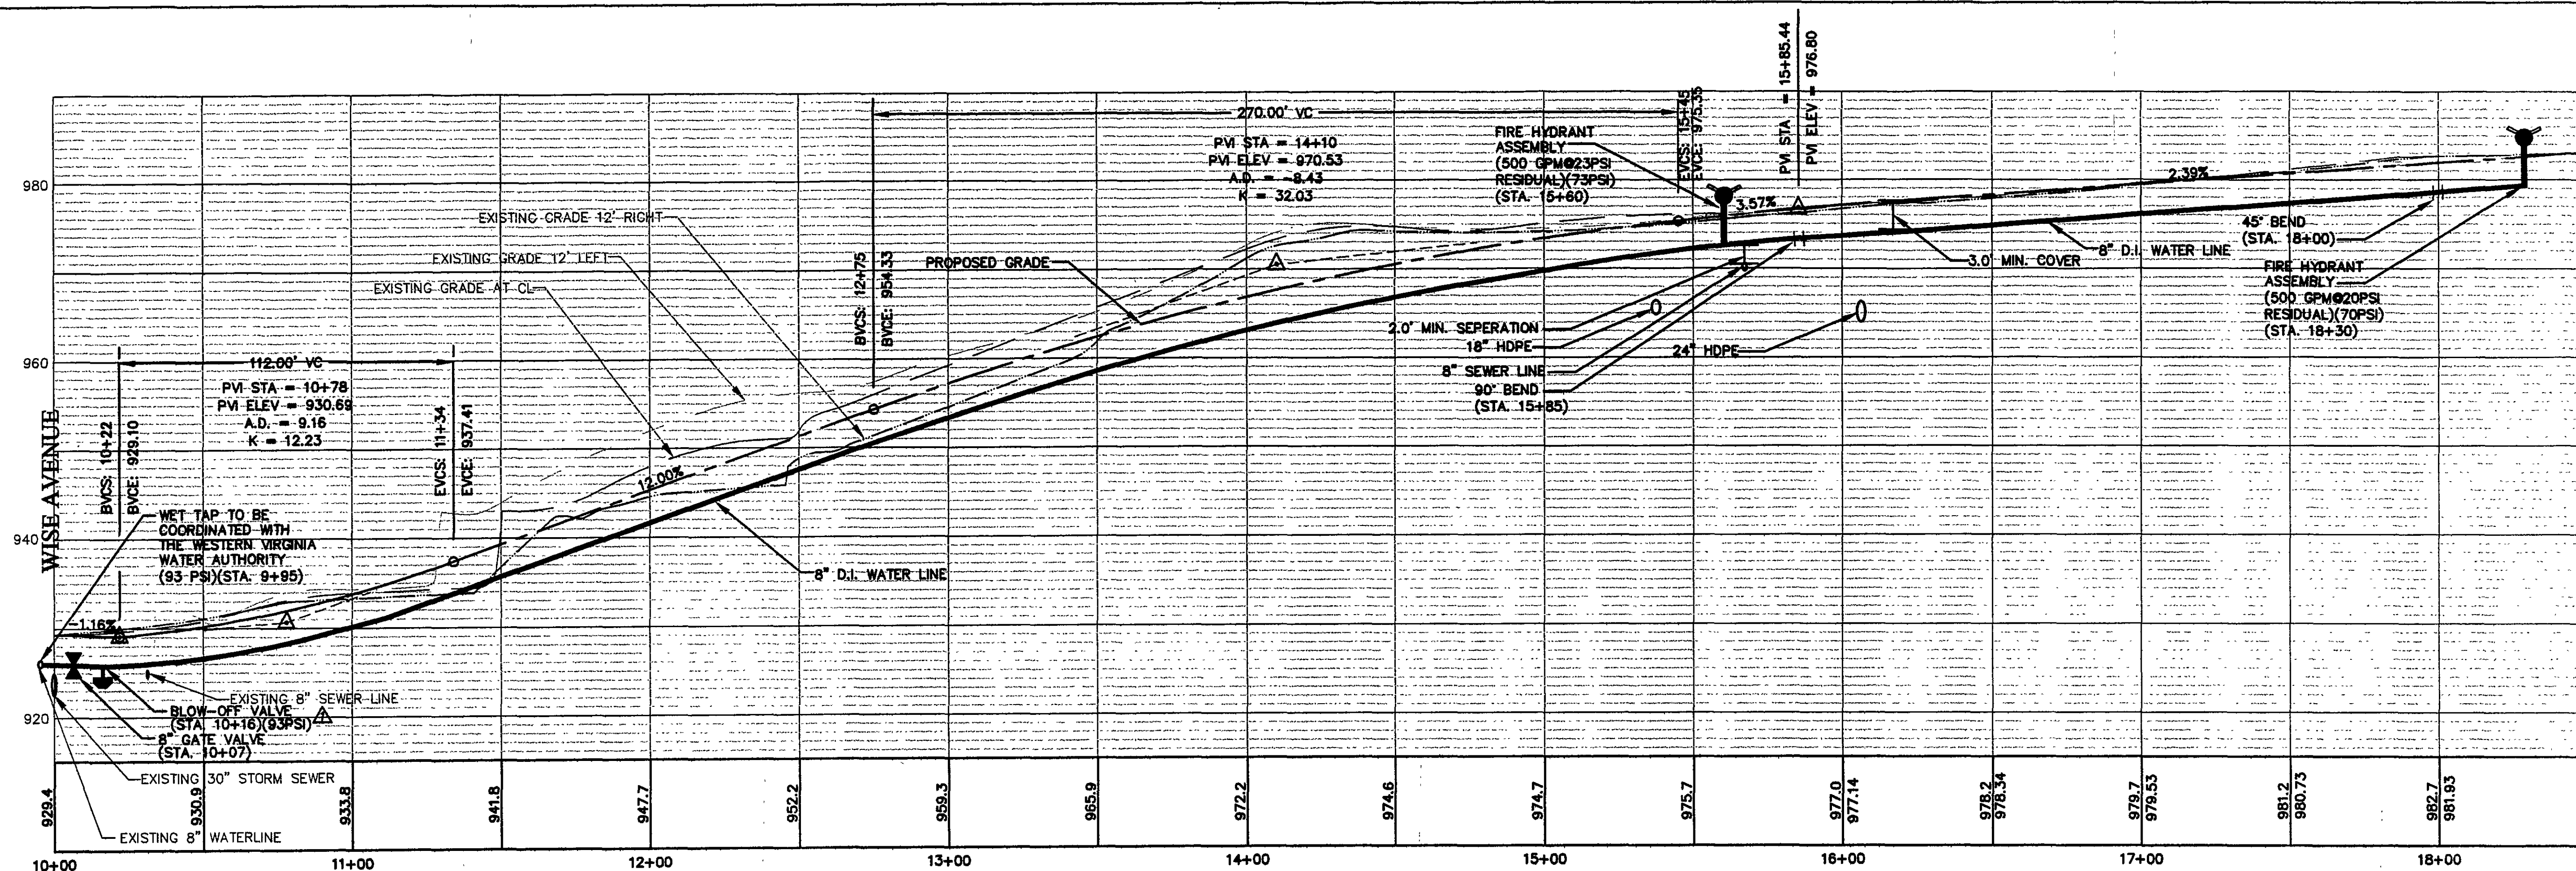

Δ DRIVEWAY AND WATERLINE PROFILE
 HORIZ. SCALE: 1" = 30'
 VERT. SCALE: 1" = 10'

102 Albemarle Ave
 Roanoke, Virginia 24013
 www.lmwpc.com
 ph: 540.345.0675
 fax: 540.342.4456
 lmweng@lmw-roanoke.com

Engineering
 Architecture
 Surveying
 Landscape Design

INDIAN VILLAGE
 COMPREHENSIVE SITE PLAN
 CITY OF ROANOKE, VIRGINIA

NO.	DATE	DESCRIPTION	BY	K/O
1	03/29/06	PER CITY COMMENTS	CHW	
2	2/9/06	PER CITY COMMENTS	CHW	

ROAD, WATER, AND SEWER
 PROFILES

Designed By	RCW
Drawn By	CHW
Checked By	RCW
Approved By	RCW
Submitted By	CHW
Drawing	2863VBASE
Date	AUG. 24, 200
Scale	AS SHOWN
Commission No.	2863
Sheet	8 of 1