



NOTE: THE DESIGN and concept indicated by this print and accompanying documents are the sole property of Craighead and associates, architects they may not be used, copied, altered or reproduced in any form or manner, nor may they be assigned to any third party without written permission of the architects. Prints not bearing the signed architects seal shall be schematic or design development drawing only, not for construction.

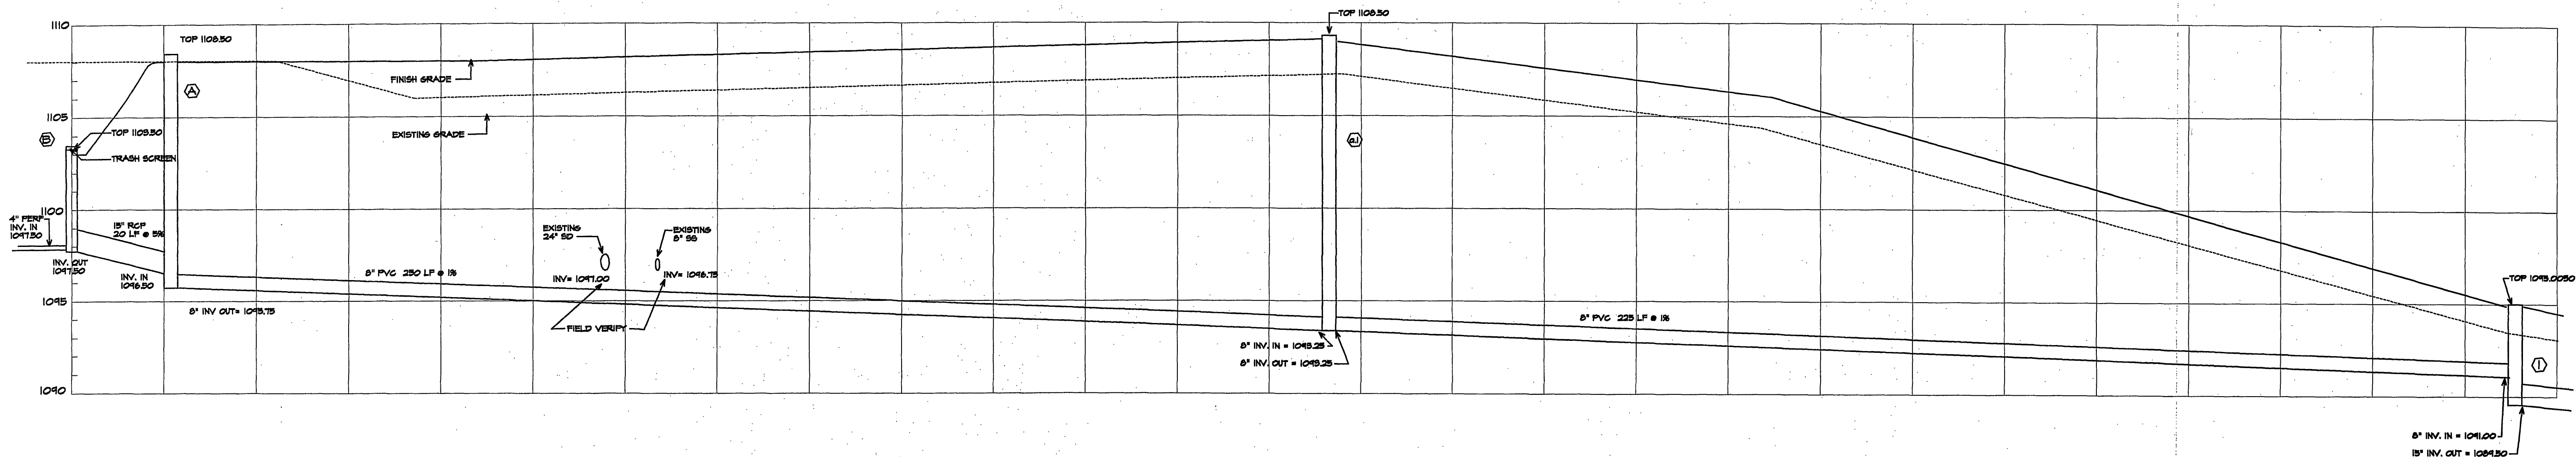

STORM DRAIN PROFILE


(H) = 1" = 20'
(V) = 1" = 5'

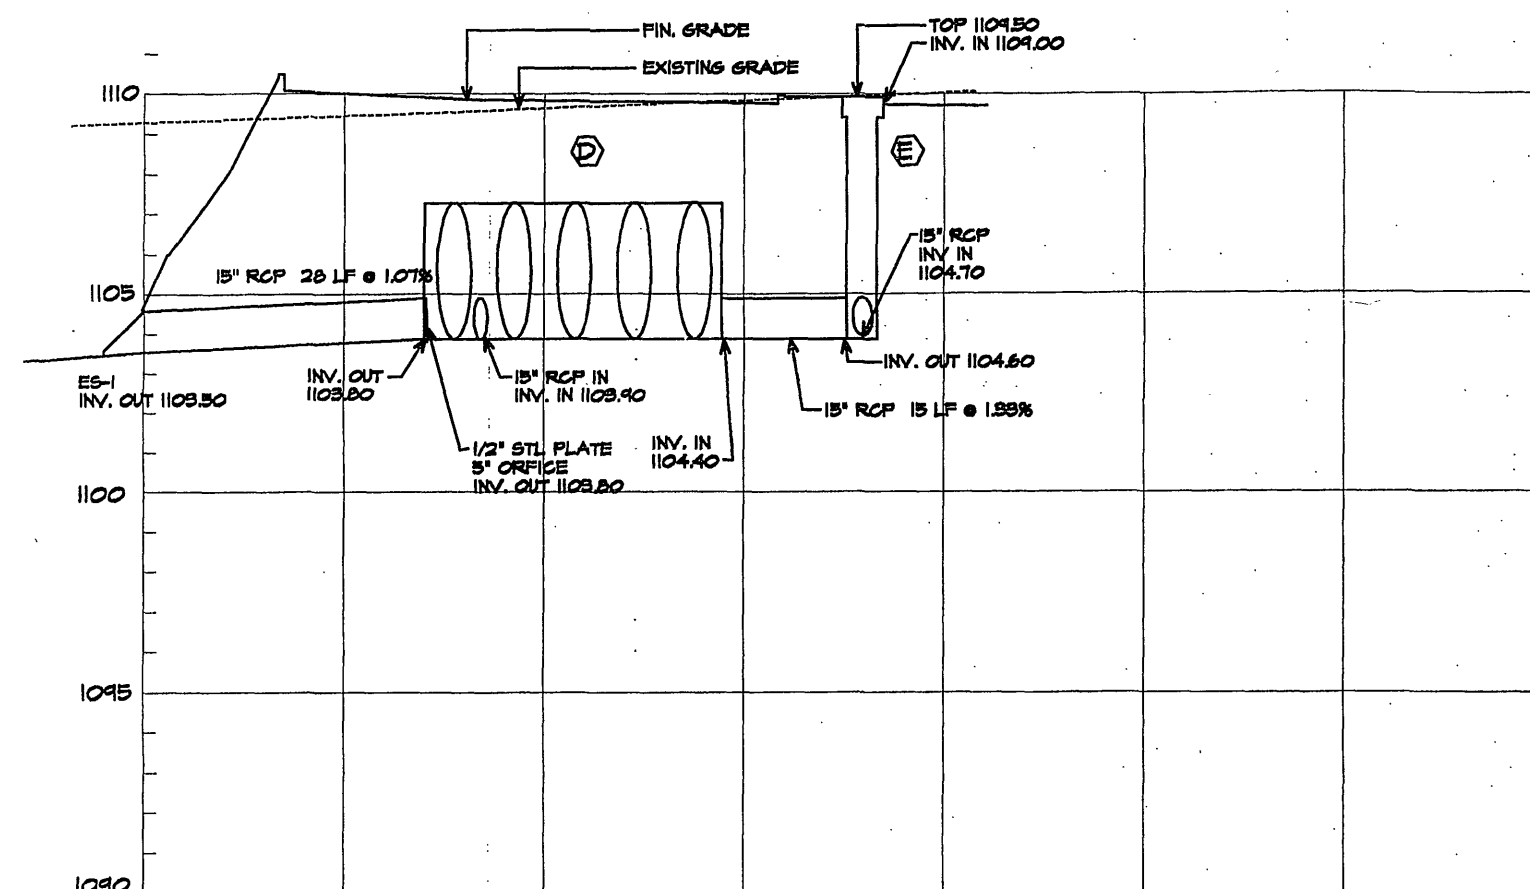

STORM DRAIN PROFILE


(H) = 1" = 20'
(V) = 1" = 5'

WEST END STORM PROFILES

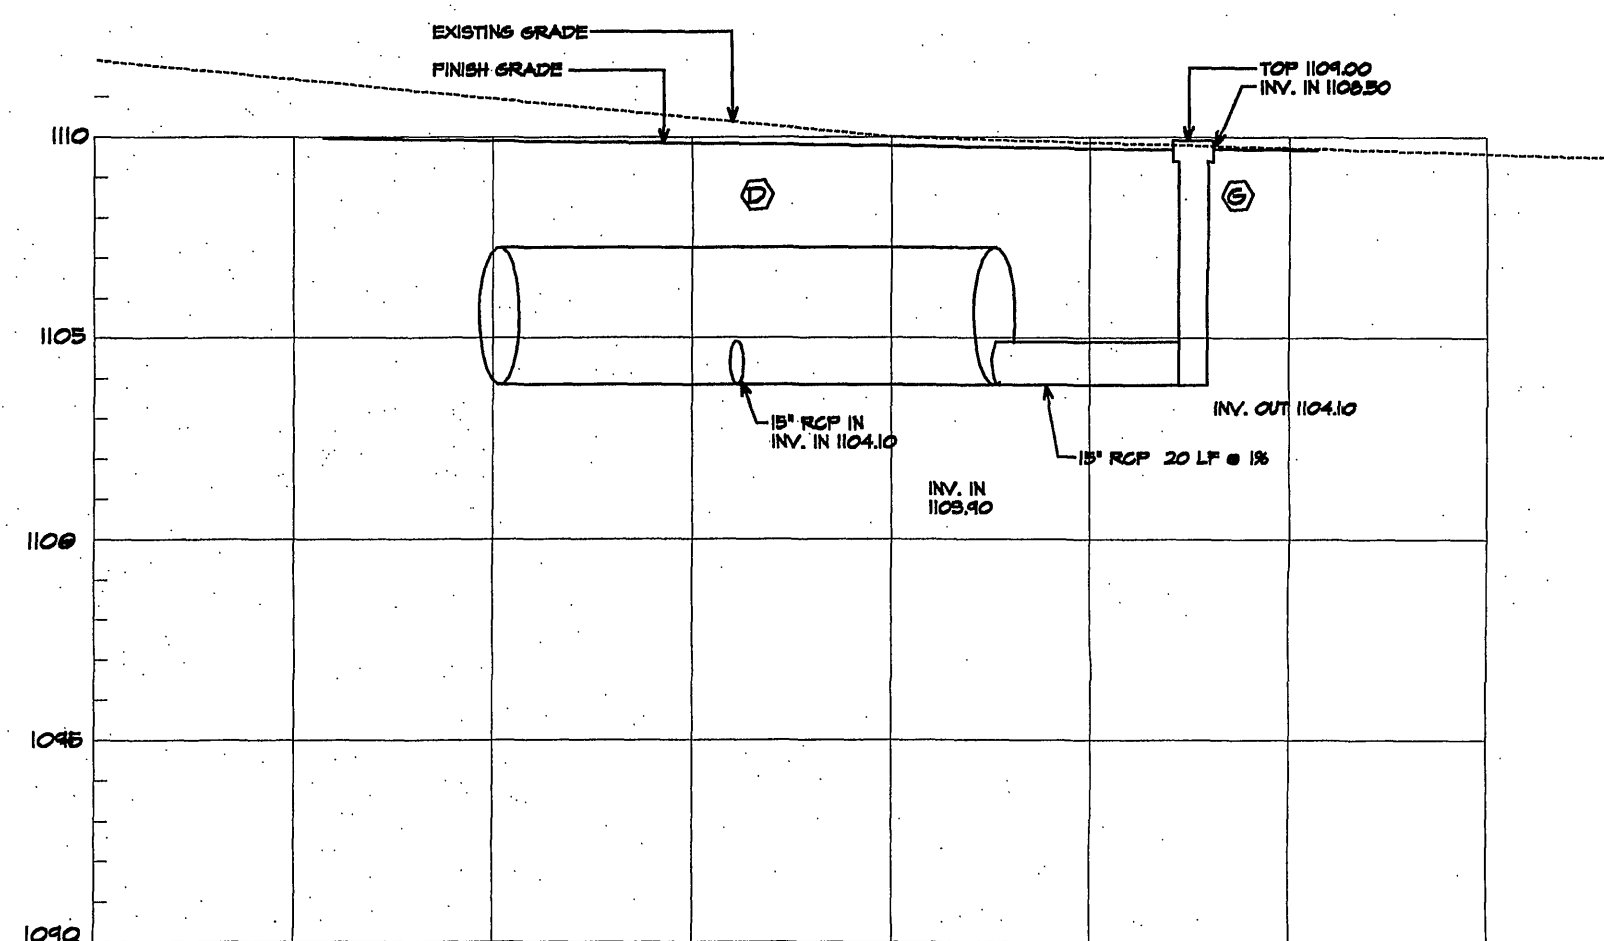

STORM DRAIN PROFILE


(H) = 1" = 20'
(V) = 1" = 5'

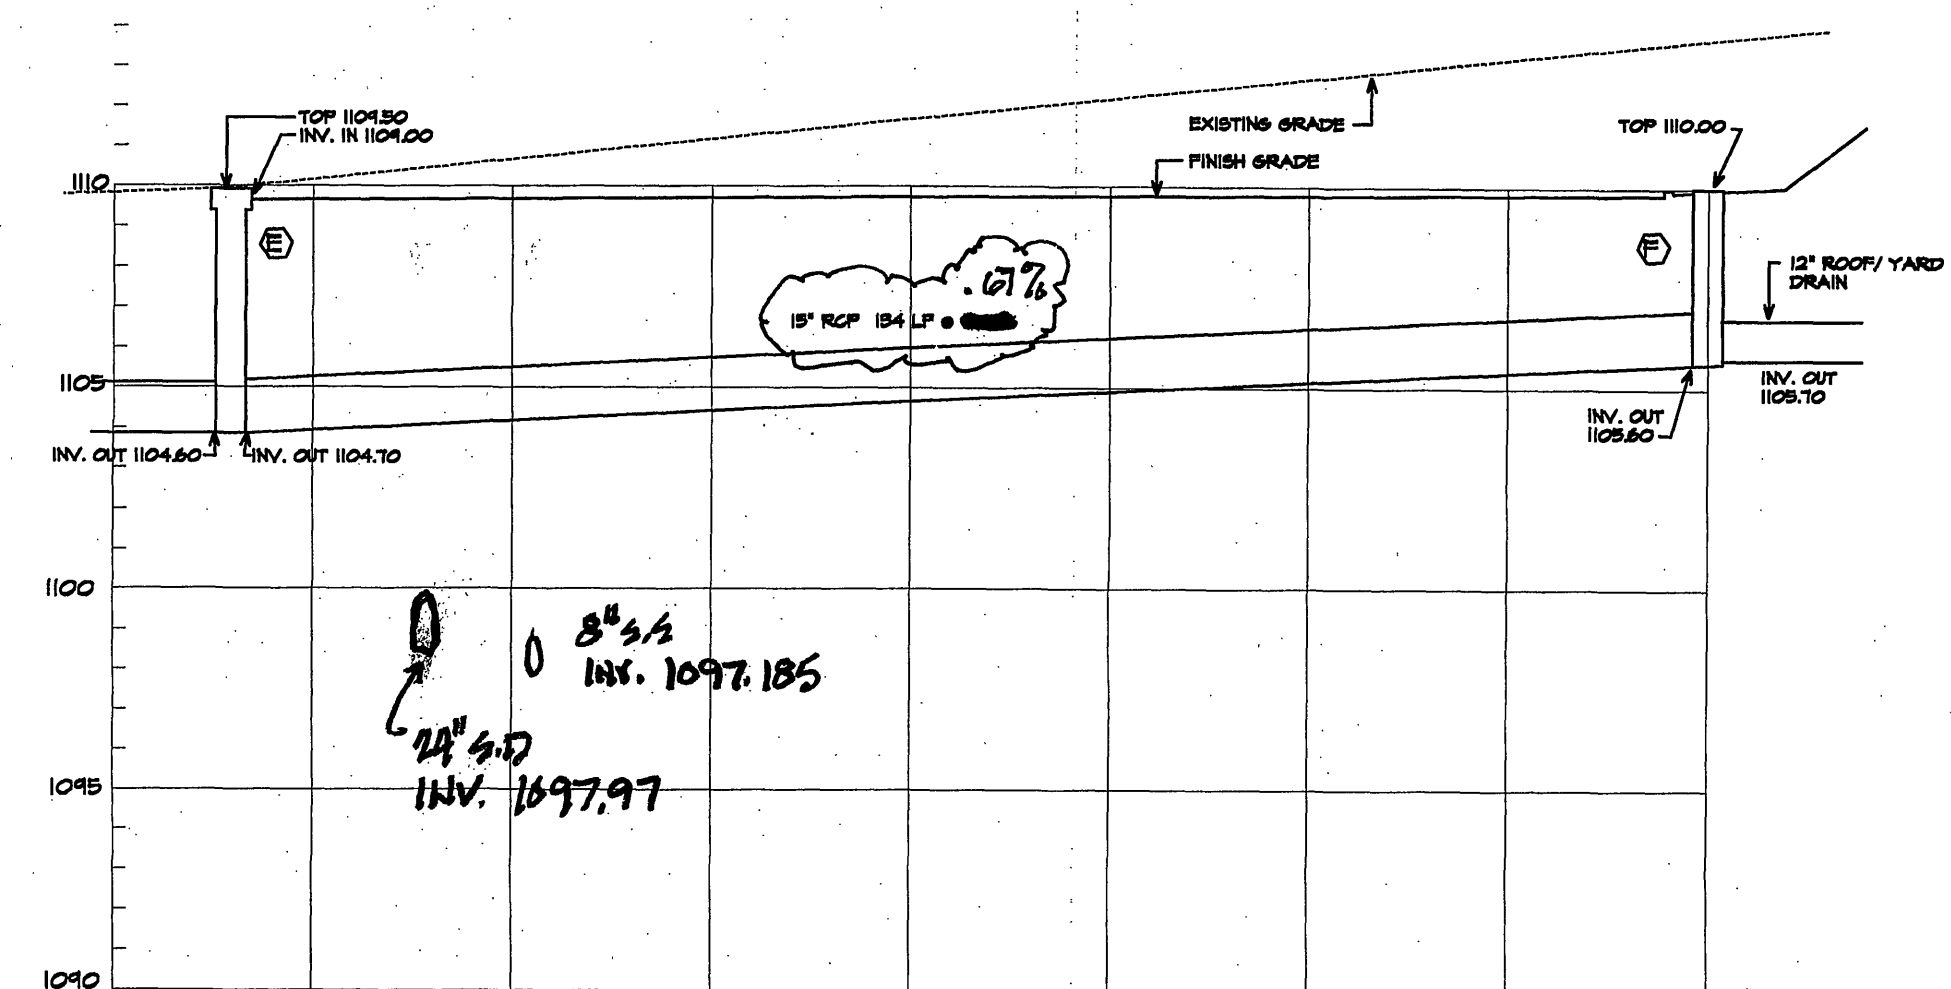

STORM DRAIN PROFILE

(H) = 1" = 20'
(V) = 1" = 5'

1ST SUBMIT	1/25/11
2ND SUBMIT	03/08/2011
3RD SUBMIT	04/15/2011
4TH SUBMIT	05/05/2011
REVISIONS	DATE

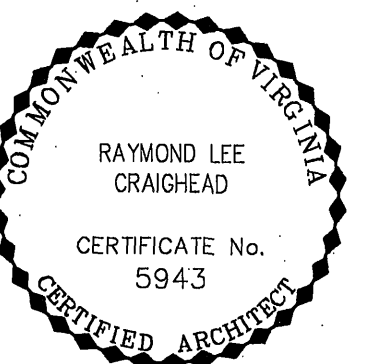

PROPOSED FACILITY
FOR
TRANE
ROANOKE CITY VA

PROJECT NO.: 21004
DATE: 1/15/10
DRAWN BY: RLC
CHECKED BY: RLC

APPROVED FOR THE OWNER DATE
S-11
STORM DRAIN PROFILES
BUILDING 5 SITE PLAN
SCALE: AS NOTED
GRAPHIC: