



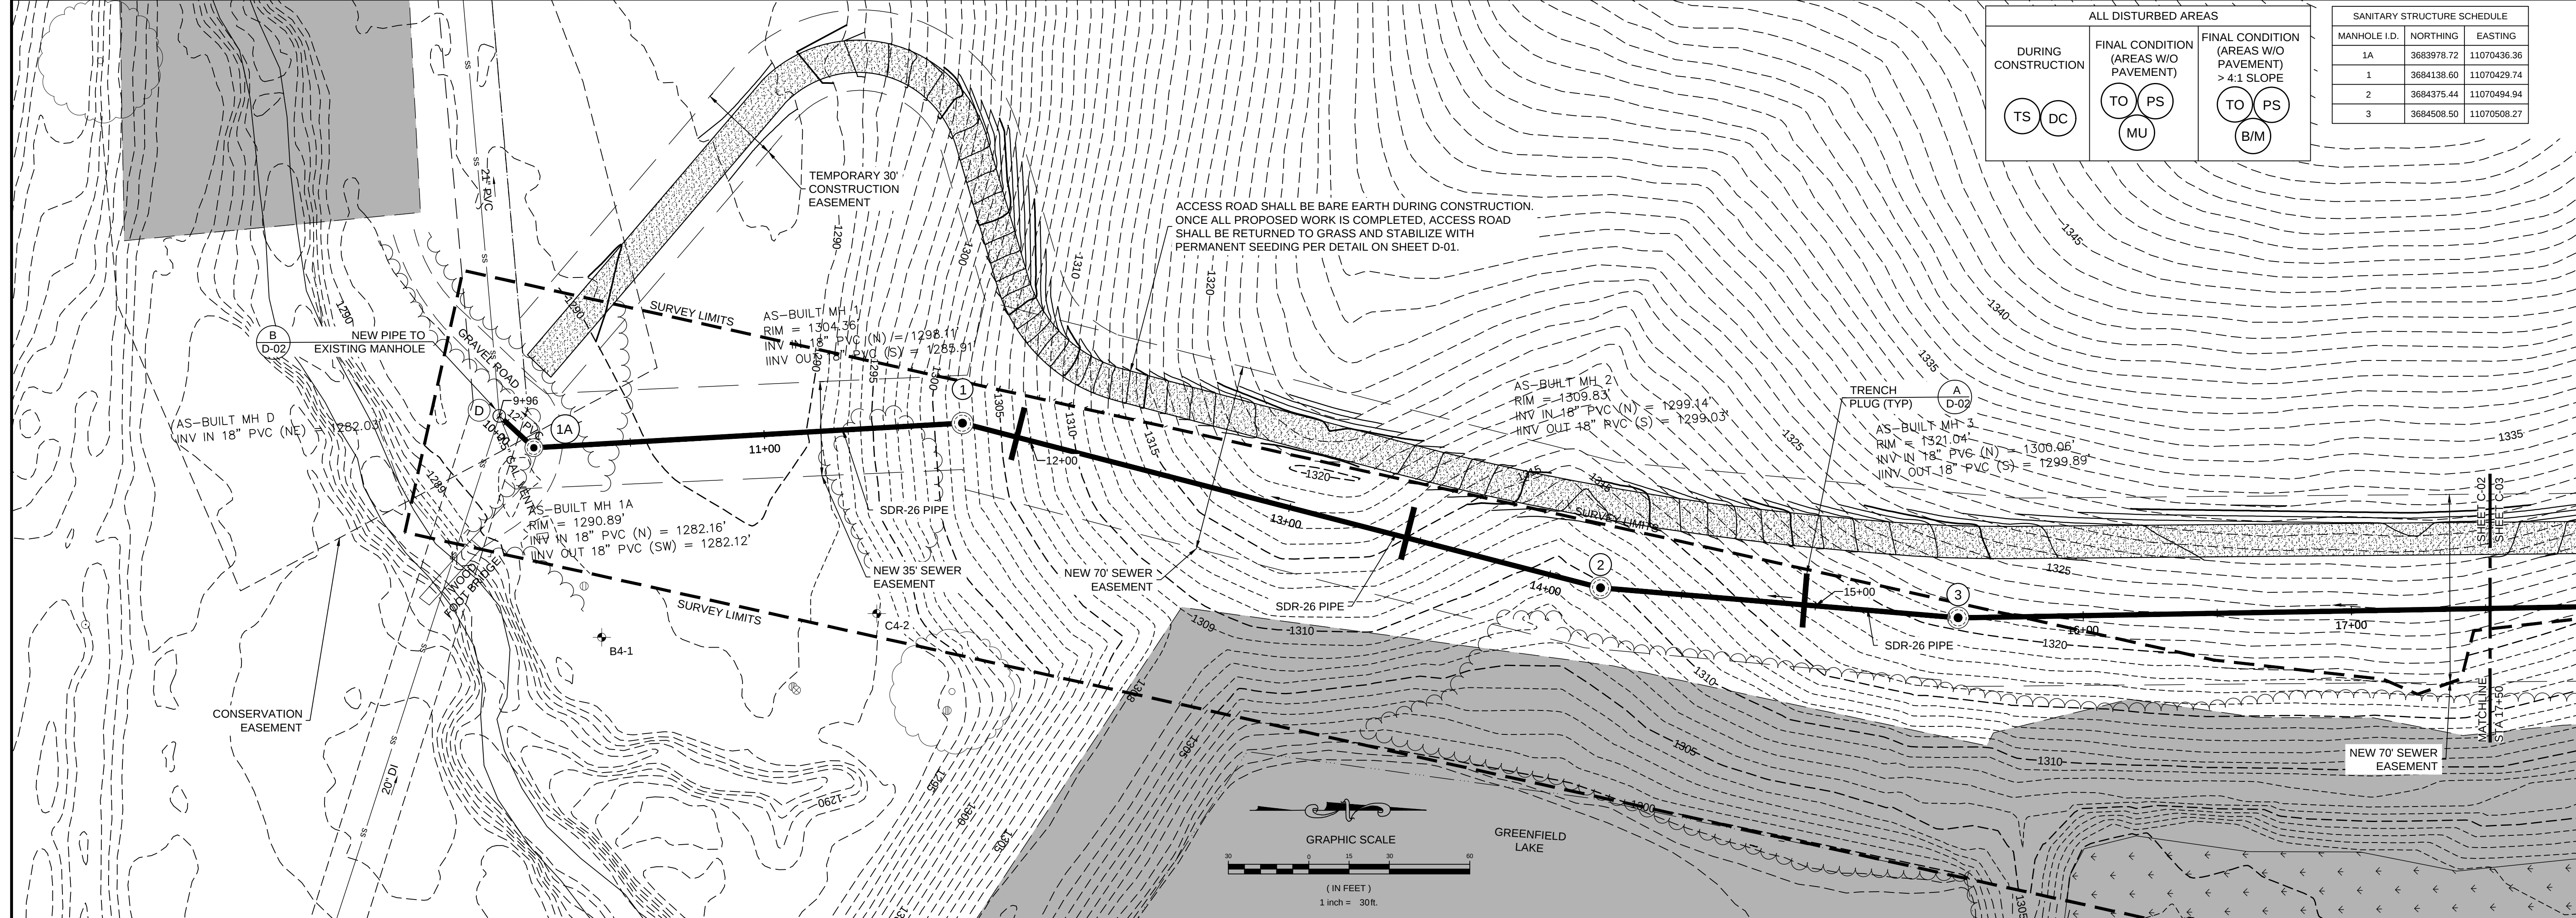

ALL DISTURBED AREAS		
DURING CONSTRUCTION	FINAL CONDITION (AREAS W/O PAVEMENT)	FINAL CONDITION (AREAS W/O PAVEMENT) > 4:1 SLOPE
TS DC	TO PS MU	TO PS B/M

SANITARY STRUCTURE SCHEDULE		
MANHOLE I.D.	NORTHING	EASTING
1A	3683978.72	11070436.36
1	3684138.60	11070429.74
2	3684375.44	11070494.94
3	3684508.50	11070508.27

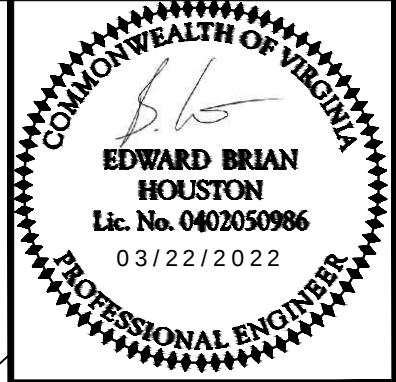


Draper Aden Associates
Engineering • Surveying • Environmental Services

2206 South Main Street
Blacksburg, VA 24060
540-552-0444 Fax: 540-552-0291
www.daa.com

• Raleigh, NC
• Fayetteville, NC
• Charlottesville, VA
• Northern Virginia
• Hampton Roads, VA
• Virginia Beach, VA

PLAN AND PROFILE
BOTETOURT CENTER AT GREENFIELD
SANITARY SEWER EXTENSION
BOTETOURT COUNTY, VIRGINIA

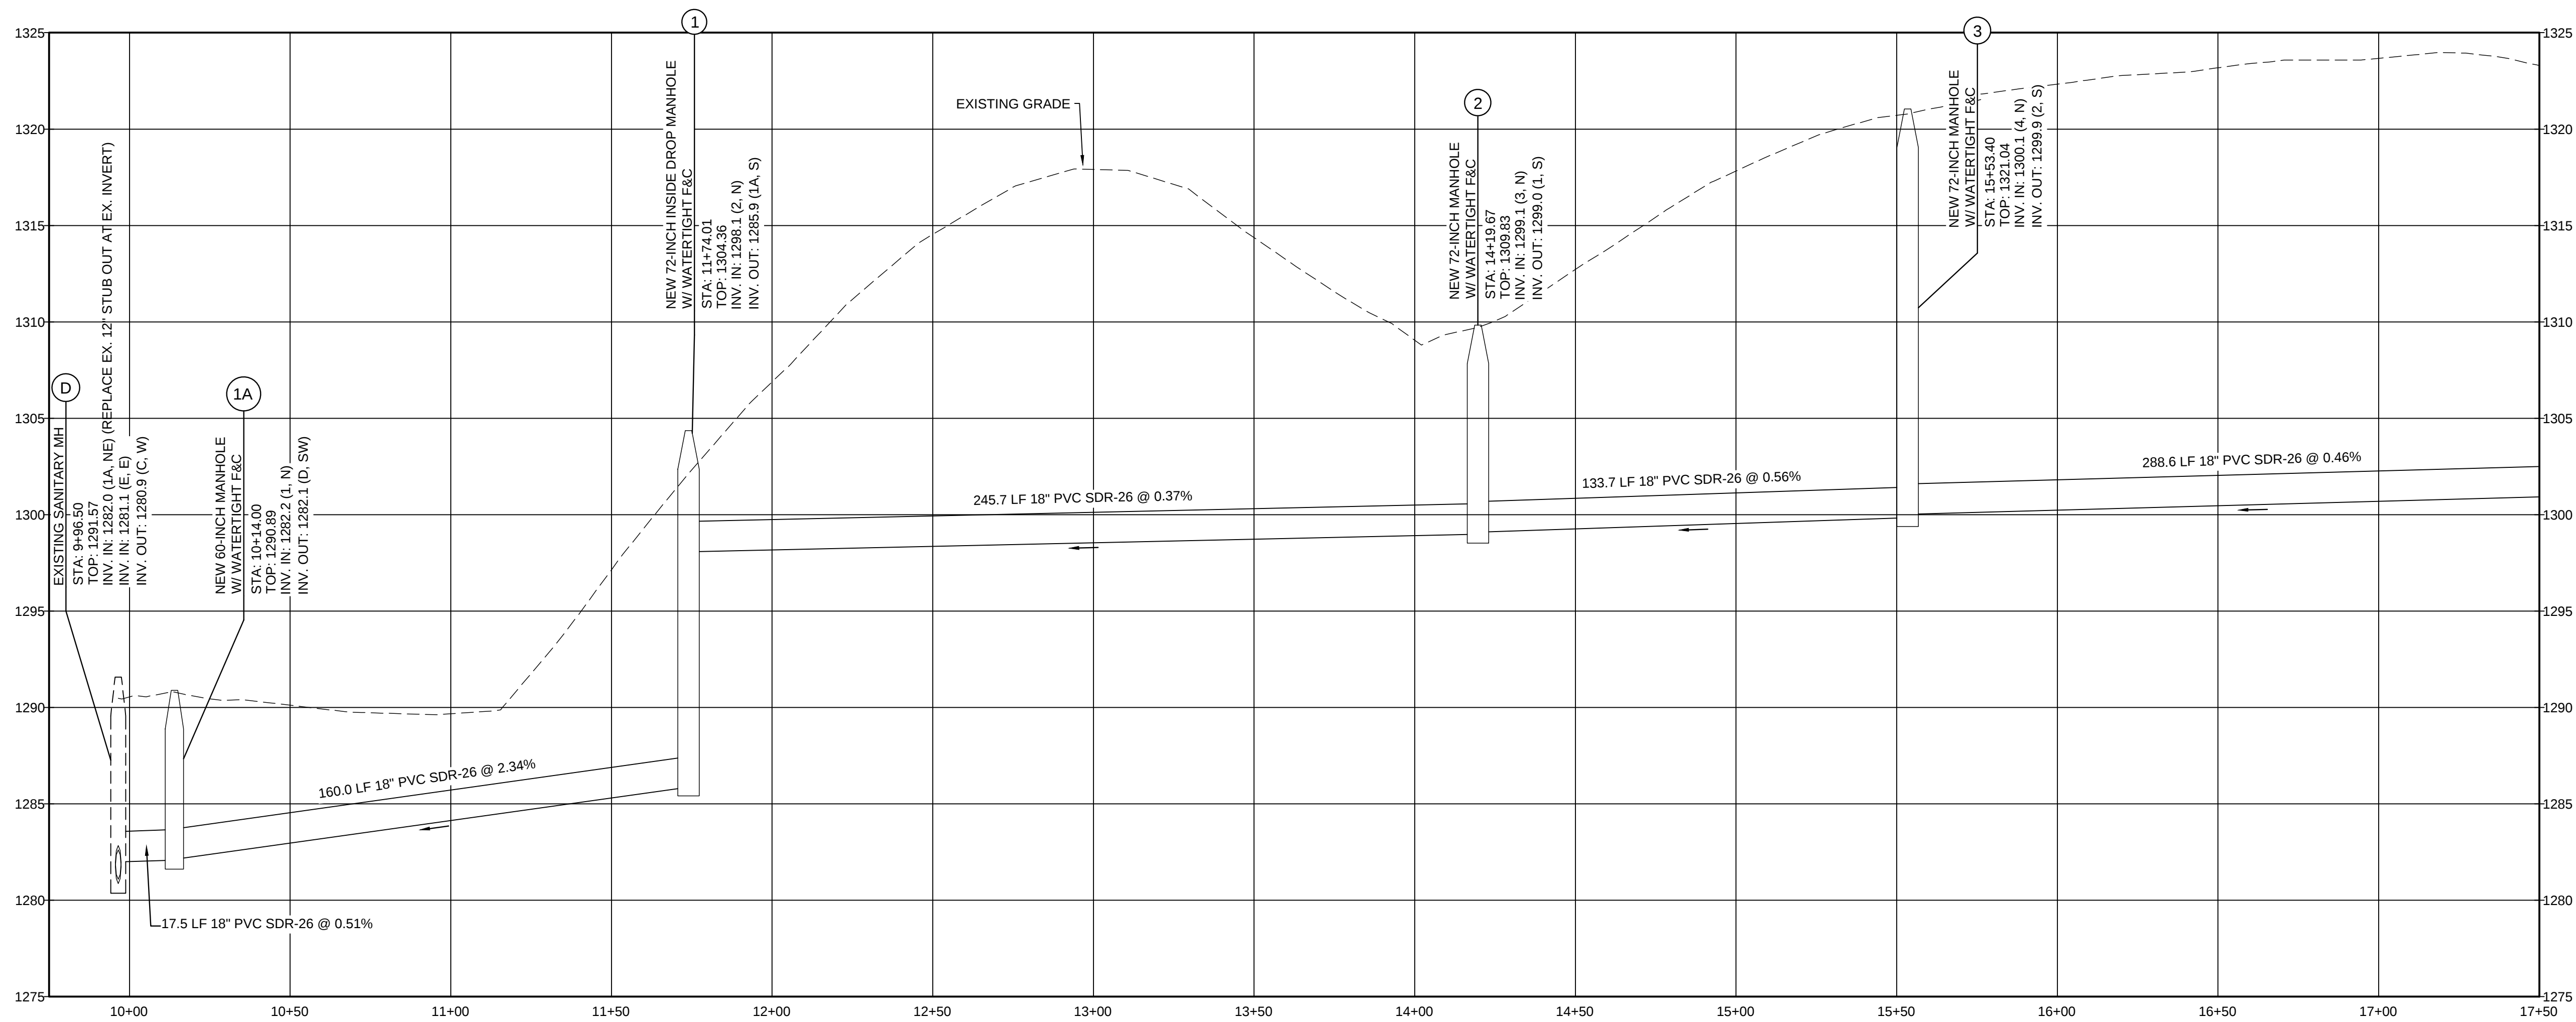

SANITARY SEWER PROFILE - STA 9+96.50 TO 17+50 - Scale: H: 1"=30', V: 1"=5'

REVISIONS		
NO.	DESCRIPTION	DATE
1	ISSUED FOR CONSTRUCTION	8/6/2021
2	CO #2	09/08/21
3	CO #3	10/06/21
4	CO #4	11/16/21
5	RECORD DWG	03/22/22

DESIGNED BY:	RCN
DRAWN BY:	NRK
CHECKED BY:	EBH
SCALE:	SEE PLAN
DATE:	03/22/2022
PROJECT NUMBER:	2109323-06