



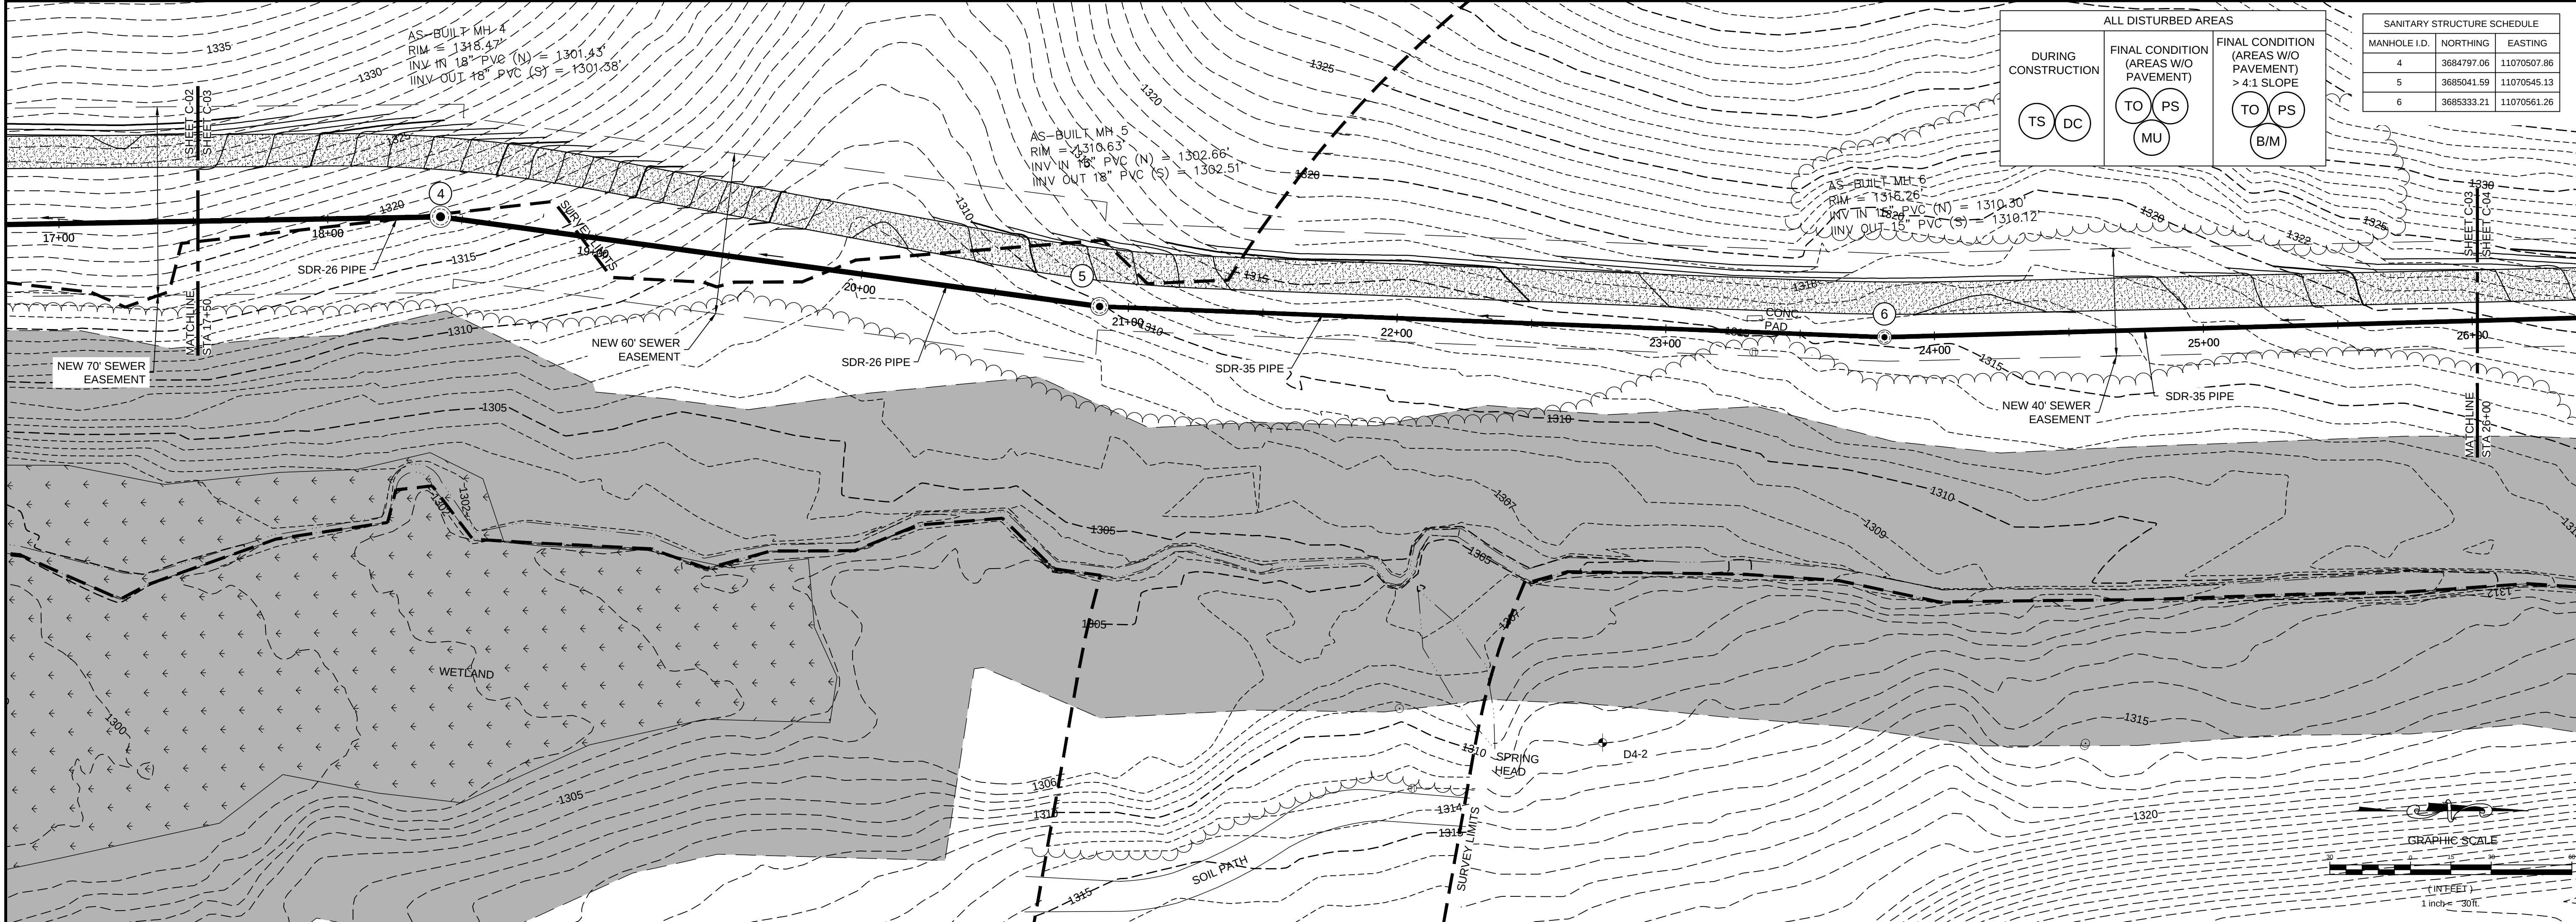

ALL DISTURBED AREAS		
DURING CONSTRUCTION	FINAL CONDITION (AREAS W/O PAVEMENT)	FINAL CONDITION (AREAS W/O PAVEMENT) > 4:1 SLOPE
TS DC	TO PS MU	TO PS B/M

SANITARY STRUCTURE SCHEDULE		
MANHOLE I.D.	NORTHING	EASTING
4	3684797.06	11070507.86
5	3685041.59	11070545.13
6	3685333.21	11070561.26

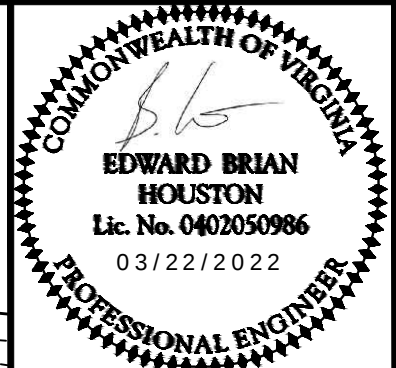

Draper Aden Associates

Engineering • Surveying • Environmental Services

2206 South Main Street
Blacksburg, VA 24060
540-552-0444 Fax: 540-552-0291
www.daa.com

• Raleigh, NC

• Fayetteville, NC

• Charlottesville, VA

• Northern Virginia

• Hampton Roads, VA

• Virginia Beach, VA

PLAN AND PROFILE

BOTETOURT CENTER AT GREENFIELD


SANITARY SEWER EXTENSION

BOTETOURT COUNTY, VIRGINIA

REVISIONS		
NO.	DESCRIPTION	DATE
1	ISSUED FOR CONSTRUCTION	8/6/2021
2	CO #2	09/08/21
3	CO #3	10/06/21
4	CO #4	11/16/21
5	RECORD DWG	03/22/22

DESIGNED BY:	RCN
DRAWN BY:	NRK
CHECKED BY:	EBH
SCALE:	SEE PLAN
DATE:	03/22/2022
PROJECT NUMBER:	2109323-06

C-03

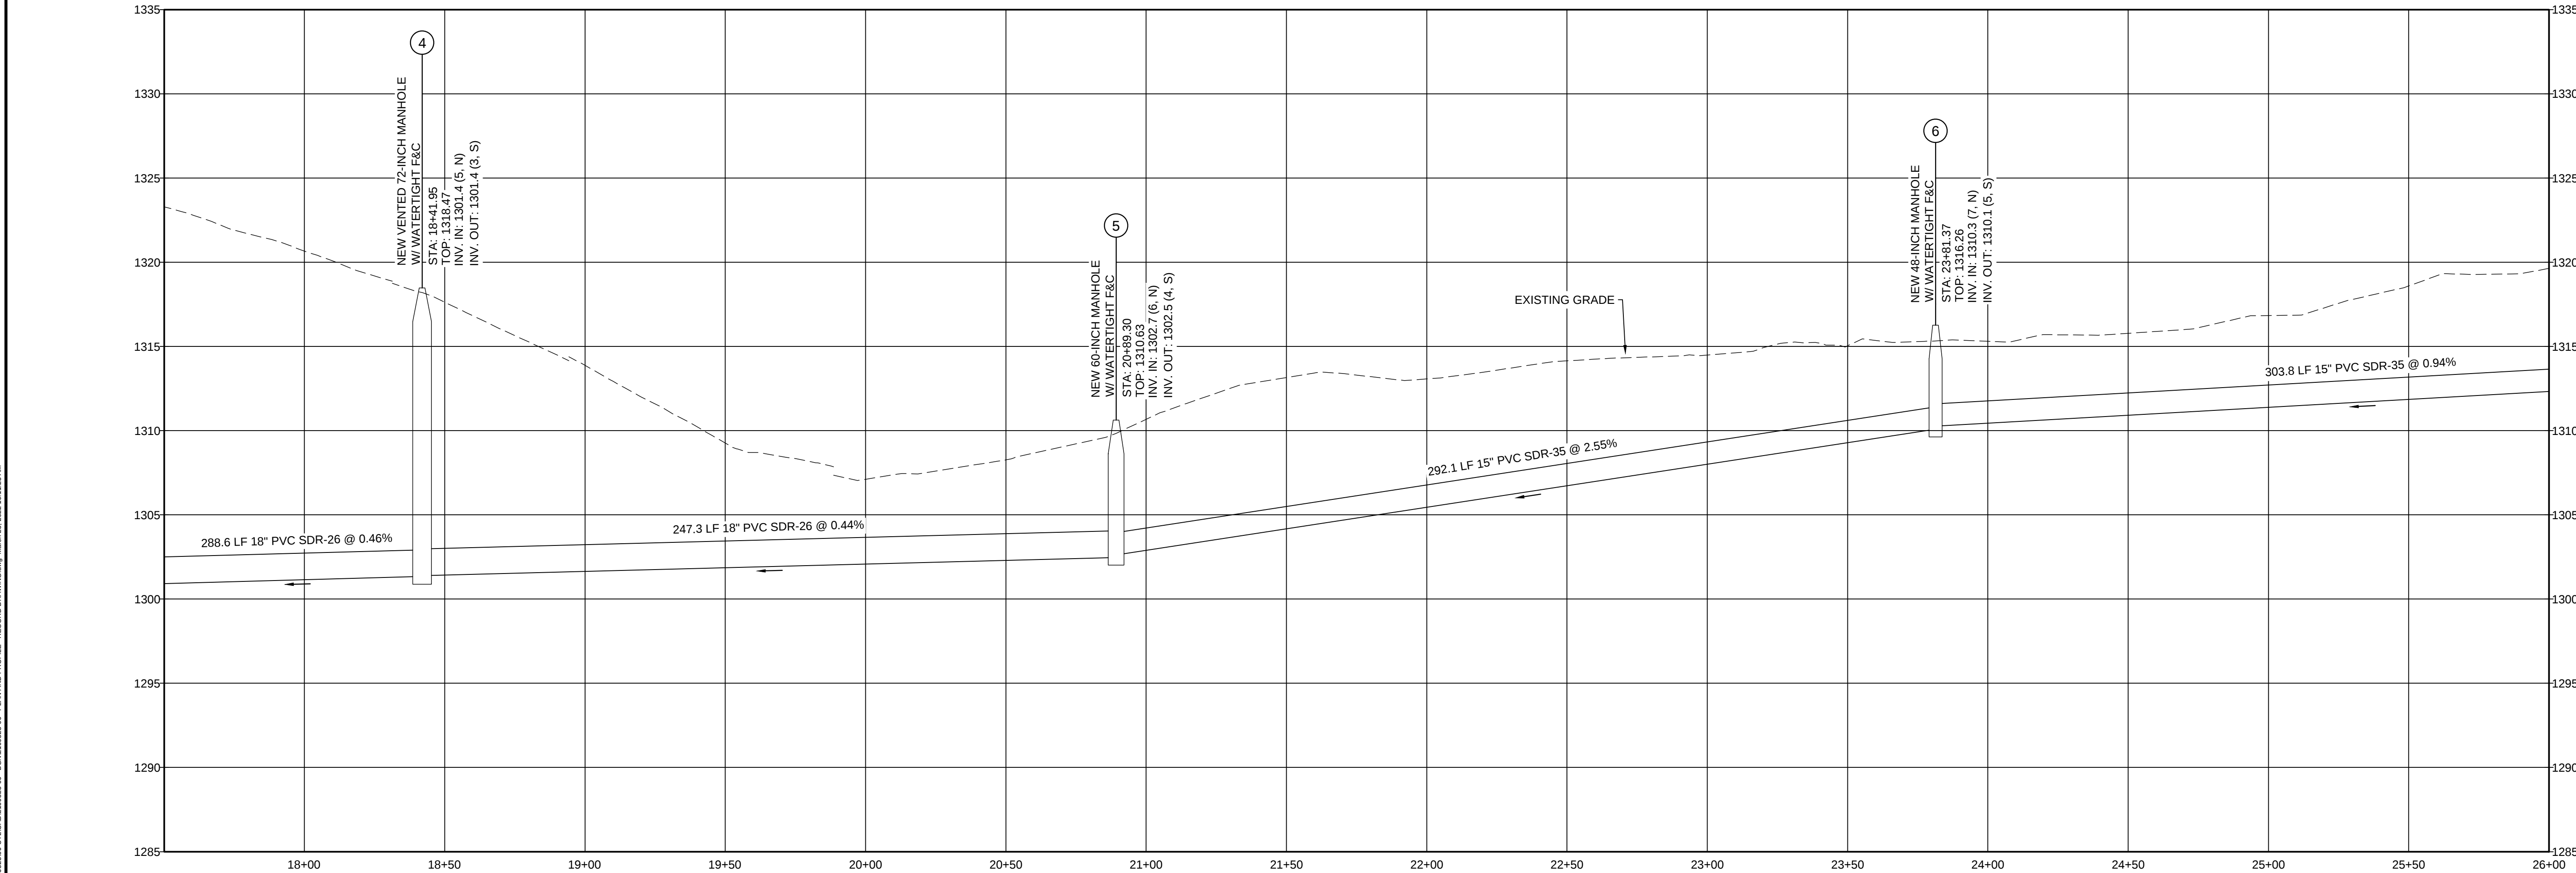

SANITARY SEWER PROFILE - STA 17+50 TO 26+00 - Scale: H: 1"=30', V: 1"=5'

P:\2109323-06\2109323-06_UPL\CA02128223-06_PLAN AND PROFILE - RECORD DRAWING.dwg, March 23, 2022 10:11:23 AM