
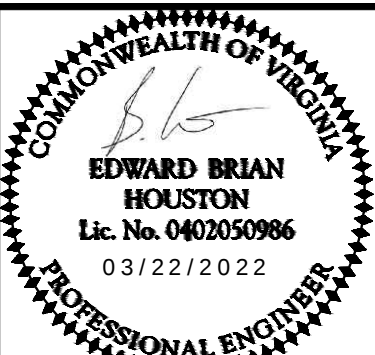
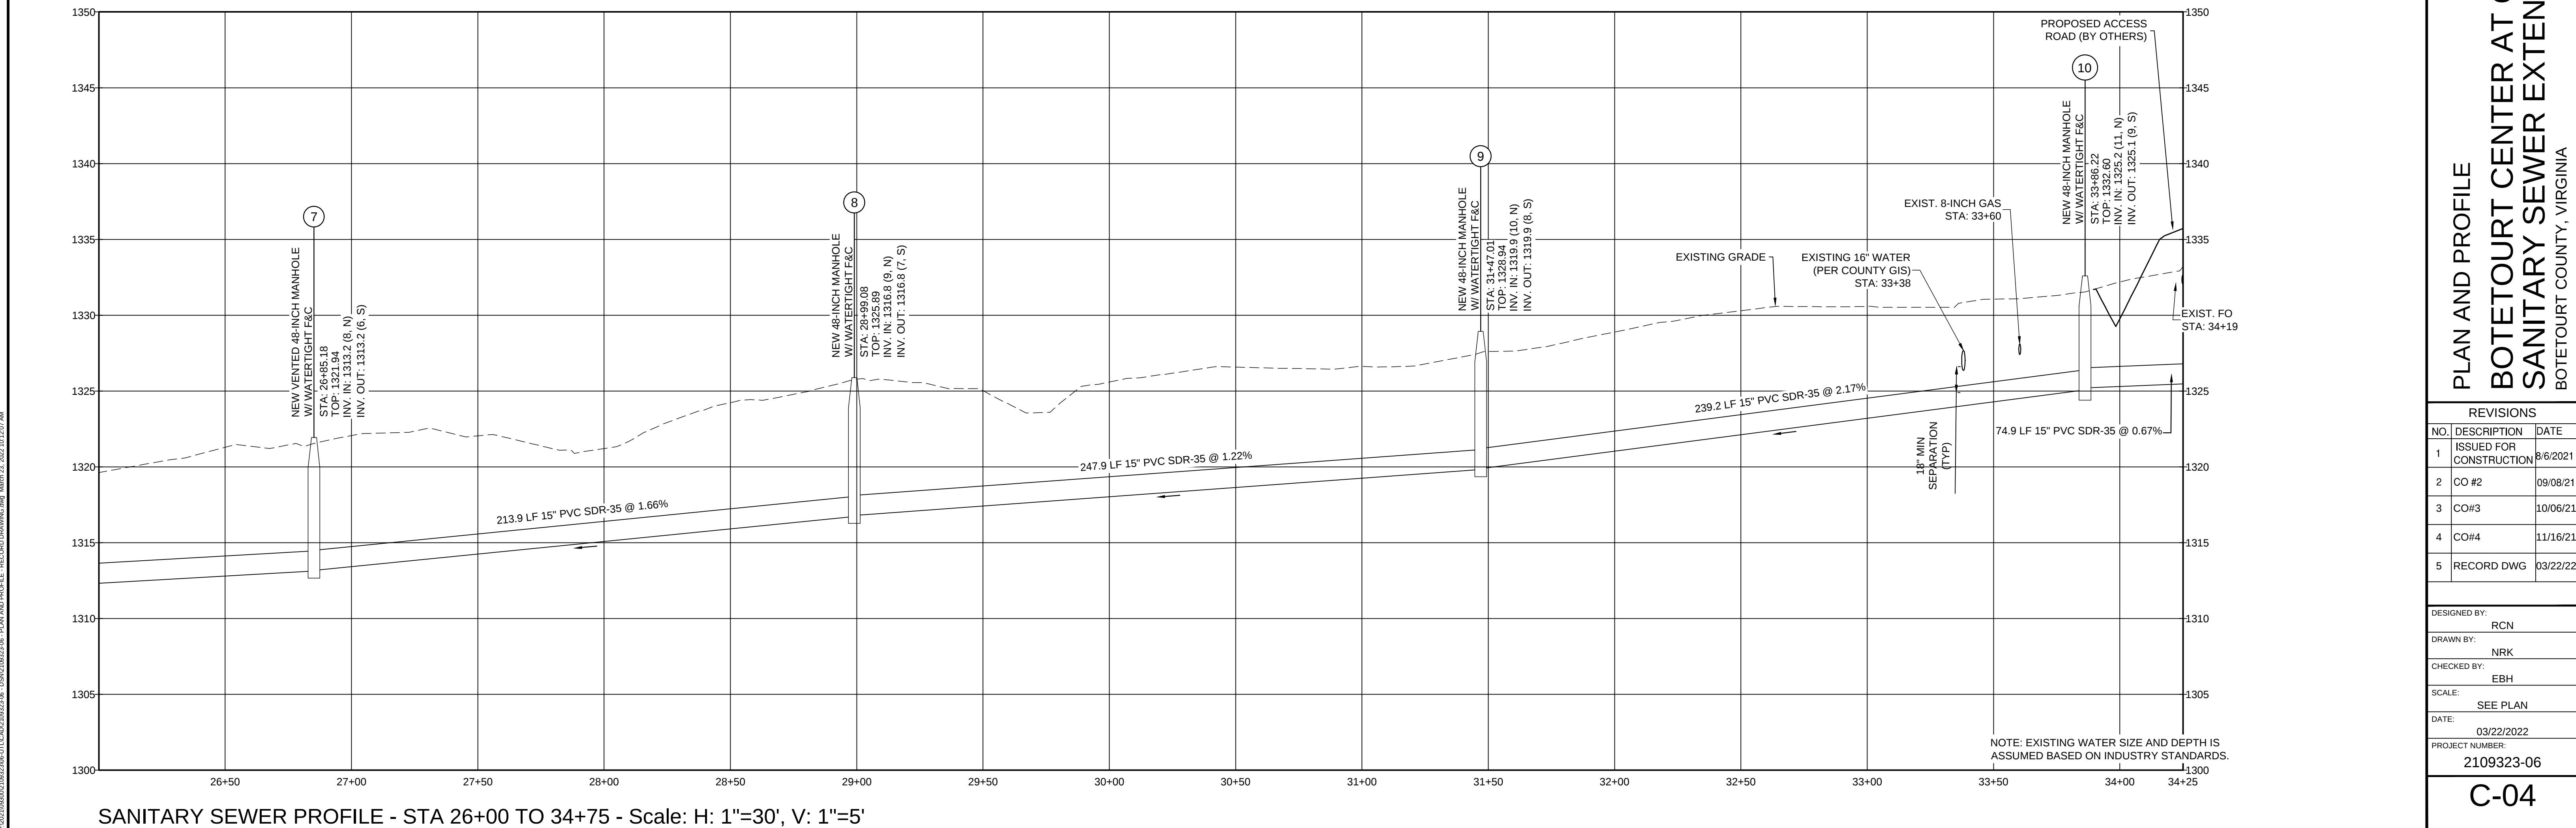


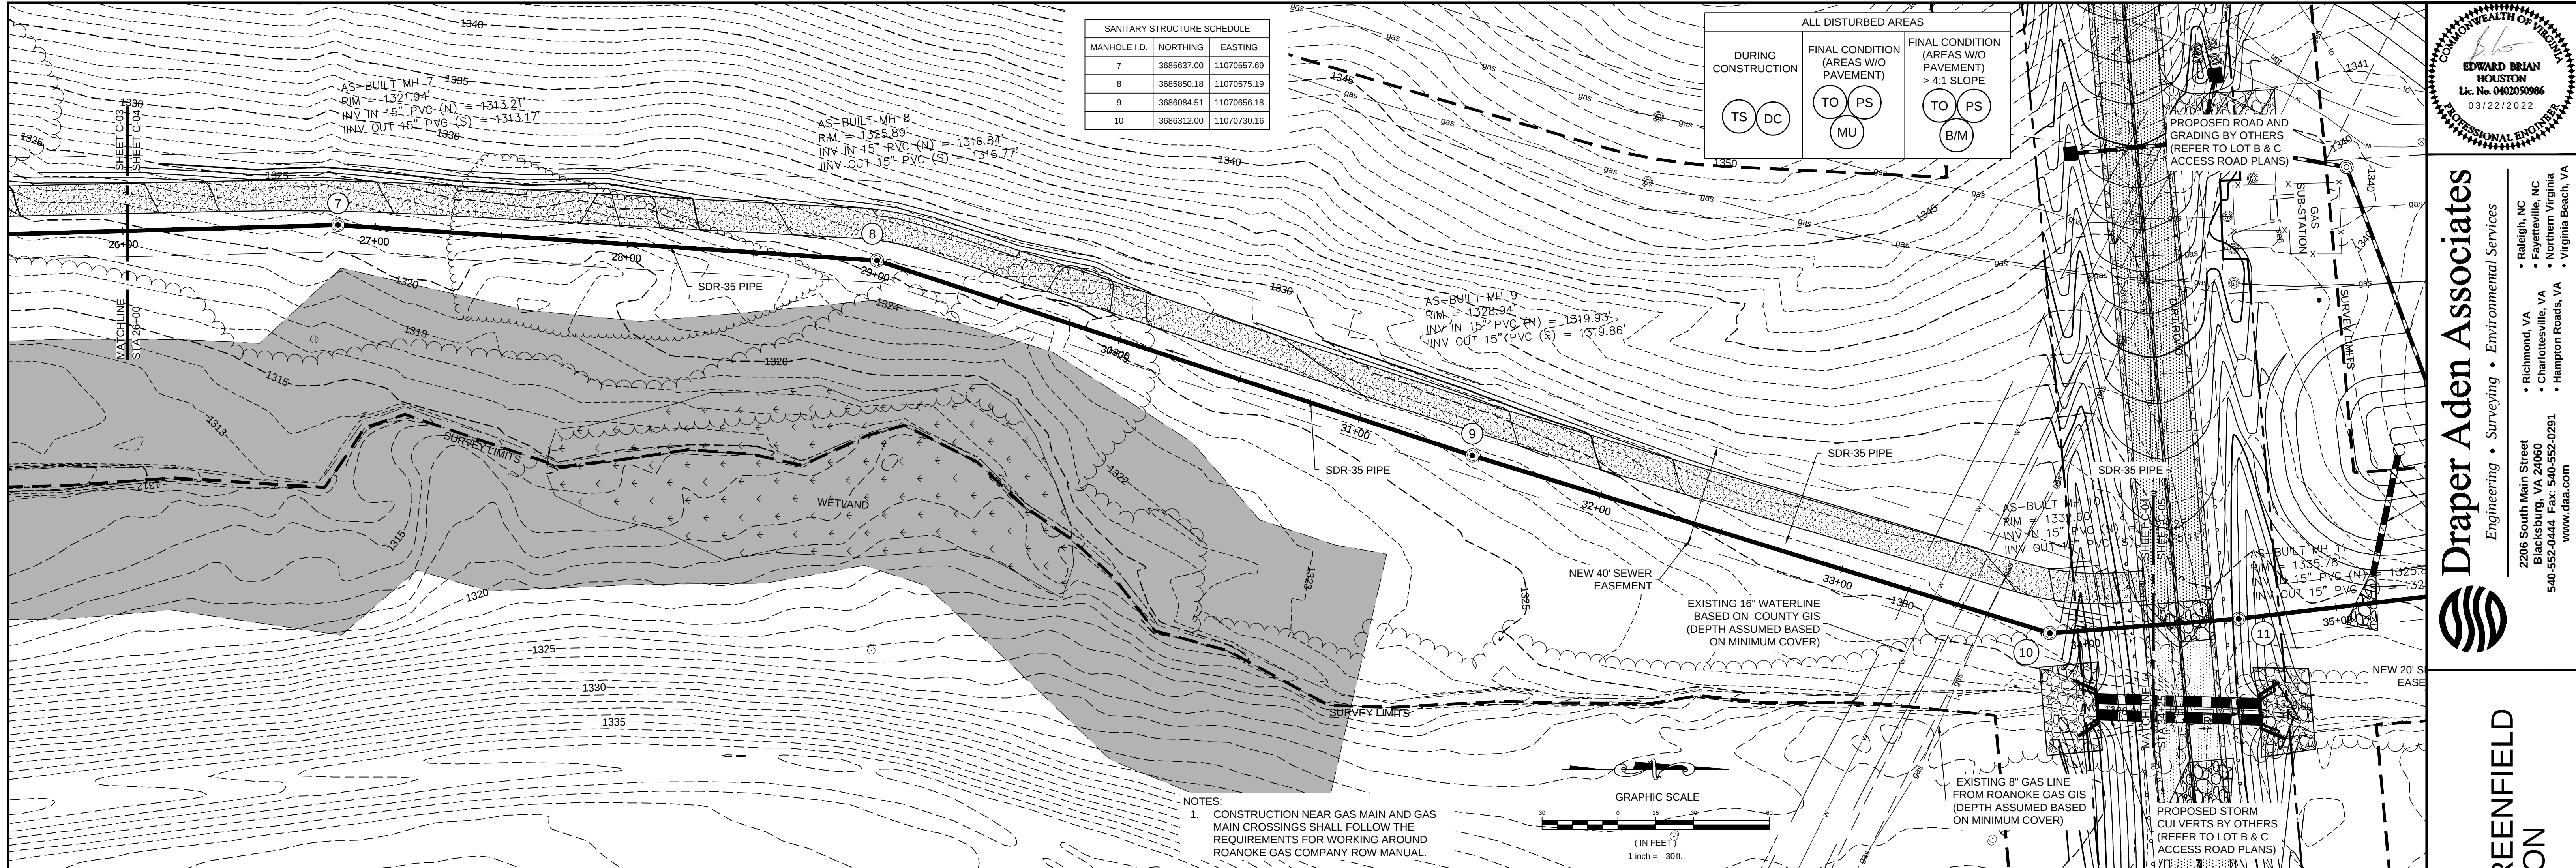

Draper Aden Associates
Engineering • Surveying • Environmental Services

2206 South Main Street
Blacksburg, VA 24060
540-552-0444 • Fax: 540-552-0291
www.daa.com

Richmond, VA
Fayetteville, NC
Charlottesville, VA
Hampton Roads, VA
Virginia Beach, VA

PLAN AND PROFILE
BOTETOURT CENTER AT GREENFIELD
SANITARY SEWER EXTENSION
BOTETOURT COUNTY, VIRGINIA

REVISIONS		
NO.	DESCRIPTION	DATE
1	ISSUED FOR CONSTRUCTION	8/6/2021
2	CO #2	09/08/21
3	CO #3	10/06/21
4	CO #4	11/16/21
5	RECORD DWG	03/22/22

DESIGNED BY:	RCN
DRAWN BY:	NRK
CHECKED BY:	EBH
SCALE:	SEE PLAN
DATE:	03/22/2022
PROJECT NUMBER:	2109323-06

C-04