

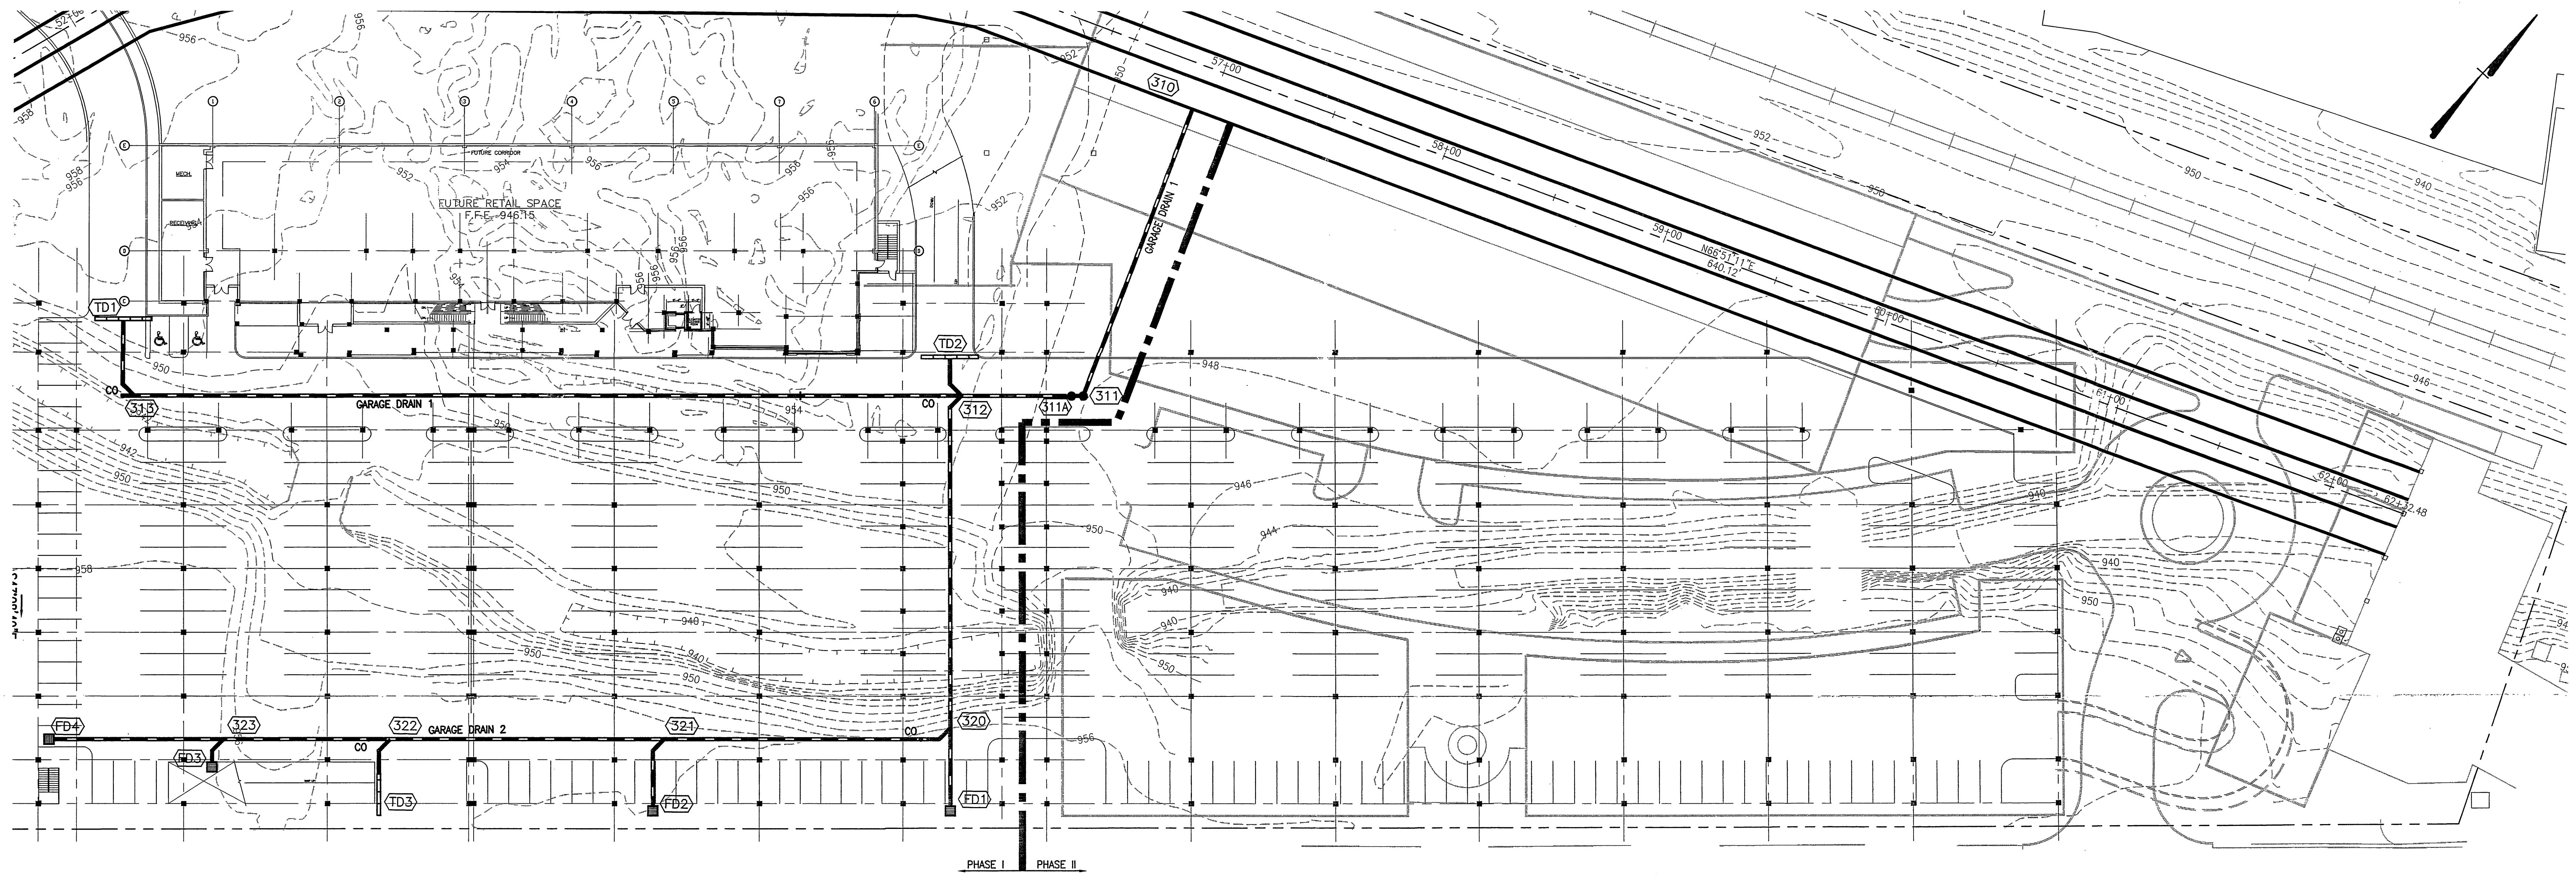


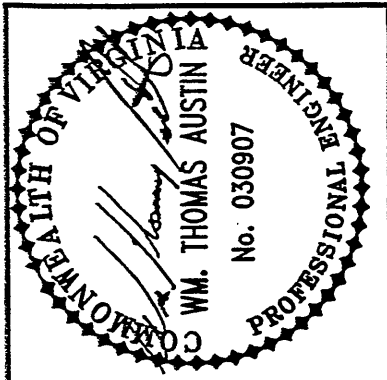

34°02'58"W
BASEMENT PLAN B - REVISED 6-27-05

THIS SHEET SHOWS WORK IN PHASE I AND PHASE II. WORK SHOWN IN THE PHASE II AREA IS FOR COORDINATION/REFERENCE ONLY.

- LEGEND**
- DITCH LINE
 - RL ROOF LEADER (SIZE AS INDICATED)
 - INFILTRATION TRENCH

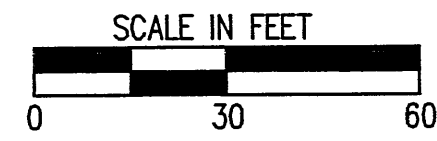

Revisions	Date
1 FINAL CITY OF ROANOKE REVIEW	1/15/05

Issue Date:	OCTOBER 25, 2005
Drawn By:	CZY
Designed By:	RSM/CZY/WTA
Checked By:	WTA
Date:	10/25/2005

Mattern & Craig
CONSULTING ENGINEERS • SURVEYORS
701 FIRST STREET
ROANOKE, VIRGINIA 24012
TEL: (540) 346-5622
FAX: (540) 346-1681

SITE DEVELOPMENT PLANS
IVY MARKET - PHASE I
**LOWER LEVEL STORM
DRAINAGE PLAN**
CITY OF ROANOKE, VIRGINIA

Vertical Scale:	N/A
Horizontal Scale:	1" = 30'
Commission No.	2384

Sheet No.:
C-6A