



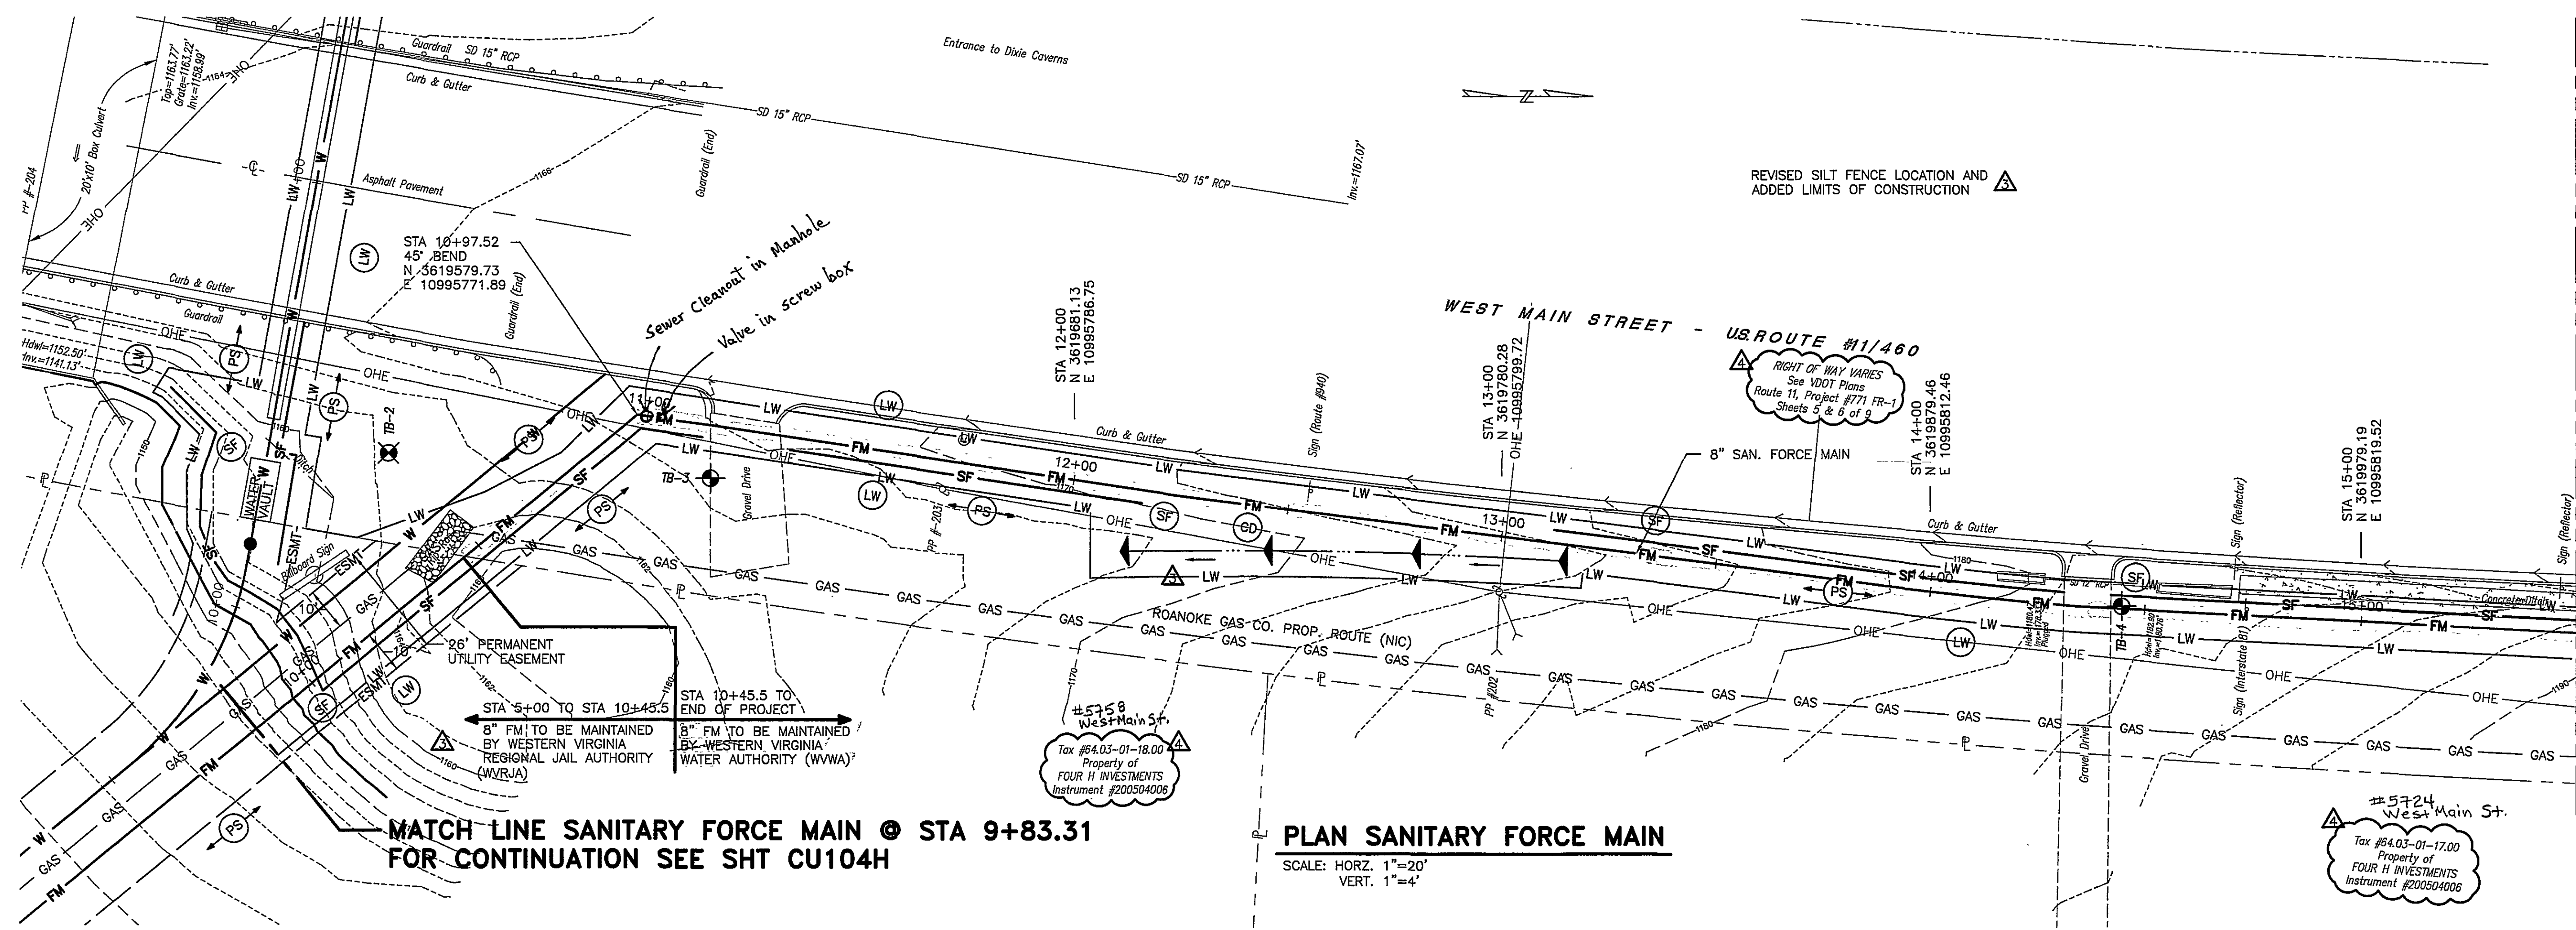


MATCH LINE SANITARY FORCE MAIN @ STA 15+50
FOR CONTINUATION SEE SHEET CU104J

- NOTES THIS SHEET:**
- SEE SHEET C001 FOR SITE/UTILITIES NOTES. SEE SHEET C002 FOR LEGEND.
 - SEE SHEET C501, C503 FOR UTILITY DETAILS.
 - SEE SHEET CU104 FOR SHEET KEY PLAN, OFF SITE UTILITIES.
 - SEE SHEET CU104Q FOR HORIZONTAL AND VERTICAL POINT CONTROL REFERENCE DIAGRAMS.

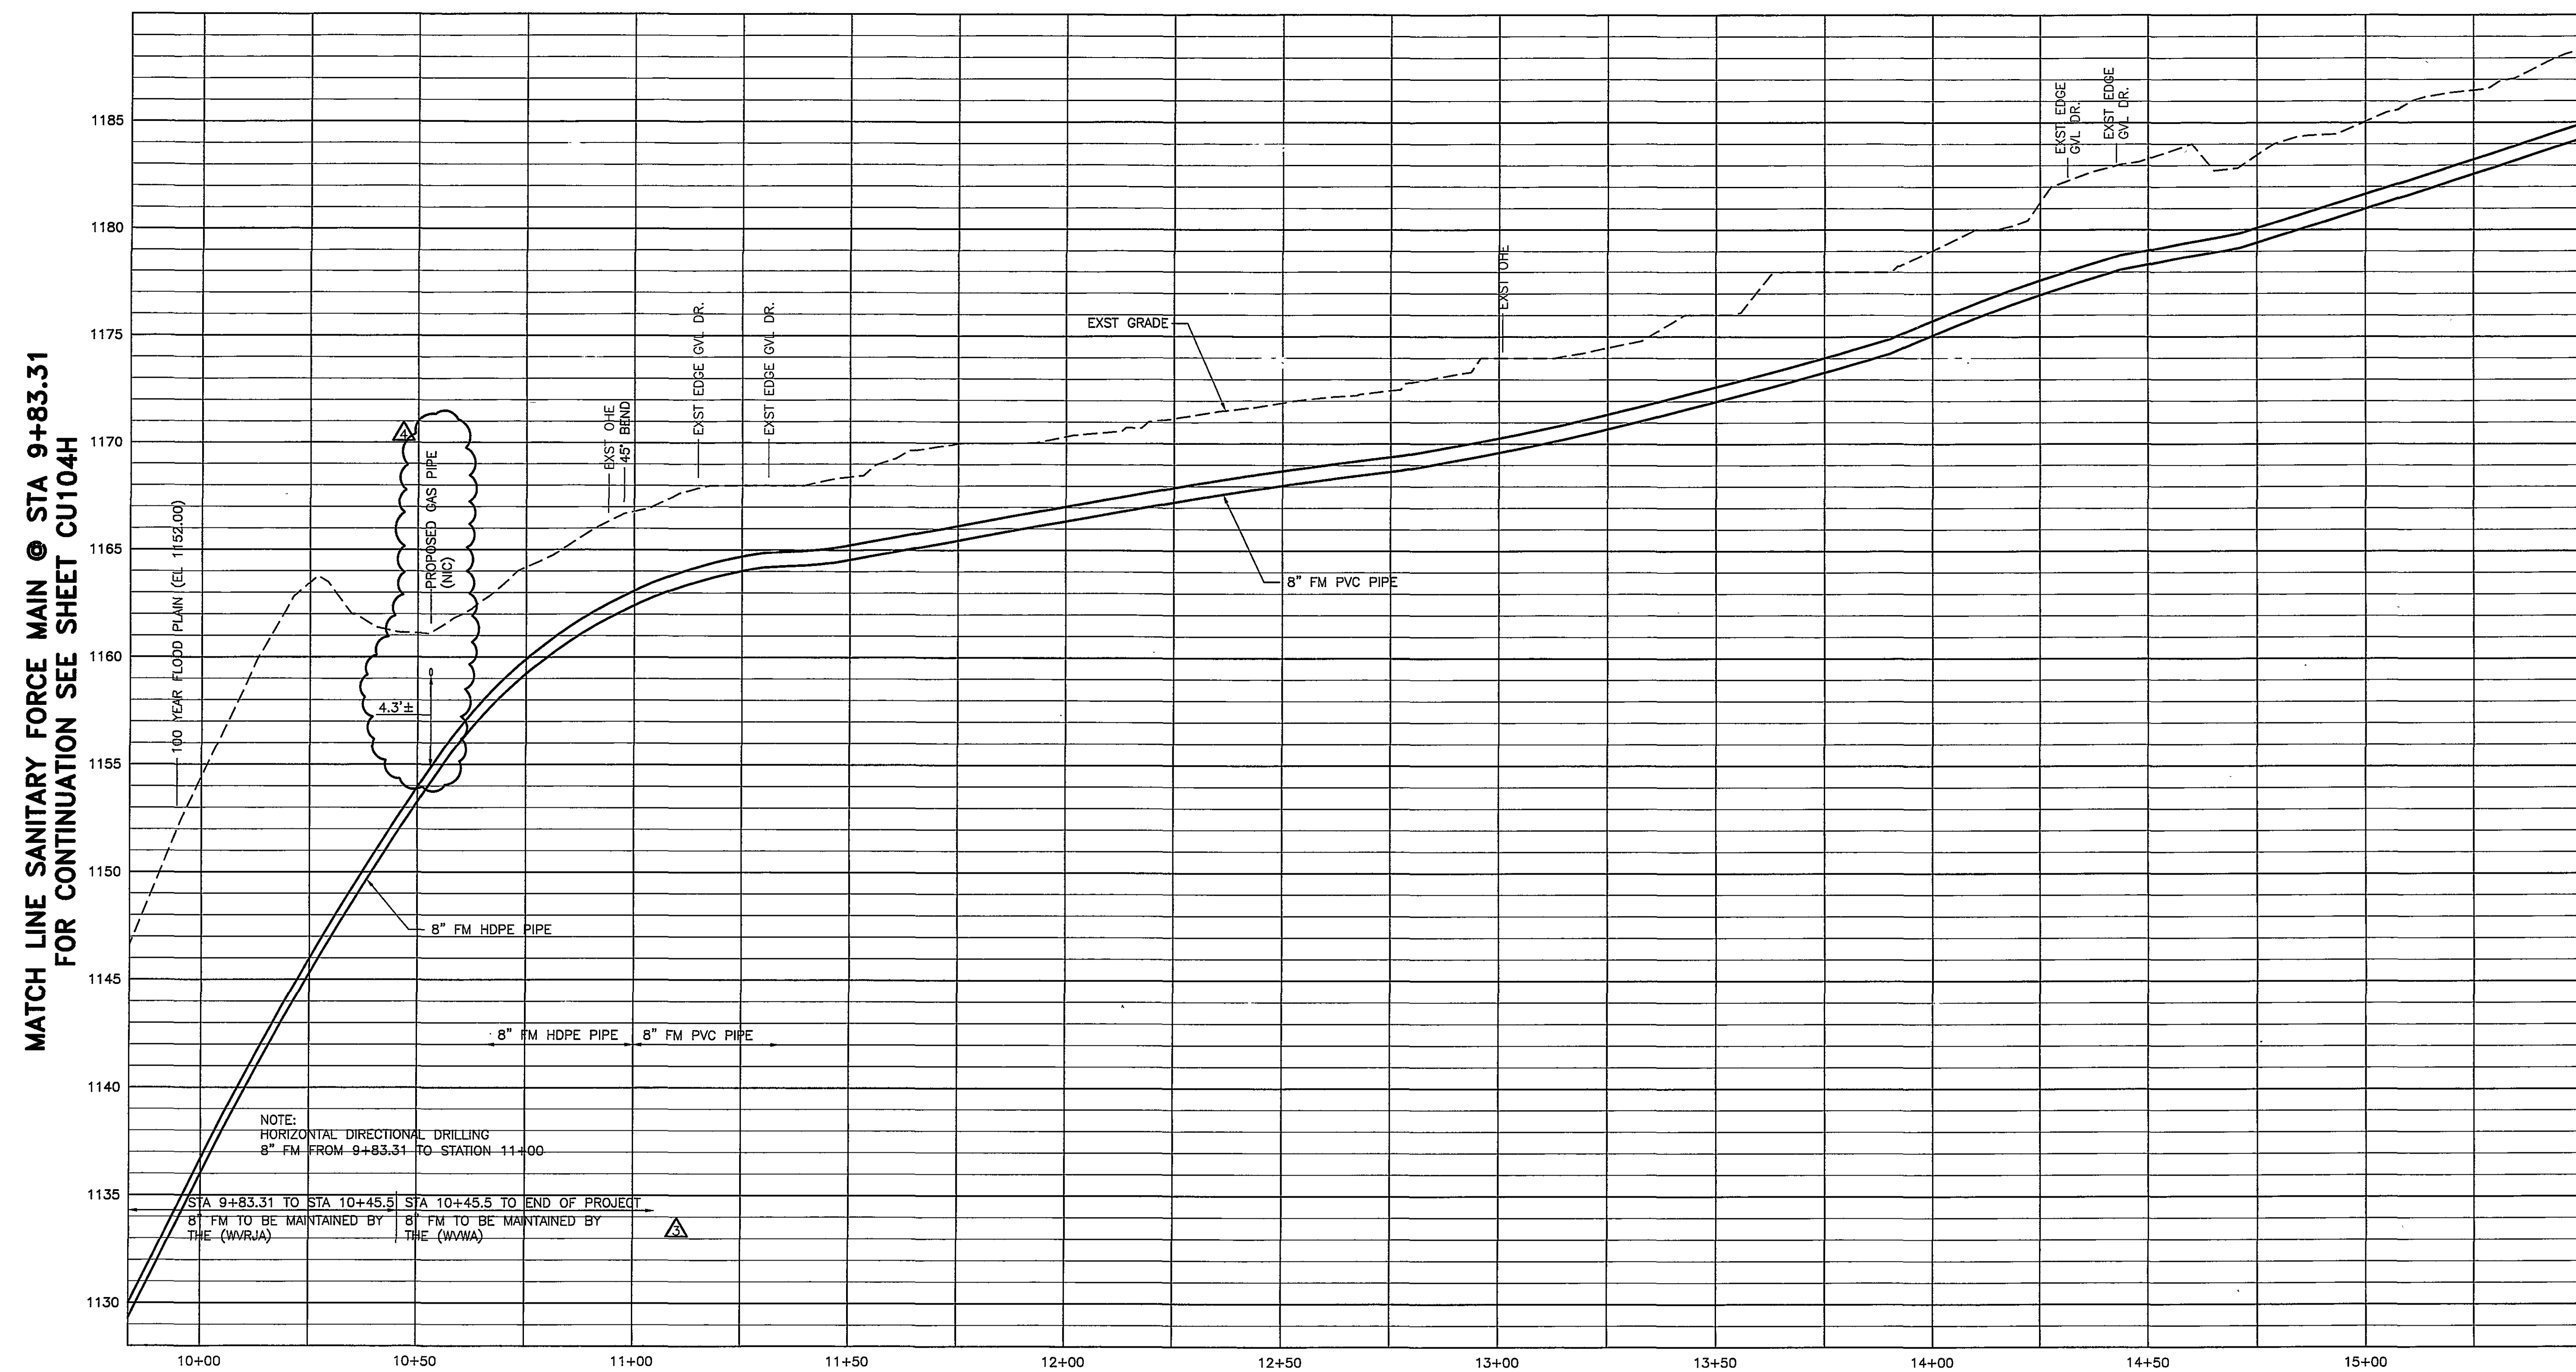


MATCH LINE SANITARY FORCE MAIN @ STA 9+83.31
FOR CONTINUATION SEE SHEET CU104H

MATCH LINE SANITARY FORCE MAIN @ STA 15+50
FOR CONTINUATION SEE SHEET CU104J

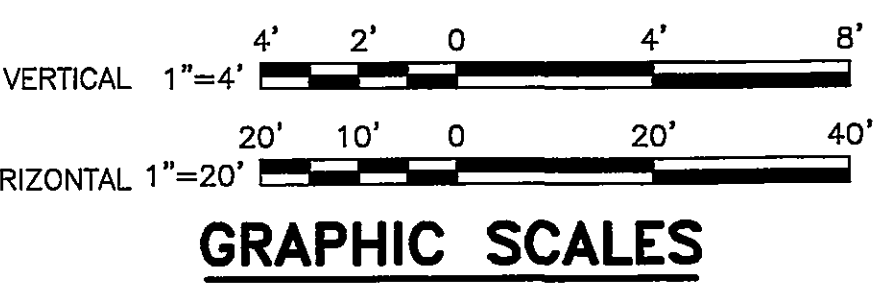

HSM
ARCHITECTS ENGINEERS PLANNERS

HAYES, SEAY, MATTERN & MATTERN, INC.
1315 FRANKLIN ROAD
ROANOKE, VA 24016
(540) 857-3100 WWW.HSM.COM

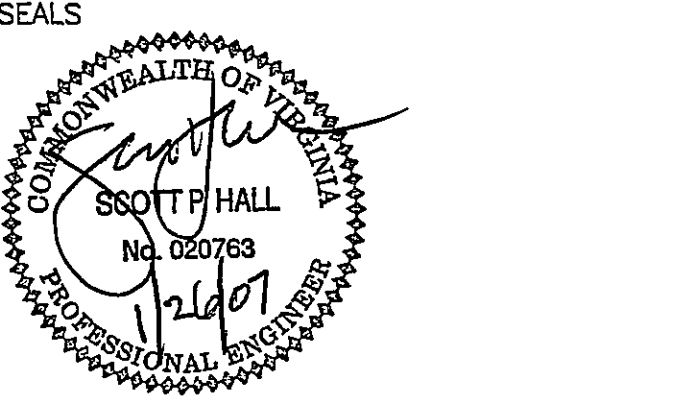

CONSULTANT
THOMPSON & LITTON
P.O. Box 1307
103 East Main Street
Wise, Virginia 24293

Rolf Jensen & Associates, Inc.
Life Safety Consultants
3040 Williams Drive, Suite 400
Fairfax, Virginia 22031

Faassen & Associates, Inc.
Food Service & Laundry Consultant
8526 Sunflower Road
Charlotte, NC 28227

David E. Musacchio & Associates
Security/Detention Consultant
Cookeville, Tennessee

**WESTERN VIRGINIA
REGIONAL JAIL**

WESTERN VIRGINIA
REGIONAL JAIL AUTHORITY
ROANOKE COUNTY, VIRGINIA

REV	DATE	DESCRIPTION	APP
3	10/24/06	ADDENDUM 3	JMC
4	11/14/06	REVIEW COMMENTS	JMC

COMM NO: 10075
ISSUE DATE: FEBRUARY 1, 2007
DESIGNED BY: SPH DRAWN BY: RHH
CHECKED BY: MLC SUBMITTED BY: JMC
© HAYES, SEAY, MATTERN & MATTERN, INC., 2005. ALL RIGHTS RESERVED.

CIVIL

PLAN AND PROFILE
SANITARY FORCE MAIN &
E&S CONTROL

CU104J