


MATCH LINE SANITARY FORCE MAIN @ STA 21+50
FOR CONTINUATION SEE SHEET CU104K

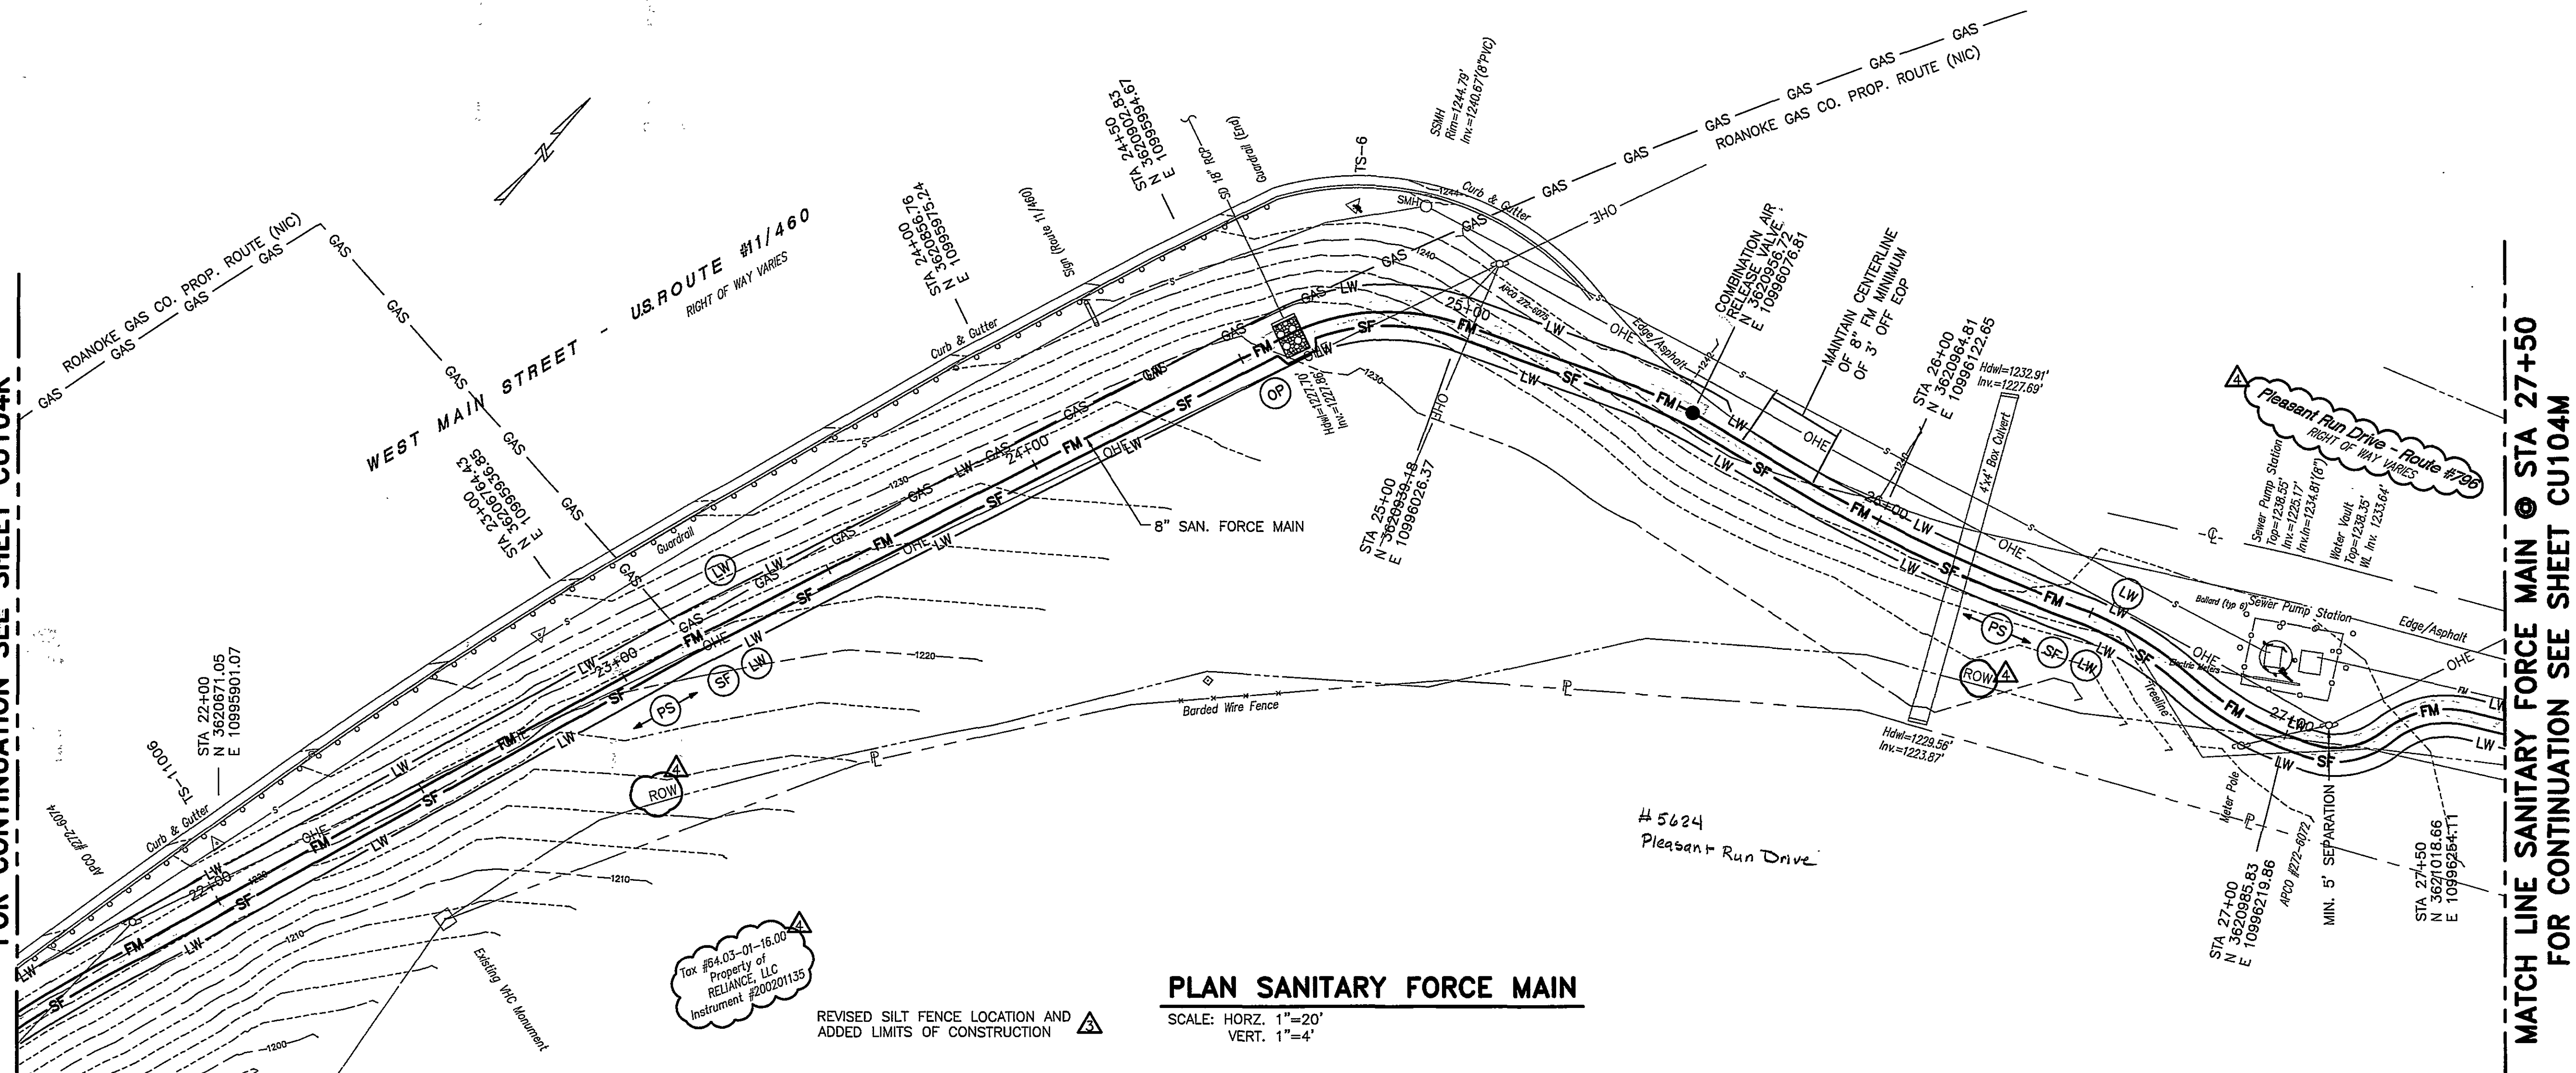


PLAN SANITARY FORCE MAIN
SCALE: HORIZ. 1"=20'
VERT. 1"=4'

MATCH LINE SANITARY FORCE MAIN @ STA 27+50
FOR CONTINUATION SEE SHEET CU104M


- NOTES THIS SHEET:**
1. SEE SHEET C001 FOR SITE/UTILITIES NOTES.
SEE SHEET C002 FOR LEGEND.
 2. SEE SHEET CUI04 FOR SHEET KEY PLAN, OFF SITE UTILITIES.
 3. SEE SHEET C501, C503 FOR UTILITY DETAILS.
 4. SEE SHEET CUI040 FOR HORIZONTAL AND VERTICAL POINT CONTROL REFERENCE DIAGRAM.

MATCH LINE SANITARY FORCE MAIN @ STA 21+50
FOR CONTINUATION SEE SHEET CU104K

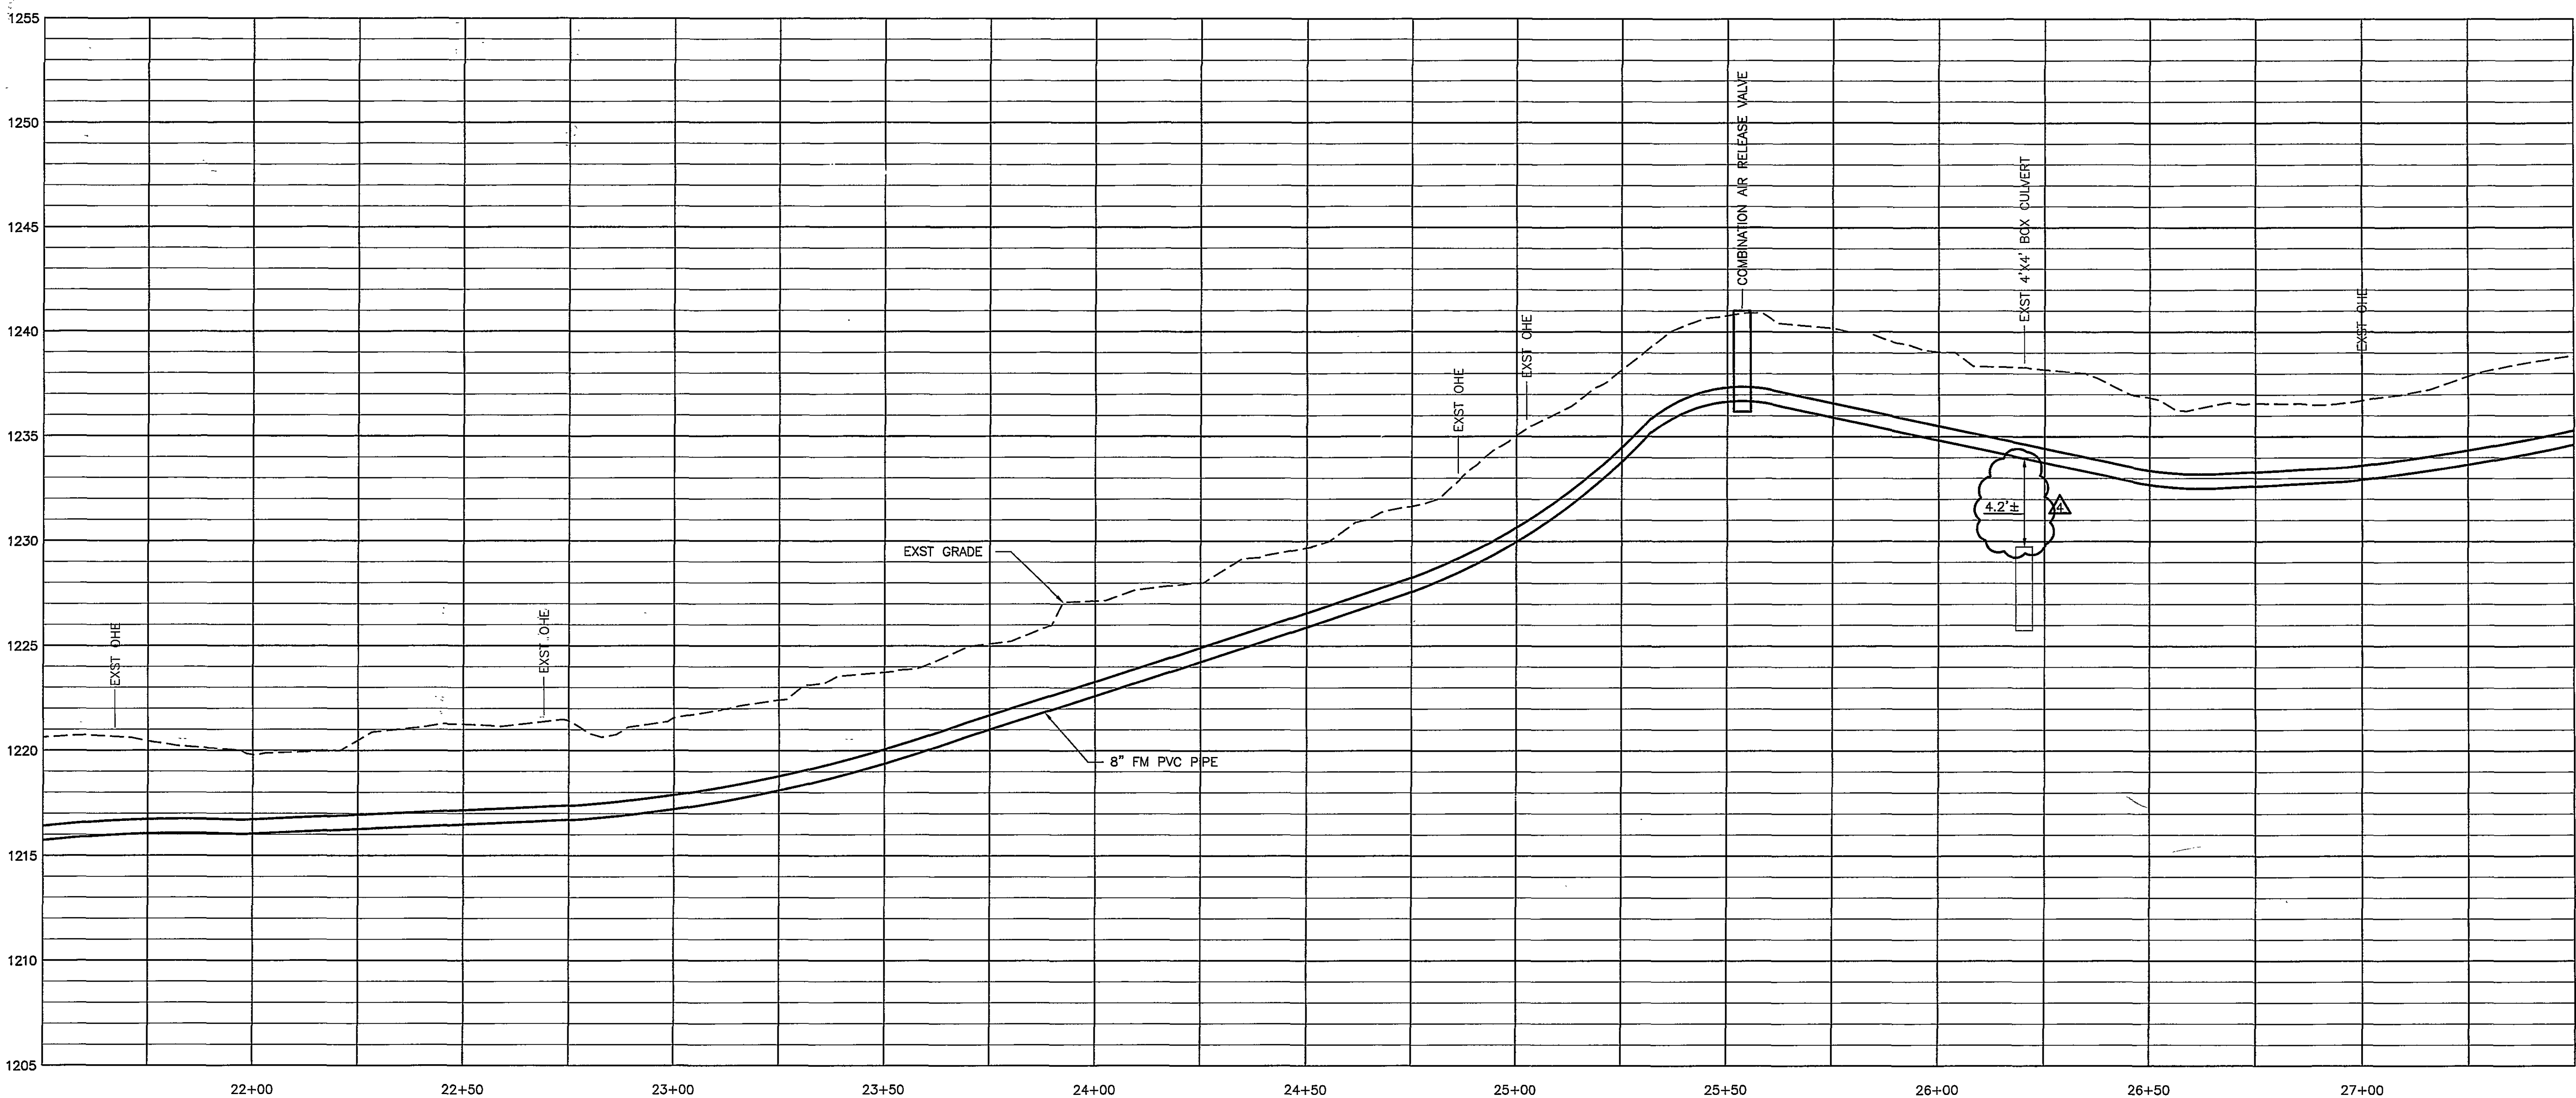


PROFILE SANITARY FORCE MAIN
SCALE: HORIZ. 1"=20'
VERT. 1"=4'

MATCH LINE SANITARY FORCE MAIN @ STA 27+50
FOR CONTINUATION SEE SHEET CU104M

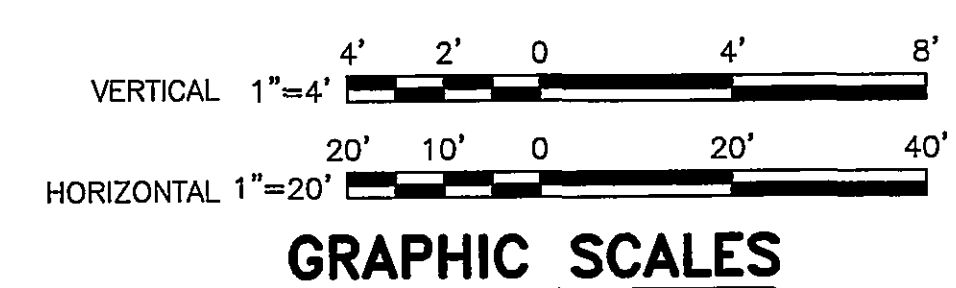

HSMM
ARCHITECTS ENGINEERS PLANNERS

HAYES, SEAY, MATTERN & MATTERN, INC.
1315 FRANKLIN ROAD
ROANOKE, VA 24016
(540) 857-3100 WWW.HSMM.COM

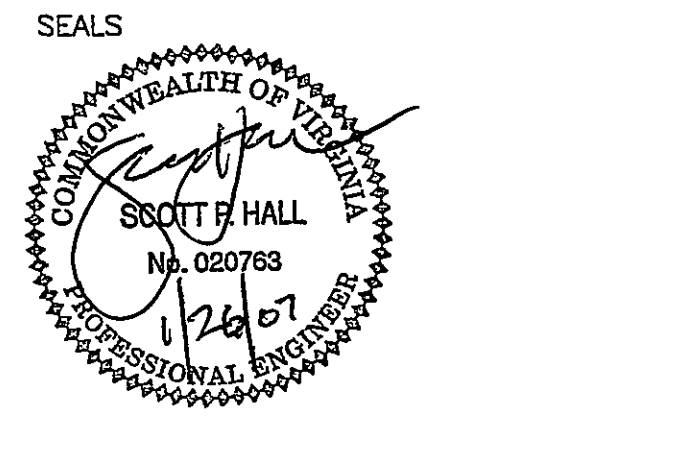

CONSULTANT

THOMPSON & LITTON
P.O. Box 1307
103 East Main Street
Wise, Virginia 24293

Rolf Jensen & Associates, Inc.
Life Safety Consultants
3040 Williams Drive, Suite 400
Fairfax, Virginia 22031

Faassen & Associates, Inc.
Food Service & Laundry Consultant
8526 Sunflower Road
Charlotte, NC 28227

David E. Musacchio & Associates
Security/Detention Consultant
Cookeville, Tennessee

**WESTERN VIRGINIA
REGIONAL JAIL**

**WESTERN VIRGINIA
REGIONAL JAIL AUTHORITY**
ROANOKE COUNTY, VIRGINIA

REV	DATE	DESCRIPTION	APP
3	10/24/06	ADDENDUM 3	JMC
4	11/14/06	REVIEW COMMENTS	JMC

COMM NO: 10075
ISSUE DATE: FEBRUARY 1, 2007
DESIGNED BY: SPH DRAWN BY: REL
CHECKED BY: MLC SUBMITTED BY: JMC
© HAYES, SEAY, MATTERN & MATTERN, INC., 2005. ALL RIGHTS RESERVED.

CIVIL

**PLAN AND PROFILE
SANITARY FORCE MAIN &
E&S CONTROL**

CU104L