



MATCH LINE SANITARY FORCE MAIN @ STA 27+50
FOR CONTINUATION SEE SHEET CU104K

MATCH LINE SANITARY FORCE MAIN @ STA 27+50
FOR CONTINUATION SEE SHEET CU104K

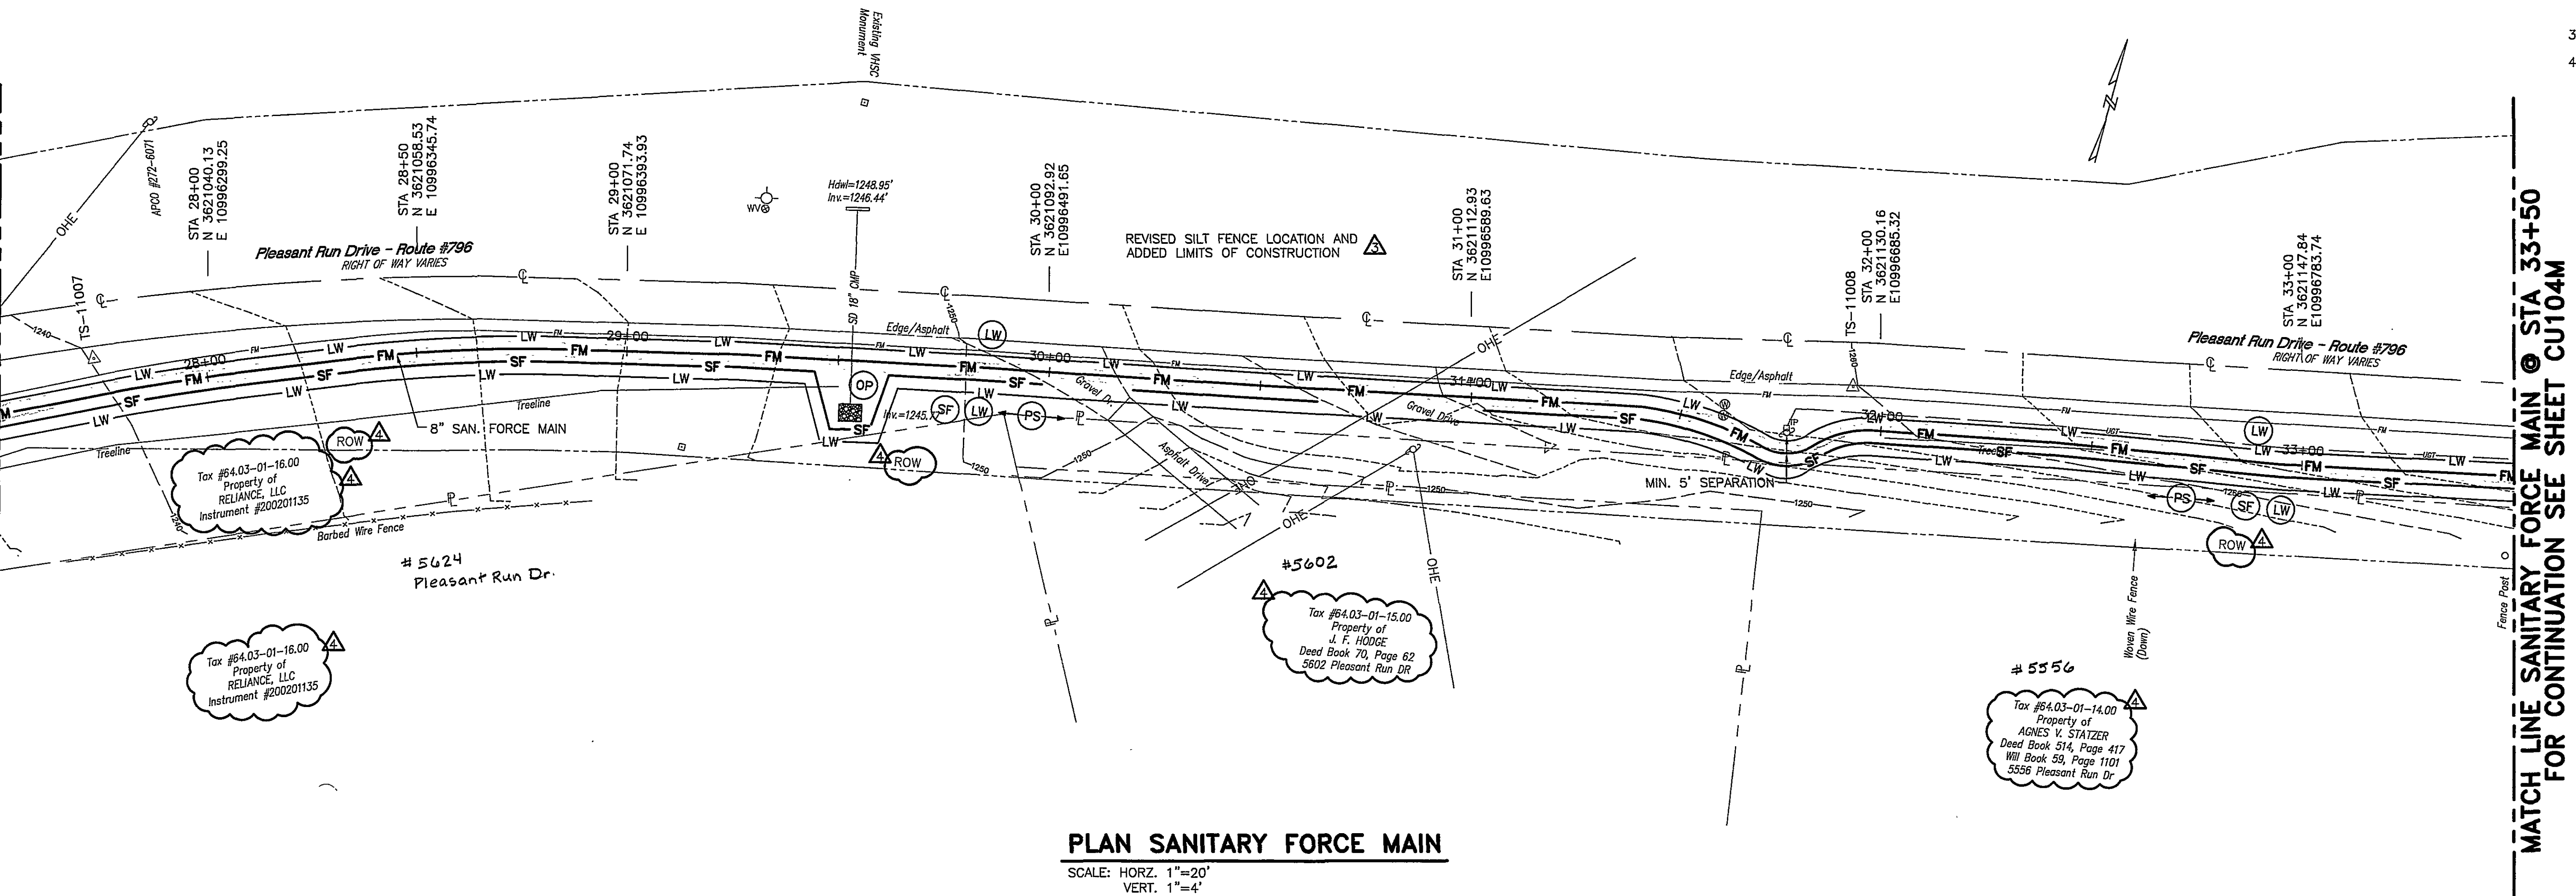

PLAN SANITARY FORCE MAIN

SCALE: HORIZ. 1"=20'
VERT. 1"=4'

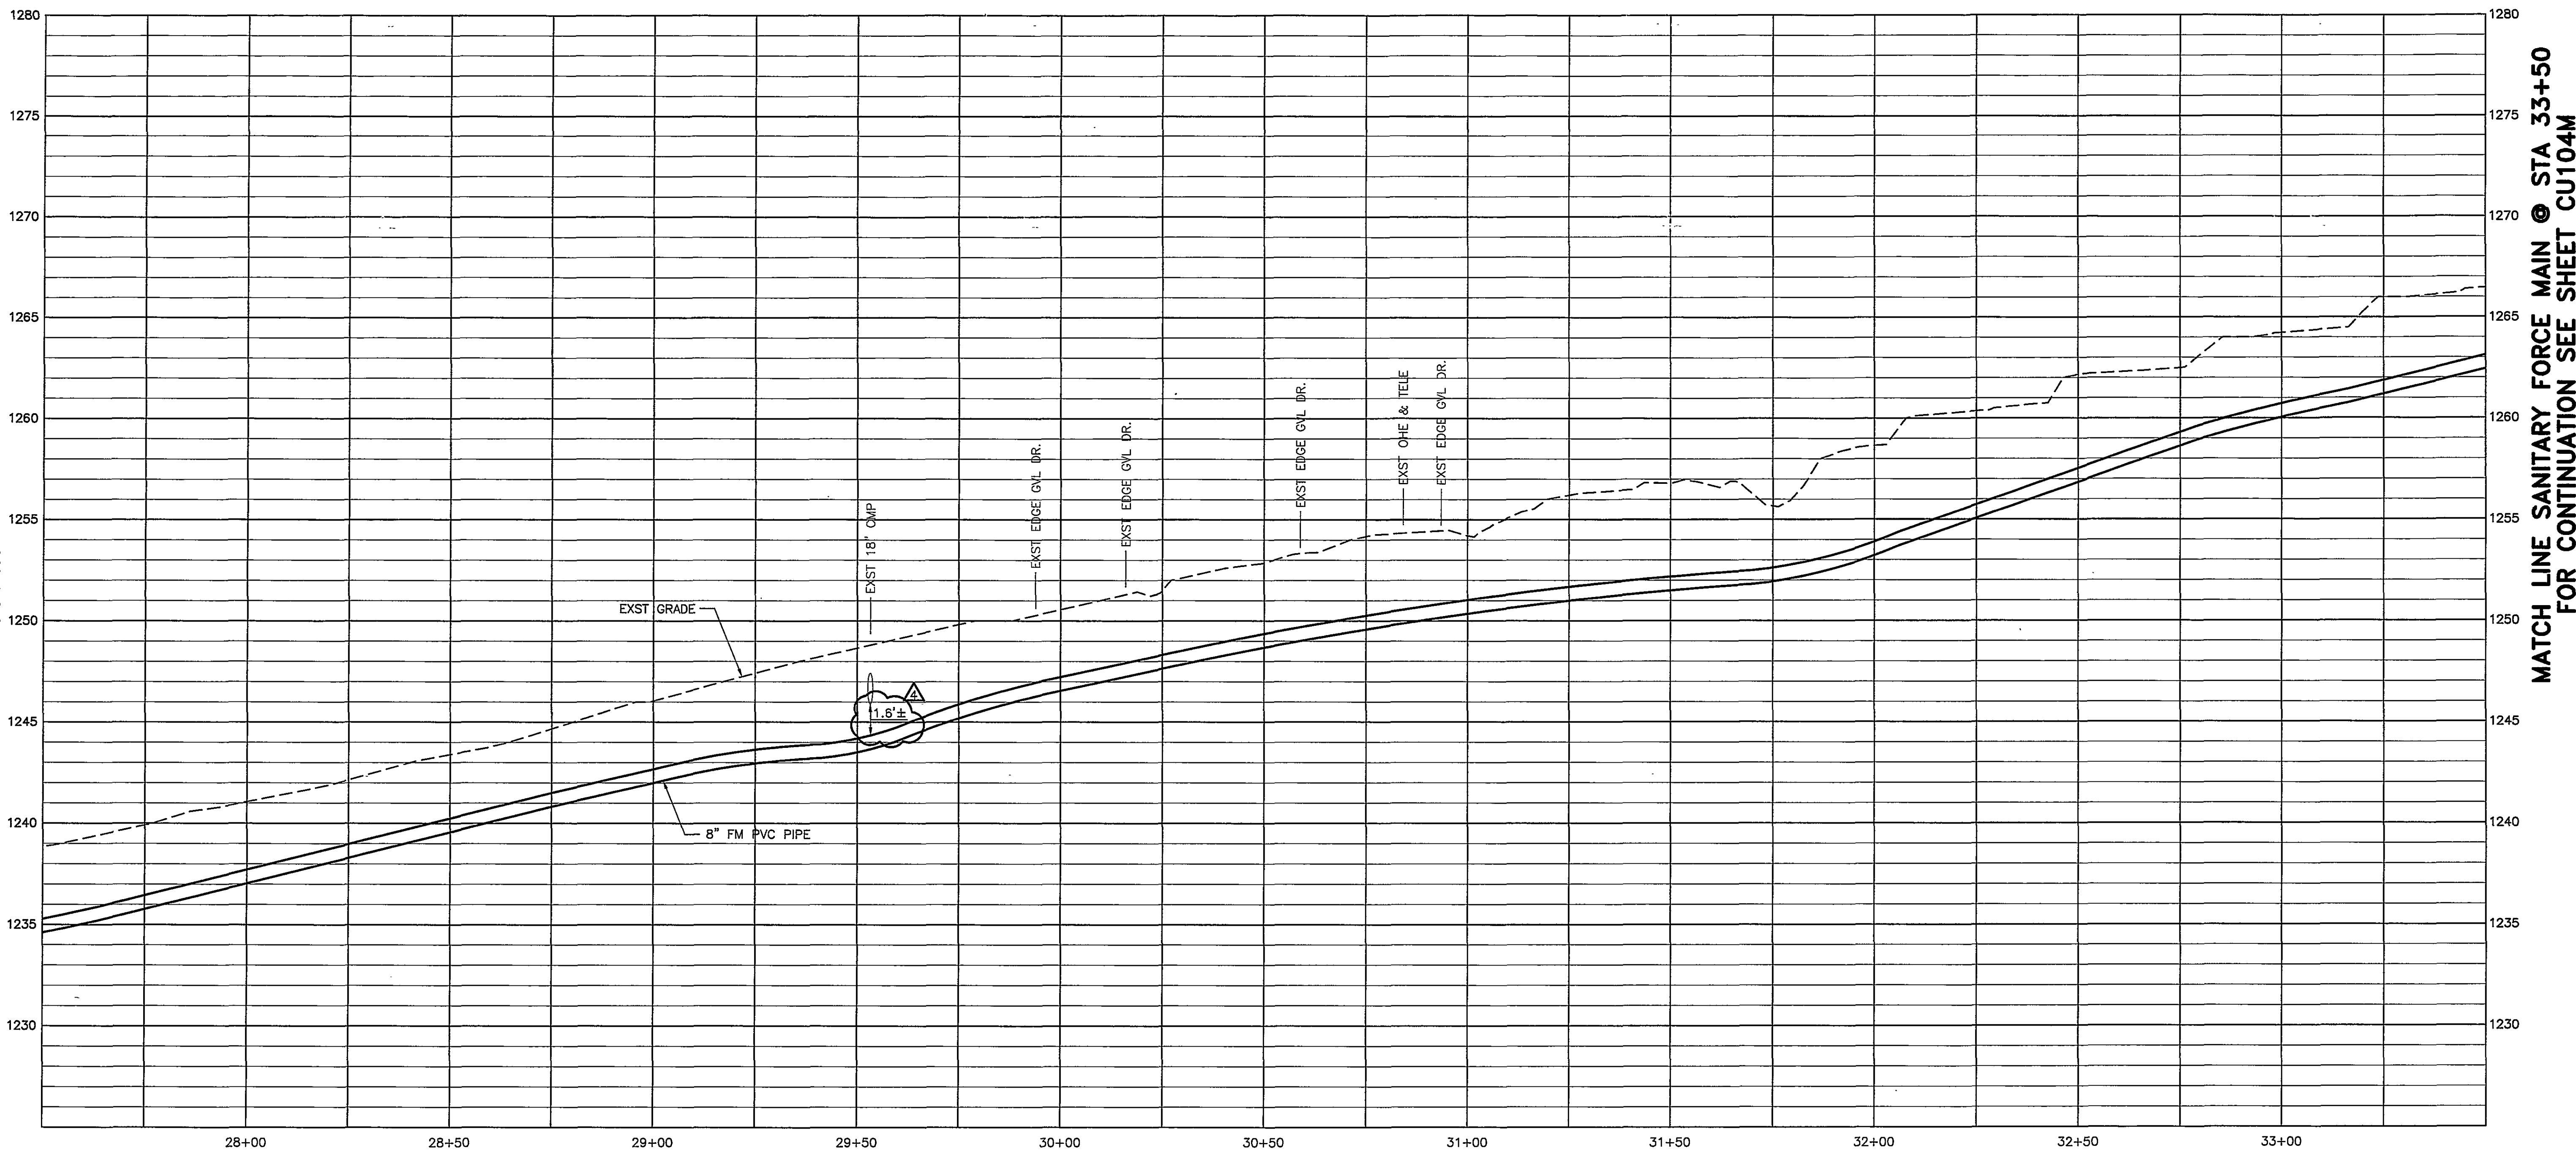

PROFILE SANITARY FORCE MAIN

SCALE: HORIZ. 1"=20'
VERT. 1"=4'

NOTES THIS SHEET:


1. SEE SHEET C001 FOR SITE/UTILITIES NOTES.
SEE SHEET C002 FOR LEGEND.
2. SEE SHEET CUI04 FOR SHEET KEY PLAN, OFF SITE
UTILITIES.
3. SEE SHEET C501, C503 FOR UTILITY DETAILS.
4. SEE SHEET CUI040 FOR HORIZONTAL AND
VERTICAL POINT CONTROL REFERENCE DIAGRAM.

HSM


ARCHITECTS ENGINEERS PLANNERS

HAYES, SEAY, MATTERN & MATTERN, INC.
1315 FRANKLIN ROAD
ROANOKE, VA 24016
(540) 857-3100 WWW.HSM.COM

SEALS

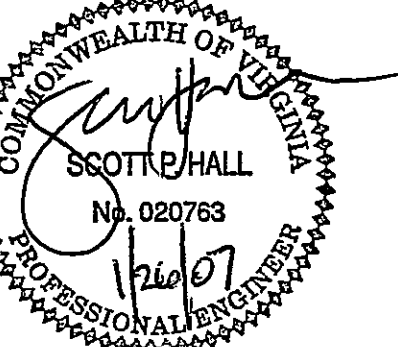

CONSULTANT

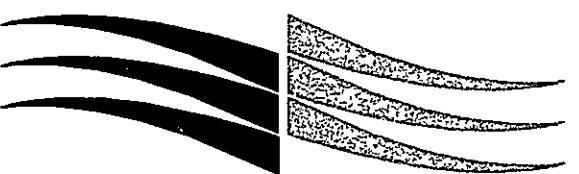

THOMPSON & LITTON

P.O. Box 1307
103 East Main Street
Wise, Virginia 24293

Rolf Jensen & Associates, Inc.

Life Safety Consultants
3040 Williams Drive, Suite 400
Fairfax, Virginia 22031

Faassen & Associates, Inc.

Food Service & Laundry Consultant
8526 Sunflower Road
Charlotte, NC 28227

David E. Musacchio & Associates

Security/Detention Consultant
Cookeville, Tennessee

**WESTERN VIRGINIA
REGIONAL JAIL**

WESTERN VIRGINIA
REGIONAL JAIL AUTHORITY
ROANOKE COUNTY, VIRGINIA


REV	DATE	DESCRIPTION	APP
3	10/24/06	ADDENDUM 3	JMC
4	11/14/06	REVIEW COMMENTS	JMC

COMM NO: 10075
ISSUE DATE: FEBRUARY 1, 2007
DESIGNED BY: SPH DRAWN BY: REH
CHECKED BY: MLC SUBMITTED BY: JMC
© HAYES, SEAY, MATTERN & MATTERN, INC.,
2005. ALL RIGHTS RESERVED.

CIVIL

PLAN AND PROFILE
SANITARY FORCE MAIN &
E&S CONTROL

CU104M

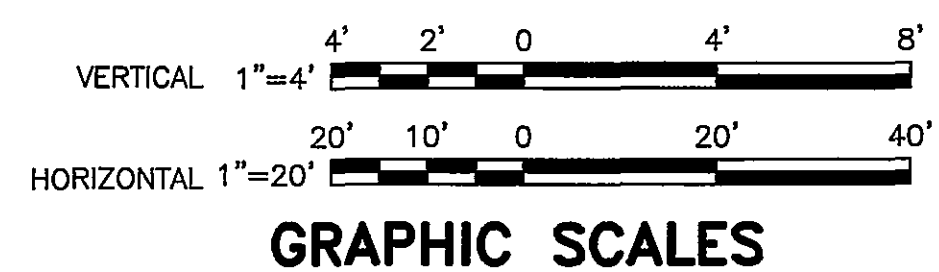

M:\1000SERIES\10075\CADD\DWG\FJ44CUN_0104M.DWG 10075 01/26/2007 09:23:54 MICHAEL RUTLEDGE
HSM-Full.ctb RP: f46_cusp01,f46_cusp02,f46_nubor,NONE