


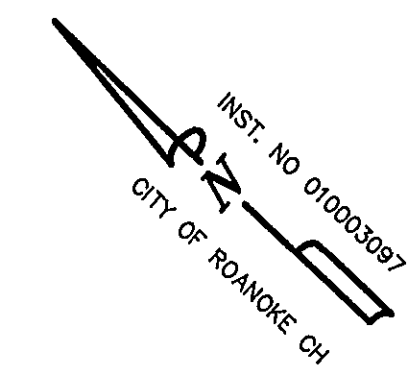

GAY AND NEEL, INC.
CIVIL ENGINEERING
LAND PLANNING
SURVEYING

328 Mountain Avenue S.W.
Roanoke, Virginia 24016
Phone: (540) 345-1110 Fax: (540) 345-5560
Email: info@gayandneel.com

Grading & Utility Plan



Kabuki Expansion
Prepared For
Koeda Akio
City of Roanoke, Virginia

COMMONWEALTH OF VIRGINIA
MICHAEL G. GAY
Lic. No. 17580
12/13/07
PROFESSIONAL ENGINEER

REVISED:
10/19/07
11/02/07

DESIGNED/CALC.: RCM
CHECKED: RCM
DRAWN: PLJ/RWA
SCALE: 1" = 20'
DATE: 07/02/07

JOB NO. 1800.0
SHEET 5 OF 13

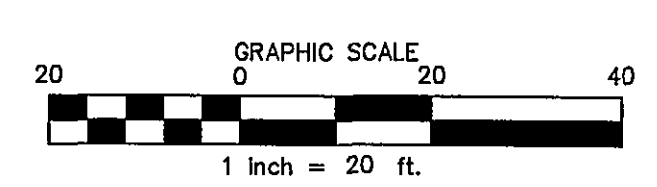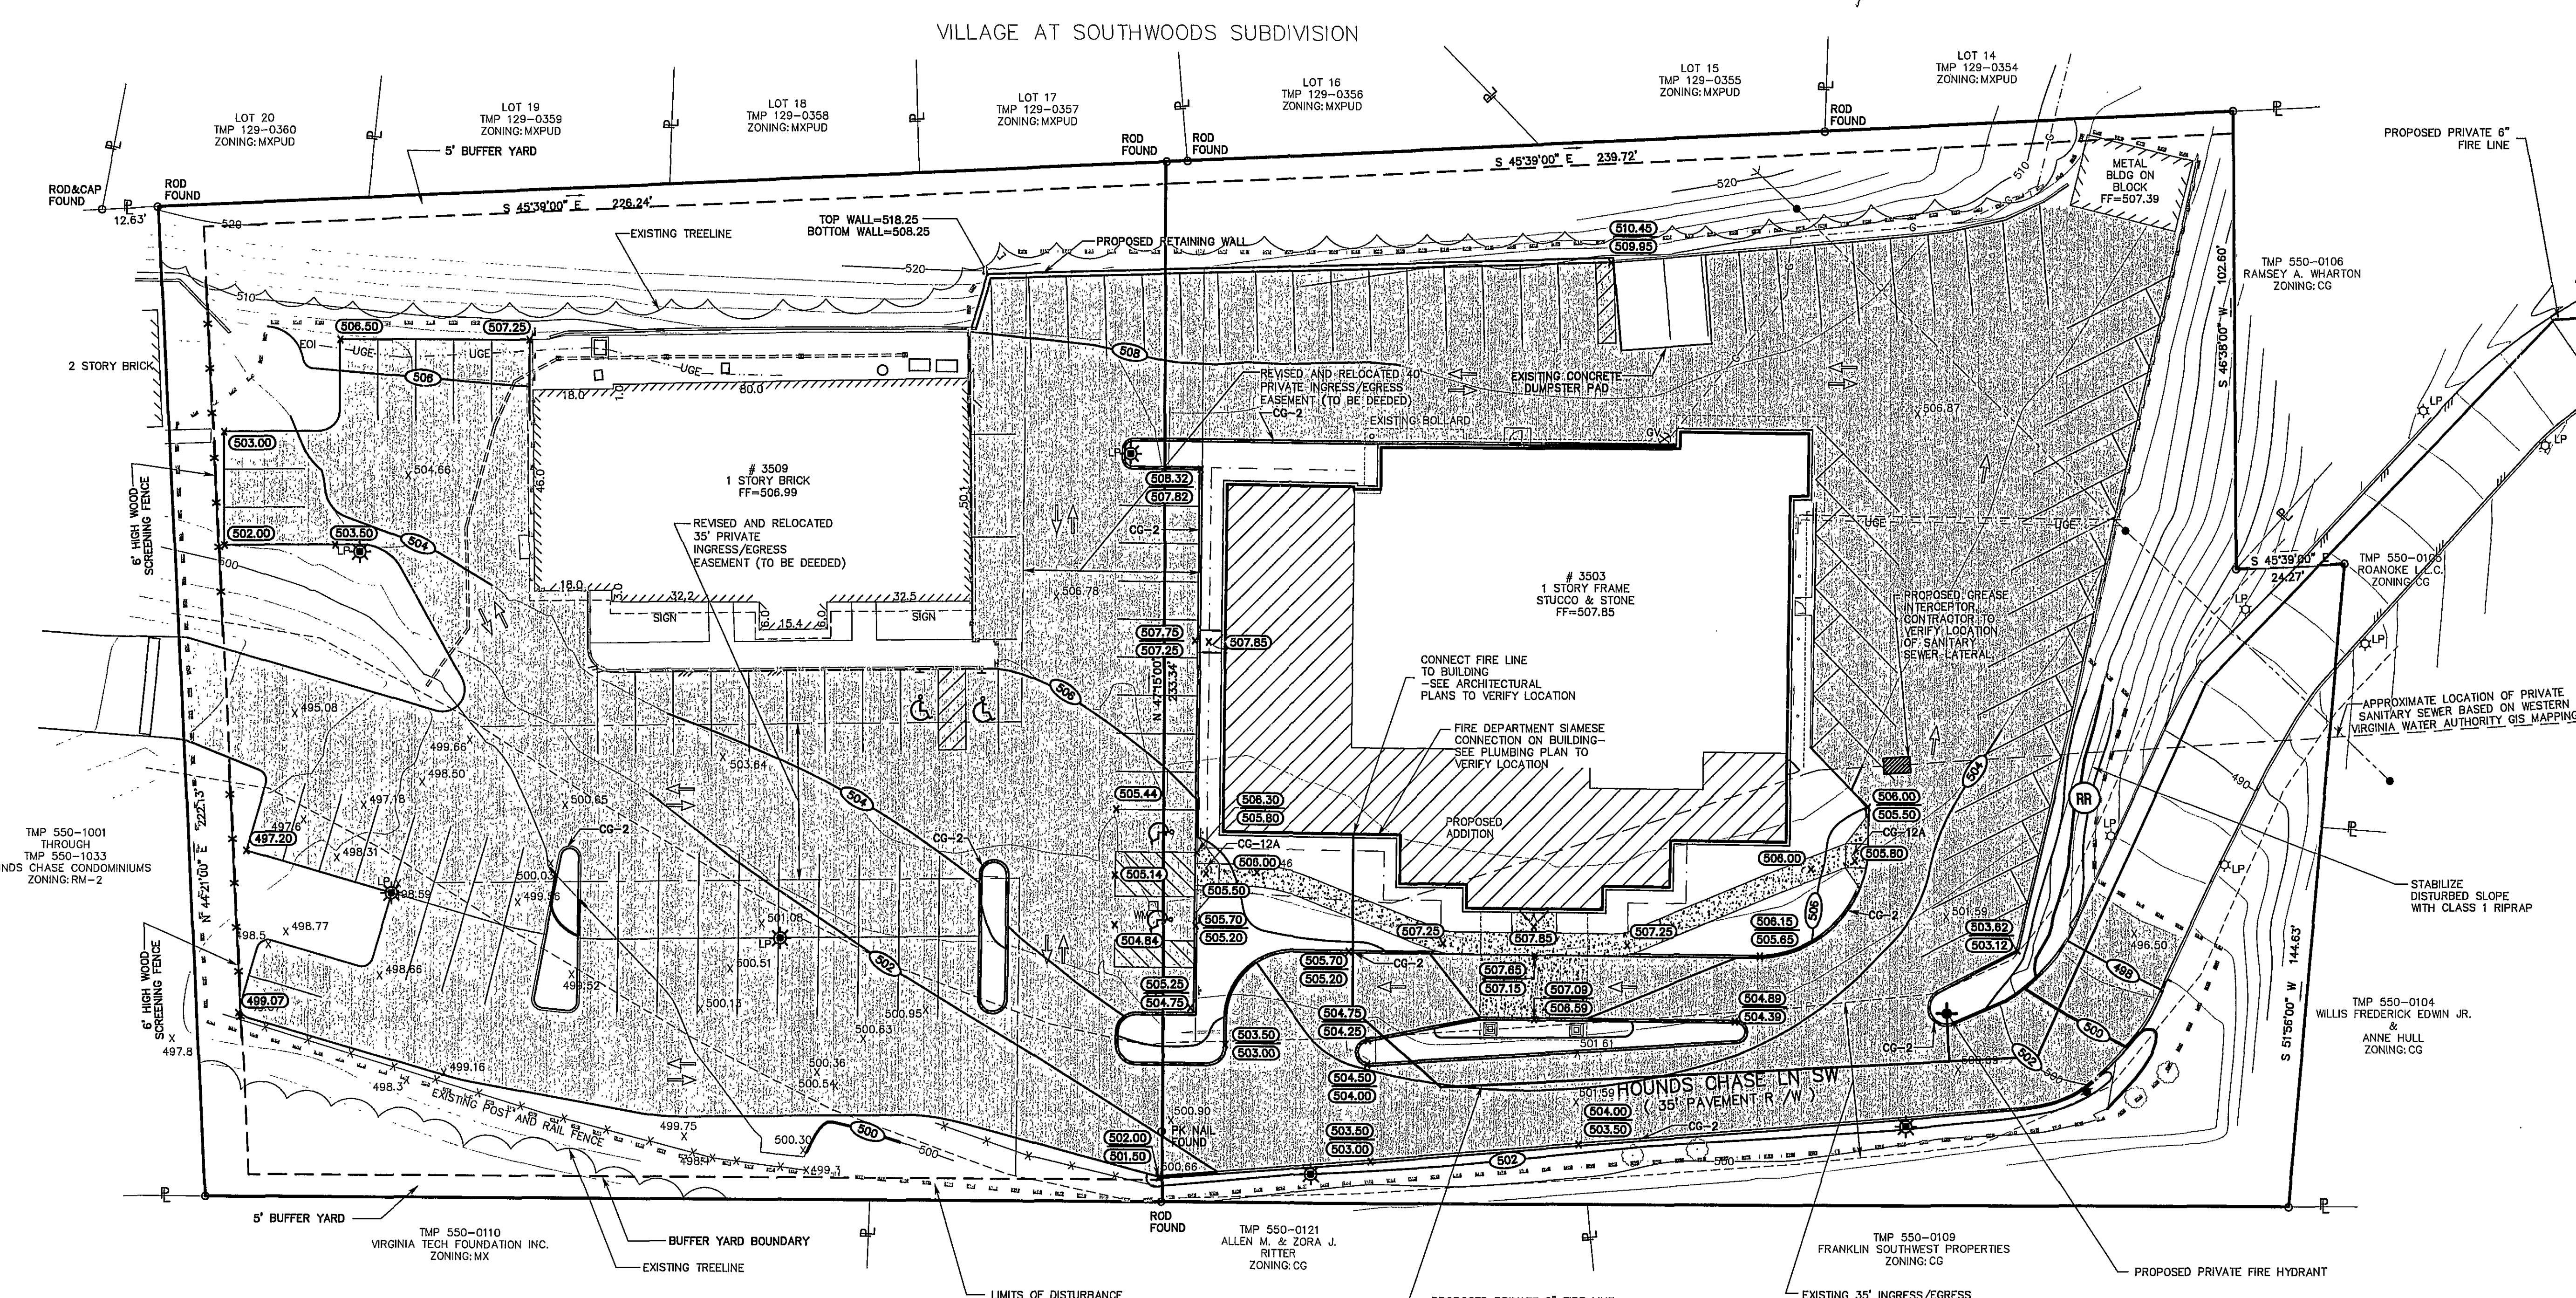

CONTRACTOR WILL LOCATE EXISTING PRIVATE WATER AND SANITARY SEWER LATERALS BOTH HORIZONTALLY AND VERTICALLY AND RELOCATE AS NECESSARY FOR THE PROPOSED BUILDING ADDITION TO MAINTAIN SERVICE TO BOTH BUILDINGS.