



| PLANTING SCHEDULE:   |                           |                            |          |            |                |                   |
|----------------------|---------------------------|----------------------------|----------|------------|----------------|-------------------|
| SYMBOL               | COMMON NAME               | BOTANICAL NAME             | QUANTITY | SIZE       | 20 YEAR CANOPY | CANOPY AREA       |
| BS                   | COLORADO BLUE SPRUCE      | PICEA PUNGENS              | 20       | 5' HEIGHT  | 113            | 2,260 S.F.        |
| RM                   | RED MAPLE                 | ACER RUBRUM                | 15       | 2" CALIPER | 314            | 4,710 S.F.        |
| JM                   | JAPANESE MAPLE            | ACER PALMATUM              | 2        | 5' HEIGHT  | 177            | 354 S.F.          |
| KC                   | CHERRY, KWANZAN FLOWERING | PRUNUS SERRULATA "KWANZAN" | 4        | 2" CALIPER | 177            | 708 S.F.          |
| TOTAL PROPOSED       |                           |                            | 65       |            |                | 8,032 S.F.        |
| EXISTING TREE CANOPY |                           |                            |          |            |                | 14,000 S.F.       |
| TOTAL TREE CANOPY    |                           |                            |          |            |                | 22,032 S.F. (20%) |

#### LANDSCAPING REQUIREMENTS:

TOTAL SITE AREA: 110,304 S.F. (2.53 AC.)  
 TOTAL PROJECT/PARCEL AREA: 110,304 S.F. (2.53 AC.)  
 TREE CANOPY REQUIRED FOR SITE: 10% OF TOTAL SITE (11,030 S.F.)  
 PROPOSED TREE CANOPY: 22,032 S.F. (20%)  
 PROPOSED PARKING AREA: 45,791 S.F. (1.05 AC.)  
 PARKING AREA TREE CANOPY REQUIRED: 10% OF PARKING AREA (4,580 S.F.)  
 PROPOSED PARKING TREE CANOPY: 5,418 S.F. (12%)

#### LUMINAIRE SCHEDULE


| Symbol | Qty | Catalog Number | Description | Lamp                     |
|--------|-----|----------------|-------------|--------------------------|
| ☼      | 6   | G400MH00LFFXXX | MONGOOSE    | 400W CLEAR FLAT GLASS MH |

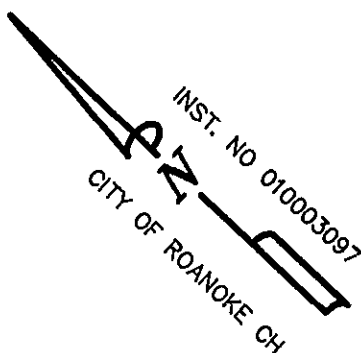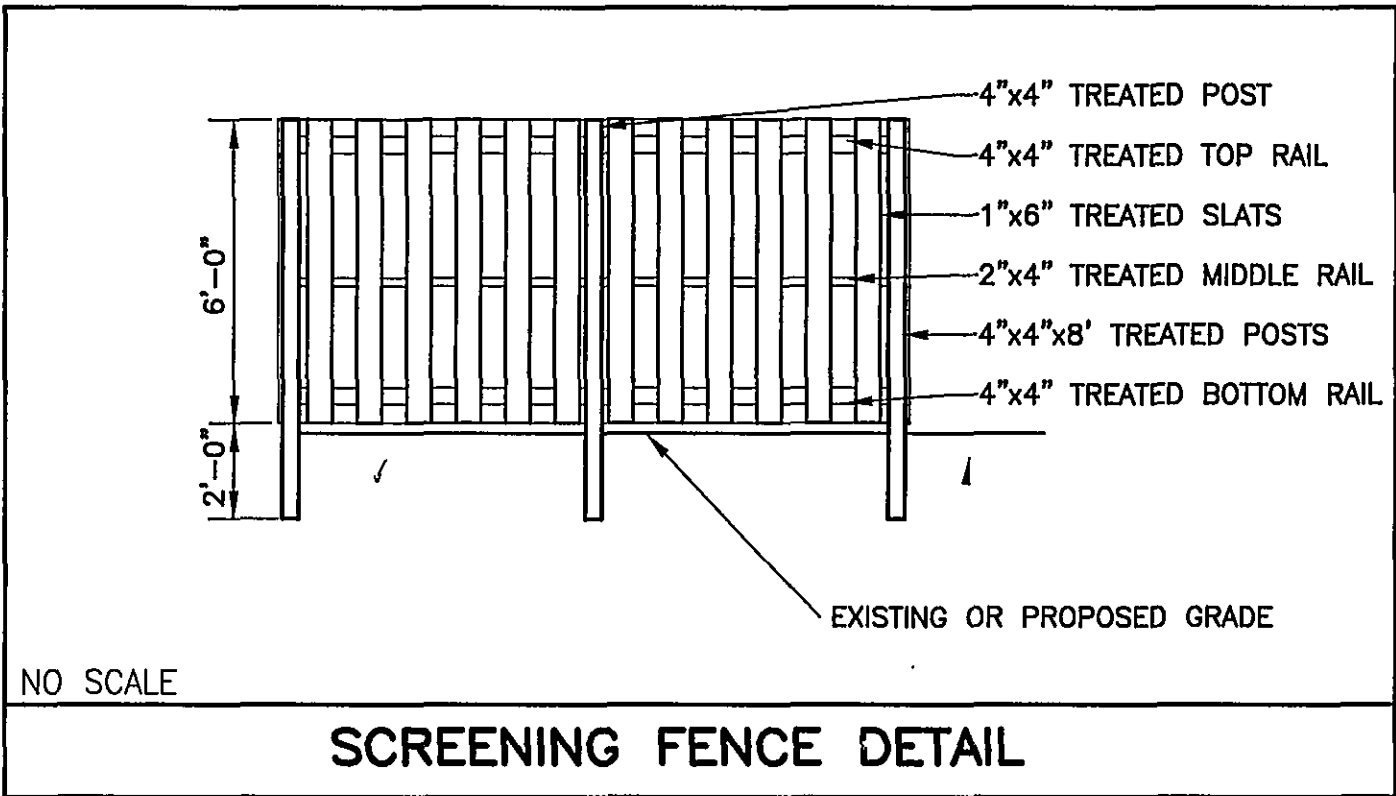

**GAY AND NEEL, INC.**  
 CIVIL ENGINEERING  
 LAND PLANNING  
 SURVEYING  
 328 Mountain Avenue S.W.  
 Roanoke, Virginia 24016  
 Phone: (540) 345-1110 Fax: (540) 345-5560  
 Email: info@gayandneel.com

**Parking, Landscaping, & Lighting Plan**

**Kabuki Expansion Prepared For Koeda Akio**  
 City of Roanoke, Virginia

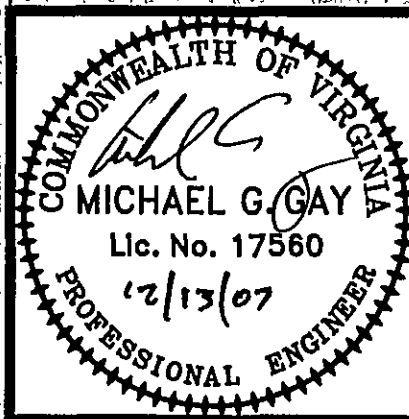


REVISED:  
 10/19/07  
 11/02/07

DESIGNED/CALC.: RCM  
 CHECKED: RCM  
 DRAWN: PLJ/RWA  
 SCALE: 1" = 20'  
 DATE: 07/02/07

JOB NO. 1800.0

SHEET 8 OF 13

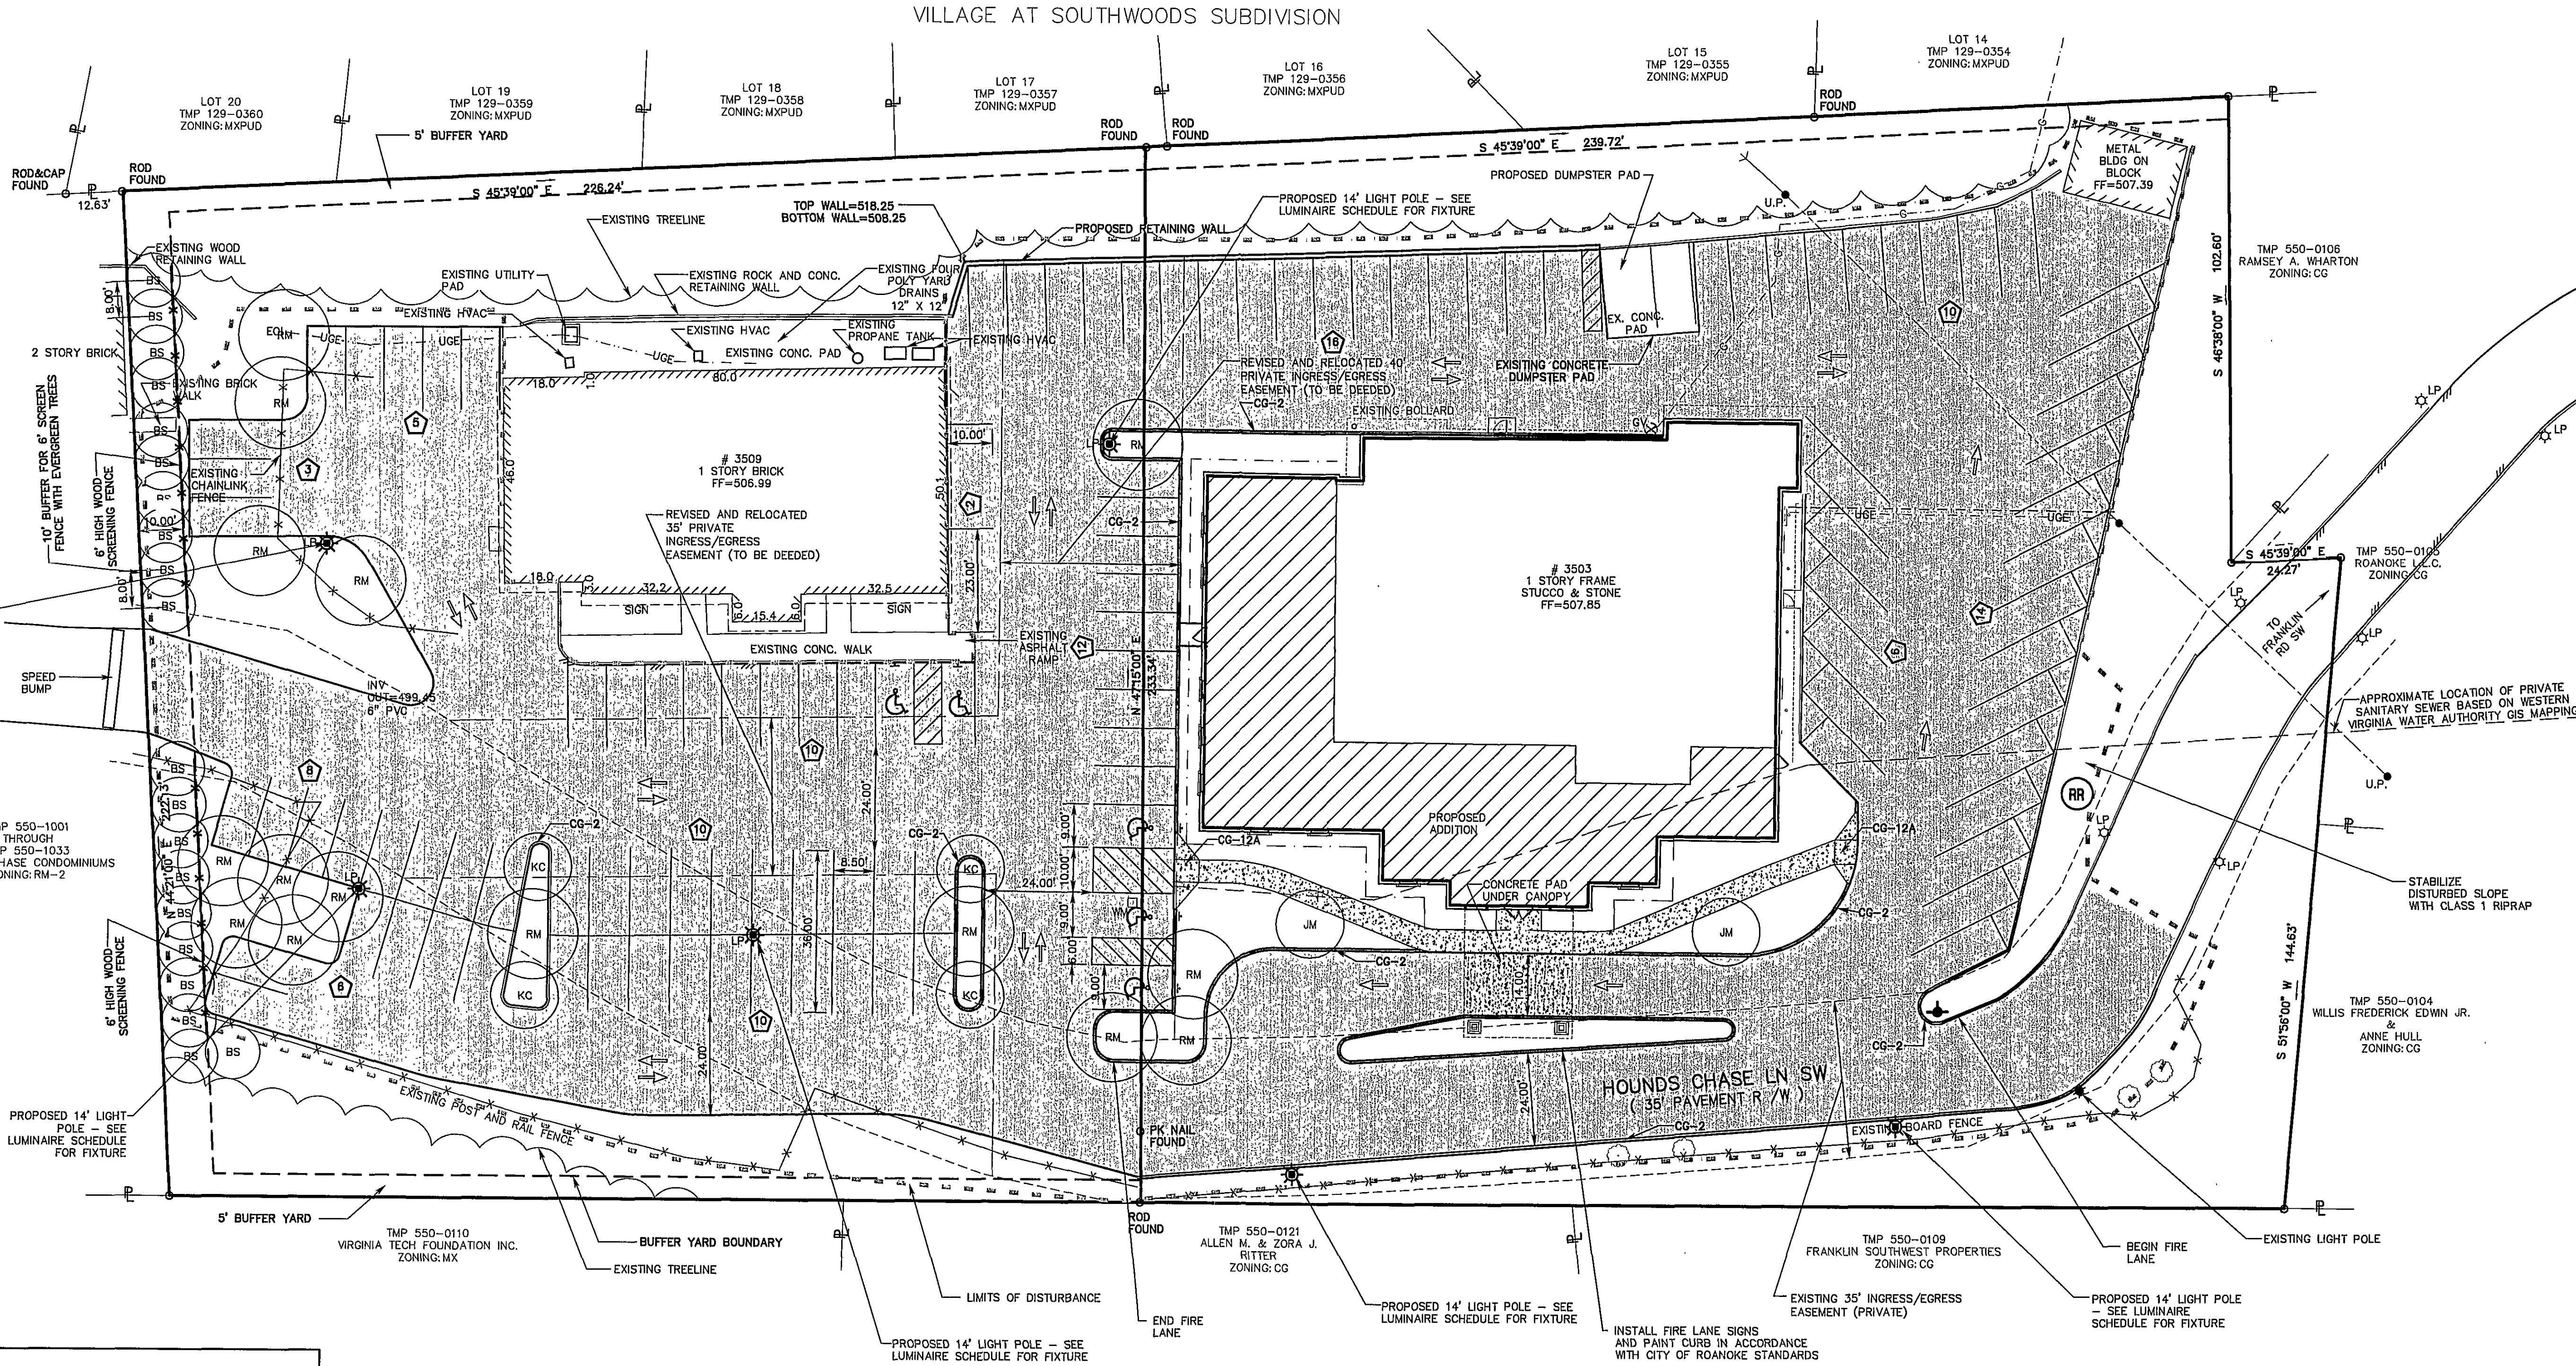

#### PARKING REQUIREMENTS:

1. PROPOSED TOTAL SEATING AREA: 6100 S.F.  
 MINIMUM REQUIRED PARKING: 102 SPACES (1 SPACE PER 60 S.F. SEATING AREA)  
 PROPOSED AVAILABLE PARKING SPACES SHOWN: 112 SPACES
2. H.C. PARKING REQUIREMENTS  
 REQUIRED H.C. PARKING: 5 SPACES (101-150 SPACES = 5 H.C. SPACES)  
 H.C. SPACES SHOWN: 5 SPACES

