

MATCH LINE - SEE SHEET NO. 2

12" GAS LINE - SEE SPECIAL REQUIREMENTS IN SPECIFICATIONS

MATCH LINE - SEE SHEET NO. 2




BM #3
CHISELED "O" ON NE CORNER
CONCRETE CURB AT TRAFFIC
LIGHT POLE CORNER AND
WALKER AVENUE
EL 918.08

BM #2

CHISELED "O" ON NE CORNER
CONCRETE CURB AT TRAFFIC
LIGHT POLE CORNER AND
WALKER AVENUE
EL 940.28

NOTES:
1. STRIPES TO BE 6" WIDE AND
ALTERNATELY BLACK AND
FEDERAL YELLOW ALL
DOWN THE LENGTH OF THE
POSTS. THE YELLOW STRIPES
TO BE PAINTED YELLOW
TWO 4" RED REFLECTOR
BUTTONS TO BE ATTACHED
TO EACH POST

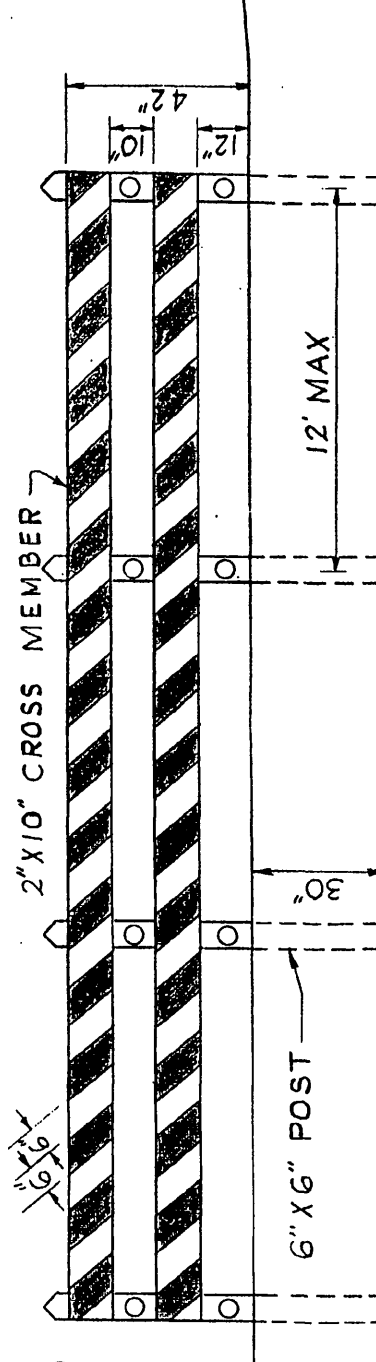

SEMI-PERMANENT BARRICADE

NO SCALE

STREET NO 6 - RUTHERFORD AVE, NE

REVISION	DATE	DESCRIPTION	BY	APP.
DESIGNED	11/15/71	KIMBALL RENEAL PROJECT - CONTRACT SI-1 CITY OF ROANOKE REDEVELOPMENT AND HOUSING AUTHORITY ROANOKE, VIRGINIA		
DRAWN	11/15/71			
CHECKED	11/15/71			
APPROVED	11/15/71			
SUBMITTED	11/15/71	GRADING PLAN		
HAYES, SEAY, MATTERN & MATTERN		ARCHITECTS - ENGINEERS	SCALE 1"=50'	
			DATE DEC 1971	
			SHEET 3 OF 3	