



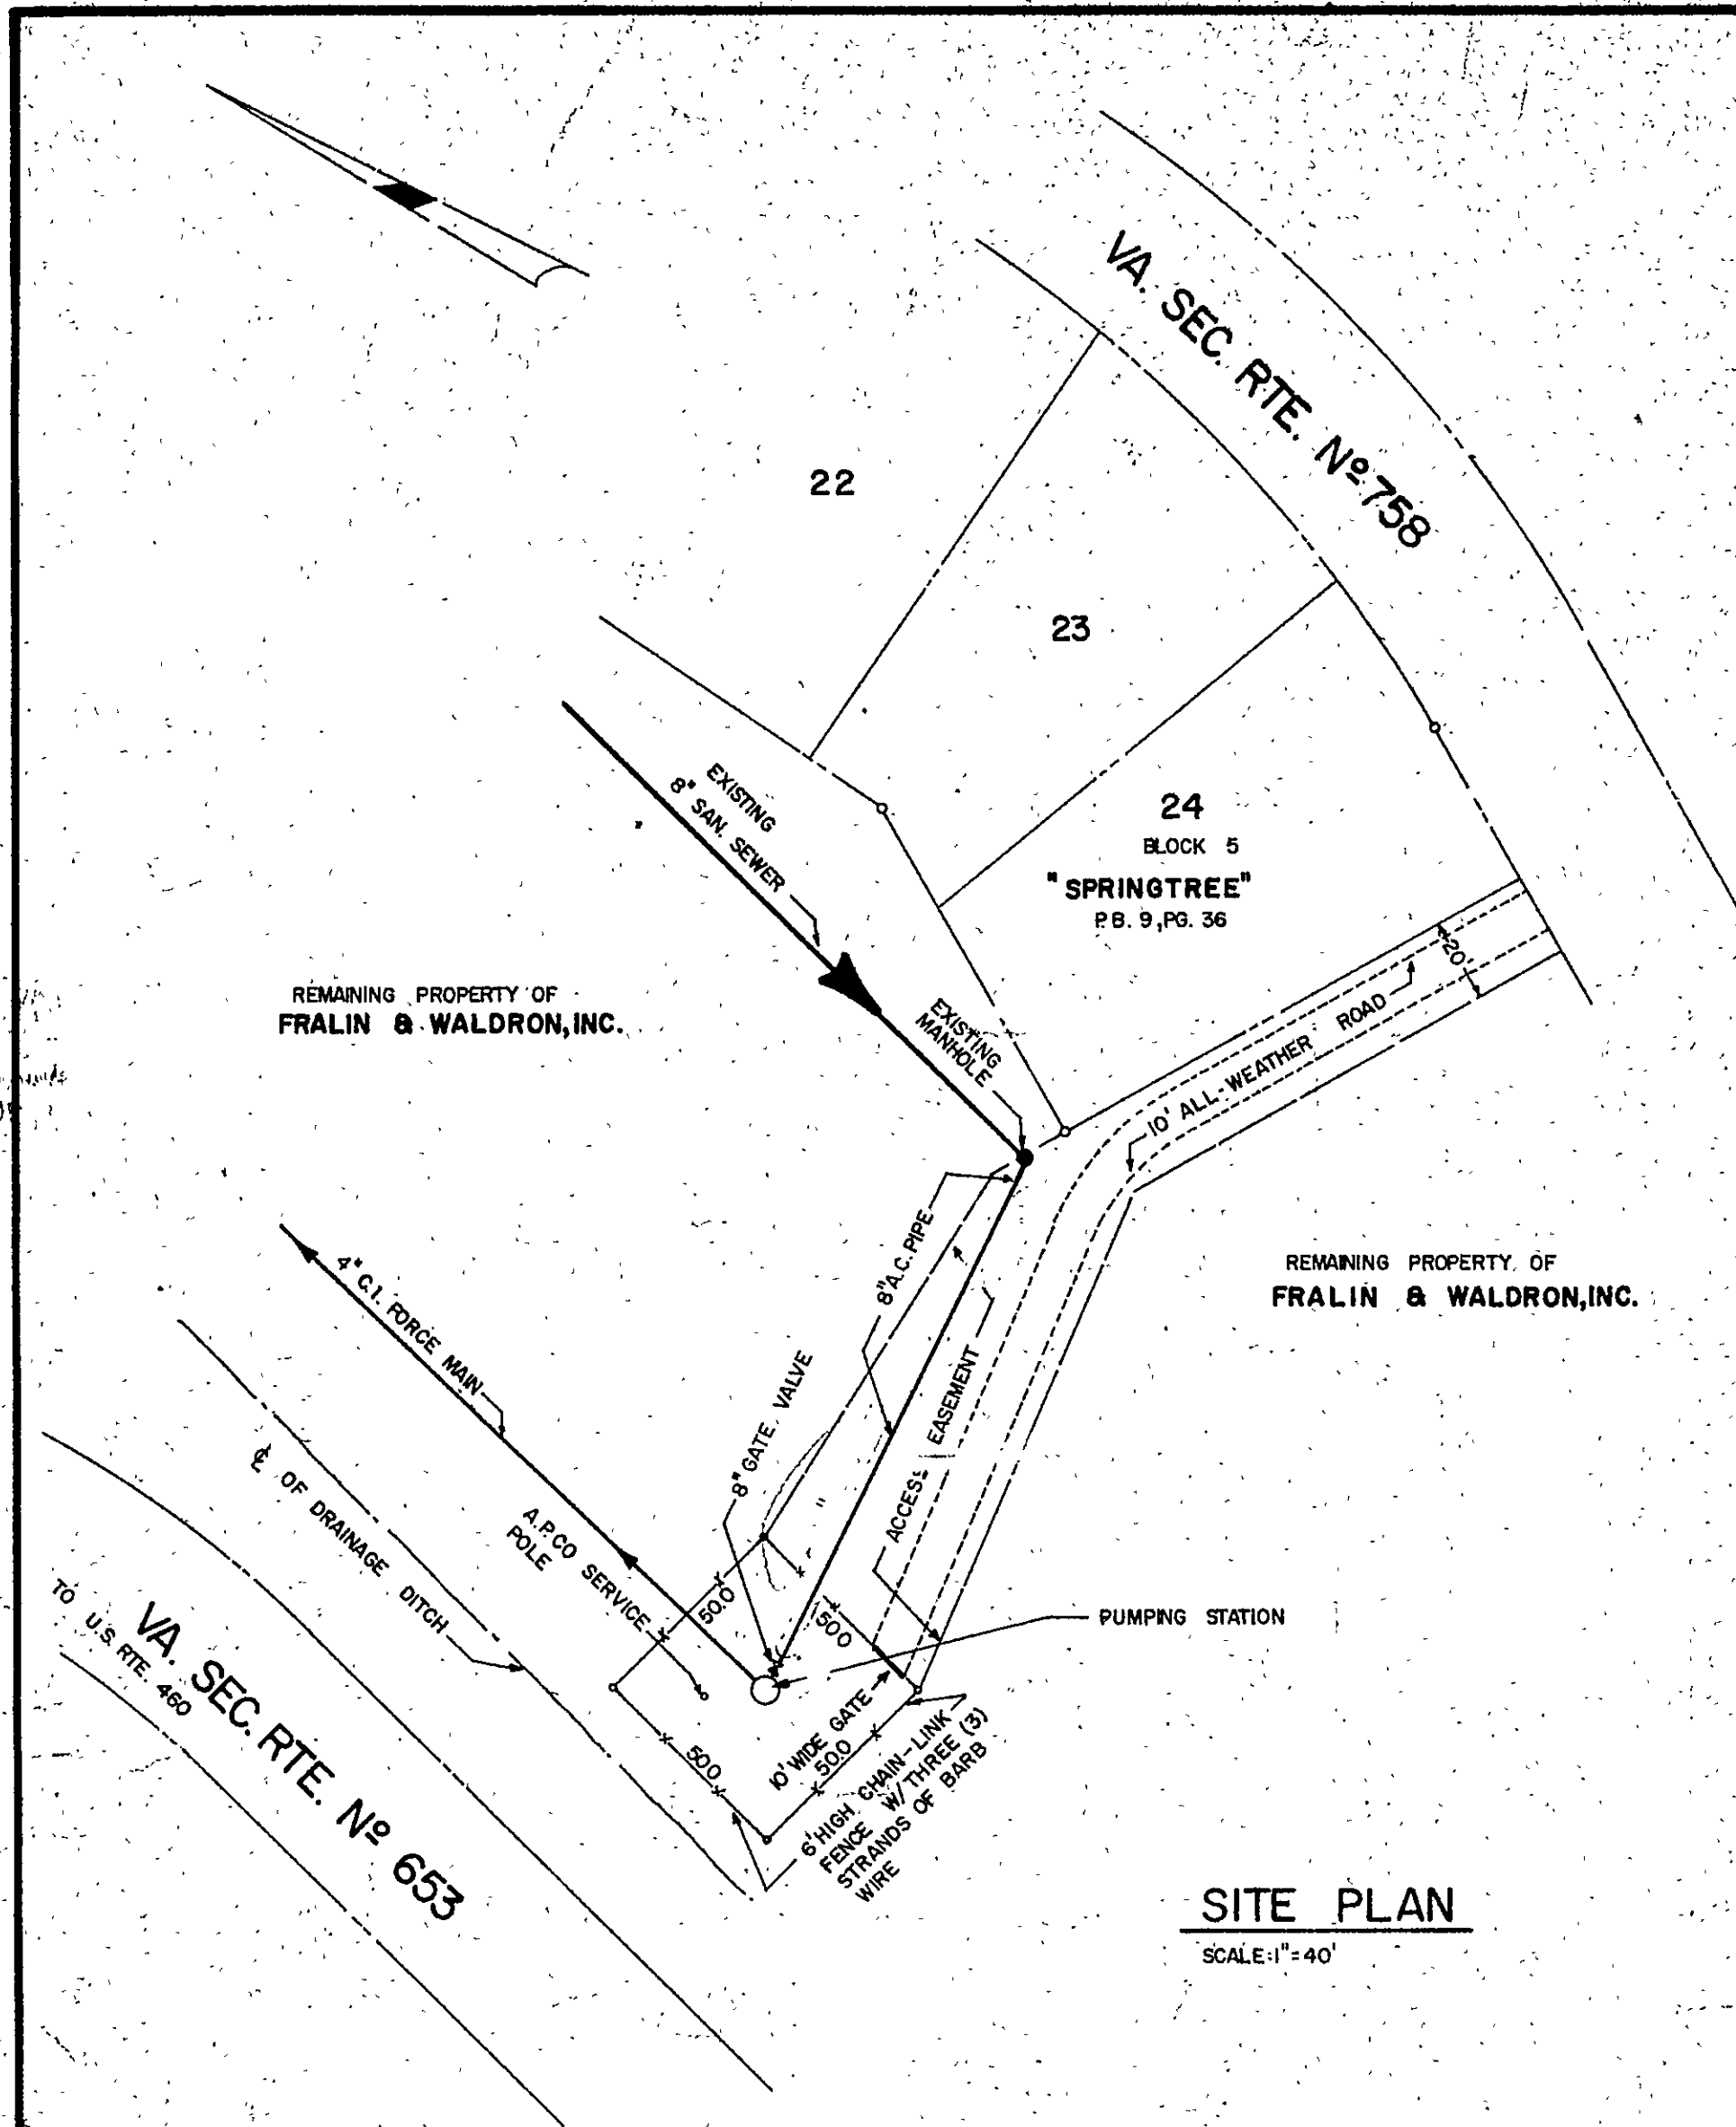


SITE PLAN

SCALE: 1" = 40'


GENERAL REVISION NOTE
 DELETE 12,220 GAL. 7.3 HOUR, 130 FT. OF 48" CONC. PIPE
 HOLDING TANK, TWO SEALED MANHOLES, VENT, AND
 APPURTENANCES.
 REPLACE WITH 148 FT. OF 8" A.C. PIPE AT 3.32%
 GRADE AS SHOWN IN CONJUNCTION WITH "ONAN"
 MODEL NO. 15.0RTG-100, 15 KW, SERIES RTG EMERGENCY
 ELECTRIC GENERATOR, OR AN APPROVED EQUAL

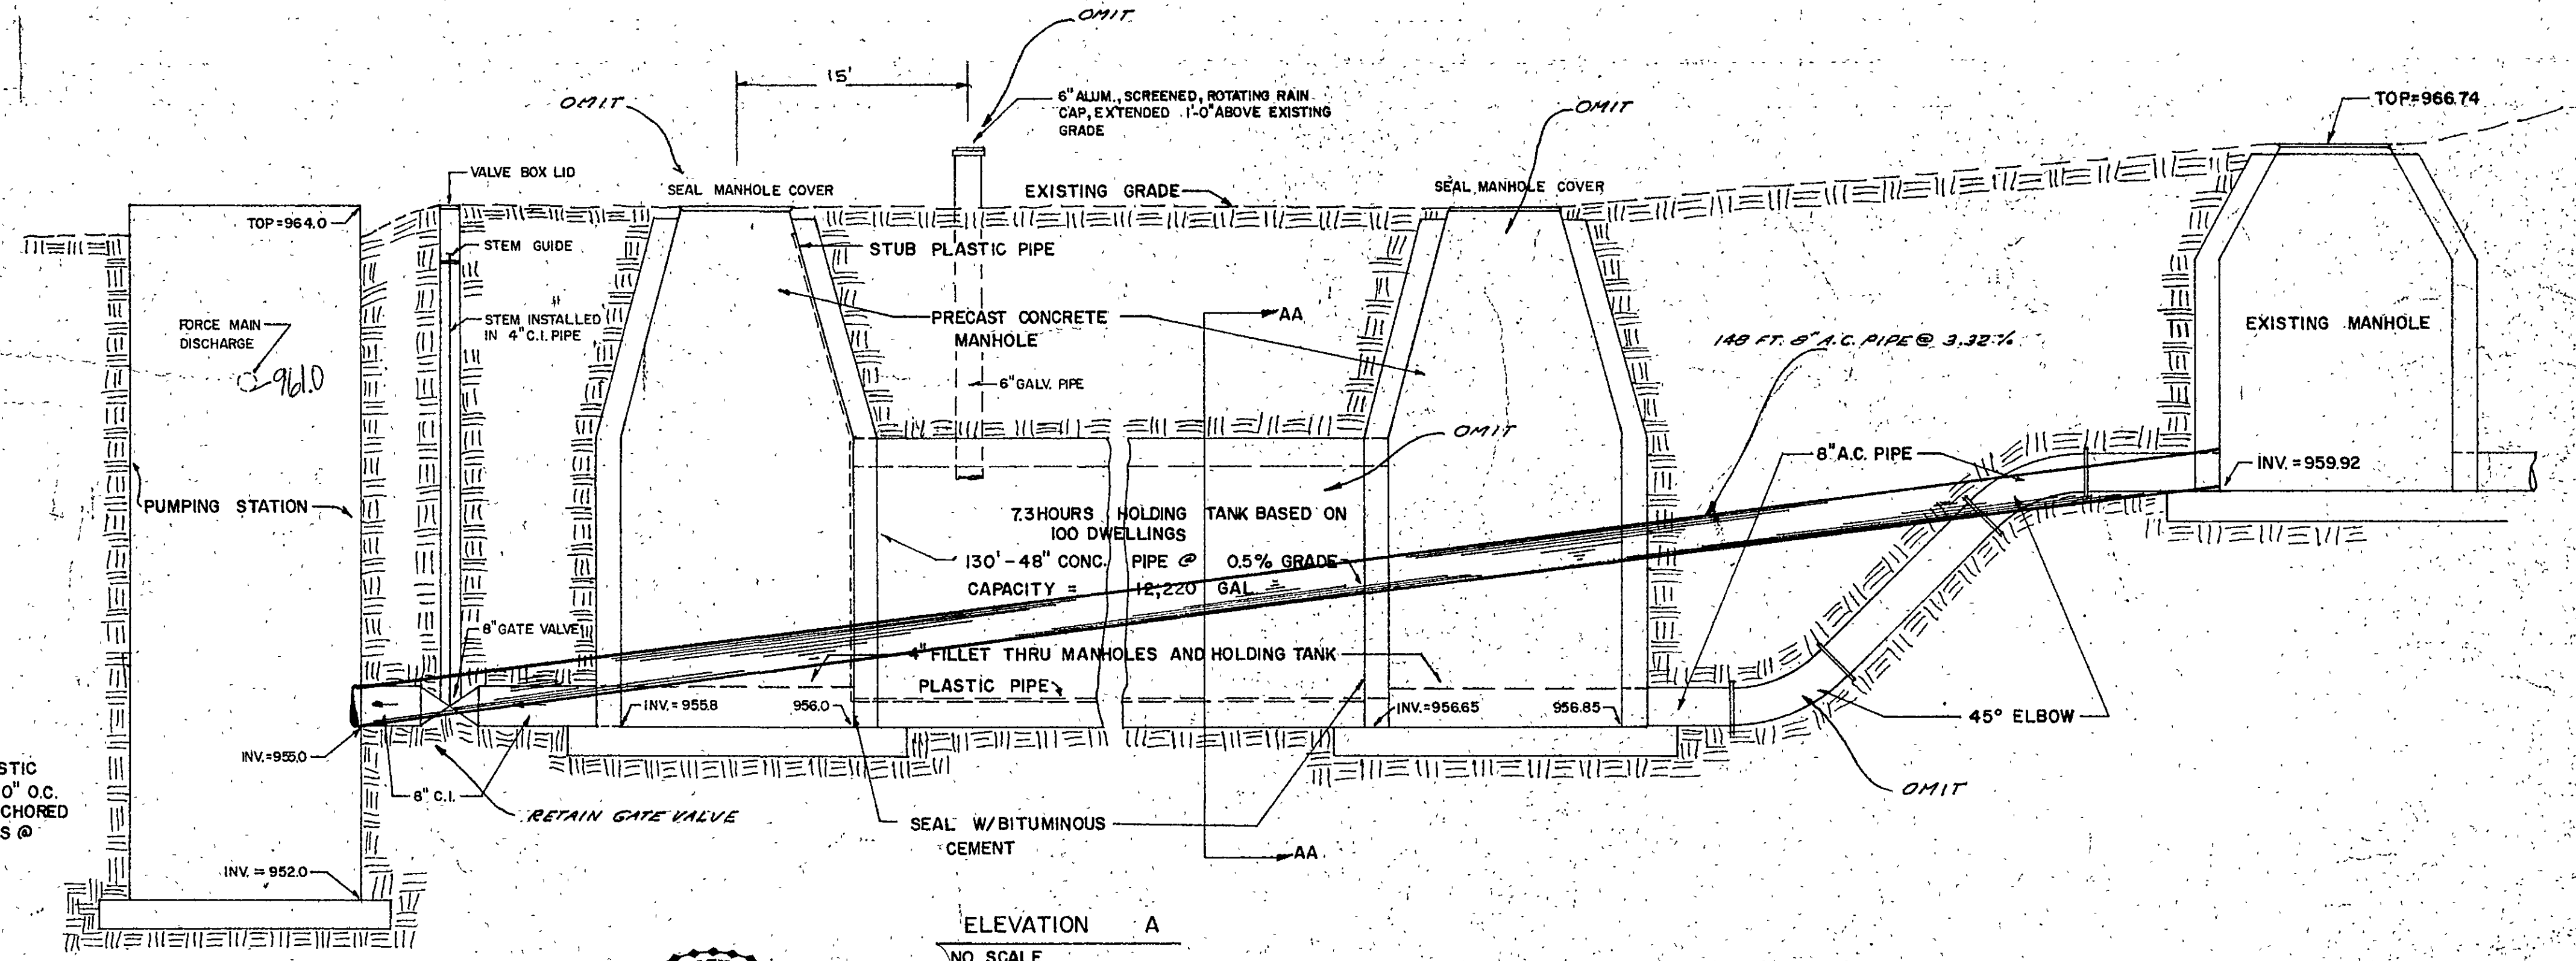

ELEVATION A
 NO SCALE

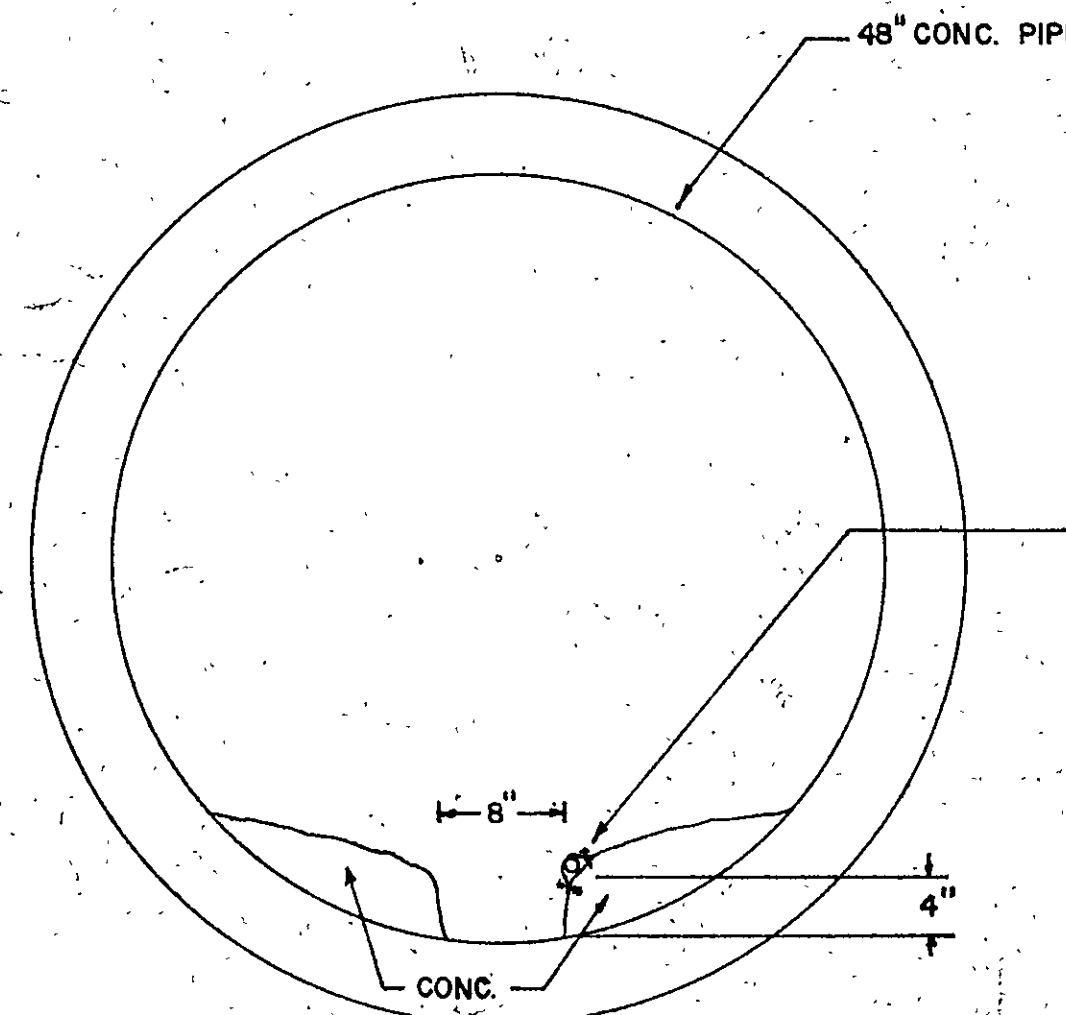

SECTION AA

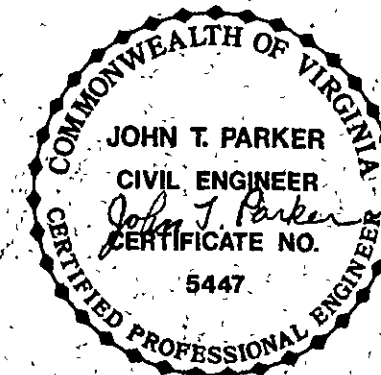

REVISIONS			
DATE	REMARKS	BY	

T. P. PARKER & SON
 engineers & surveyors

TELEPHONE (703) 387-1153
 P.O. BOX 367, SALEM, VIRGINIA, 24153

DETAILS

SHEET 6
OF 6