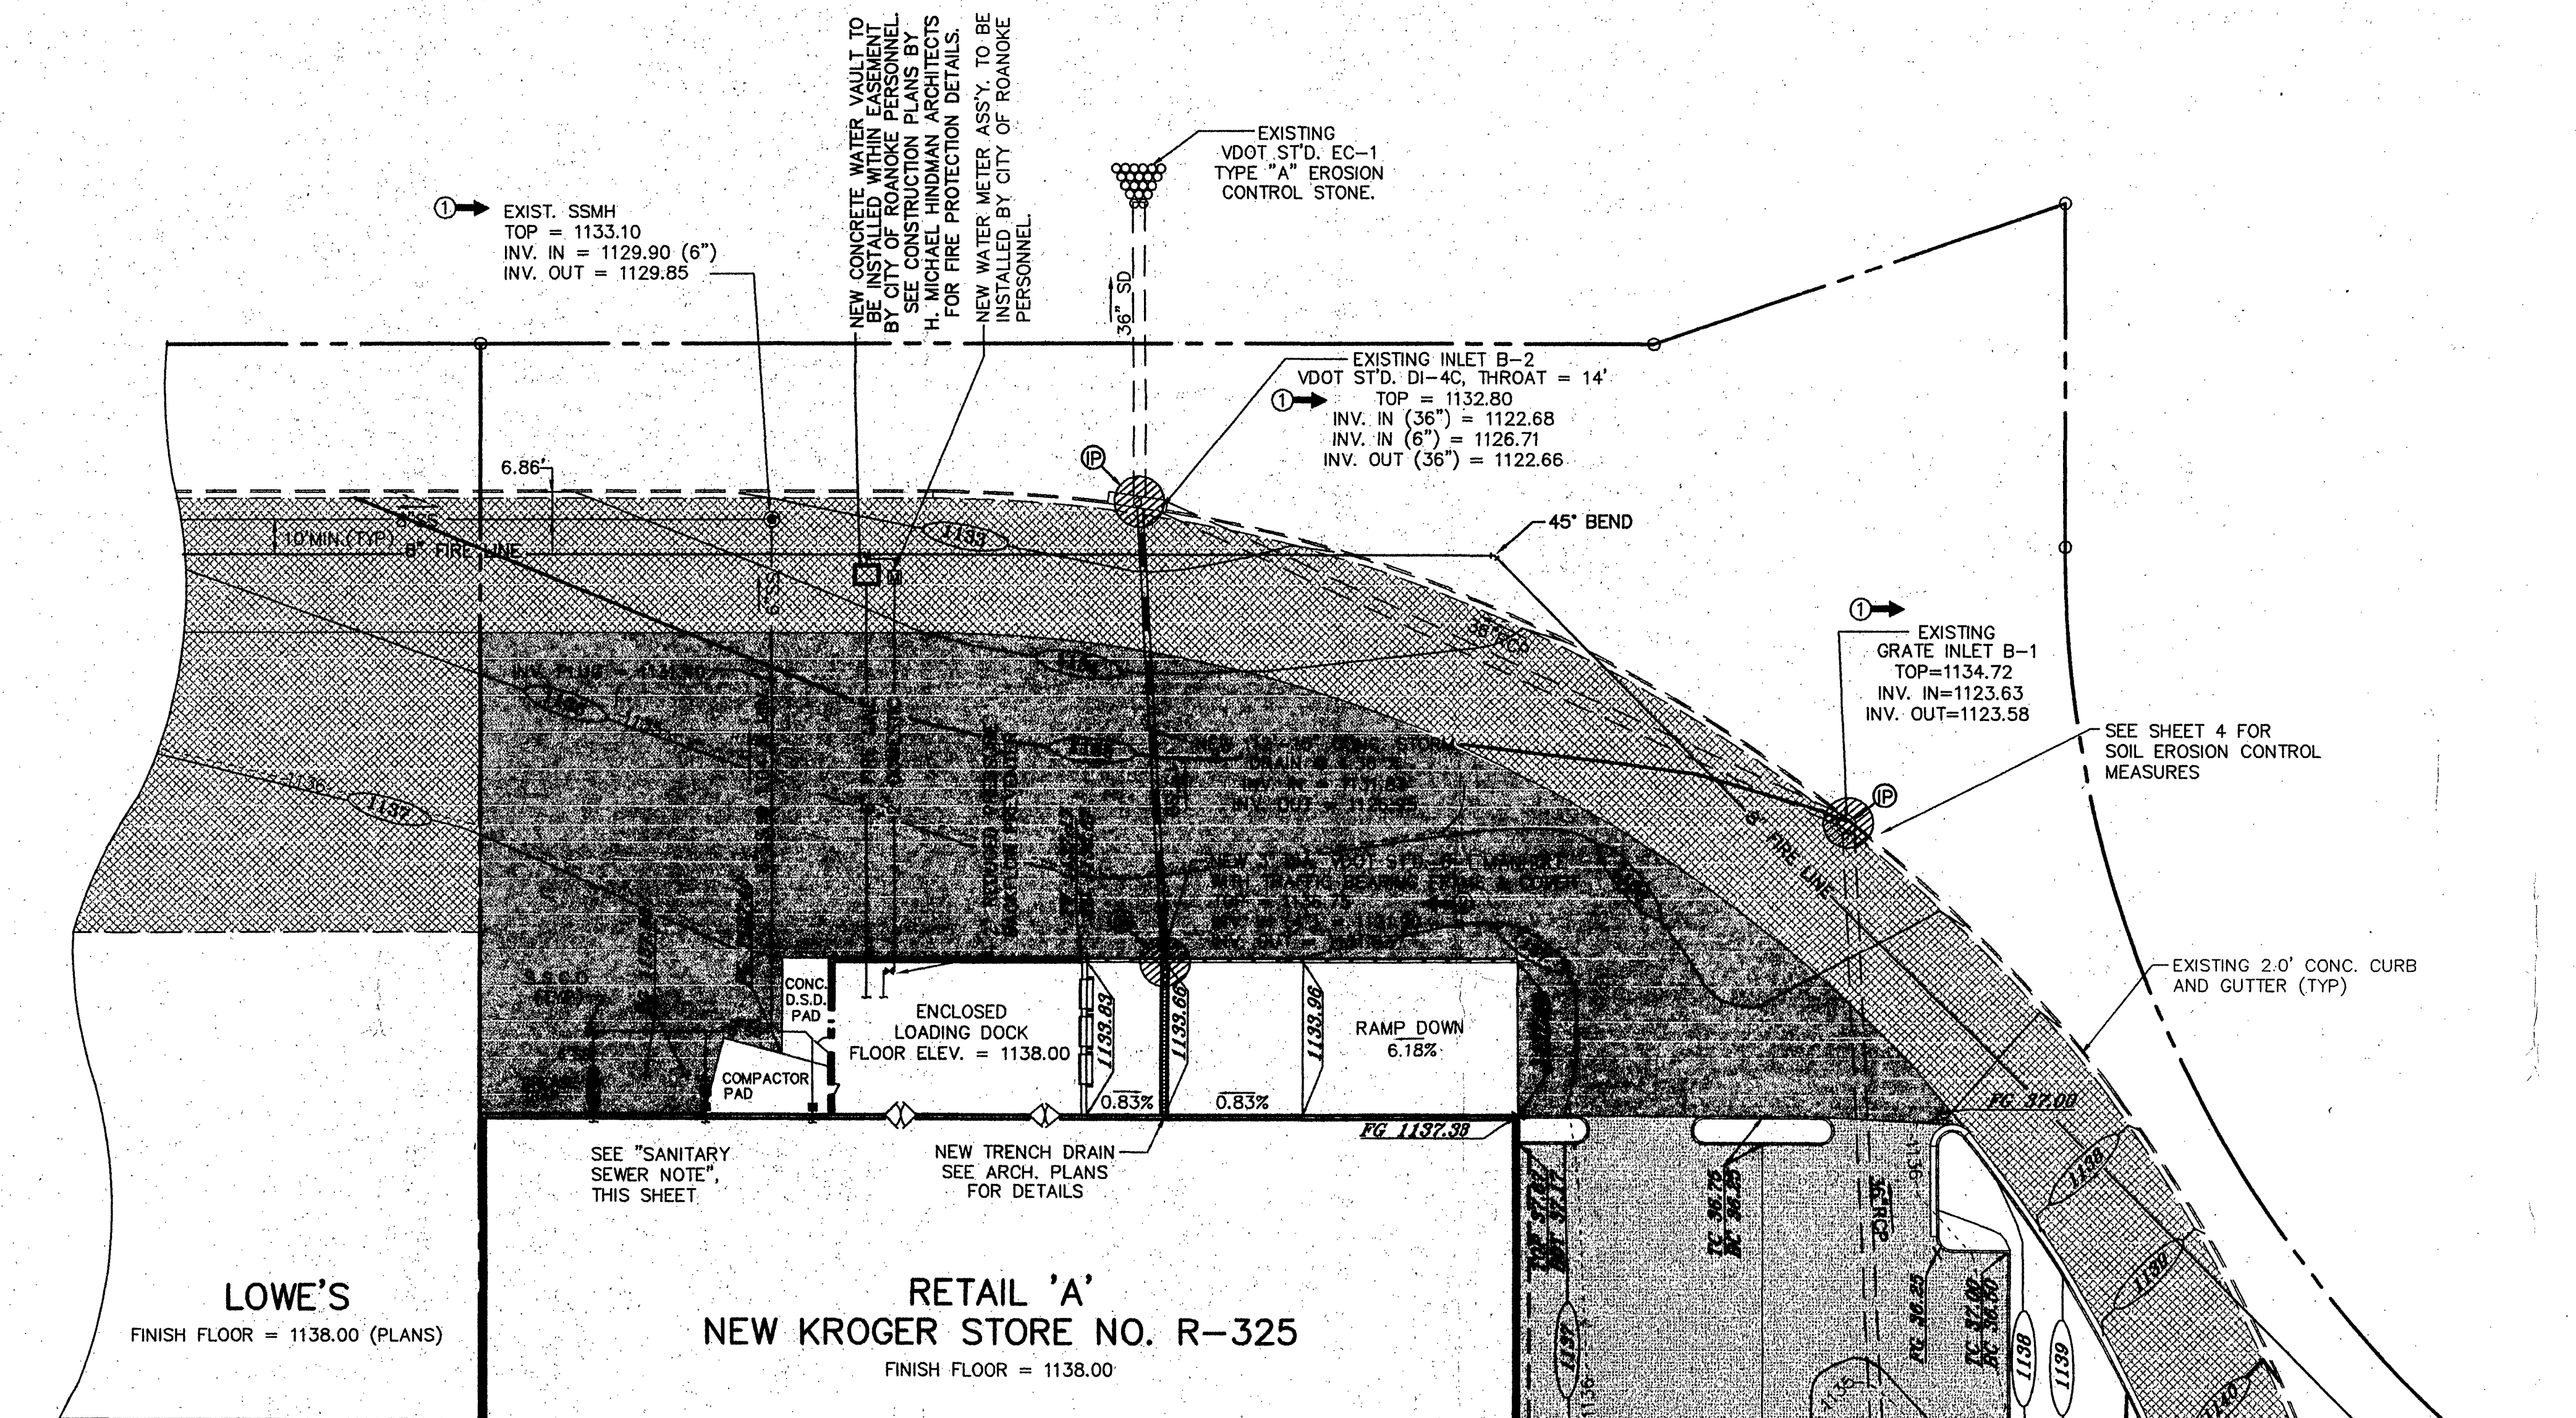
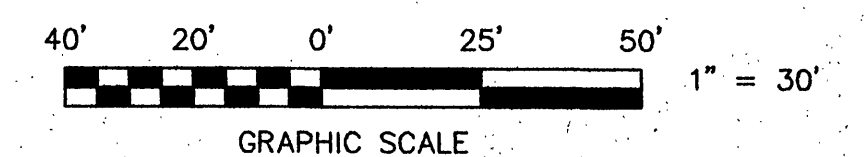


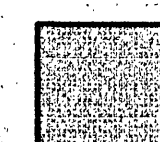
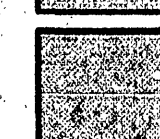
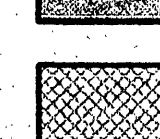


② → SANITARY SEWER NOTES
 ALL NEW 6" SANITARY SEWER SHALL BE CONSTRUCTED IN ACCORDANCE WITH LOCAL BUILDING CODES. LINES SHALL BE SDR-35 PVC PIPE AND SHALL HAVE A MINIMUM SLOPE OF 1.04 %.
 THE GREASE TRAP SHALL BE PRE-CAST AND SHALL HAVE TRAFFIC-BEARING FRAME AND COVERS.
 ALL SANITARY SEWER CLEANOUTS SHALL BE SDR-35 PVC AND SHALL HAVE TRAFFIC-BEARING FRAME AND COVERS.

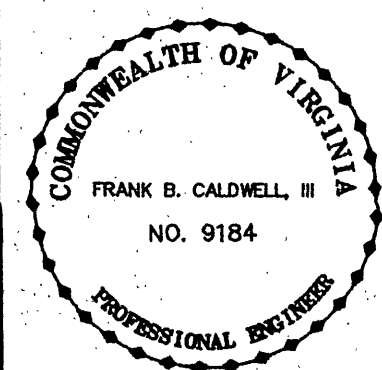
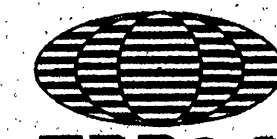
② → FIRE SUPPLY LINE NOTES
 ALL NEW 8" WATERLINE SHALL BE CLASS 50 DUCTILE IRON PIPE OR CITY OF ROANOKE APPROVED EQUAL, AND SHALL BE CONSTRUCTED IN ACCORDANCE WITH LOCAL BUILDING CODES.

BENCHMARK:
 CHISELED "□" ON TOP OF CURB INLET IN TOWNE SQUARE BOULEVARD.
 ELEVATION = 1142.75
 DATUM PER CITY OF ROANOKE STATION NO. 24, "MEMORIAL".



-  STANDARD PAVEMENT BY KROGER - SEE DETAIL, SHEET 4
-  HEAVY-DUTY PAVEMENT BY KROGER - SEE DETAIL, SHEET 4
-  HEAVY-DUTY PAVEMENT BY LOWE'S - SEE DETAIL, SHEET 4

② → REVISED 10-25-93 PER CITY OF ROANOKE REVIEW - CLW
 ① → RE-ISSUED FOR BID 9/20/93 - CLW

	GRADING, UTILITIES, AND EROSION CONTROL PLAN - WEST FOR THE KROGER COMPANY SITUATE TOWNE SQUARE SHOPPING CENTER HERSHBERGER ROAD CITY OF ROANOKE, VIRGINIA		
	SCALE: 1" = 30' DATE: SEPTEMBER 14, 1993		
	DESIGNED BY <u>C.L. WHITE</u> DRAWN BY <u>C.L. WHITE</u> CHECKED BY _____ W.O. # <u>93-1022</u> N.B. <u>JW-24</u> TAX NO. <u>665-0101</u>	 T. P. PARKER & SON 816 Boulevard Post Office Box 39 Salem, Virginia 24183 Telephone: 703-387-1153 FAX: 703-389-6767	
	TPP&S ENGINEERS SURVEYORS PLANNERS		