



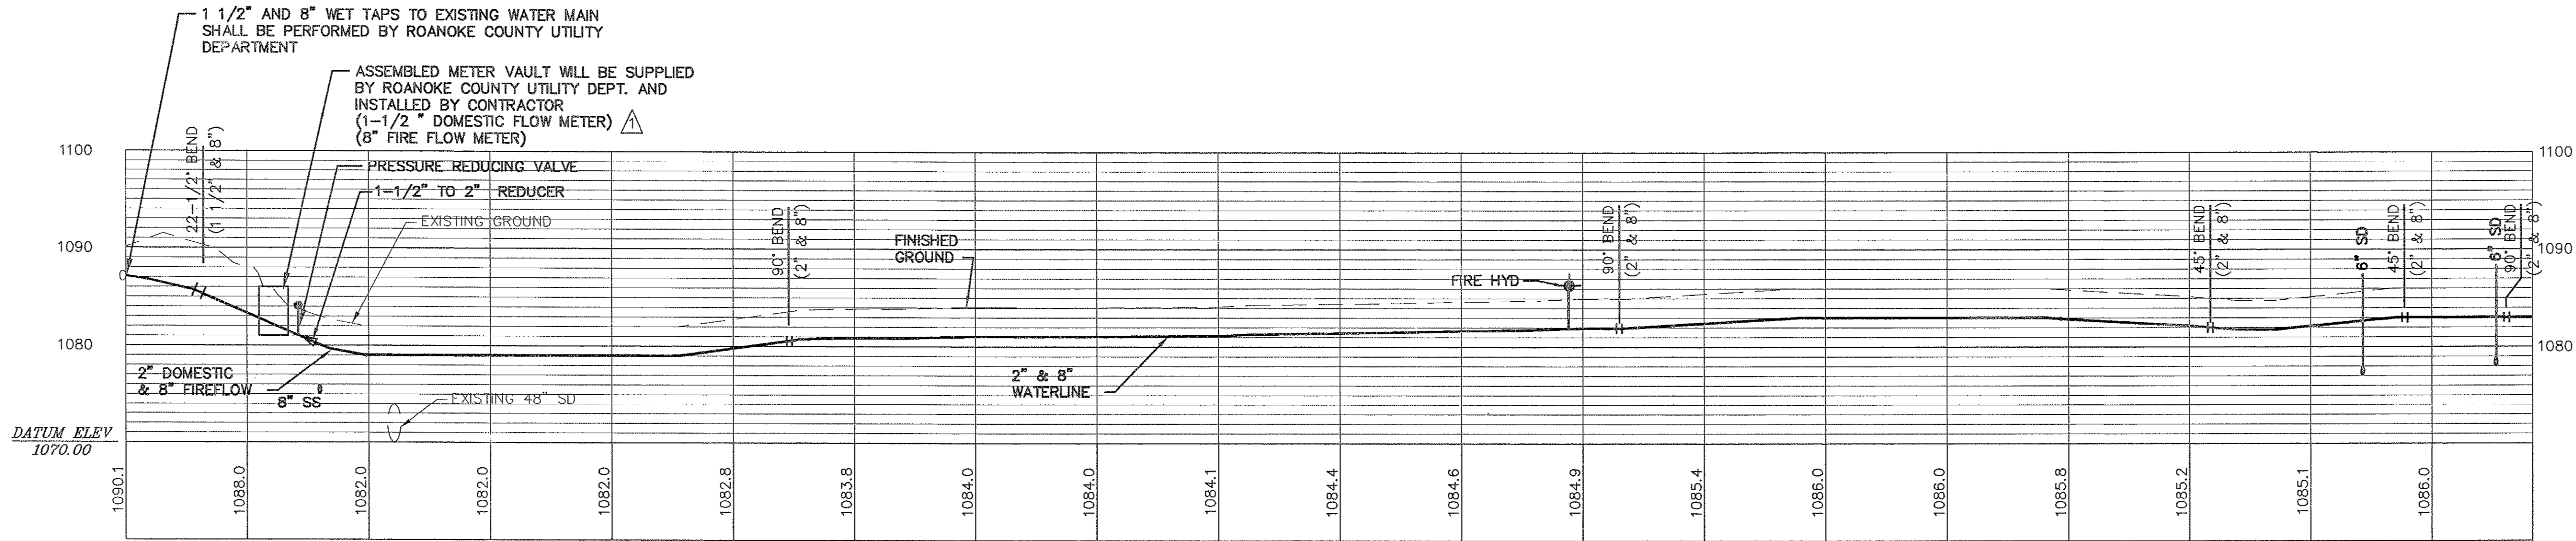


WL-100 PROFILE
SCALE: 1" = 40' HORIZONTAL
1" = 10' VERTICAL

NOTE:
THE CONTRACTOR SHALL
MAINTAIN A MINIMUM OF
3' OF COVER OVER THE
PIPE CROWN.

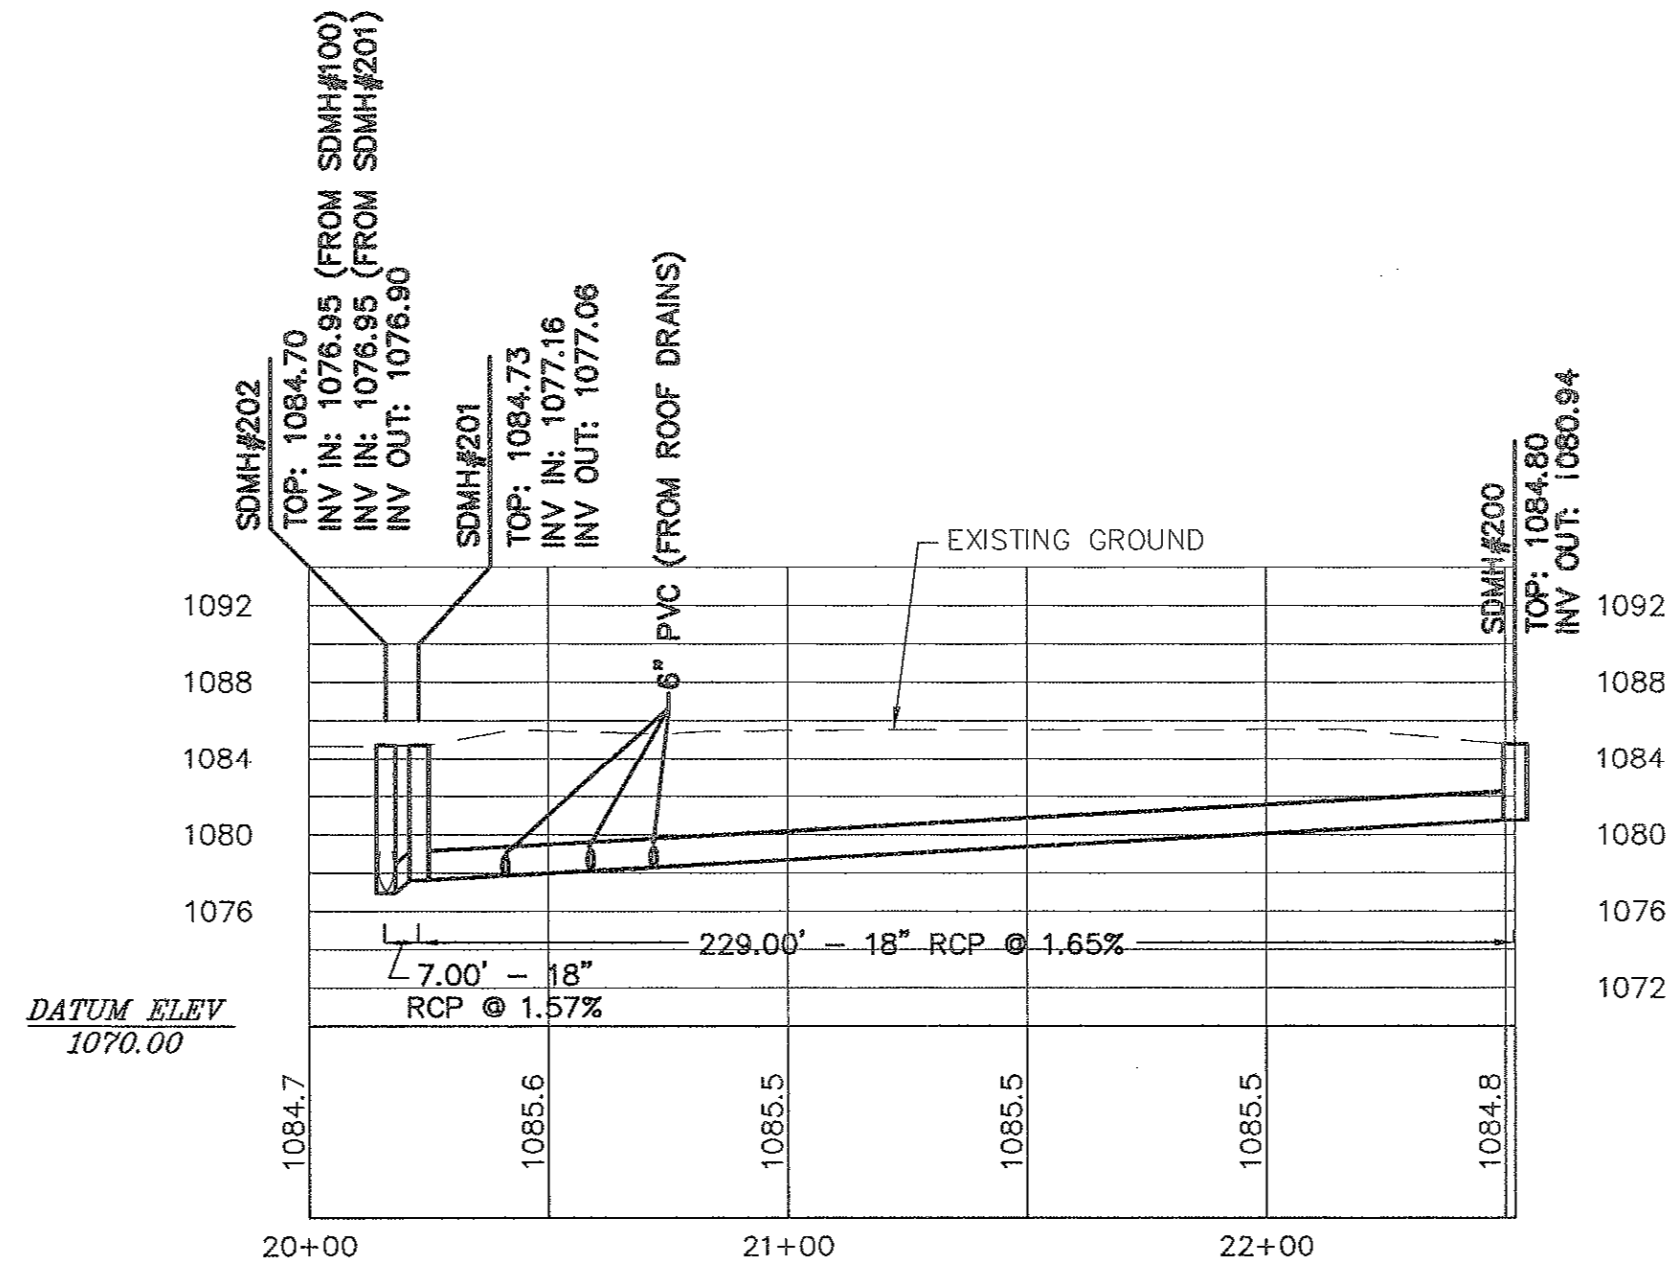

SD-200 PROFILE
SCALE: 1" = 40' HORIZONTAL
1" = 10' VERTICAL

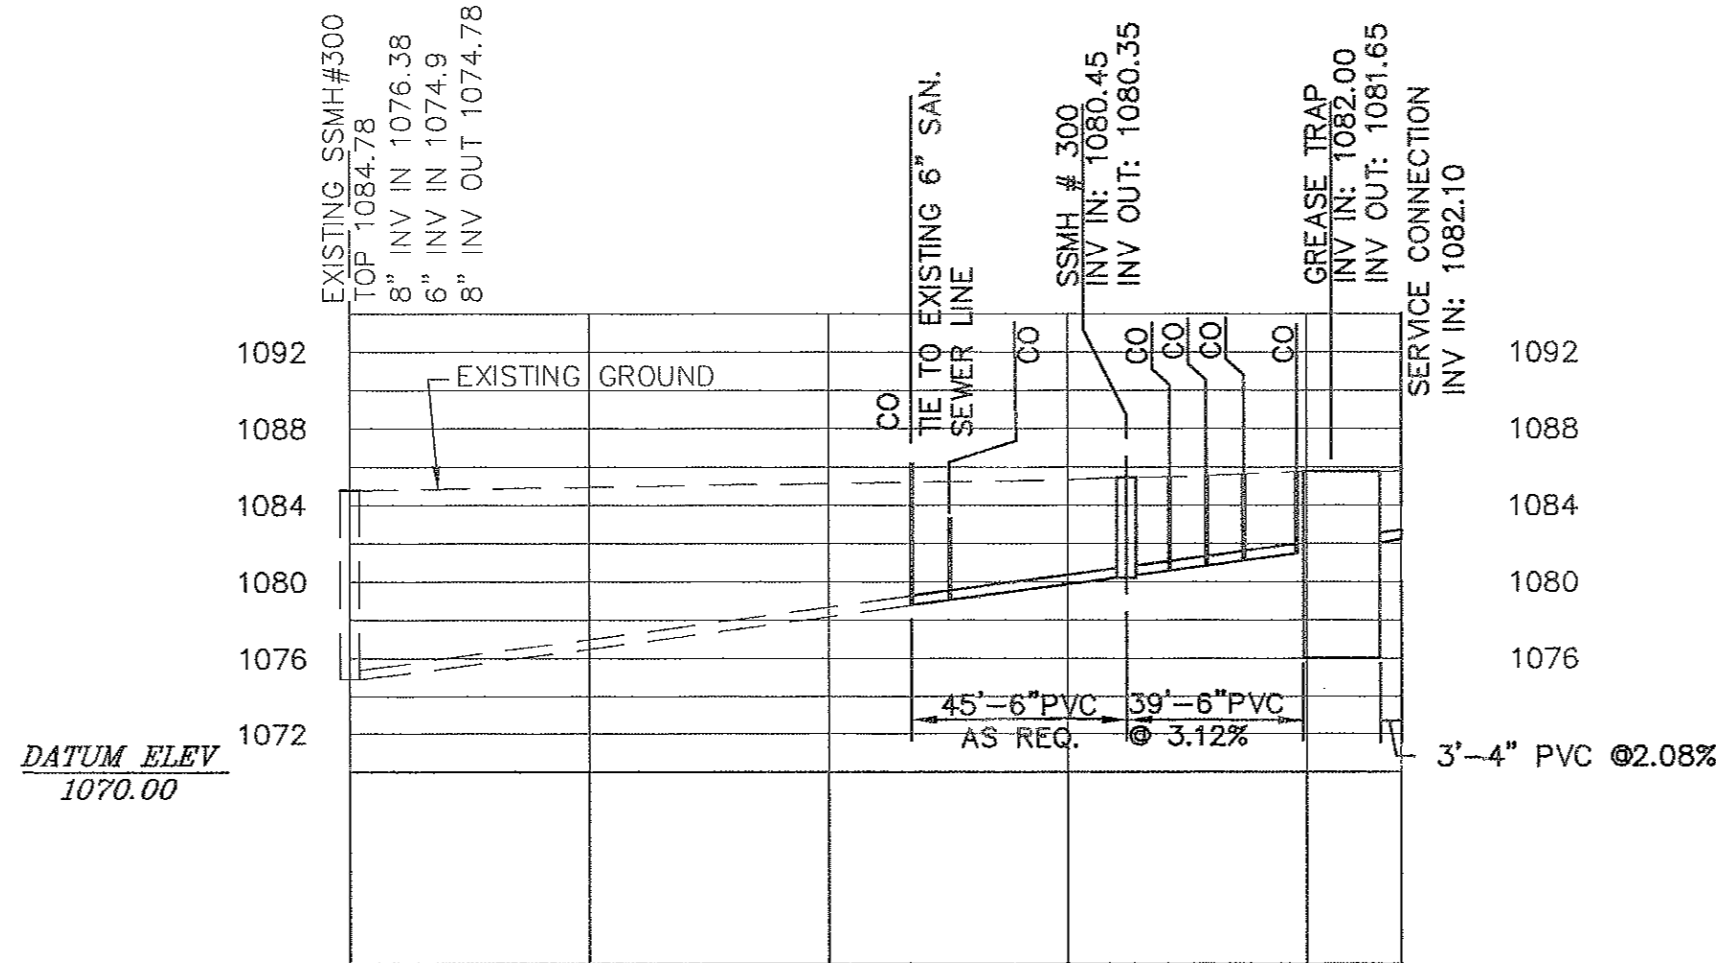


SS-300 PROFILE
SCALE: 1" = 40' HORIZONTAL
1" = 10' VERTICAL

NOTES:
1. CONTRACTOR SHALL FIELD LOCATE EXISTING SANITARY
SEWER IN THE AREA OF SS-300, VERIFY FIELD
CONDITIONS AND NOTIFY ENGINEER.
2. NEW 4" SERVICES SHALL INCLUDE CONNECTING
EXISTING LATERAL TO NEW SANITARY SEWER SS-300.

KROGER STORE R-375
SITE PLAN
ROANOKE COUNTY, VIRGINIA

NO.	DATE	DESCRIPTION	KER	BY
11-25-03		ROANOKE COUNTY COMMENTS	KER	BY

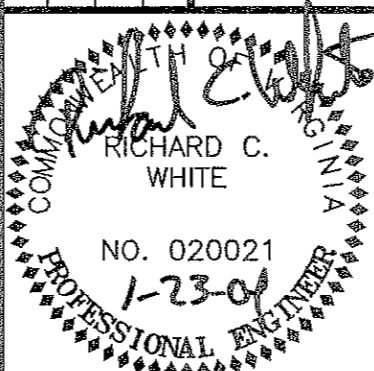

Designed By	KER
Drawn By	KER
Checked By	RCW
Approved By	RCW
Submitted By	RCW
Drawing	2303C_SITE
Date	07/07/03
Scale	1" = 40'
Commission No.	2303C
Sheet	6 of 11

LMW P.C.
ENGINEERING - ARCHITECTURE - SURVEYING
102 ALBEMARLE AVE., S.E.
ROANOKE, VIRGINIA 24013
(540) 945-0675
FAX (540) 942-4456