

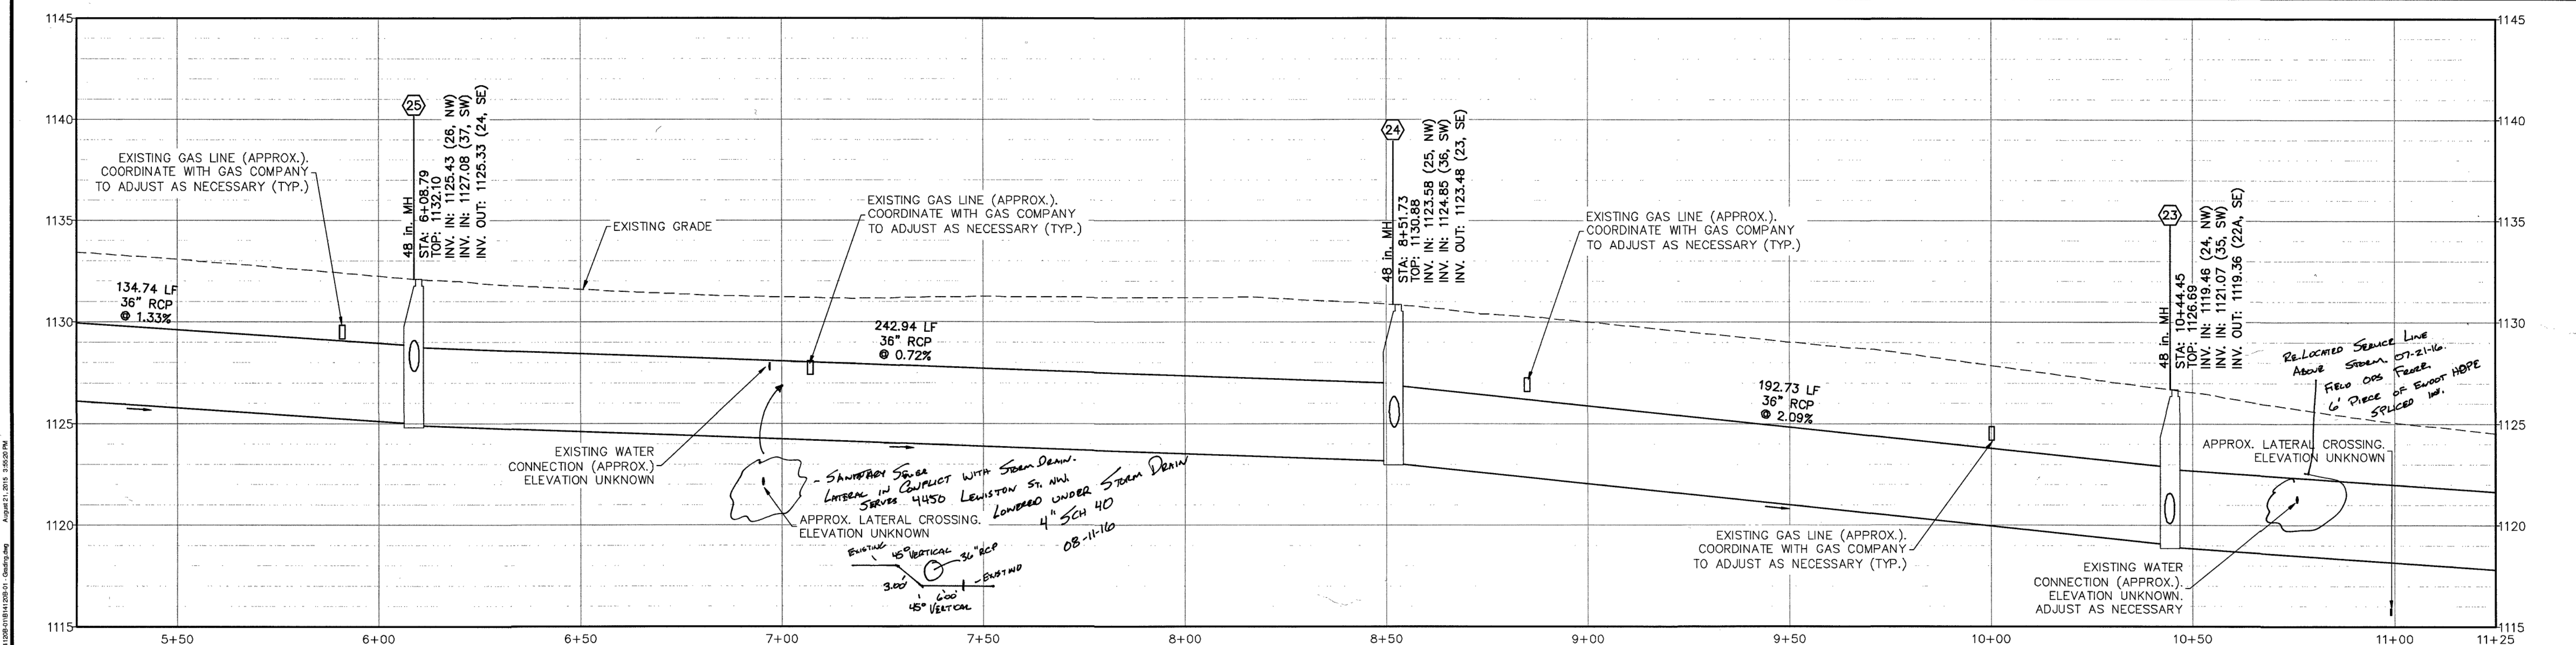


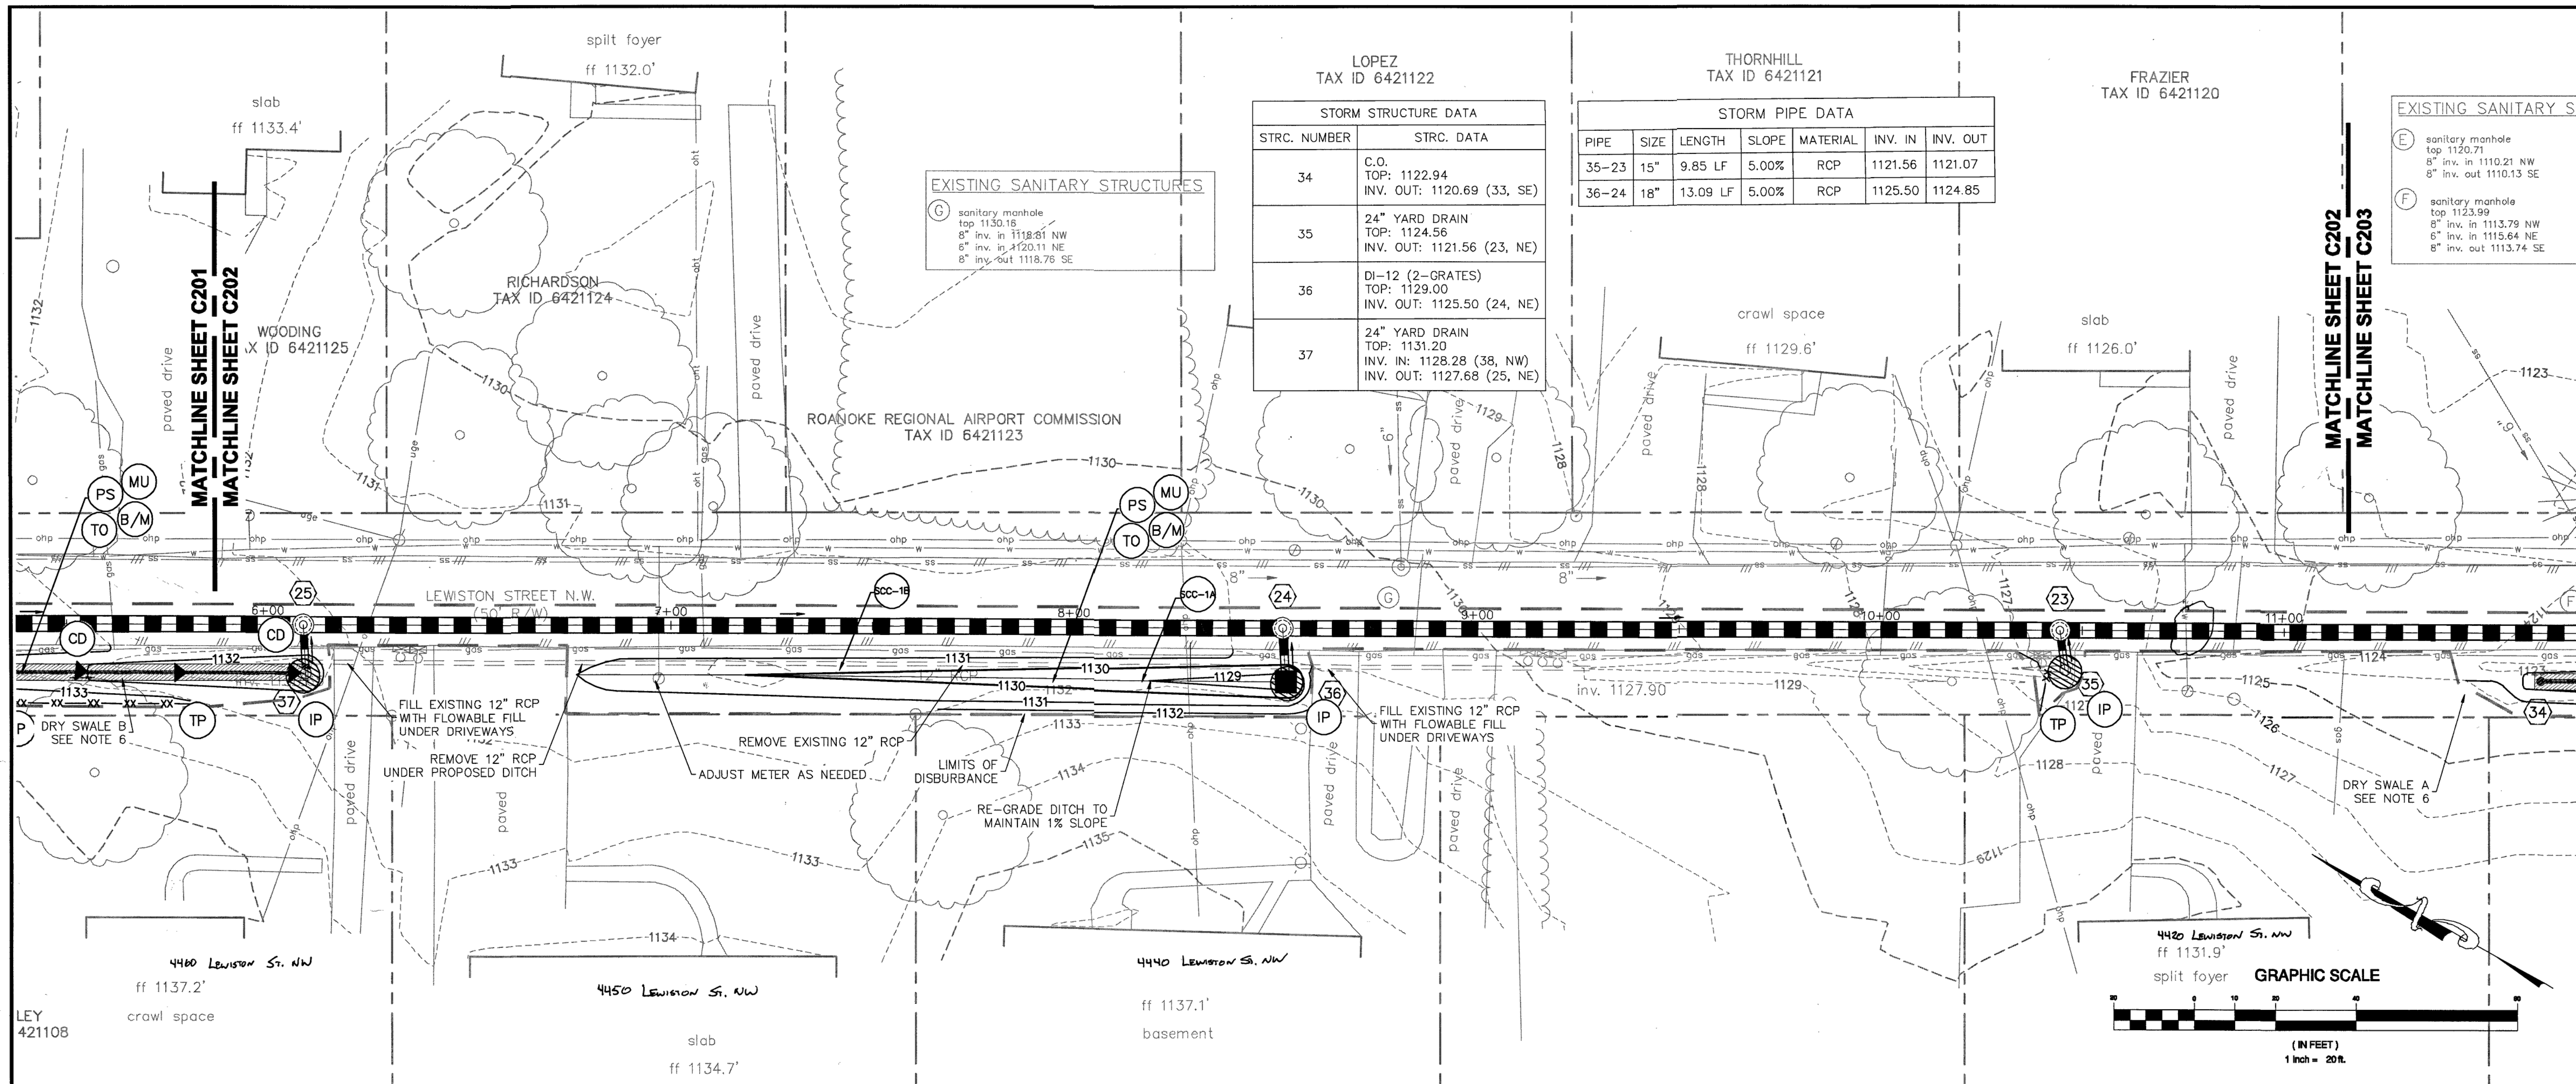

PROPOSED STORM (STA. 5+25 TO 10+50) - Scale: H: 1"=20', V: 1"=4'

NOTE:

1. WORK IS TO BE PERFORMED PER THE CITY OF ROANOKE RIGHT OF WAY EXCAVATION AND RESTORATION STANDARDS.
2. COORDINATE RELOCATION OF GAS LINE WITH GAS UTILITY COMPANY.
3. COORDINATE RELOCATION OF WATER AND SEWER LINES WITH THE WESTERN VIRGINIA WATER AUTHORITY.
4. WHERE WATER METER RELOCATION IS REQUIRED, THE EXISTING METER IS TO BE REUSED.
5. CHECK DAMS SHOWN ON THE PLANS ARE TO BE PERMANENT WATER QUALITY CHECK DAMS AND ARE TO FOLLOW MINIMUM STANDARD 3.13 OF THE VIRGINIA BMP CLEARINGHOUSE.
6. DRY SWALES ARE TO BE CONSTRUCTED AFTER ALL UPSLOPE AREAS HAVE BEEN FULLY STABILIZED.

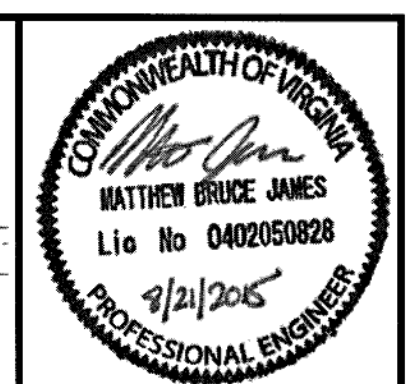

Draper Aden Associates
Engineering • Surveying • Environmental Services
Blackburg, VA
2206 South Main Street
Blackburg, VA 24060
540-552-0444 Fax: 540-552-0291
www.daa.com

Richmond, VA
Charlottesville, VA
Hampton Roads, VA

SITE & GRADING PLAN
LAUREL RIDGE RD / LEWISTON ST
DRAINAGE IMPROVEMENTS
ROANOKE, VIRGINIA

REVISIONS	
DESIGNED BY:	MBJ
DRAWN BY:	AJH
CHECKED BY:	LBL
SCALE:	1" = 20'
DATE:	AUGUST 21, 2015
PROJECT NUMBER:	B14120B-01
C202	