


NOTES:

1. NEW SERVICES SHALL TIE TO THE EXISTING SERVICES AT THE FACE OF THE BUILDING.

2. PROVIDE A TEMPORARY CONNECTION BETWEEN THE NEW AND EXISTING SYSTEMS TO PROVIDE WATER FOR TESTING, DISINFECTION AND FLUSHING.

3. CONNECT THE NEW LINE TO THE EXISTING MASTER METER AFTER THE NEW LINE IS APPROVED AND IN SERVICE.

4. CONNECTIONS INDICATED ①, ②, & ③, TO EXISTING CITY OF ROANOKE WATER MAINS SHALL BE DONE BY CITY OF ROANOKE. CONTRACTOR SHALL COORDINATE, APPLY FOR AND PAY ALL ASSOCIATED FEES.

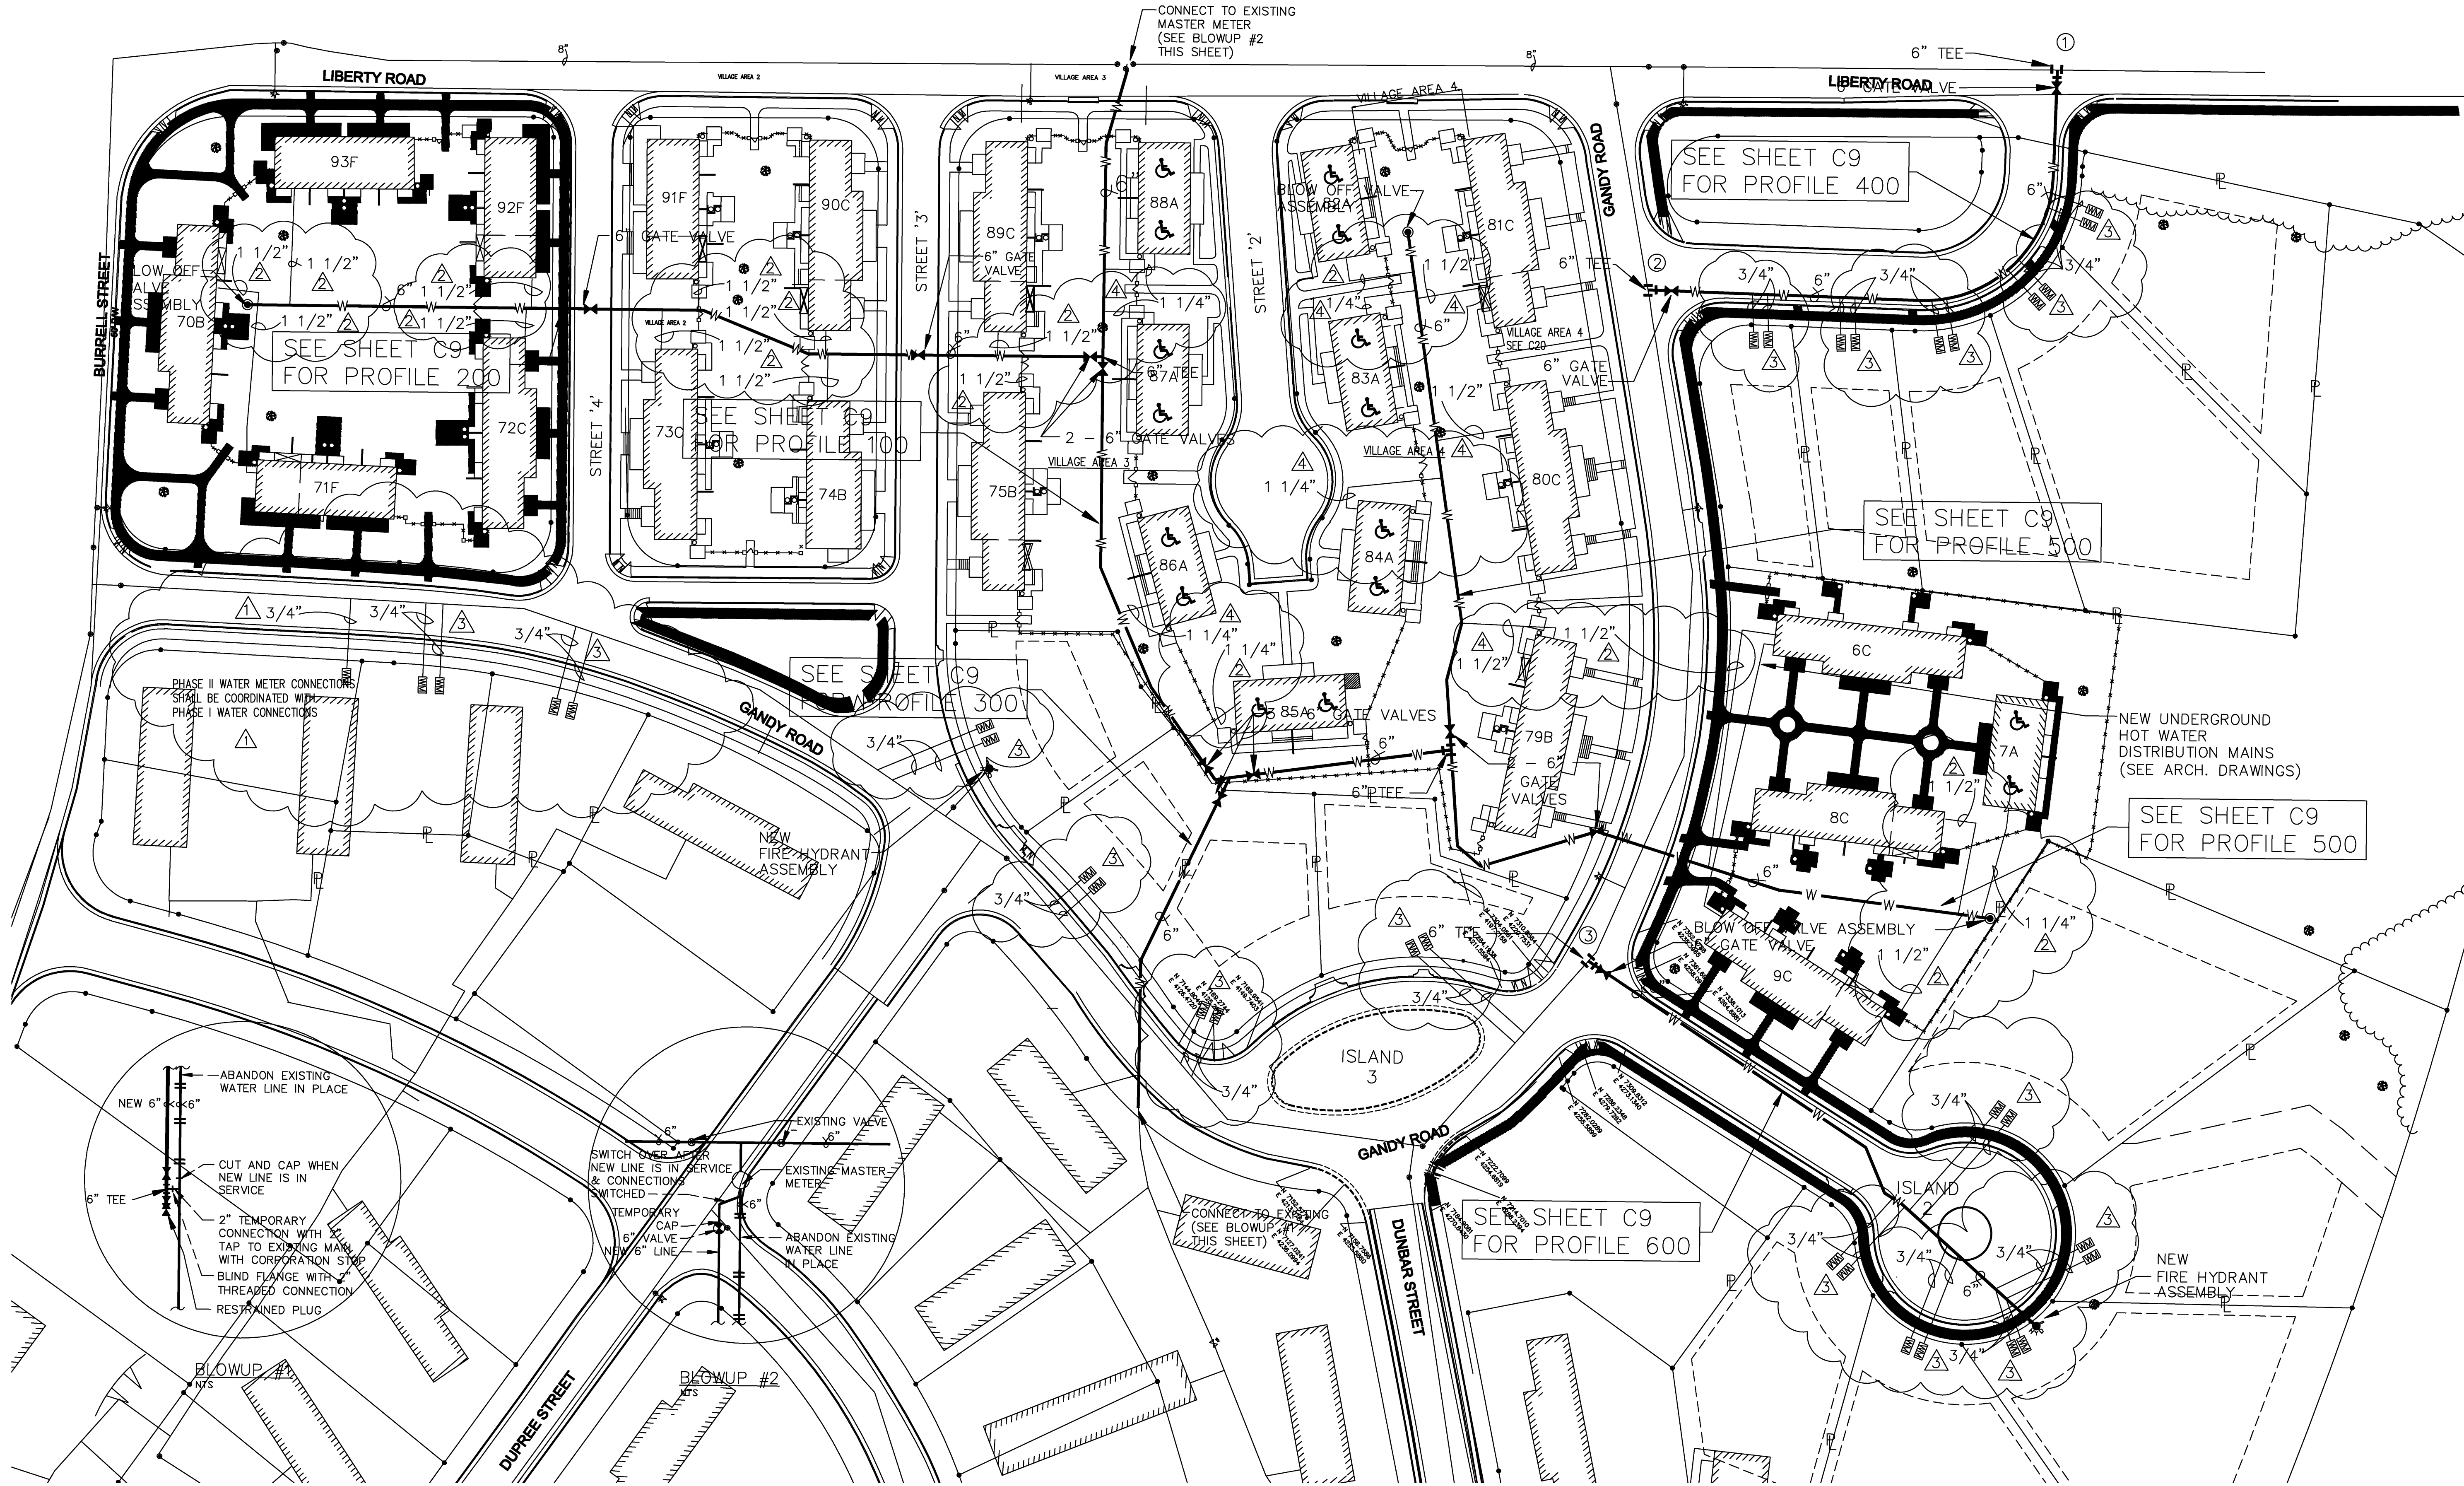

MarshWitt


MarshWitt Associates, P.C.

Architecture
Planning
Value Analysis

315 King George Ave. SW
Roanoke, VA 24016
Phone: 540 982 1444
Fax: 540 982 8300
email: marshwitt@rev.net


CONSULTANTS:

LMW P.C.
ENGINEERING
(540) 345-0875 102 ALBEMARLE AVE., S.E.
FAX (540) 342-4456 ROANOKE, VIRGINIA 24013

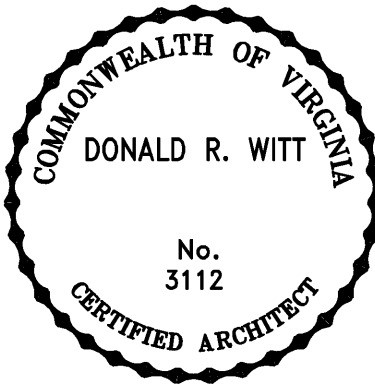

LINCOLN 2000

ROANOKE, VIRGINIA

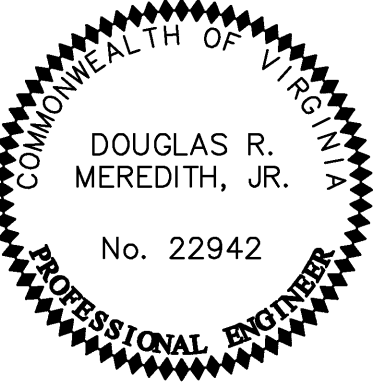

PHASE ONE

COMM. NO: 9825A

DESIGNED BY: DME

DRAWN BY: DJB

CHECKED BY: DRM

PLOT SCALE: 1:40

COPYRIGHT
MARSHWITT ASSOCIATES P.C. 1999

Δ	05-18-01	WATER LATERAL REVISIONS
3	03-29-01	WATER REVISIONS
2	03-13-01	WATER REVISIONS
1	12-11-00	WATER REVISIONS
MK	DATE	DESCRIPTION

SHEET TITLE:

SITE PLAN /
WATER

C8

SHEET 8 OF 24

