


Issue Date: May 2005

 Matten & Craig
CONSULTING ENGINEERS • SURVEYORS
701 FIRST STREET, S.W.
ROANOKE, VIRGINIA 24016
(540) 345-9342
FAX (540) 345-7691

SANITARY SEWER PROJECT
LINDENWOOD SEWER
PLAN AND PROFILE -
8" SANITARY SEWER
TOWN OF VINTON, VIRGINIA

Vertical Scale: 1" = 10'	Horizontal Scale: 1" = 30'	Commission Number: 1955-L	Sheet No. 8
-----------------------------	-------------------------------	------------------------------	----------------

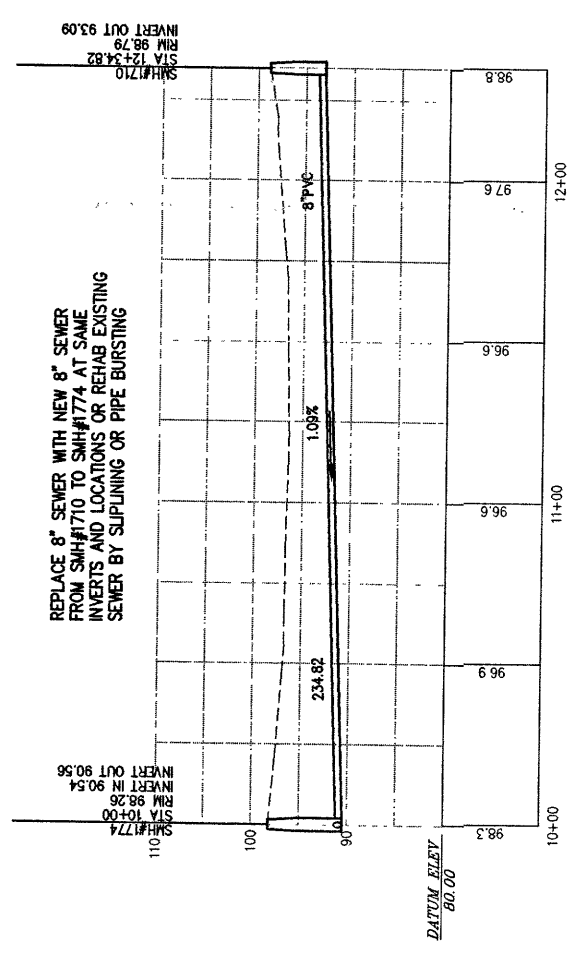

SS 1774-1710